



CIVIL AVIATION AUTHORITY OF THE PHILIPPINES

THIS DRAWING IS THE PROPERTY OF THE CIVIL AVIATION AUTHORITY OF THE PHILIPPINES AND MUST NOT BE REPRODUCED, COPIED, EITHERED, LOANED AND/OR CURED IN ANY MANNER WITHOUT THE WRITTEN CONSENT FROM THE DIRECTOR GENERAL CAMP.

AERODROME DEVELOPMENT AND MANAGEMENT SERVICE
AREA-V, LEGAZPI AIRPORT

ENGINEERING & PLANNING UNIT

PREPARED BY:

[Signature]
LIMUEY MARI T. MALORCA
AIRPORT TECHNICAL ASSISTANT
CAMP AREA V, LEGAZPI AIRPORT

CHECKED BY:

[Signature]
MARIA AI-AYE SOLEDAD I. REGINALES
AERODROME ENGINEER
CAMP AREA V, LEGAZPI AIRPORT

APPROVAL RECOMMENDED BY:

[Signature]
ANDREW N. ARELLANO
DEPT. IN CHARGE
CAMP AREA V, LEGAZPI AIRPORT

APPROVED BY:

[Signature]
CYNTHIA W. TUMANOUT
AREA/AIRPORT MANAGER
CAMP AREA V

PROJECT:

REHAB OF ARFF BLDG.

LOCATION:


MASBATE AIRPORT
MASBATE CITY

CONFIDENTIAL


* DETAIL OF LADDER

SHEET NO:


04
04

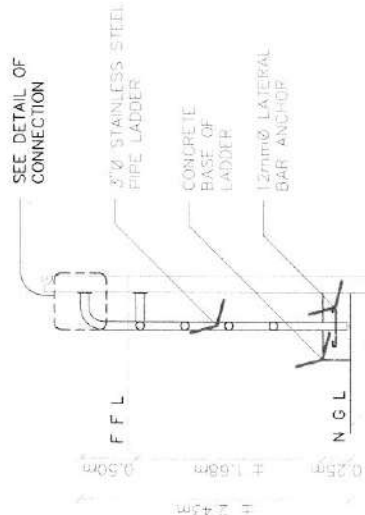


SECTION THRU A-A

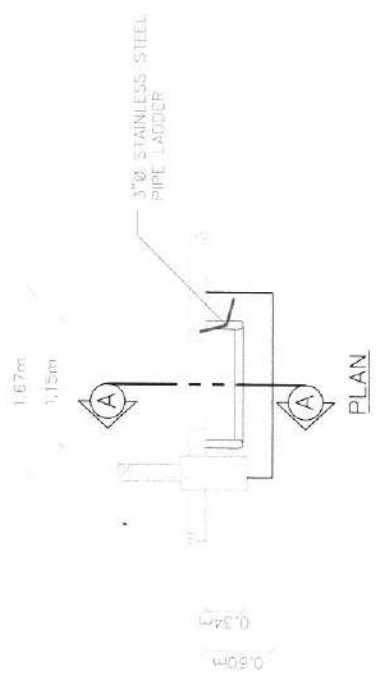

PLAN

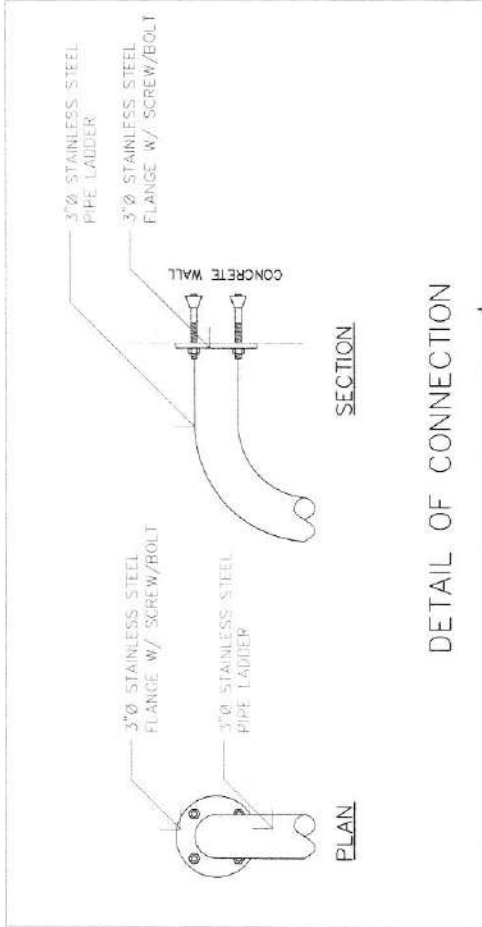

DETAIL OF CONNECTION

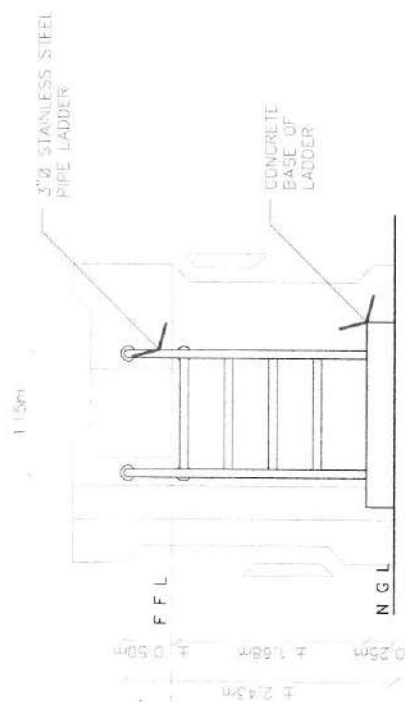

ELEVATION

DETAIL OF LADDER
SCALE: NTS.



REPUBLIC OF THE PHILIPPINES
 CIVIL AVIATION AUTHORITY OF THE PHILIPPINES
 THIS DRAWING IS EXCLUSIVE PROPERTY OF CIVIL AVIATION AUTHORITY OF THE PHILIPPINES AND MUST NOT BE REPRODUCED, COPIED, EITHER WHOLLY OR IN PART OR IN ANY MANNER, WITHOUT PRIOR PERMISSION AND/OR WRITTEN CONSENT FROM THE DIRECTOR GENERAL, CAA.

AERODROME DEVELOPMENT AND MANAGEMENT SERVICE
 AREA-V, LEGAZPI AIRPORT

ENGINEERING & PLANNING UNIT

PREPARED BY:
 LIMUEK MARI T. MALLORCA
 AIRPORT TECHNICAL ASSISTANT
 CAMP AREA V, LEGAZPI AIRPORT

CHECKED BY:
 MARIA AL-AYE SOLEDAD I. REGINALES
 AERODROME ENGINEERING
 CAMP AREA V, LEGAZPI AIRPORT

APPROVAL RECOMMENDED BY:
 ANDREW M. APABELANO
 AIRPORT TECHNICAL ASSISTANT
 CAMP AREA V, LEGAZPI AIRPORT

APPROVED BY:
 CYNTHIA M. TUMANUT
 AREA/PORT MANAGER
 CAMP AREA V


PROJECT:

REHAB OF ARFF BLDG.

LOCATION:
**MASBATE AIRPORT
 MASBATE CITY**

CONTENT:
 * REFLECTED CEILING PLAN
 * LIGHTING LAYOUT

SHEET NO:
 03
 04

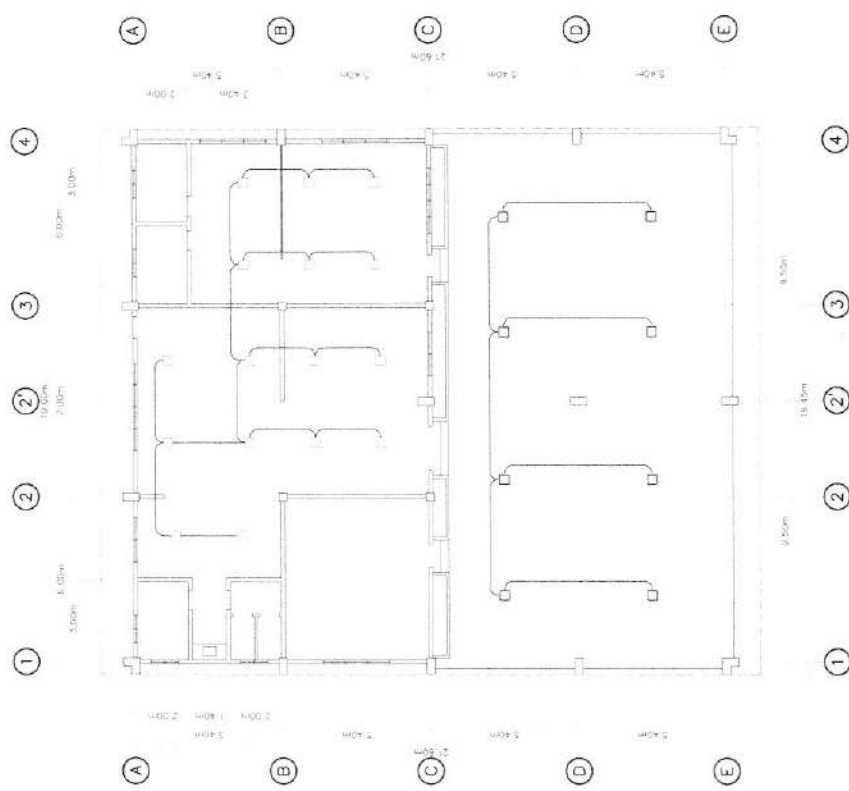

LIGHTING LAYOUT
 SCALE: NTS.

LEGEND:	
	RECESSED CEILING LIGHT, SLIM LED 7" DAYLIGHT (SQUARE TYPE)
	RECESSED CEILING LIGHT, SLIM LED 18" DAYLIGHT (SQUARE TYPE)



REFLECTED CEILING PLAN
 SCALE: NTS.



REPUBLIC OF THE PHILIPPINES
CIVIL AVIATION AUTHORITY OF THE PHILIPPINES
 THIS DRAWING IS EXCLUSIVE PROPRIETIES OF THE CIVIL AVIATION AUTHORITY OF THE PHILIPPINES AND MUST NOT BE REPRODUCED OR TRANSMITTED IN ANY FORM OR BY ANY MEANS, ELECTRONIC OR MECHANICAL, INCLUDING PHOTOCOPYING, RECORDING, OR BY ANY INFORMATION STORAGE AND RETRIEVAL SYSTEM, WITHOUT THE WRITTEN PERMISSION AND/OR WRITTEN CONSENT FROM THE DIRECTOR GENERAL, CAA.

AERODROME DEVELOPMENT AND MANAGEMENT SERVICES AREA-V, LEGAZPI AIRPORT

ENGINEERING & PLANNING UNIT

PREPARED BY:

LIMUEL MARI T. M. LLORCA
 AIRPORT TECHNICAL ASSISTANT
 CAMP AREA V, LEGAZPI AIRPORT

CHECKED BY:

MARIA AL-AYE SOLIS
 AIRPORT ENGINEER
 CAMP AREA V, LEGAZPI AIRPORT

APPROVAL RECOMMENDED BY:

ANDREW N. ARELLANO
 AIRPORT ENGINEER
 CAMP AREA V, LEGAZPI AIRPORT

APPROVED BY:


CYNTHIA D. TUMANAIT
 AREA/AIRPORT MANAGER
 CAMP AREA V

PROJECT:
REHAB OF ARFF BLDG.

LOCATION:
**MASBATE AIRPORT
 MASBATE CITY**

CONTENT:
 SHEET NO:
02
04


- DETAIL OF FLOOR FINISH
- ROOF PLAN
- DETAIL OF PLUMBING FIXTURES

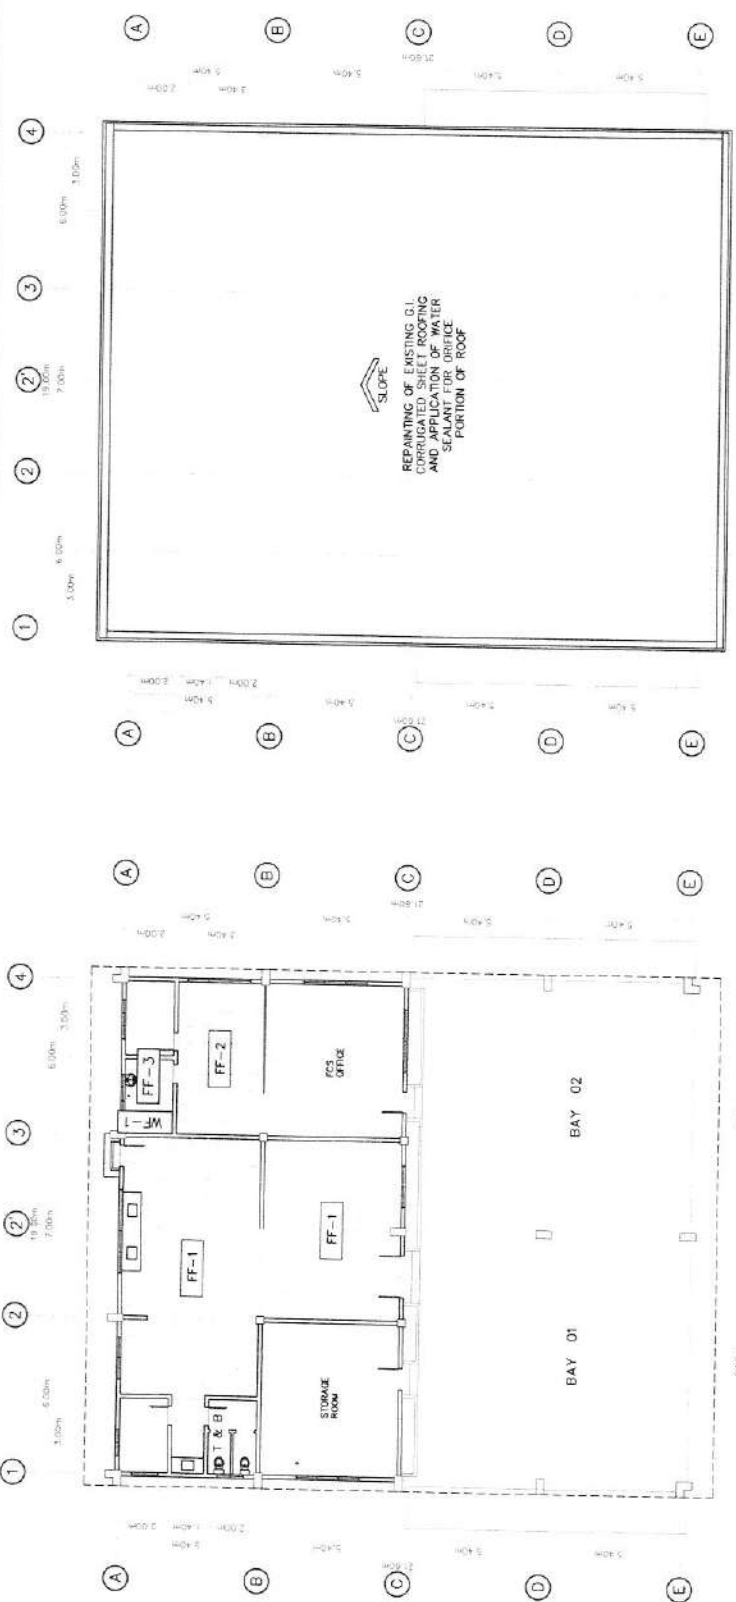

ROOF PLAN
 SCALE: NTS




DETAIL OF FLOOR FINISH
 SCALE: NTS

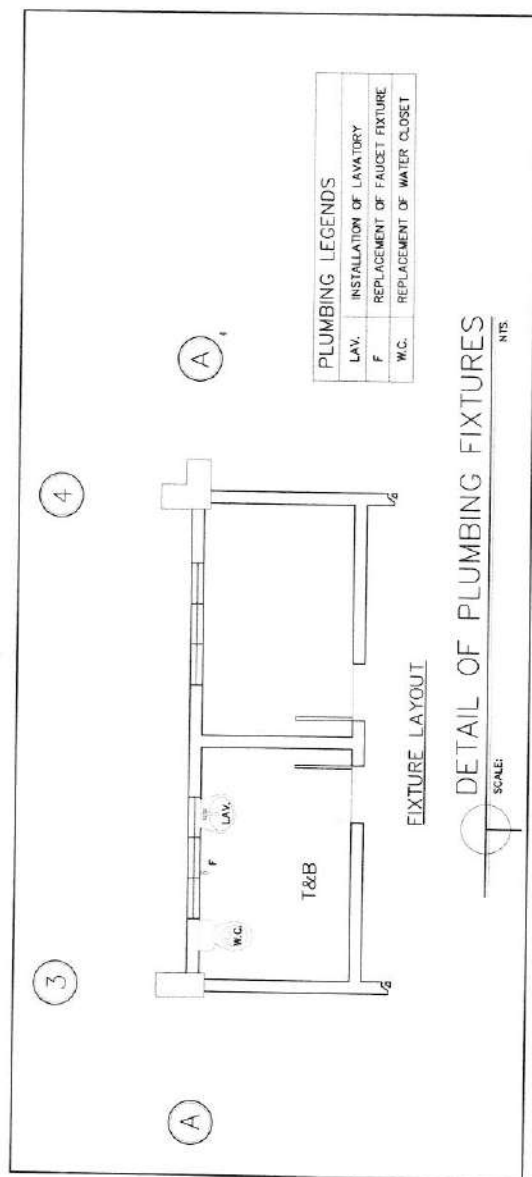


LEGEND:

TAGS	DESCRIPTION
FF-1	600mm x 600mm POLISHED FINISH TILE REPLACEMENT FOR THE APPLICATION OF TILE ADHESIVE
FF-2	REPLACEMENT OF 14-600mm x 600mm POLISHED FINISH TILE REPLACING FOR THE APPLICATION OF TILE ADHESIVE
FF-3	150mm x 300mm NON-SKID TILE REPLACEMENT FOR THE APPLICATION OF TILE ADHESIVE
WF-1	600mm x 300mm POLISHED FINISH TILE REPLACEMENT FOR THE APPLICATION OF TILE ADHESIVE

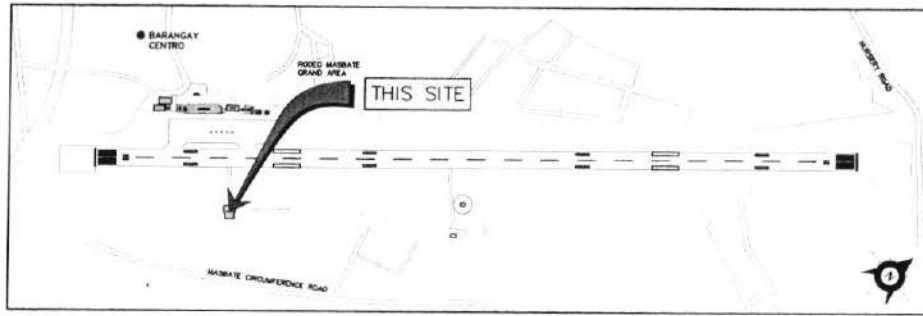


VICINITY MAP
SCALE: NTS.

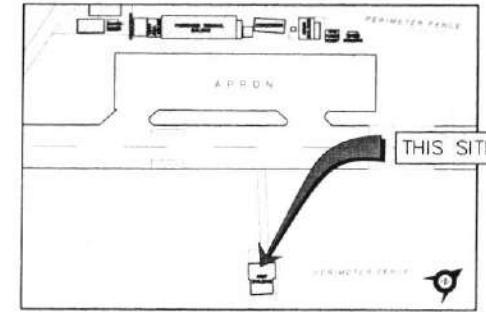

LOCATION PLAN
SCALE: NTS.




FLOOR PLAN
SCALE: NTS.

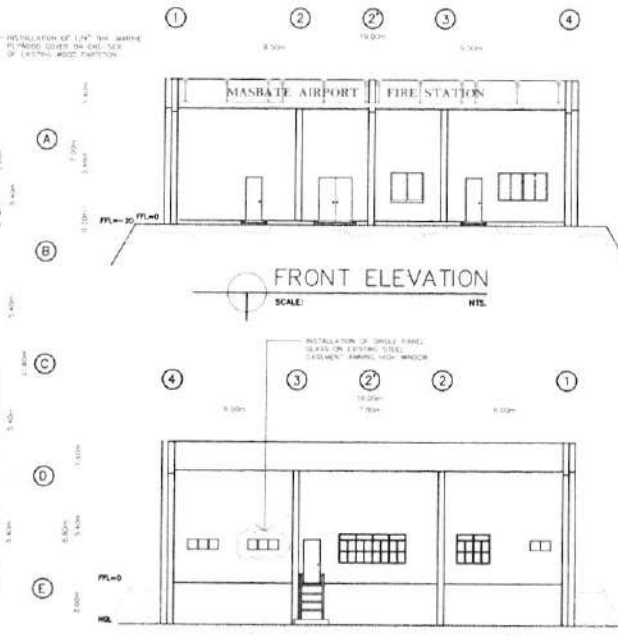


FRONT ELEVATION
SCALE: NTS.

REAR ELEVATION
SCALE: NTS.

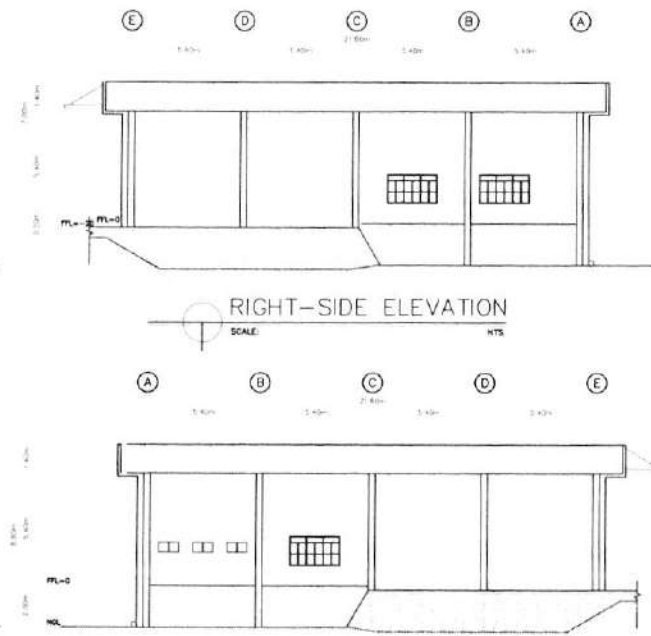

RIGHT-SIDE ELEVATION
SCALE: NTS.

LEFT-SIDE ELEVATION
SCALE: NTS.

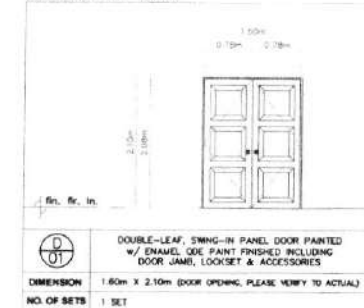

REPUBLIC OF THE PHILIPPINES
CIVIL AVIATION AUTHORITY OF THE PHILIPPINES

THIS DRAWING IS EXCLUSIVE PROPERTY OF CIVIL AVIATION AUTHORITY OF THE PHILIPPINES AND MUST NOT BE REPRODUCED, EXHIBITED, LOANED NOR COPIED IN PART OR IN WHOLE WITHOUT PROPER PERMISSION AND/OR WRITTEN CONSENT FROM THE DIRECTOR GENERAL, CAAAP.

AERODROME DEVELOPMENT AND MANAGEMENT SERVICE AREA-V, LEGAZPI AIRPORT

ENGINEERING & PLANNING UNIT

PREPARED BY

[Signature]
LIMUEL MARI T. WALLORCA
AIRPORT TECHNICAL ASSISTANT
CAAP AREA V, LEGAZPI AIRPORT

CHECKED BY

[Signature]
MARIA AI-AYE SOLEDAD I. REGINALES
AERODROME ENGINEER
CAAP AREA V, LEGAZPI AIRPORT

APPROVAL RECOMMENDED BY:

[Signature]
ANDREW N. AREDLANO
ENR. SUPERVISOR
CAAP AREA V, LEGAZPI AIRPORT

APPROVED BY:

[Signature]
CYNTHIA M. TUMANUT
AREA/AIRPORT MANAGER,
CAAP AREA V

PROJECT:

REHAB OF ARFF BLDG.

LOCATION:

MASBATE AIRPORT
MASBATE CITY

CONTENT:

- LOCATION PLAN
- FLOOR & ELEVATION PLAN
- SCHEDULE OF DOOR

SHEET NO.:

01
04