 



THIS DRAWING IS EXCLUSIVE PROPERTIES OF CIVIL AVIATION AUTHORITY OF THE PHILIPPINES AND MUST NOT BE REPRODUCED, EXHIBITED, LOANED NOR COPIED IN PART OR IN WHOLE WITHOUT PROPER PERMISSION AND/OR WRITTEN CONSENT FROM THE DIRECTOR GENERAL CAAP.

AERODROME DEVELOPMENT AND MANAGEMENT SERVICE

INFRASTRUCTURE DEVELOPMENT AND DESIGN DIVISION

DESIGN STAFF:	INITIAL / DATE
DESIGNED BY:	IDDD
DRAWN BY:	JCMC
CHECKED BY:	RUAJR

 REVIEWED BY:

RAUL R. CRUCENA
 Division Chief III, IDDD-ADMS

SUBMITTED BY:

ARNEL F. BORLADO
 Department Manager III, AED-ADMS

RECOMMENDED APPROVAL:

LT COL VALENTINO A. DIONELA PAF (RET.)
 ADG II, ADMS

APPROVED:

CAPTAIN MANUEL ANTONIO L. TAMAYO
 Director General

APPROVED:

ATTY. ROBERTO C.O. LIM
 Undersecretary for Aviation and Airports

NOTES/REVISIONS:
 1



PROJECT:
ILOILO INTERNATIONAL AIRPORT DEVELOPMENT PROJECT
 (Rehabilitation/Improvement of Passenger Terminal Building - Supply, Installation and Commissioning of Three (3) Units 600 KW Chiller)

LOCATION:
ILOILO INTERNATIONAL AIRPORT
CABATUAN, ILOILO

SHEET CONTENTS:
 CHILLER DEMOLITION PLAN

DRAWING SCALE:	SHEET NO:
AS SHOWN	M - 01
	01 05

KEY PLAN

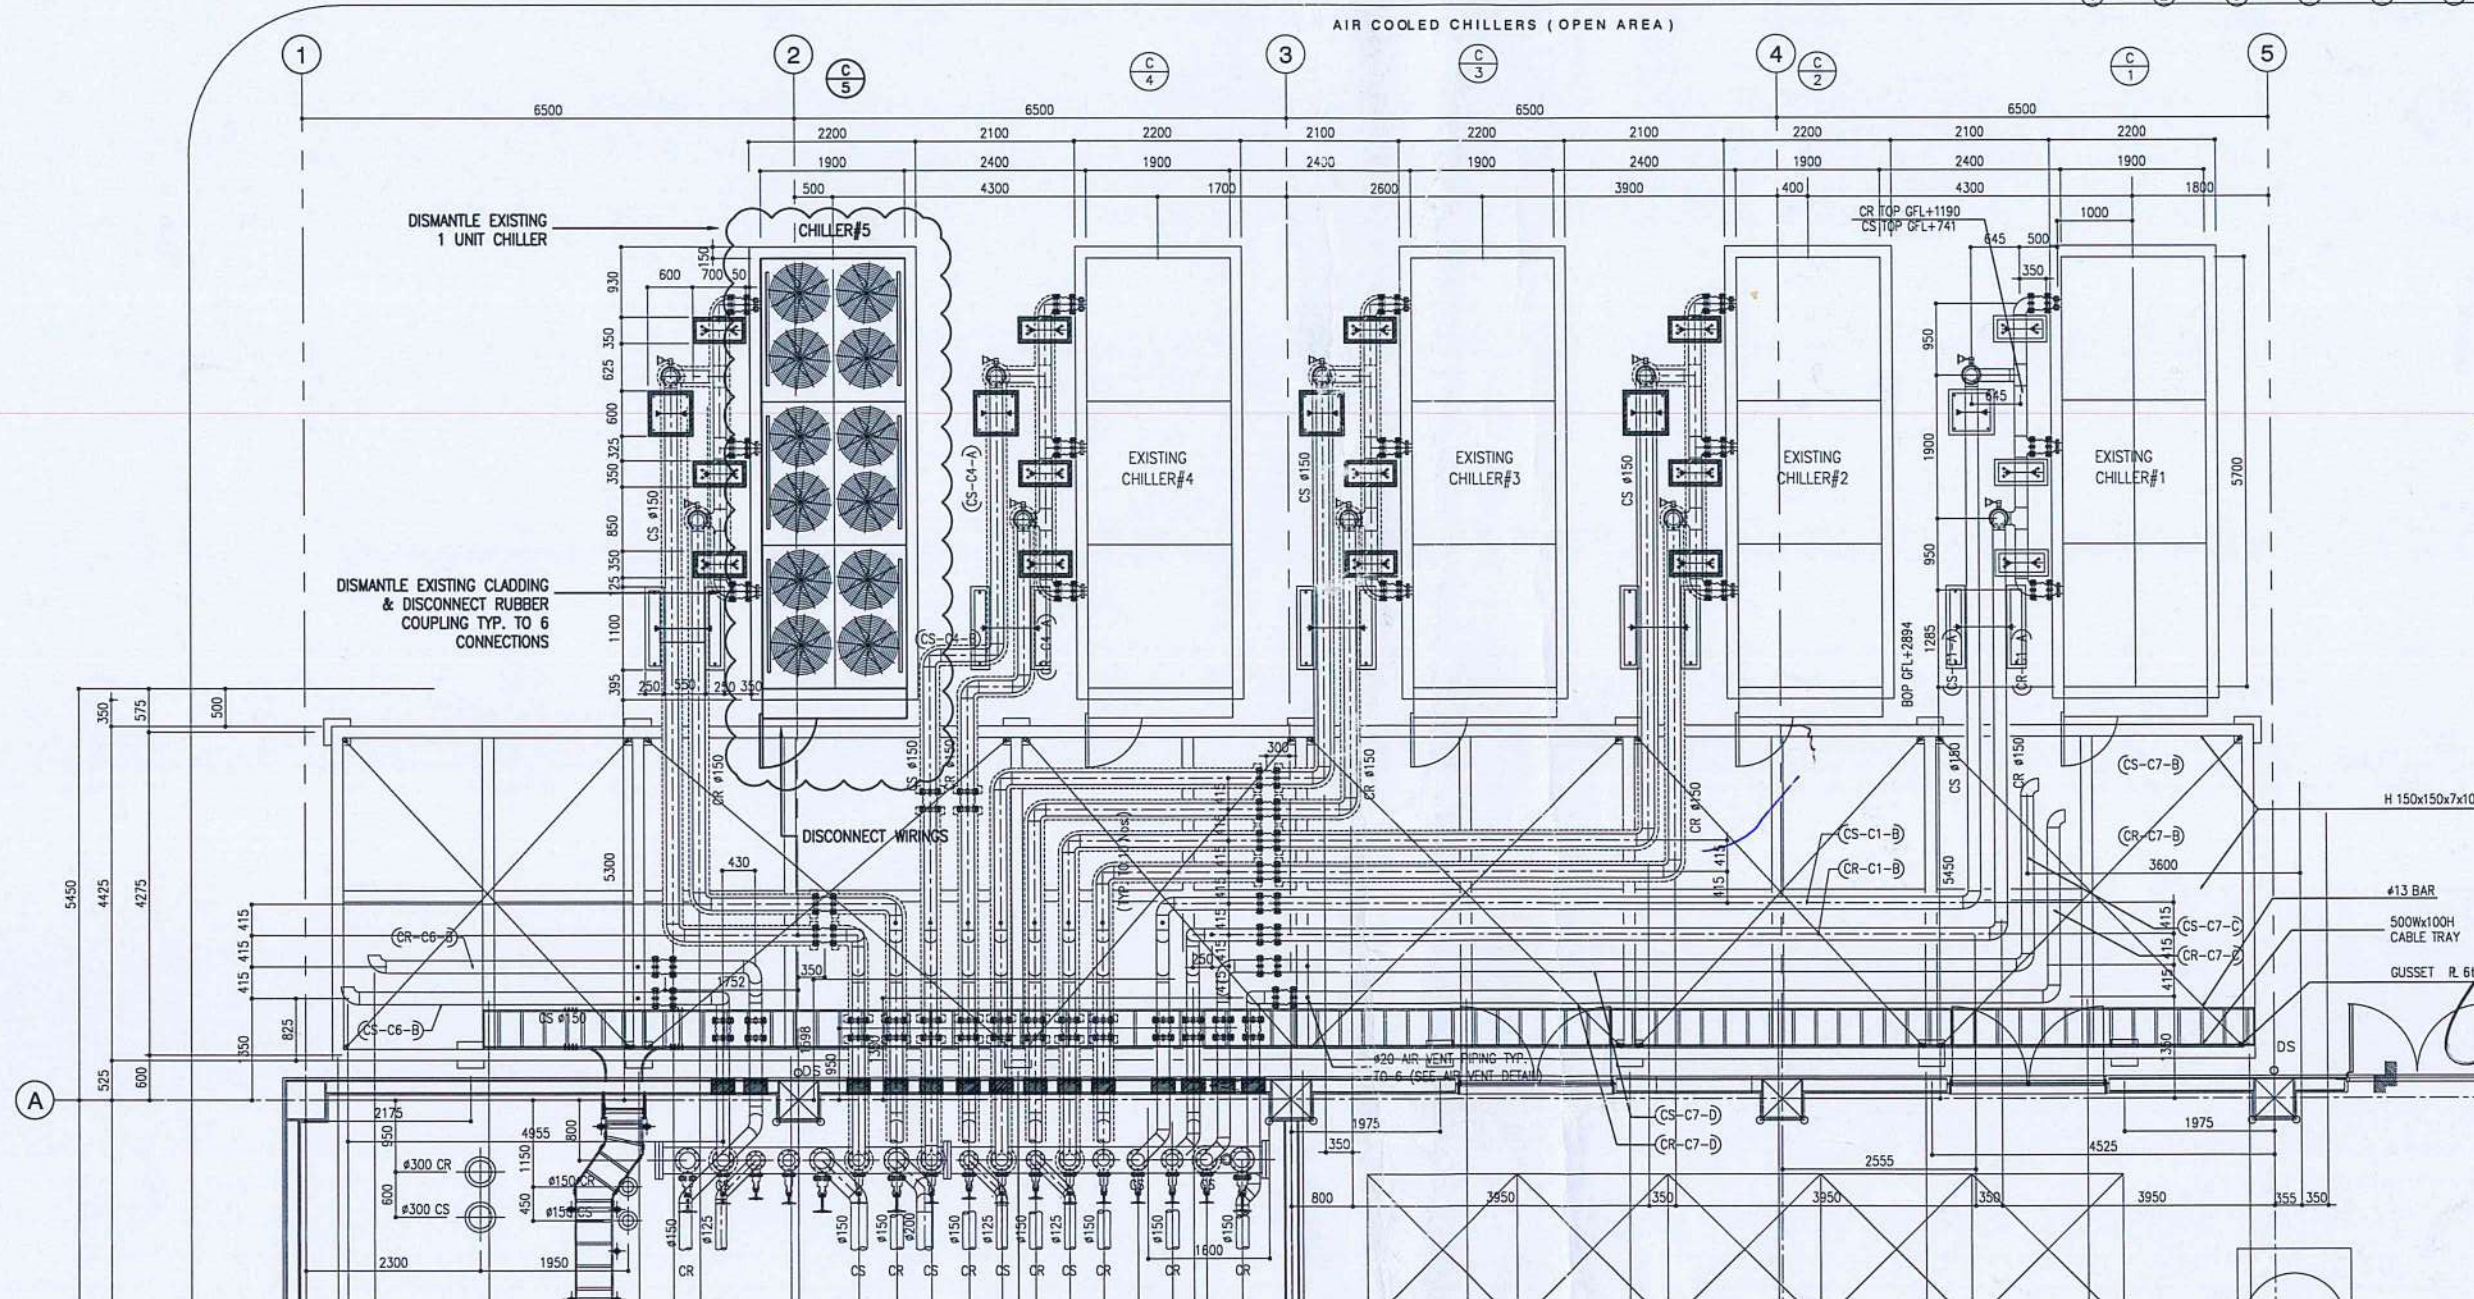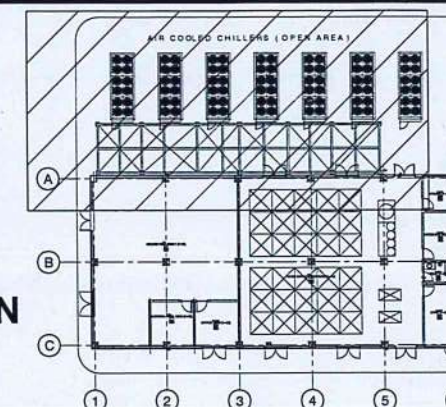


1 CHILLER DEMOLITION PLAN
 M-01/M-01 SCALE: 1 : 100 M

AIR-COOLED WATER CHILLER

MARK	QTY.	LOCATION	COOLING LOAD/UNIT KW (TR)	ELECTRICAL DATA			REMARKS
				V	PH	HZ	
C #	3	AIR-COOLED CHILLER OPEN AREA	600 (170.6)	440-460	3	60	SCREW-TYPE AIR-COOLED WATER CHILLER WITH R-407C REFRIGERANT. SHOULD BE BMS-READY.

KEY PLAN

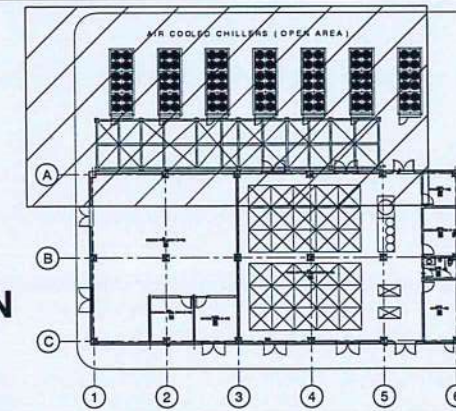

THIS DRAWING IS EXCLUSIVE PROPERTY OF CIVIL AVIATION AUTHORITY OF THE PHILIPPINES AND MUST NOT BE REPRODUCED, EXHIBITED, LOANED NOR COPIED IN PART OR IN WHOLE WITHOUT PROPER PERMISSION AND/OR WRITTEN CONSENT FROM THE DIRECTOR GENERAL CAAP.

AERODROME DEVELOPMENT AND
MANAGEMENT SERVICE

INFRASTRUCTURE DEVELOPMENT AND
DESIGN DIVISION

DESIGN STAFF: INITIAL / DATE

DESIGNED BY: IDDD
DRAWN BY: JCMC
CHECKED BY: RUJMR

REVIEWED BY:

RAUL R. CRUCENA
Division Chief III, IDDD-ADMS

SUBMITTED BY:

ARNEL F. BORLADO
Department Manager III, AED-ADMS

RECOMMENDED APPROVAL:

LT COL VALENTINO A. DIONELA PAF (RET)
ADG II, ADMS

APPROVED:

CAPTAIN MANUEL ANTONIO L. TAMAYO
Director General

APPROVED:

ATY ROBERTO C.O. LIM
Undersecretary for Aviation and Airports

NOTES/REVISIONS:


PROJECT:
ILOILO INTERNATIONAL
AIRPORT DEVELOPMENT
PROJECT
(Rehabilitation/Improvement of
Passenger Terminal Building - Supply,
Installation and Commissioning of Three
(3) Units 600 KW Chiller)

LOCATION:
ILOILO INTERNATIONAL
AIRPORT
CABATUAN, ILOILO

SHEET CONTENTS:

CHILLER & PIPING LAYOUT

DRAWING SCALE: AS SHOWN
SHEET NO: M - 02
02 05

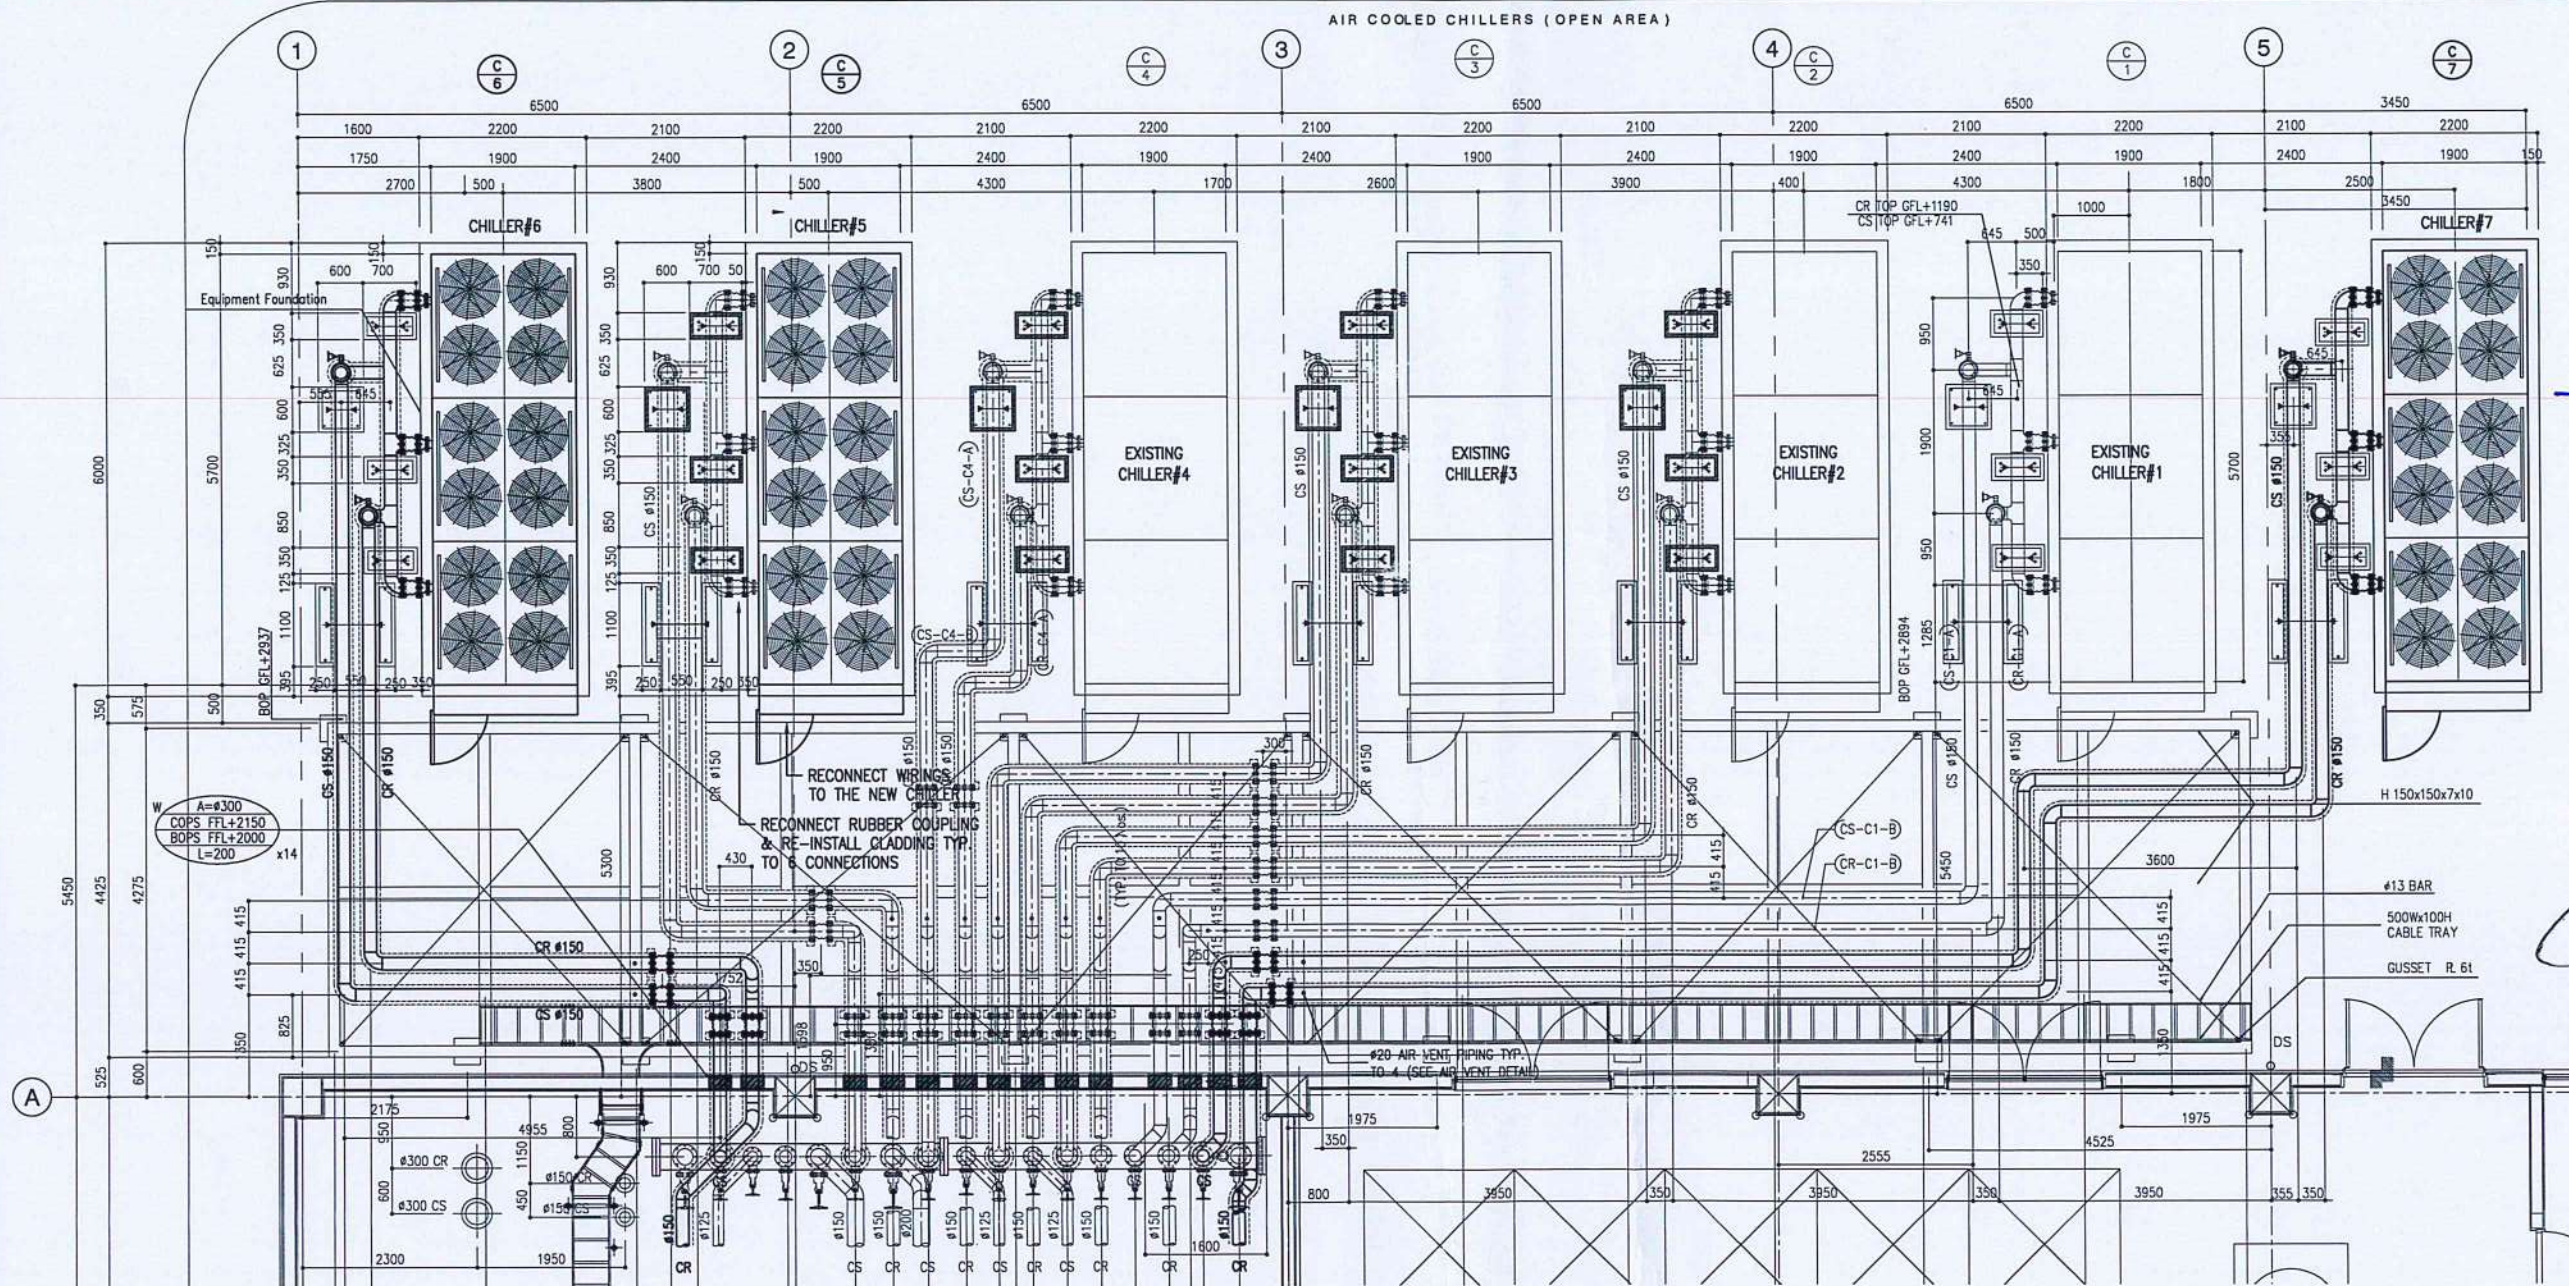


1 CHILLER & PIPING LAYOUT

M-02M-02 SCALE:


1 : 100 M

NOTE:


CHILLED WATER PIPING SHALL BE COMPLETE WITH NECESSARY INSULATION, CLADDING & SUPPORT (VERIFY EXISTING).

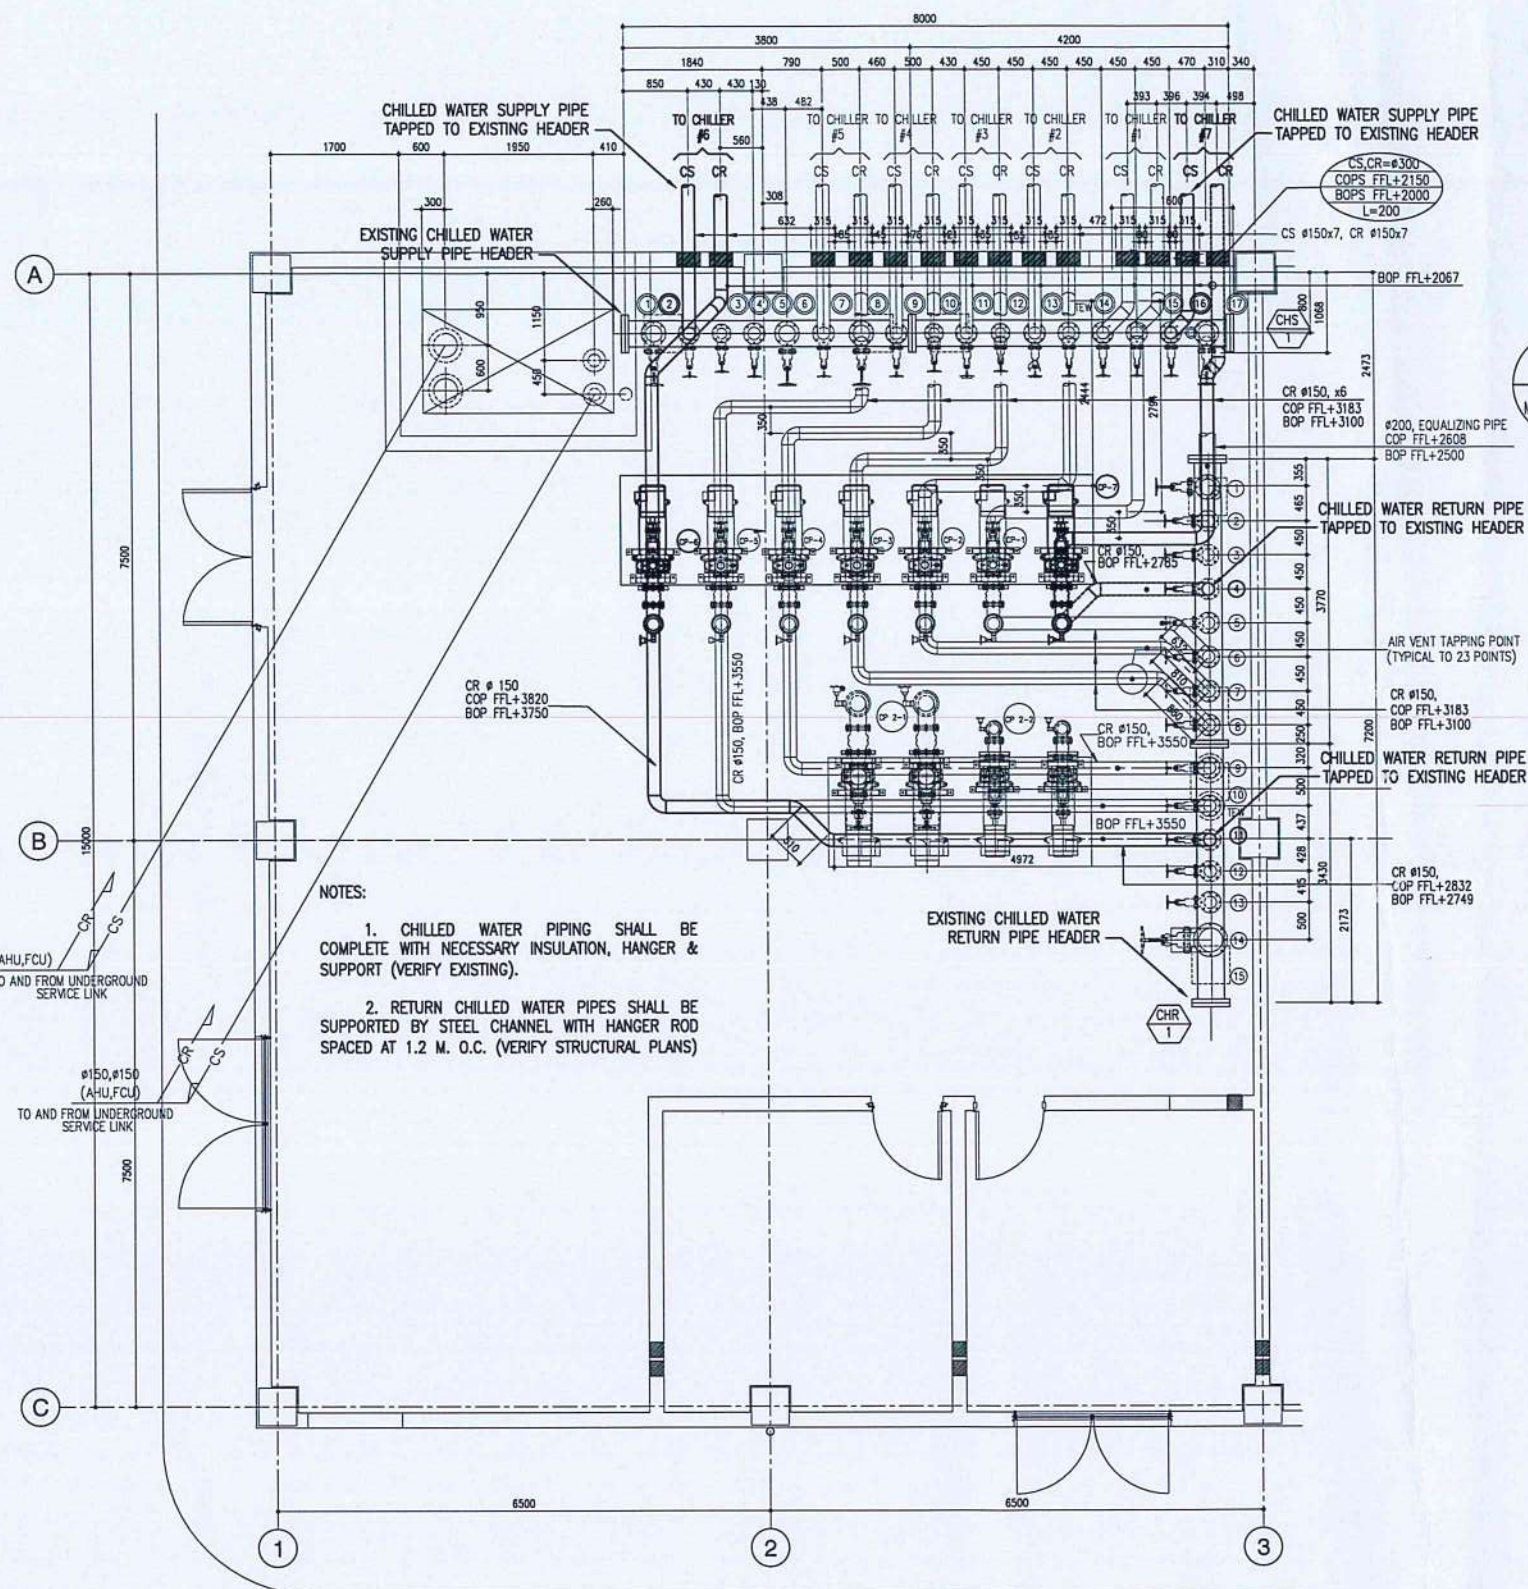

1 CHILLED WATER PUMP & PIPING LAYOUT
SCALE: 1 : 100 M

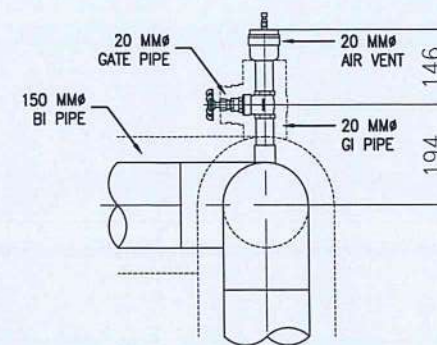


2 AIR VENT DETAIL
SCALE: NTS

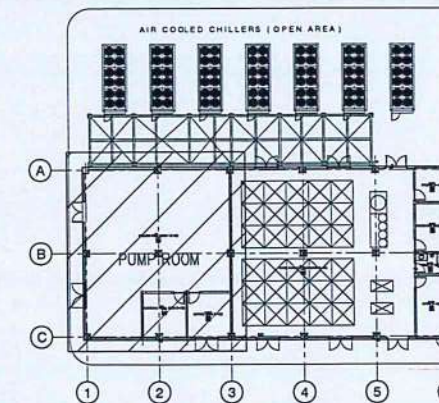

KEY PLAN

PRIMARY CHILLED WATER PUMP

MARK	QTY.	LOCATION	CAPACITY M ³ /MIN	HEAD M	RPM	MOTOR OUTPUT KW	ELECTRICAL DATA			REMARKS
							V	PH	HZ	
CP-#	2	PUMP ROOM	1.72	20	1750	11	440-460	3	60	CENTRIFUGAL TYPE, PRIMARY CHILLED WATER PUMP WITH COMPLETE ACCESSORIES & SUPPORT.

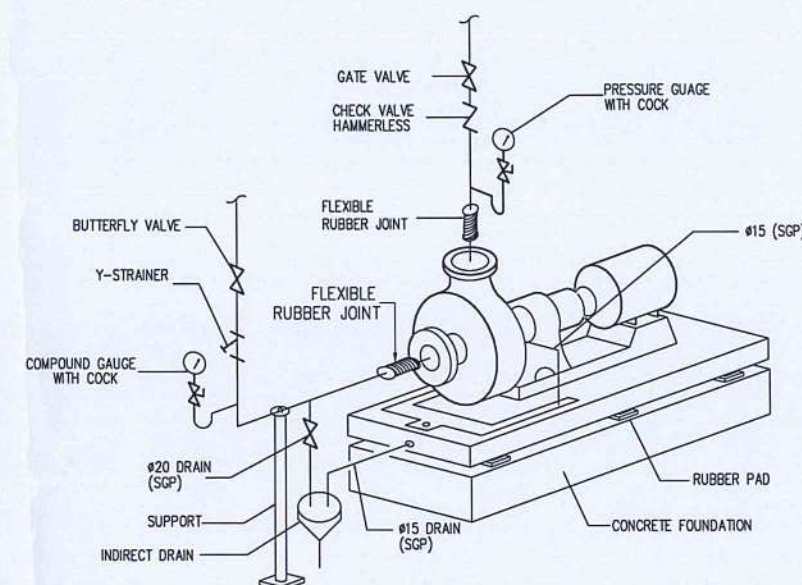

3 CHILLED WATER PUMP DETAIL
SCALE: NTS

THIS DRAWING IS EXCLUSIVE PROPERTY OF CIVIL AVIATION AUTHORITY OF THE PHILIPPINES AND MUST NOT BE REPRODUCED, EXHIBITED, LOANED NOR COPIED IN PART OR IN WHOLE WITHOUT PROPER PERMISSION AND/OR WRITTEN CONSENT FROM THE DIRECTOR GENERAL CAAP.

AERODROME DEVELOPMENT AND MANAGEMENT SERVICE

INFRASTRUCTURE DEVELOPMENT AND DESIGN DIVISION

DESIGN STAFF: INITIAL / DATE
DESIGNED BY: IDDD
DRAWN BY: JCMC
CHECKED BY: RUAR

REVIEWED BY:
RAUL R. CRUCENA
Division Chief III, IDDD-ADMS

SUBMITTED BY:
ARNEL F. BORLADO
Department Manager III, AED-ADMS

RECOMMENDED APPROVAL:
LT COL VALENTINO A. DIONELA PAF (RET)
ADG-ADMS

APPROVED:
CAPTAIN MUEL ANTONIO L. TAMAYO
Director General

 
 
APPROVED:
ATTY. ROBERTO C.O. LIM
Undersecretary for Aviation and Airports
NOTES/REVISIONS:

PROJECT:
ILOILO INTERNATIONAL AIRPORT DEVELOPMENT PROJECT
(Rehabilitation/Improvement of Passenger Terminal Building - Supply, Installation and Commissioning of Three (3) Units 600 KW Chiller)

LOCATION:
**ILOILO INTERNATIONAL AIRPORT
CABATUAN, ILOILO**

SHEET CONTENTS:
AS SHOWN

DRAWING SCALE: SHEET NO:
AS SHOWN M - 03
03 05



THIS DRAWING IS EXCLUSIVE PROPERTY OF CIVIL AVIATION AUTHORITY OF THE PHILIPPINES AND MUST NOT BE REPRODUCED, EXHIBITED, LOANED NOR COPIED IN PART OR IN WHOLE WITHOUT PROPER PERMISSION AND/OR WRITTEN CONSENT FROM THE DIRECTOR GENERAL CAAP.

AERODROME DEVELOPMENT AND MANAGEMENT SERVICE

INFRASTRUCTURE DEVELOPMENT AND DESIGN DIVISION

DESIGN STAFF:	INITIAL / DATE
DESIGNED BY:	1000
DRAWN BY:	JCMC
CHECKED BY:	RUAJR

REVIEWED BY:



RAUL R. CRUCENA
Division Chief III, IDDD-ADMS

SUBMITTED BY:



ARNEL F. BORLADO
Department Manager III, AED-ADMS

RECOMMENDED APPROVAL:



LT. COL. VALENTINO A. DIONELA PAF (RET)
ADG III, ADMS

APPROVED:



CAPTAIN MANUEL ANTONIO L. TAMAYO
Director General

APPROVED:



ATTY. ROBERTO C.O. LIM
Undersecretary for Aviation and Airports

NOTES/REVISIONS:

-
-
-
-

PROJECT:

ILOILO INTERNATIONAL AIRPORT DEVELOPMENT PROJECT
(Rehabilitation/Improvement of Passenger Terminal Building - Supply, Installation and Commissioning of Three (3) Units 600 KW Chiller)


LOCATION:

ILOILO INTERNATIONAL AIRPORT
CABATUAN, ILOILO

SHEET CONTENTS:

SECTION - "B-B"

DRAWING SCALE:	SHEET NO:
AS SHOWN	M - 05
	05 05

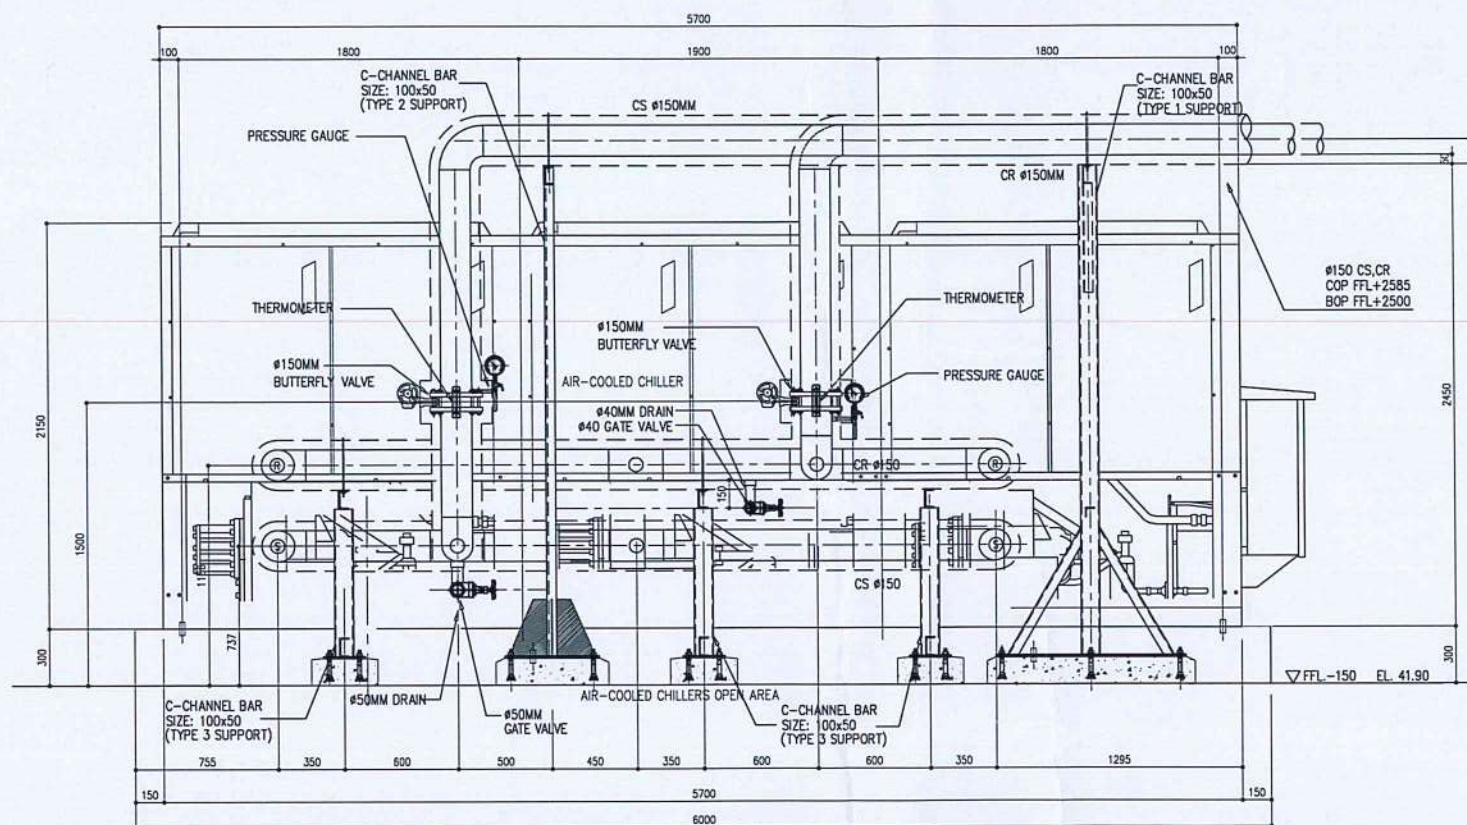

1

SECTION - "A-A"

M-05M-05

SCALE:

1 : 40 M



CIVIL AVIATION AUTHORITY OF THE PHILIPPINES
(An Agency, Not a Government Unit)

THIS DRAWING IS EXCLUSIVE PROPERTY OF THE CIVIL AVIATION AUTHORITY OF THE PHILIPPINES AND MUST NOT BE REPRODUCED, EXHIBITED, LOANED NOR COPIED IN PART OR IN WHOLE WITHOUT PROPER PERMISSION AND/OR WRITTEN CONSENT FROM THE DIRECTOR GENERAL CAAP.

AERODROME DEVELOPMENT AND
MANAGEMENT SERVICE

INFRASTRUCTURE DEVELOPMENT AND
DESIGN DIVISION

DESIGN STAFF:	INITIAL / DATE
DESIGNED BY:	IDDG
DRAWN BY:	RUJ/R
CHECKED BY:	

REVIEWED BY:

RAUL R. GRUCENA
Division Chief III, AED-ADMS

SUBMITTED BY:

ARNEL F. BORLADO
Department Manager III, AED-ADMS

RECOMMENDED APPROVAL:

LT COL. VALENTINO A. DIONELA PAF (RET)
ADG II, ADMS

APPROVED:

CAPTAIN MANIBELA ANTONIO L. TAMAYO
Director General

APPROVED:

ATTY. ROBERTO C.O. LIM
Undersecretary for Aviation and Airports

NOTES/REVISIONS:

PROJECT:
ILOILO INTERNATIONAL
AIRPORT DEVELOPMENT
PROJECT
(Rehabilitation/Improvement of
Passenger Terminal Building - Supply,
Installation and Commissioning of
Three (3) Units 600 KW Chiller)

LOCATION:
ILOILO INTERNATIONAL
AIRPORT
CABATUAN, ILOILO

SHEET CONTENTS:
POWER FEEDER SYSTEM LAYOUT

DRAWING SCALE:	SHEET NO:
AS SHOWN	E-01

PANEL BOARD
MAIN : 600AT, 3-POLE, 460VAC
BRANCHES: 3x200AT, 3-POLE, 460VAC
TO LVSG CPM-NO. 1
2 SETS OF:
3-150mm² THHN/THWN-2 +
1-38mm² THHN/THWN-2 (G)
IN 80mm² (3") IMC/CABLE TRAY

PANEL BOARD
MAIN : 600AT, 3-POLE, 460VAC
BRANCHES: 3x200AT, 3-POLE, 460VAC
TO LVSG CPM-NO. 2
2 SETS OF:
3-150mm² THHN/THWN-2 +
1-38mm² THHN/THWN-2 (G)
IN 80mm² (3") IMC/CABLE TRAY

W700XH200XL150
FFL+3000 BOTTL.
500W x 70H CABLE TRAY/RISE UP (LV)
500W x 70H CABLE TRAY/RISE UP
with SEPARATOR(LV/COM)

TO MCCP1-CPM
3-8.0mm² THHN/THWN-2 +
1-5.5mm² THHN/THWN-2 (G)
CHILLER'S
PUMP ROOM
TO MCCP2-CPM
3-8.0mm² THHN/THWN-2 +
1-5.5mm² THHN/THWN-2 (G)

ELECTRICAL
PANEL ROOM
CONTROL
ROOM
MCCP3
700W x 2150H x 300D
FREE STANDING PANEL
MCCP2
700W x 2150H x 300D
FREE STANDING PANEL
MCCP1
800W x 2150H x 300D
FREE STANDING PANEL

1 POWER FEEDER SYSTEM LAYOUT

E-01 E-01 SCALE: 1:150M



CIVIL AVIATION AUTHORITY OF THE PHILIPPINES
1000, 1000, 1000

THIS DRAWING IS EXCLUSIVE PROPERTY
OF CIVIL AVIATION AUTHORITY OF THE PHILIPPINES
AND MUST NOT BE REPRODUCED, EXHIBITED,
LOANED NOR COPIED IN PART OR
IN WHOLE WITHOUT PROPER PERMISSION AND/OR
WRITTEN CONSENT FROM THE DIRECTOR GENERAL
CAAP.

AERODROME DEVELOPMENT AND
MANAGEMENT SERVICE

INFRASTRUCTURE DEVELOPMENT AND
DESIGN DIVISION

DESIGN STAFF:	INITIAL / DATE
DESIGNED BY:	DDO
DRAWN BY:	GGF
CHECKED BY:	EJDJR
REVIEWED BY:	

RAUL R. CRUCENA
Division Chief III, DDO-ADMS

ARNEL F. BORLADO
Department Manager III, AED-ADMS

LT COL VALENTINO A. DIONELA PAF (RET)
ADG II, ADMS

CAPTAIN MANUEL ANTONIO L. TAMAYO
Director General

ATTY. ROBERTO C. O. LIM
Undersecretary for Aviation and Airports


NOTES/REVISIONS:

PROJECT:
ILOILO INTERNATIONAL
AIRPORT DEVELOPMENT
PROJECT
(Rehabilitation/Improvement of
Passenger Terminal Building - Supply,
Installation and Commissioning of Three
(3) Units 600 KW Chiller)



LOCATION:
ILOILO INTERNATIONAL
AIRPORT
CABATUAN, ILOILO

SHEET CONTENTS:
CONCRETE PAD LAYOUT
DETAILED SECTIONS

DRAWING SCALE:	SHEET NO:
AS SHOWN	S - 1
	01 02

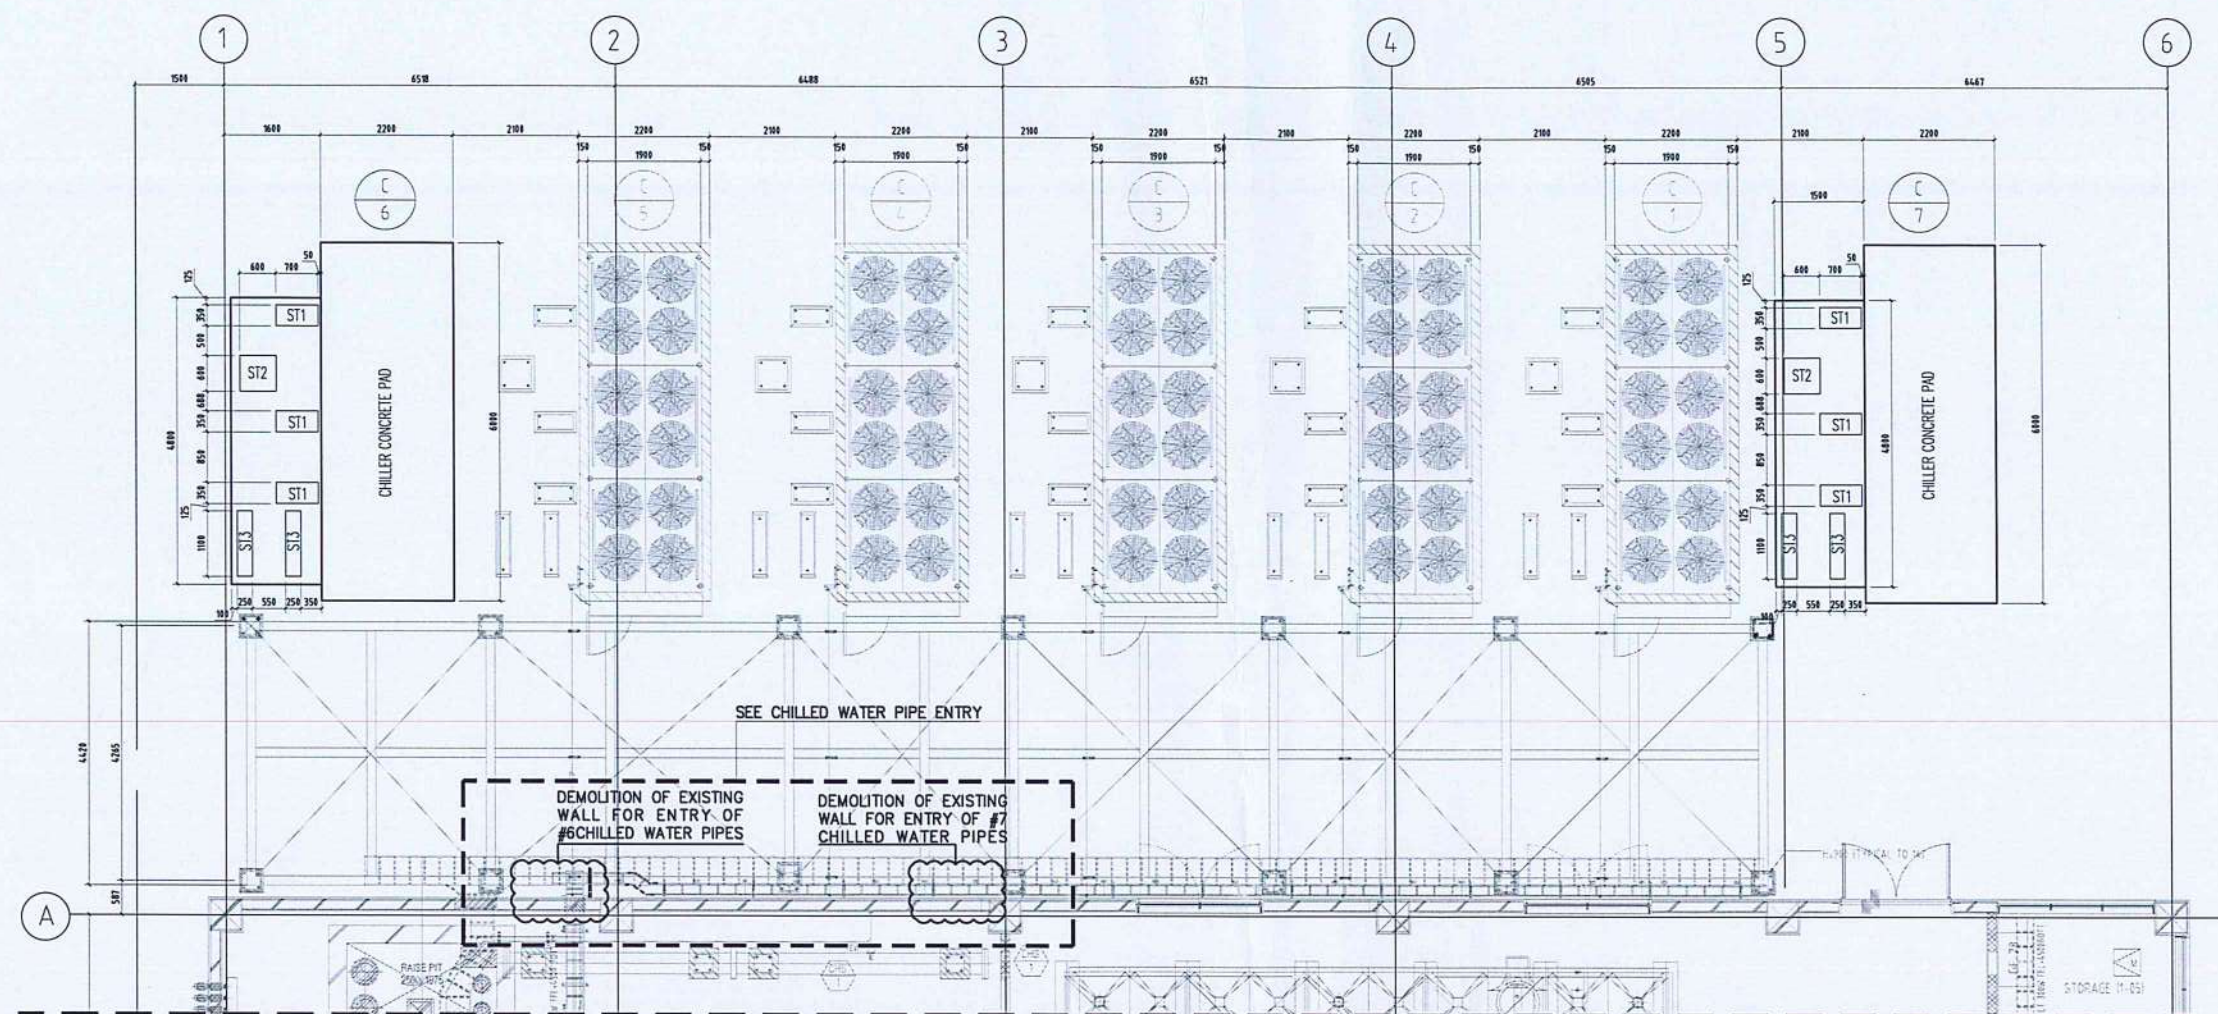


1 CHILLER CONCRETE PAD LAYOUT
SCALE: 1:120M

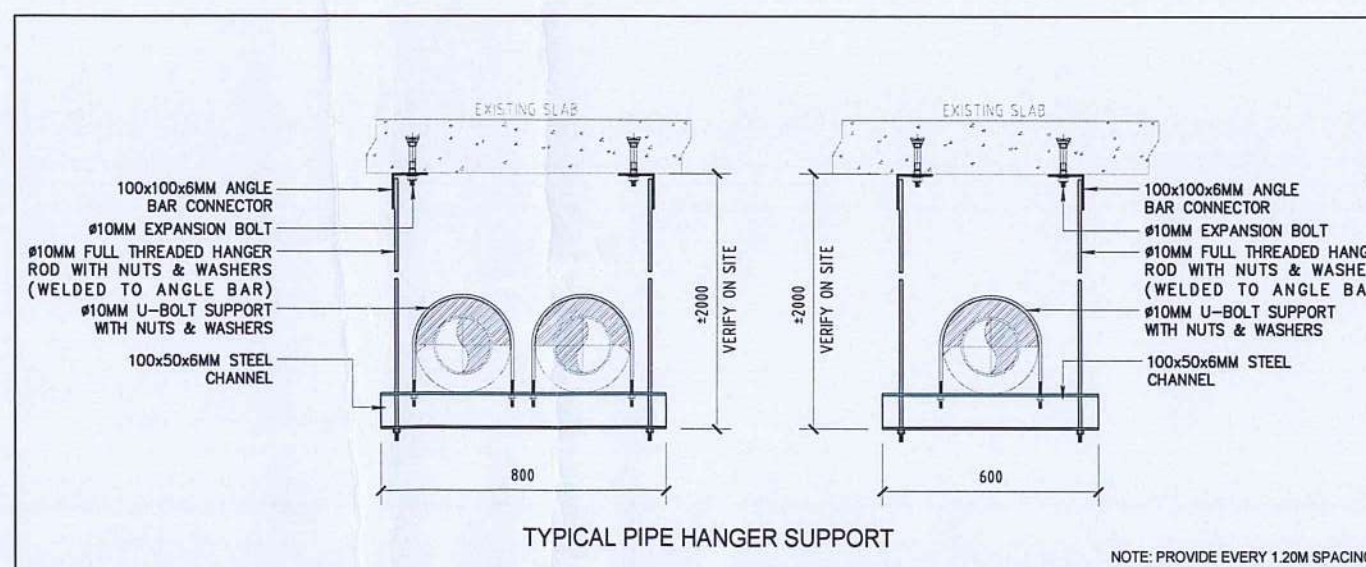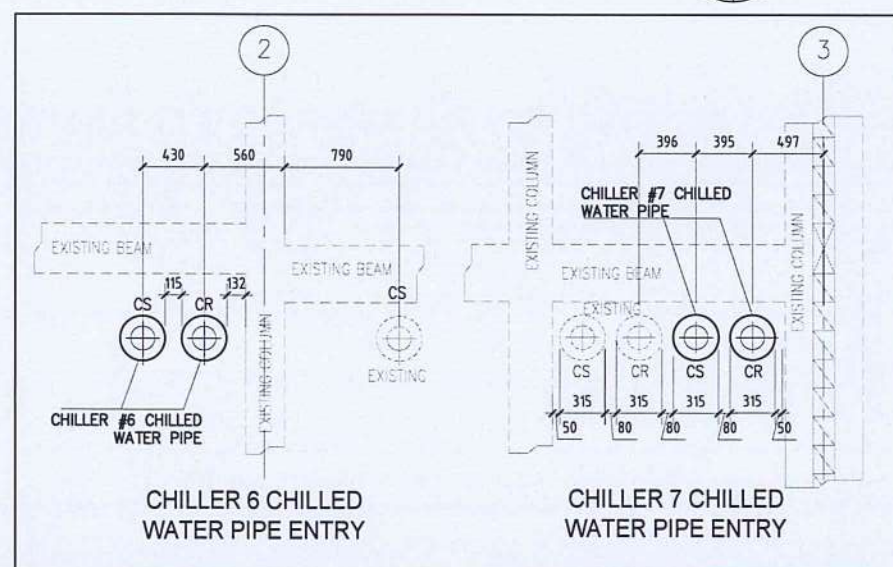


NOTE: PROVIDE EVERY 1.20M SPACING


NOTE: CONCRETE COMPRESSIVE STRENGTH IS 3000PSI

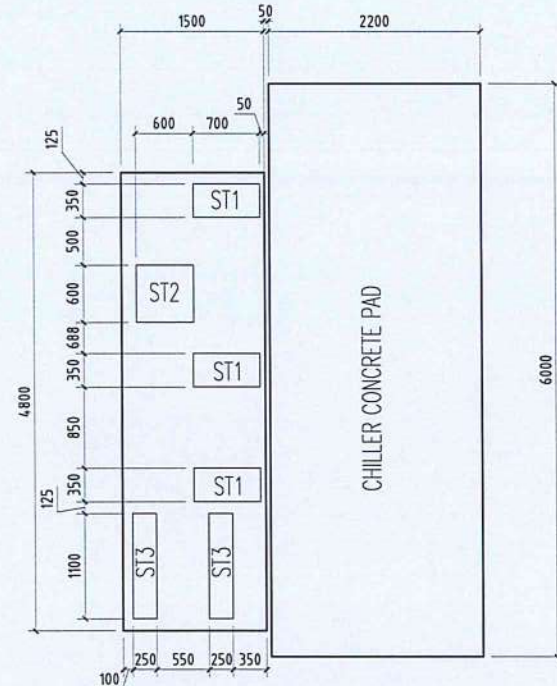


1 TYPICAL DETAILS
CONCRETE PAD LAYOUT PLAN
SCALE: 1:75M

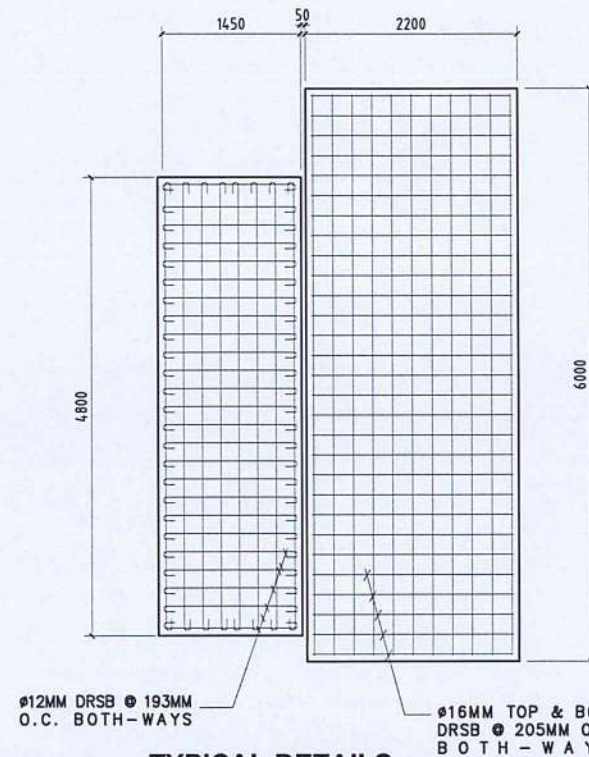


2 TYPICAL DETAILS
CONCRETE PAD REINFORCEMENT
SCALE: 1:75M

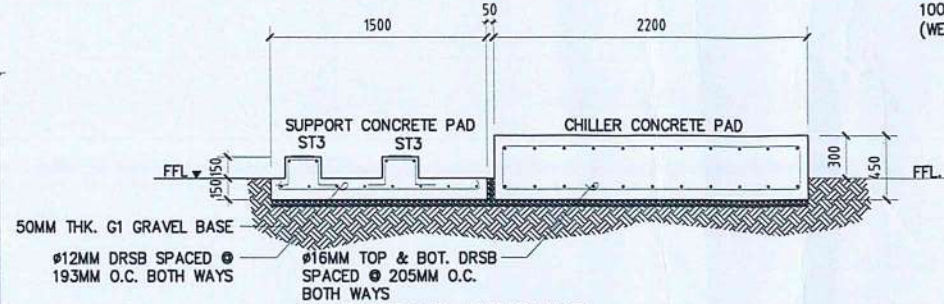


3 TYPICAL DETAILS
CONCRETE PAD SECTION VIEW
SCALE: 1:50M

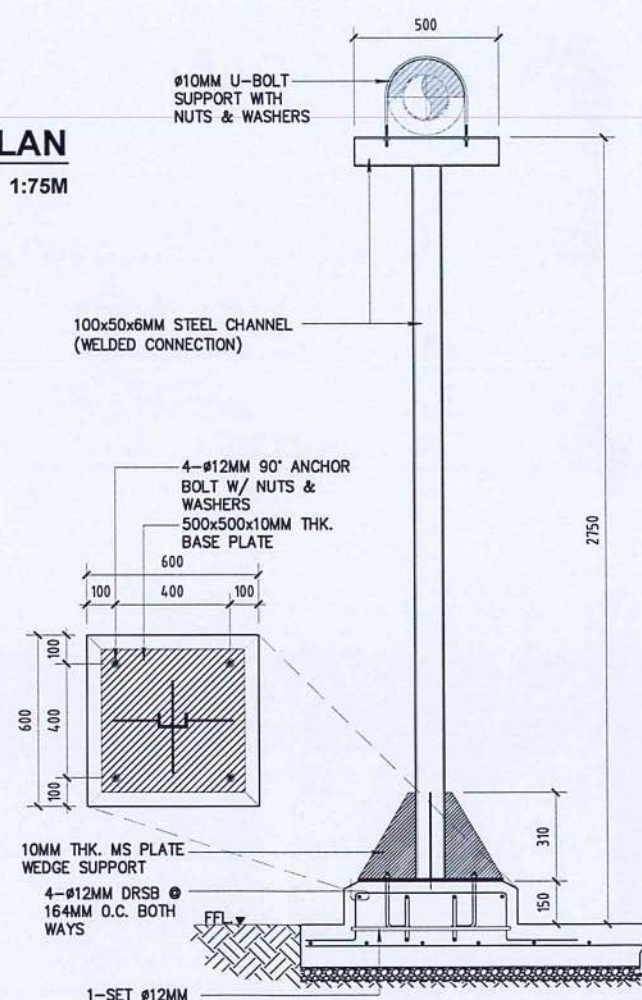

5 SUPPORT TYPE 2
ST2 ELEVATION VIEW
SCALE: 1:25M

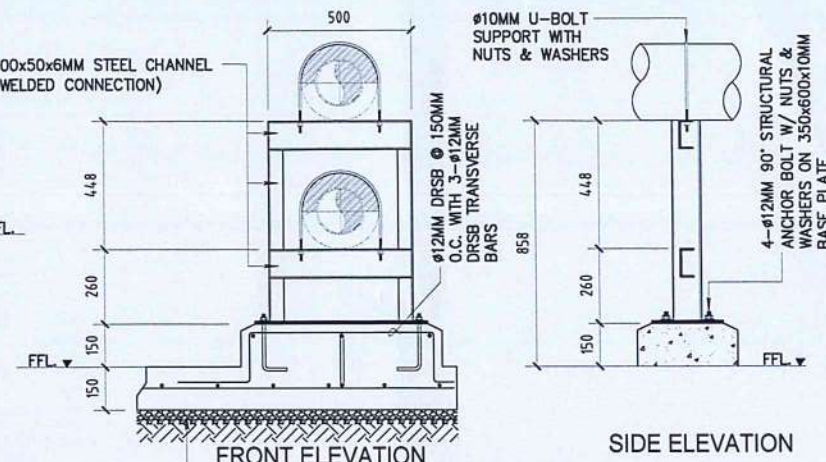

4 SUPPORT TYPE 1
ST1 ELEVATION VIEW
SCALE: 1:25M

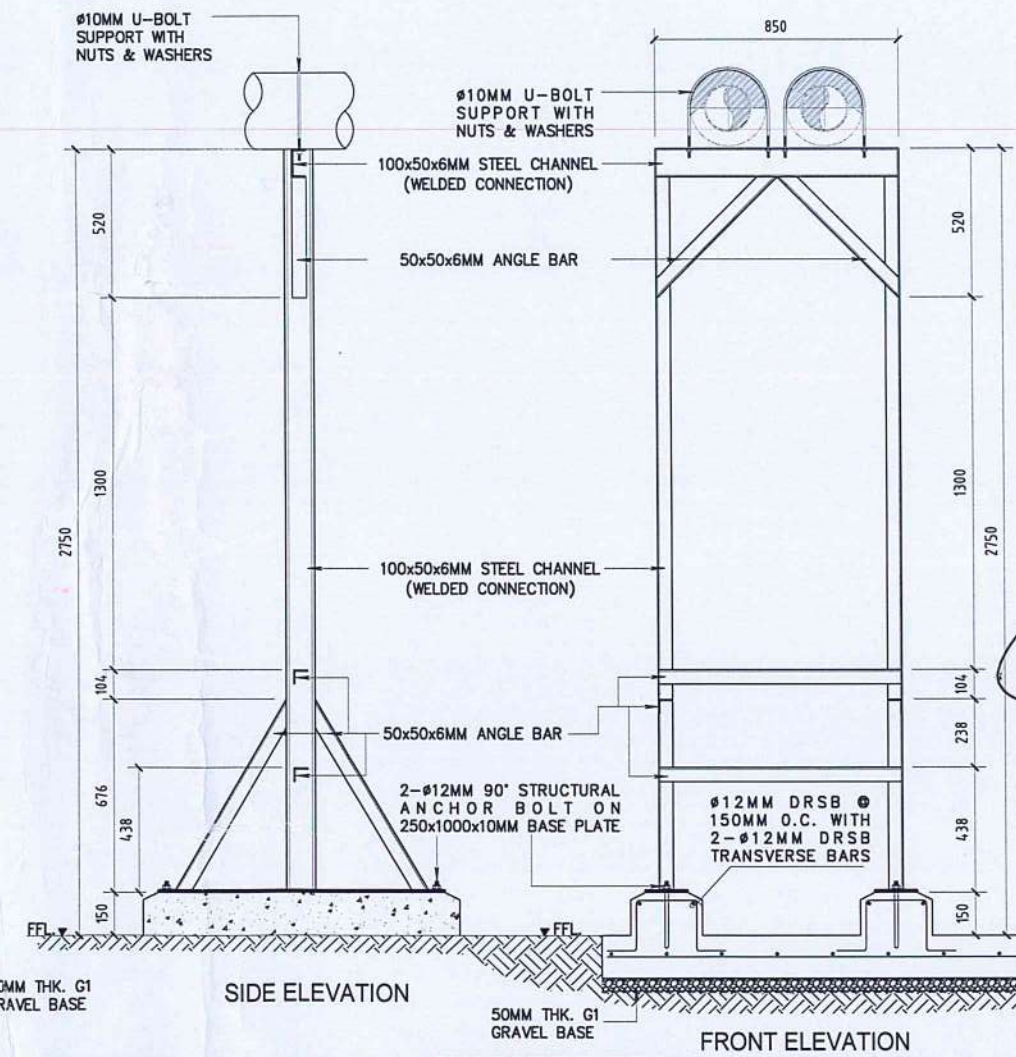

6 SUPPORT TYPE 3
ST3 ELEVATION VIEW
SCALE: 1:25M



CIVIL AVIATION AUTHORITY OF THE PHILIPPINES
1000 N. E. AVENUE, 1000 N. E. AVENUE

THIS DRAWING IS EXCLUSIVE PROPERTY OF CIVIL AVIATION AUTHORITY OF THE PHILIPPINES AND MUST NOT BE REPRODUCED, EXHIBITED, LOANED NOR COPIED IN PART OR IN WHOLE WITHOUT PROPER PERMISSION AND/OR WRITTEN CONSENT FROM THE DIRECTOR GENERAL CAAP.

AERODROME DEVELOPMENT AND MANAGEMENT SERVICE

INFRASTRUCTURE DEVELOPMENT AND DESIGN DIVISION

DESIGN STAFF:	INITIAL / DATE
DESIGNED BY: IDDD	
DRAWN BY: GOF	
CHECKED BY: EAJR	

REVIEWED BY:
RAUL R. CRUCENA
Division Chief III, AED-ADMS

SUBMITTED BY:
ARNEL F. BORLADO
Department Manager III, AED-ADMS

RECOMMENDED APPROVAL:
LT COL. VALENTINO A. DIONELA PAF (RET)
ADG II ADMS

APPROVED:
CAPTAIN MANUEL ANTONIO L. TAMAYO
Director General

APPROVED:
ATTY. ROBERTO C.O. LIM
Undersecretary for Aviation and Airports

NOTES/REVISIONS: 1. 2. 3.

PROJECT:
ILOILO INTERNATIONAL AIRPORT DEVELOPMENT PROJECT
(Rehabilitation/Improvement of Passenger Terminal Building - Supply, Installation and Commissioning of Three (3) Units 600 KW Chiller)

LOCATION:
ILOILO INTERNATIONAL AIRPORT
CABATUAN, ILOILO

SHEET CONTENTS:
CONCRETE PAD LAYOUT
DETAILED SECTIONS

DRAWING SCALE:	SHEET NO:
AS SHOWN	S - 2
	02 02