



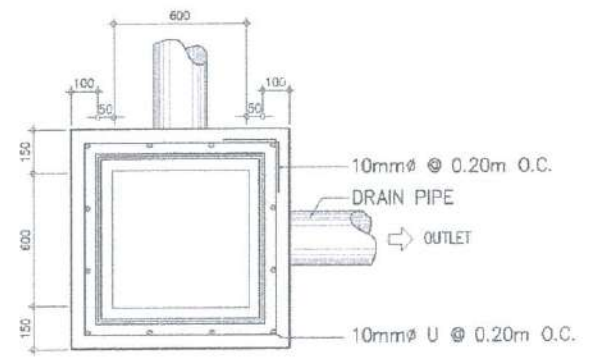


PLAN

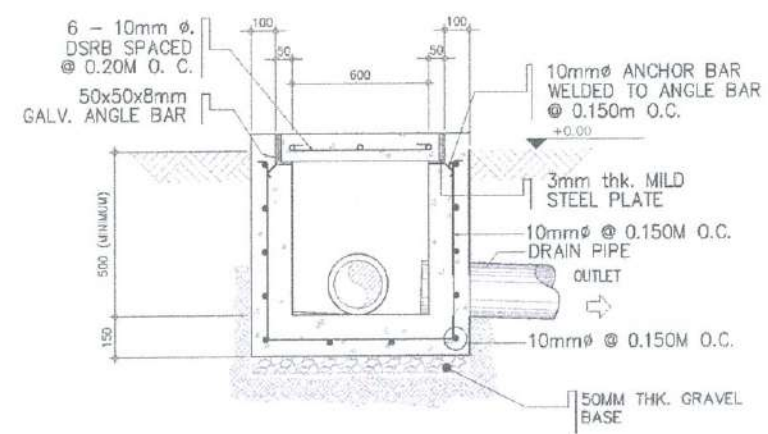


SECTION


CATCH BASIN

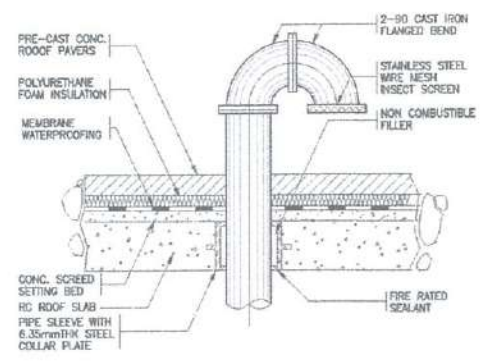

VENT THRU ROOF

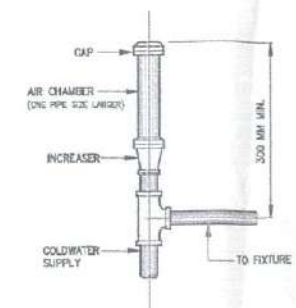


AIR CHAMBER

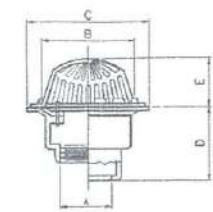


PIPE SIZE A (mm)	DIMENSION (mm)				REMARKS
B	C	D	E	F	
50	165	178	82	79	SIMILAR TO MODEL JPH-123 OR APPROVED EDAL
75	165	178	82	79	
100	165	178	82	79	
200	240	254	82	97	


GUTTER DRAIN

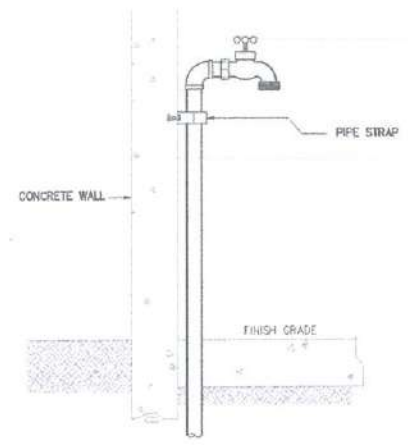


HOSE BIBB

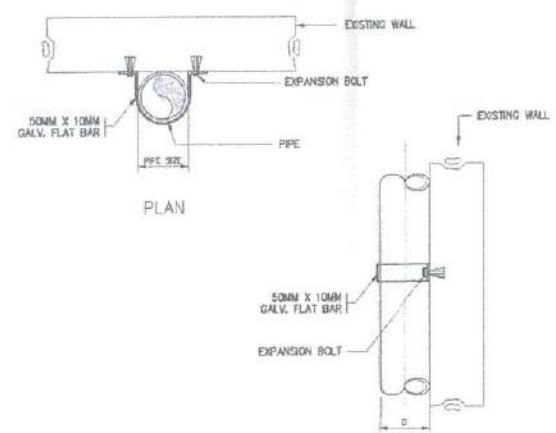


PIPE CLAMP

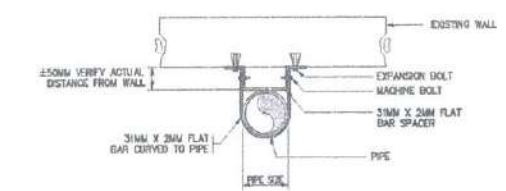


OFFSET CLAMP

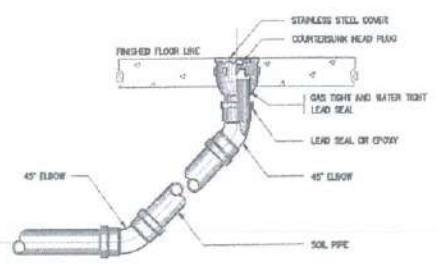

FLOOR CLEAN-OUT

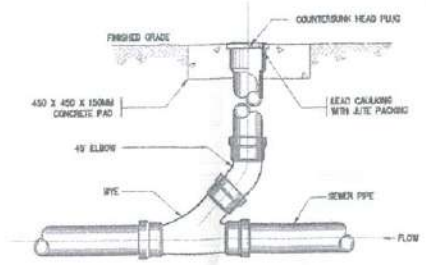

GROUND CLEAN-OUT

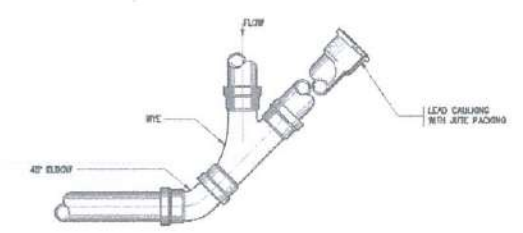

STACK CLEAN-OUT




REPUBLIC OF THE PHILIPPINES

CIVIL AVIATION AUTHORITY OF THE PHILIPPINES
AERODROME DEVELOPMENT AND MANAGEMENT SERVICE
NAIA ROAD, 1350 PASAY CITY

THIS DRAWINGS AND DESIGN IS EXCLUSIVE PROPERTIES OF CIVIL AVIATION AUTHORITY OF THE PHILIPPINES AND SUCH MUST NOT BE REPRODUCED, EXHIBITED, LOANED NOR COPIED IN PART OR IN WHOLE WITHOUT PROPER PERMISSION AND/OR WRITTEN CONSENT FROM THE DIRECTOR GENERAL CAAP.

AERODROME DEVELOPMENT AND MANAGEMENT SERVICE

INFRASTRUCTURE DEVELOPMENT AND DESIGN DIVISION

DESIGN STAFF: INITIAL / DATE

DESIGNED BY: IDDD

DRAWN BY: JCDS

CHECKED BY: CDJS

EJDI

REVIEWED BY:

RAUL R. CRUCENA
Division Chief, IDDD-AED

SUBMITTED BY:

ARNEL F. BORLADO
Department Manager III, AED-ADMS

RECOMMEND APPROVAL:

LT COL. VALENTINO A. DIONELA PAF (RET)
Assistant Director General II, ADMS

APPROVED BY:

CAPTAIN MAURICIO ANTONIO L. TAMAYO
Director General

NOTES/REVISIONS:

PROJECT:

IMPROVEMENT/REHABILITATION OF AIRWAYS FACILITY COMPLEX BUILDING

LOCATION:

CAAP CENTRAL OFFICE
NAIA RD. COR. N. AQUINO AVENUE,
PASAY CITY

SHEET CONTENTS:

DRAWING SCALE:	SHEET NO:
	P 015




SITE

**1 AIRWAYS FACILITY COMPLEX
EXTERIOR PERSPECTIVE**
SCALE: NTS



2 VICINITY MAP
SCALE: NTS

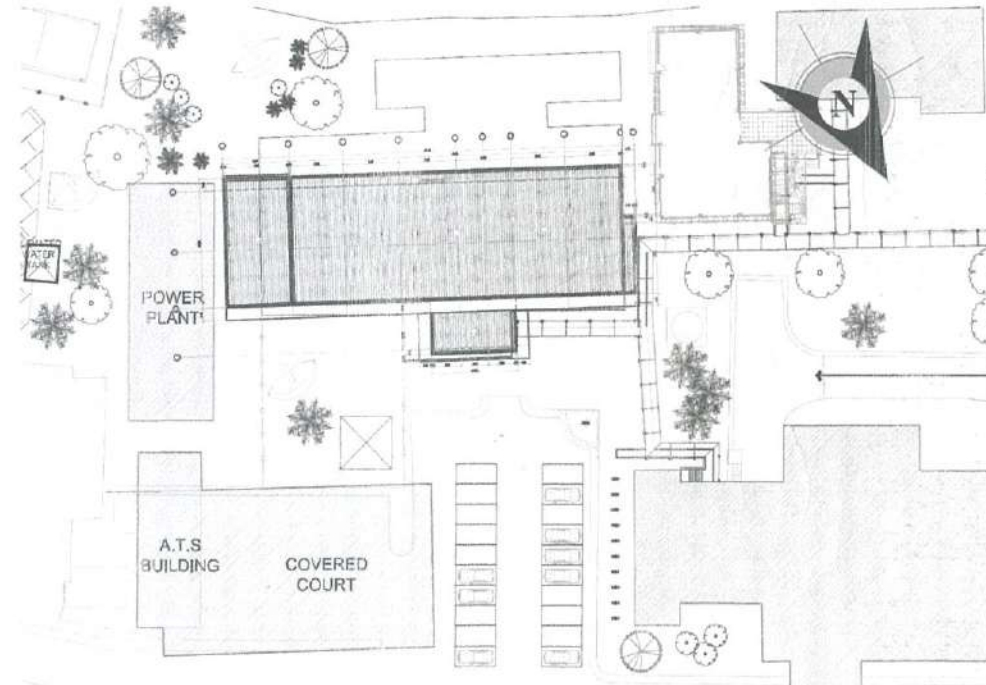

3 PLAN ON SITE
SCALE: 1 : 500 M

REPUBLIC OF THE PHILIPPINES DEPARTMENT OF TRANSPORTATION OFFICE OF THE BUILDING OFFICIALS	 
DISTRICT/CITY/MUNICIPALITY	REPUBLIC OF THE PHILIPPINES CIVIL AVIATION AUTHORITY OF THE PHILIPPINES AERODROME DEVELOPMENT AND MANAGEMENT SERVICE NAIA RD., COR. N. AQUINO AVENUE, PASAY CITY
LAND USE & ZONING	THIS DRAWING AND DESIGN IS EXCLUSIVE PROPERTY OF CIVIL AVIATION AUTHORITY OF THE PHILIPPINES AND SUCH MUST NOT BE REPRODUCED, EXHIBITED, LOANED NOR COPIED IN PART OR IN WHOLE WITHOUT PROPER PERMISSION AND/OR WRITTEN CONSENT FROM THE DIRECTOR GENERAL CAAP.
LINE & GRADE	AERODROME DEVELOPMENT AND MANAGEMENT SERVICE INFRASTRUCTURE DEVELOPMENT AND DESIGN DIVISION DESIGN STAFF: INITIAL / DATE DESIGNED BY: IDDO DRAWN BY: DRPGMPLR CHECKED BY:
ARCHITECTURAL	REVIEWED BY:  RAY E. CRUCERA Division Chief III, IDDO/AAED
CIVIL / STRUCTURAL	SUBMITTED BY:  ARNEL F. BORLADO Department Manager III, ASD-ADMS
ELECTRICAL	RECOMMEND APPROVAL:  LT COL VALENTINO A. DIONELA PAF (RET) Assistant Director General II, ADMS
MECHANICAL	APPROVED BY:  CAPTAIN MANGEL ANTONIO L. TAVAYO Director General
SANITARY	NOTES/REVISIONS:
ELECTRONICS	PROJECT: IMPROVEMENT/REHABILITATION OF AIRWAYS FACILITY COMPLEX BUILDING
GEODETIC ENGINEER	LOCATION: CAAP CENTRAL OFFICE NAIA RD., COR. N. AQUINO AVENUE, PASAY CITY
	SHEET CONTENTS: • EXTERIOR PERSPECTIVE • VICINITY MAP • PLAN ON SITE
	DRAWING SCALE: NTS SHEET NO: TP 01 17

TABLE OF CONTENTS

I. ARCHITECTURAL		II. STRUCTURAL	
SHEET #	DESCRIPTION	SHEET #	DESCRIPTION
TP - 01	EXTERIOR PERSPECTIVE, VICINITY MAP	S - 01	CONSTRUCTION NOTES
TP - 02	PLAN ON SITE	S - 02	FOUNDATION PLAN
TP - 03	TABLE OF CONTENTS AND GENERAL NOTES	S - 03	ROOF FRAMING PLAN
TP - 04	INTERIOR PERSPECTIVES	S - 04	TRUSS DETAILS
A - 01	INTERIOR PERSPECTIVES	S - 05	STAIR DETAILS
A - 02	GROUND FLOOR DEMOLITION PLAN	S - 06	2ND FLOOR FRAMING PLAN
A - 03	SECOND FLOOR DEMOLITION PLAN	III. ELECTRICAL	
A - 03.1	PROPOSED GROUND FLOOR PLAN	SHEET # DESCRIPTION	
A - 03.2	BLOW UP OF PROPOSED GROUND FLOOR PLAN	E - 01	GENERAL NOTES, SPECIFICATIONS, LEGEND
A - 03a	BLOW UP OF PROPOSED GROUND FLOOR PLAN	E - 02	SCHEDULE OF LOADS
A - 03a.1	DETAILED GROUND FLOOR PLAN	E - 03	SCHEDULE OF LOADS
A - 03a.2	BLOW UP OF DETAILED GROUND FLOOR PLAN	E - 04	SINGLE LINE DIAGRAM
A - 04	BLOW UP OF DETAILED GROUND FLOOR PLAN	E - 05	DATA & VOICE RISER DIAGRAM, FDAS RISER DIAGRAM
A - 04.1	PROPOSED SECOND FLOOR PLAN	E - 06	PARTIAL GROUND FLOOR LIGHTING LAYOUT PLAN
A - 04.2	BLOW UP OF PROPOSED SECOND FLOOR PLAN	E - 07	PARTIAL GROUND FLOOR LIGHTING LAYOUT PLAN
A - 04a	BLOW UP OF PROPOSED SECOND FLOOR PLAN	E - 08	PARTIAL SECOND FLOOR LIGHTING LAYOUT PLAN
A - 04a.1	DETAILED SECOND FLOOR PLAN	E - 09	PARTIAL SECOND FLOOR LIGHTING LAYOUT PLAN
A - 04a.2	BLOW UP OF DETAILED SECOND FLOOR PLAN	E - 10	PARTIAL GROUND FLOOR POWER LAYOUT PLAN
A - 05	BLOW UP OF DETAILED SECOND FLOOR PLAN	E - 11	PARTIAL GROUND FLOOR POWER LAYOUT PLAN
A - 05.1	GROUND FLOOR REFLECTED CEILING PLAN	E - 12	PARTIAL SECOND FLOOR POWER LAYOUT PLAN
A - 05.2	BLOW UP OF GROUND FLOOR REFLECTED CEILING PLAN	E - 13	PARTIAL SECOND FLOOR POWER LAYOUT PLAN
A - 06	BLOW UP OF GROUND FLOOR REFLECTED CEILING PLAN	E - 14	GROUND FLOOR DATA & VOICE SYSTEM LAYOUT PLAN
A - 06.1	SECOND FLOOR REFLECTED CEILING PLAN	E - 15	GROUND FLOOR DATA & VOICE SYSTEM LAYOUT PLAN
A - 06.2	BLOW UP OF SECOND FLOOR REFLECTED CEILING PLAN	E - 16	SECOND FLOOR DATA & VOICE SYSTEM LAYOUT PLAN
A - 07	BLOW UP OF SECOND FLOOR REFLECTED CEILING PLAN	E - 17	SECOND FLOOR DATA & VOICE SYSTEM LAYOUT PLAN
A - 08	ROOF PLAN	E - 18	PARTIAL GROUND FLOOR FDAS LAYOUT PLAN
A - 09	FRONT & REAR ELEVATION	E - 19	PARTIAL GROUND FLOOR FDAS LAYOUT PLAN
A - 10	RIGHT & LEFT SIDE ELEVATION	E - 20	PARTIAL SECOND FLOOR FDAS LAYOUT PLAN
A - 11	LONGITUDINAL SECTIONS	E - 21	PARTIAL SECOND FLOOR FDAS LAYOUT PLAN
A - 12	CROSS SECTIONS & BLOW-UP SECTIONS	IV. MECHANICAL	
A - 13	GROUND FLOOR SIGNAGE LAYOUT PLAN	SHEET # DESCRIPTION	
A - 13a	SECOND FLOOR SIGNAGE LAYOUT PLAN	M - 01	GROUND FLOOR AIR CONDITIONING LAYOUT
A - 13b	SIGNAGE DETAILS	M - 02	SECOND FLOOR AIR CONDITIONING LAYOUT
A - 14	SIGNAGE DETAILS	M - 03	GROUND FLOOR ACU CONDENSATE DRAIN PIPE LAYOUT
A - 15a	SCHEDULE OF DOORS & WINDOWS	M - 04	SECOND FLOOR ACU CONDENSATE DRAIN PIPE LAYOUT
A - 15b	TOILET DETAILS	M - 05	GROUND FLOOR VENTILATION LAYOUT
A - 15c	TOILET DETAILS	M - 06	SECOND FLOOR VENTILATION LAYOUT
A - 15d	TOILET DETAILS	M - 07	GENERAL NOTES, LEGENDS & SYMBOLS, EQUIPMENT SCHEDULE
A - 16	TOILET DETAILS	M - 08	MISCELLANEOUS DETAILS
A - 17	SCHEDULE OF FURNITURES	V. PLUMBING	
A - 17a	SCHEDULE OF FURNITURES	SHEET # DESCRIPTION	
A - 18	STAIR DETAILS	P - 01	GENERAL NOTES
		P - 02	GROUND FLOOR SEWER LINE LAYOUT
		P - 03	SECOND FLOOR SEWER LINE LAYOUT
		P - 04	ENLARGED SEWER LINE LAYOUT AND ISOMETRIC VIEW
		P - 05	ENLARGED SEWER LINE LAYOUT AND ISOMETRIC VIEW
		P - 06	ENLARGED SEWER LINE LAYOUT AND ISOMETRIC VIEW
		P - 07	GROUND FLOOR COLD WATER LINE LAYOUT
		P - 08	SECOND FLOOR COLD WATER LINE LAYOUT
		P - 09	ENLARGED CWL LAYOUT AND ISOMETRIC VIEW
		P - 10	ENLARGED CWL LAYOUT AND ISOMETRIC VIEW
		P - 11	ENLARGED CWL LAYOUT AND ISOMETRIC VIEW
		P - 12	STORM DRAIN LINE LAYOUT
		P - 13	STORM DRAIN LINE LAYOUT ISOMETRIC VIEW
		P - 14	SEPTIC TANK DETAILS
		P - 15	MISCELLANEOUS DETAILS

GENERAL NOTES

1. THE CONTRACTOR SHALL VISIT THE JOBSITE AND SHALL BE RESPONSIBLE FOR THE VERIFICATIONS OF ALL GRADES, CONDITIONS AND DIMENSIONS PRIOR TO COMMENCING CONSTRUCTION.
2. ALL WRITTEN DIMENSIONS SHALL TAKE PRECEDENCE OVER SCALED DIMENSIONS.
3. THE CONTRACTOR SHALL COORDINATE AND VERIFY WITH THE PLUMBING, ELECTRICAL CONTRACTORS THE SIZE AND LOCATION OF ALL PIPING, SLEEVES, SPECIAL BOLTING.
4. THE CONTRACTOR SHALL BE RESPONSIBLE FOR THE PROTECTION OF PUBLIC AND PRIVATE WORK AREA AND SHALL EXERCISE DUE CAUTION TO AVOID SUCH DAMAGE TO PROPERTIES.
5. VERIFY ACTUAL SITE CONDITION PRIOR TO START OF CONSTRUCTION; REFER TO DETAILED PLANS TO DOUBLE CHECK ON SITE MAJOR DEVIATIONS (IF ANY) ON THE ACTUAL LOCATIONS AND HEADROOM CLEARANCES OF ALL UTILITY PROVISIONS.
6. CONTRACTOR SHALL VERIFY/FOLLOW ALL NATIONAL & LOCAL BUILDING CODES, REQUIREMENTS AND RESTRICTIONS.
7. VERIFY AND FOLLOW PROVISIONS AS PRESCRIBED ON THE ISSUED O.B.O. GUIDELINES RELATIVE TO REQUIREMENT AND RESTRICTIONS.
8. VERIFY AND RE-CHECK ACTUAL EXTENT OF LOT LINE; NO PROJECTIONS BEYOND LOT LINE ARE ALLOWED.
9. PLANS SHALL ALWAYS BE PRESENT ON SITE FOR CONSTRUCTION MONITORING AND AS A BASIS FOR CONSTRUCTION.
10. ONLY NEW, FIRST CLASS MATERIALS, EQUIPMENT, FIXTURES, INCLUDING TRADE FIXTURES AND FURNISHINGS SHALL BE USED IN THE PREMISES.
11. ALL MATERIALS FOR INTERIOR FINISH (WALL SYSTEM, CEILING SYSTEM, FURNITURE FLOORING INCLUSIVE OF ADHESIVE, COATINGS, SEALERS, GROUT, ETC.) SHALL BE USING LOW-VOC COMPONENTS; ALL MATERIALS SHALL BE NON-COMBUSTIBLE AND NON-ASBESTOS TYPE OF MATERIALS.
12. ALL WOOD FINISHES/MATERIALS SHOULD BE KILN DRIED, MILL QUALITY FINISH.
13. CEILING CONSTRUCTION SHOULD BE NON-COMBUSTIBLE. NO WOOD SHALL BE USED ABOVE THE CEILING.
14. ALL CEILING FRAMING, HANGERS AND SUPPORT SHOULD BE METAL OR RODS WHICH IS PAINTED WITH EPOXY PRIMER IF MATERIALS DID NOT RECEIVE ANY FACTORY COATING. WOOD AND G.I. WIRES ARE NOT ALLOWED AS CEILING HANGERS AND FRAMING.
15. ALL LIGHTING MATERIALS MUST BE NON-COMBUSTIBLE. ALL BALLAST & TRANSFORMERS OF LIGHTING FIXTURES SHALL BE PROVIDED WITH METAL PLATFORM/BACKING MATERIALS.
16. ALL PLANS WITH COMMENTS OF O.B.O. MUST ALWAYS BE PRESENT ON SITE PRIOR TO CONSTRUCTION MONITORING AND AS A BASIS OF CONSTRUCTION.
17. ALL CONSTRUCTION MATERIALS, FIXTURES, FURNITURE, EQUIPMENT, FINISHES, MECHANISMS, ETC. OF ALL DISCIPLINES SHALL BE APPROVED BY CAAP PROJECT-IN-CHARGE PRIOR TO INSTALLATION.
18. PROVIDE A MINIMUM OF 9 CONCRETE CYLINDER SAMPLES PER BATCH MIX THAT WILL BE SUBJECTED TO MATERIAL TESTING ON 7TH, 14TH AND 28TH DAY FOR COMPRESSIVE STRENGTH (VERIFY STRUCTURAL FOR PSI) AT ANY DPWH ACCREDITED MATERIAL TESTING LABORATORY. THE POURED CONCRETE ON THE STRUCTURAL MEMBERS WILL BE SUBJECTED TO RETROFITTING OR REPLACEMENT AT CONTRACTOR'S EXPENSE IF THE MATERIAL TESTING RESULT WILL NOT MEET THE DESIGN STRENGTH AS INDICATED ON PLANS.



REPUBLIC OF THE PHILIPPINES
CIVIL AVIATION AUTHORITY OF THE PHILIPPINES
AERODROME DEVELOPMENT AND MANAGEMENT SERVICE
NAIA ROAD, 1551 PASAY CITY

THIS DRAWING AND DESIGN IS EXCLUSIVE PROPERTY OF CIVIL AVIATION AUTHORITY OF THE PHILIPPINES AND SUCH MUST NOT BE REPRODUCED, EXHIBITED, LOANED, COPIED IN PART OR IN WHOLE WITHOUT PROPER PERMISSION AND/OR WRITTEN CONSENT FROM THE DIRECTOR GENERAL CAAP.

AERODROME DEVELOPMENT AND MANAGEMENT SERVICE

INFRASTRUCTURE DEVELOPMENT AND DESIGN DIVISION

DESIGN STAFF: INITIAL / DATE

DESIGNED BY: IDDD

DRAWN BY: DRPSMPER

CHECKED BY:

REVIEWED BY:

RAUL R. CRUCENA
Division Chief, IDDD/ADM

SUBMITTED BY:

ARNEL F. BORLADO
Department Manager III, ASD/ADM

RECOMMEND APPROVAL:

LT COL VALENTINO A. DIONELA PAF, RET.
Assistant Director General III, ADM

APPROVED BY:

CAPTAIN MANUEL ANTONIO L. TAMAYO
Project Engineer

NOTES/REVISIONS:

PROJECT:

IMPROVEMENT/REHABILITATION OF AIRWAYS FACILITY COMPLEX BUILDING

LOCATION:

CAAP CENTRAL OFFICE
NAIA RD. COR. N. AQUINO AVENUE,
PASAY CITY

SHEET CONTENTS:


• TABLE OF CONTENTS
• GENERAL NOTES

DRAWING SCALE: SHEET NO.

NTS TP
02 17



1
TP-02 TP-03
CSIS ADMIN OFFICE
INTERIOR PERSPECTIVE
SCALE: NTS

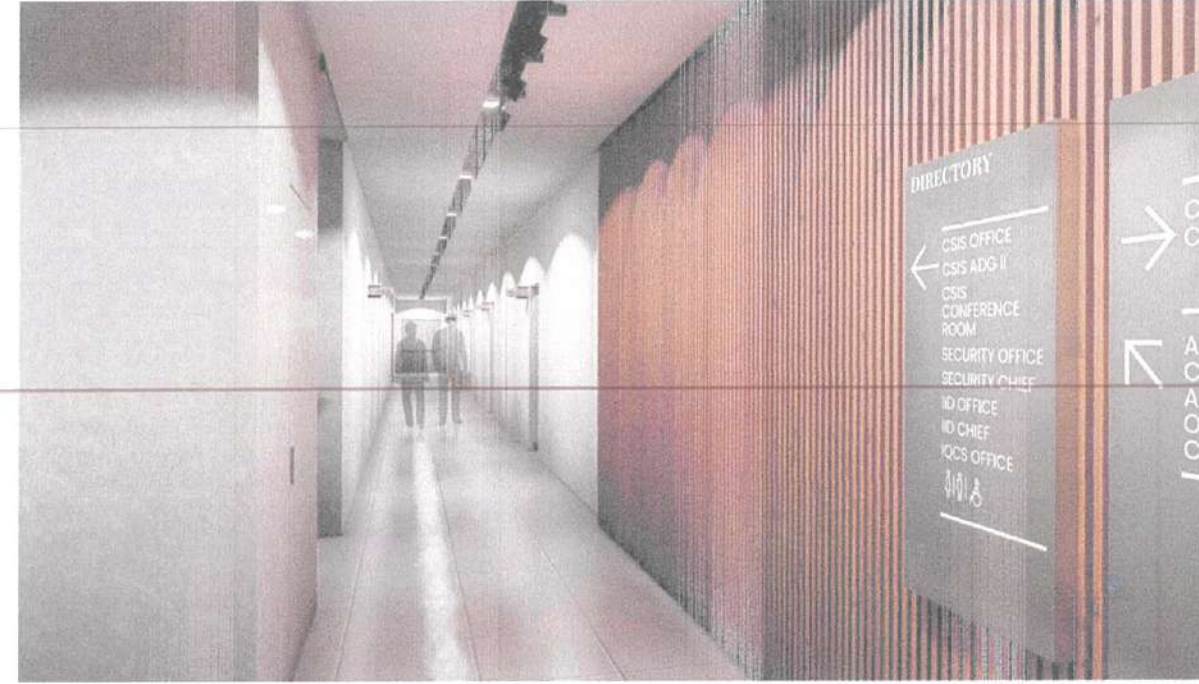

2
TP-02 TP-03
GROUND FLOOR HALLWAY
INTERIOR PERSPECTIVE
SCALE: NTS



3
TP-02 TP-03
LOBBY
INTERIOR PERSPECTIVE
SCALE: NTS



3
TP-02 TP-03
SECOND FLOOR HALLWAY
INTERIOR PERSPECTIVE
SCALE: NTS



REPUBLIC OF THE PHILIPPINES
CIVIL AVIATION AUTHORITY OF THE PHILIPPINES
AERODROME DEVELOPMENT AND MANAGEMENT SERVICE
NAIA RD. 1568 PASAY CITY

THIS DRAWING AND DESIGN IS EXCLUSIVE PROPERTY OF CIVIL AVIATION AUTHORITY OF THE PHILIPPINES AND SUCH MUST NOT BE REPRODUCED, EXHIBITED, LOANED NOR COPIED IN PART OR IN WHOLE WITHOUT PROPER PERMISSION AND/OR WRITTEN CONSENT FROM THE DIRECTOR GENERAL CAA.

AERODROME DEVELOPMENT AND MANAGEMENT SERVICE

INFRASTRUCTURE DEVELOPMENT AND DESIGN DIVISION

DESIGN STAFF	INITIAL / DATE
DESIGNED BY: IDDD	
DRAWN BY: DRPG/MLR	
CHECKED BY:	

REVIEWED BY:

[Signature]
RAMEL R. CRUCENA
Division Chief III, IDDD-AED

SUBMITTED BY:

[Signature]
ARNEL F. BORLADO
Department Manager III, AED-ADMS

RECOMMEND APPROVAL:

[Signature]
LT COL VALENTINO A. DIONELA PAF (RET)
Assistant Director General R. ADMS

APPROVED BY:

[Signature]
CAPTAIN RAFAEL ANTONIO L. TAYAYO
General

NOTES/REVISIONS:

PROJECT:
IMPROVEMENT/REHABILITATION OF AIRWAYS FACILITY COMPLEX BUILDING

LOCATION:
CAAP CENTRAL OFFICE
NAIA RD. COR. N. AQUINO AVENUE,
PASAY CITY

SHEET CONTENTS:
INTERIOR PERSPECTIVES

DRAWING SCALE:	SHEET NO:
NTS	TP 03 17



1
TP-01 TP-02
COA OFFICE
INTERIOR PERSPECTIVE
SCALE: NTS



2
TP-03 TP-04
COA CHIEF OFFICE
INTERIOR PERSPECTIVE
SCALE: NTS




3
TP-05 TP-06
AAIB OFFICE
INTERIOR PERSPECTIVE
SCALE: NTS




4
TP-07 TP-08
OPEN OFFICE
INTERIOR PERSPECTIVE
SCALE: NTS

 	
REPUBLIC OF THE PHILIPPINES CIVIL AVIATION AUTHORITY OF THE PHILIPPINES AERODROME DEVELOPMENT AND MANAGEMENT SERVICE NAIA ROAD - 1305 PASAY CITY	
THIS DRAWINGS AND DESIGN IS EXCLUSIVE PROPERTY OF CIVIL AVIATION AUTHORITY OF THE PHILIPPINES AND SUCH MUST NOT BE REPRODUCED, EXHIBITED, LOANED NOR COPIED IN PART OR IN WHOLE WITHOUT PROPER PERMISSION AND/OR WRITTEN CONSENT FROM THE DIRECTOR GENERAL CAA.	
AERODROME DEVELOPMENT AND MANAGEMENT SERVICE	
INFRASTRUCTURE DEVELOPMENT AND DESIGN DIVISION	
DESIGN STAFF:	INITIAL / DATE
DESIGNED BY:	BDG
DRAWN BY:	DRP/MLP
CHECKED BY:	
REVIEWED BY:  RAUL R. CRUZ Director General III, AED-AMS	
SUBMITTED BY:  ARNEL F. BORLADO Department Manager III, AED-AMS	
RECOMMEND APPROVAL:  LT COL. VALENTINO A. DIONELA PAF (RET) Assistant Director General B, AED-AMS	
APPROVED BY:  CAPTAIN MANUEL ANTONIO L. TAMAYO Director General	
NOTES/REVISIONS:	
PROJECT: IMPROVEMENT/REHABILITATION OF AIRWAYS FACILITY COMPLEX BUILDING	
LOCATION: CAAP CENTRAL OFFICE NAIA RD., COR. N. AQUINO AVENUE, PASAY CITY	
SHEET CONTENTS: INTERIOR PERSPECTIVES	
DRAWING SCALE:	SHEET NO:
NTS	TP 04 17

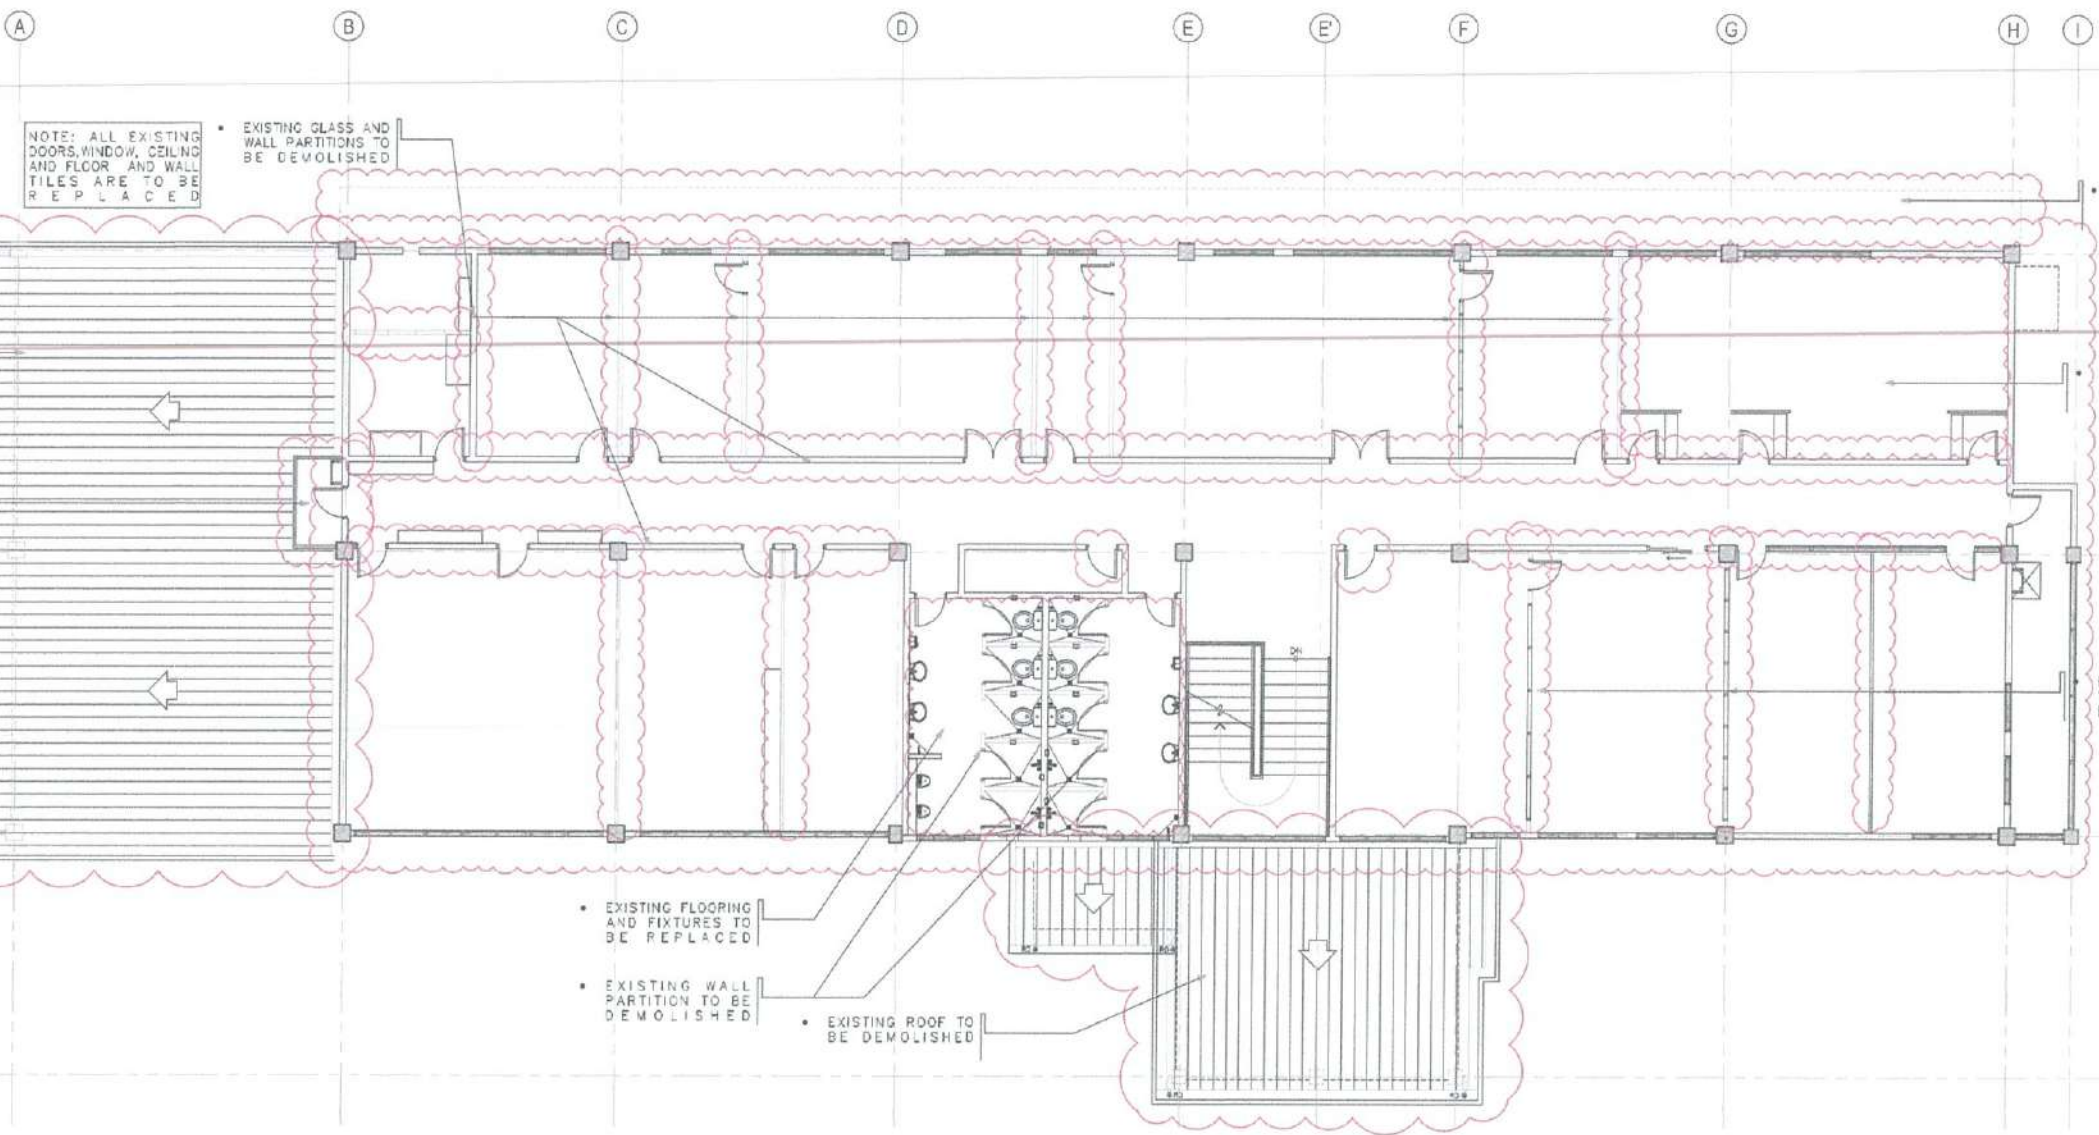

1
A-02 A-02
**SECOND FLOOR
DEMOLITION PLAN**
SCALE: 1:100 M

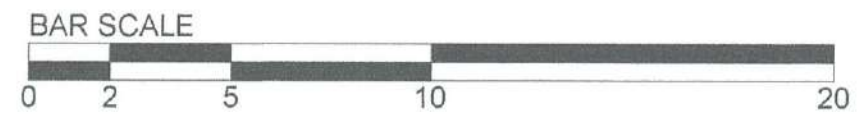




REPUBLIC OF THE PHILIPPINES
CIVIL AVIATION AUTHORITY OF THE PHILIPPINES
AERODROME DEVELOPMENT AND ARRANGEMENT SERVICE
NAIA ROAD, 1500 PASAY CITY

THIS DRAWINGS AND DESIGN IS EXCLUSIVE PROPERTIES OF CIVIL AVIATION AUTHORITY OF THE PHILIPPINES AND SUCH MUST NOT BE REPRODUCED, EXHIBITED, LOANED NOR COPIED IN PART OR IN WHOLE WITHOUT PROPER PERMISSION AND/OR WRITTEN CONSENT FROM THE DIRECTOR GENERAL CAAP.

AERODROME DEVELOPMENT AND MANAGEMENT SERVICE

INFRASTRUCTURE DEVELOPMENT AND DESIGN DIVISION

DESIGN STAFF:	INITIAL / DATE
DESIGNED BY: IDDD	
DRAWN BY: DRPGMPLR	
CHECKED BY:	

REVIEWED BY:


RAUL R. CRUZENA
Division Chief, IDDD-AED

SUBMITTED BY:


ARNEL F. BORLADO
Department Manager III, AED-ADMS

RECOMMEND APPROVAL:


LT COL. VALENTINO A. DIONELA PAF (RET)
Assistant Director General II, ADMS

APPROVED BY:


CAPTAIN MANUEL ANTONIO L. TAMAYO
Director General


NOTES/REVISIONS:

PROJECT:
IMPROVEMENT/REHABILITATION OF AIRWAYS FACILITY COMPLEX BUILDING


LOCATION:
CAAP CENTRAL OFFICE
NAIA RD. COR. N. AQUINO AVENUE,
PASAY CITY

SHEET CONTENTS:
• SECOND FLOOR DEMOLITION PLAN

DRAWING SCALE:	SHEET NO.
1:100 M	A
	2 17

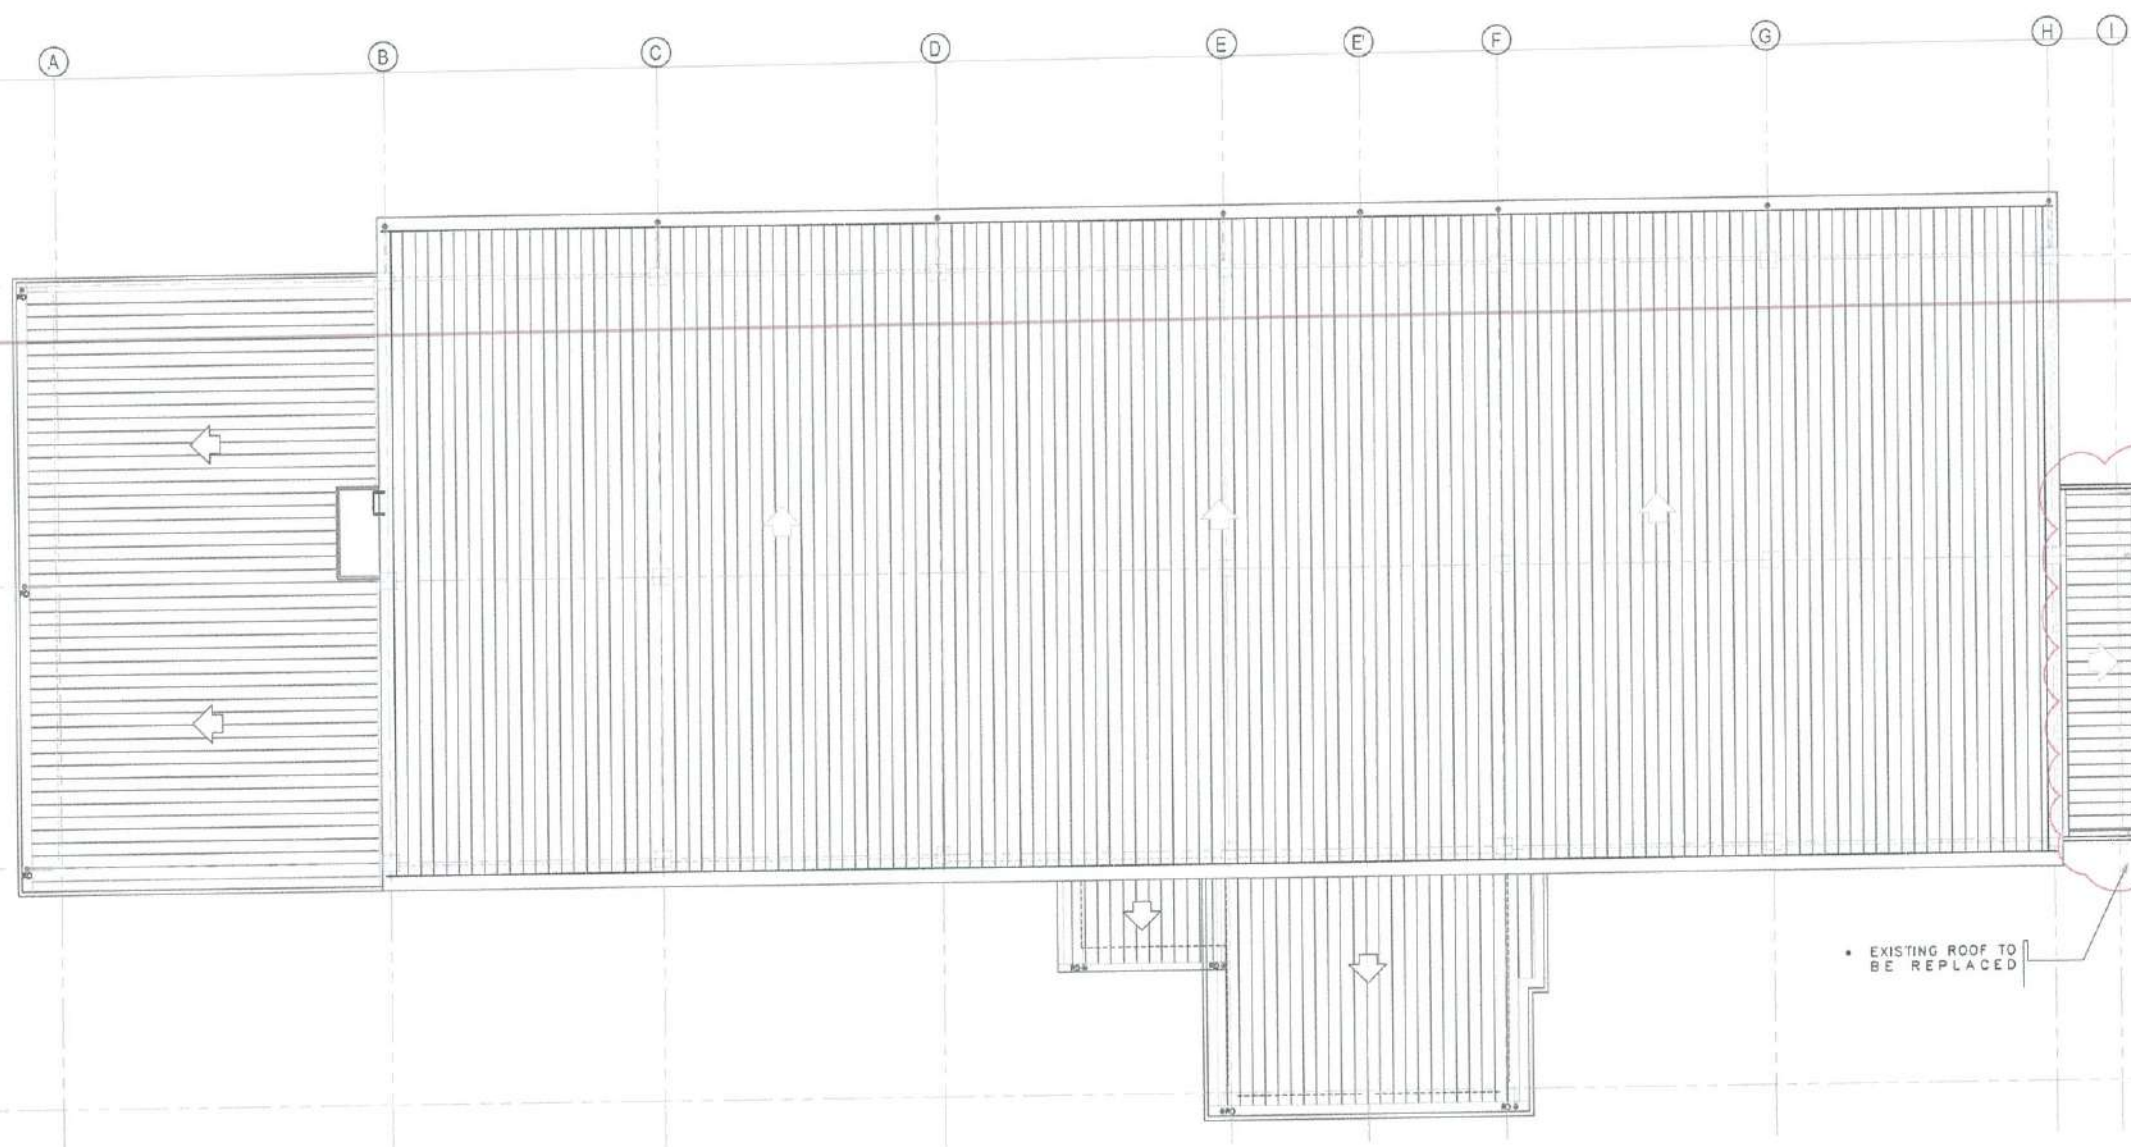

 1
A-02a A-02b
EXISTING ROOF
DEMOLITION PLAN
SCALE: 1:100 M



 	
REPUBLIC OF THE PHILIPPINES CIVIL AVIATION AUTHORITY OF THE PHILIPPINES AERODROME DEVELOPMENT AND MANAGEMENT SERVICE RAJA ROAD, 1386 PASAY CITY	
THIS DRAWING AND DESIGN IS EXCLUSIVE PROPERTY OF CIVIL AVIATION AUTHORITY OF THE PHILIPPINES AND SUCH MUST NOT BE REPRODUCED, EXHIBITED, LOANED NOR COPIED IN PART OR IN WHOLE WITHOUT PROPER PERMISSION AND/OR WRITTEN CONSENT FROM THE DIRECTOR GENERAL CAAP.	
AERODROME DEVELOPMENT AND MANAGEMENT SERVICE	
INFRASTRUCTURE DEVELOPMENT AND DESIGN DIVISION	
DESIGN STAFF:	INITIAL / DATE
DESIGNED BY:	IDDD
DRAWN BY:	DRPG/MLR <i>W. 12/24</i>
CHECKED BY:	
REVIEWED BY:	
 RAUL R. CRUCENA Division Chief, IDDD-AED	
SUBMITTED BY:	
 ARNEL F. BORLADO Department Manager III, AED-ADMS	
RECOMMEND APPROVAL:	
 LT. COL. VALENTINO A. DIONELA PAF (RET) Assistant Director General II, ADMS	
APPROVED BY:	
 CAPTAIN MANUEL ANTONIO L. TAMAYO Director General	
NOTES/REVISIONS:	
PROJECT: IMPROVEMENT/REHABILITATION OF AIRWAYS FACILITY COMPLEX BUILDING	
LOCATION: CAAP CENTRAL OFFICE NAIA RD. COR. N. AQUINO AVENUE, PASAY CITY	
SHEET CONTENTS: • EXISTING ROOF DEMOLITION PLAN	
DRAWING SCALE:	SHEET NO:
1:100 M	A 2a 17



REPUBLIC OF THE PHILIPPINES
CIVIL AVIATION AUTHORITY OF THE PHILIPPINES
AERODROME DEVELOPMENT AND MANAGEMENT SERVICE
RAA ROAD, 1288 PASAY CITY

THIS DRAWINGS AND DESIGN IS EXCLUSIVE
PROPERTY OF CIVIL AVIATION AUTHORITY
OF THE PHILIPPINES AND SUCH MUST NOT BE
REPRODUCED, EXHIBITED, LOANED NOR
COPIED IN PART OR IN WHOLE WITHOUT
PROPER PERMISSION AND/OR WRITTEN
CONSENT FROM THE DIRECTOR GENERAL
CAAP.

AERODROME DEVELOPMENT
AND MANAGEMENT SERVICE

INFRASTRUCTURE DEVELOPMENT AND DESIGN
DIVISION

DESIGN STAFF: INITIAL / DATE
DESIGNED BY: IDDO
DRAWN BY: DRPG/MLR
CHECKED BY:

REVIEWED BY:

RAUL R. CRUZENA
Division Chief III, IDDD-AED

SUBMITTED BY:

ARNEL F. BORLADO
Department Manager III, AED-ADMS

RECOMMEND APPROVAL:

LT COL. VALENTINO A. DIONELA PAF (RET)
Assistant Director General II, ADMS

APPROVED BY:

CAPTAIN MARCEL ANTONIO L. TAMAYO
Director General

NOTES/REVISIONS:

PROJECT:

IMPROVEMENT/REHABILITATION
OF AIRWAYS FACILITY COMPLEX
BUILDING

LOCATION:


CAAP CENTRAL OFFICE
NAIA RD. COR. N. AQUINO AVENUE,
PASAY CITY

SHEET CONTENTS:


• GROUND FLOOR PLAN


DRAWING SCALE: SHEET NO.:

1 : 100 M A
03 17

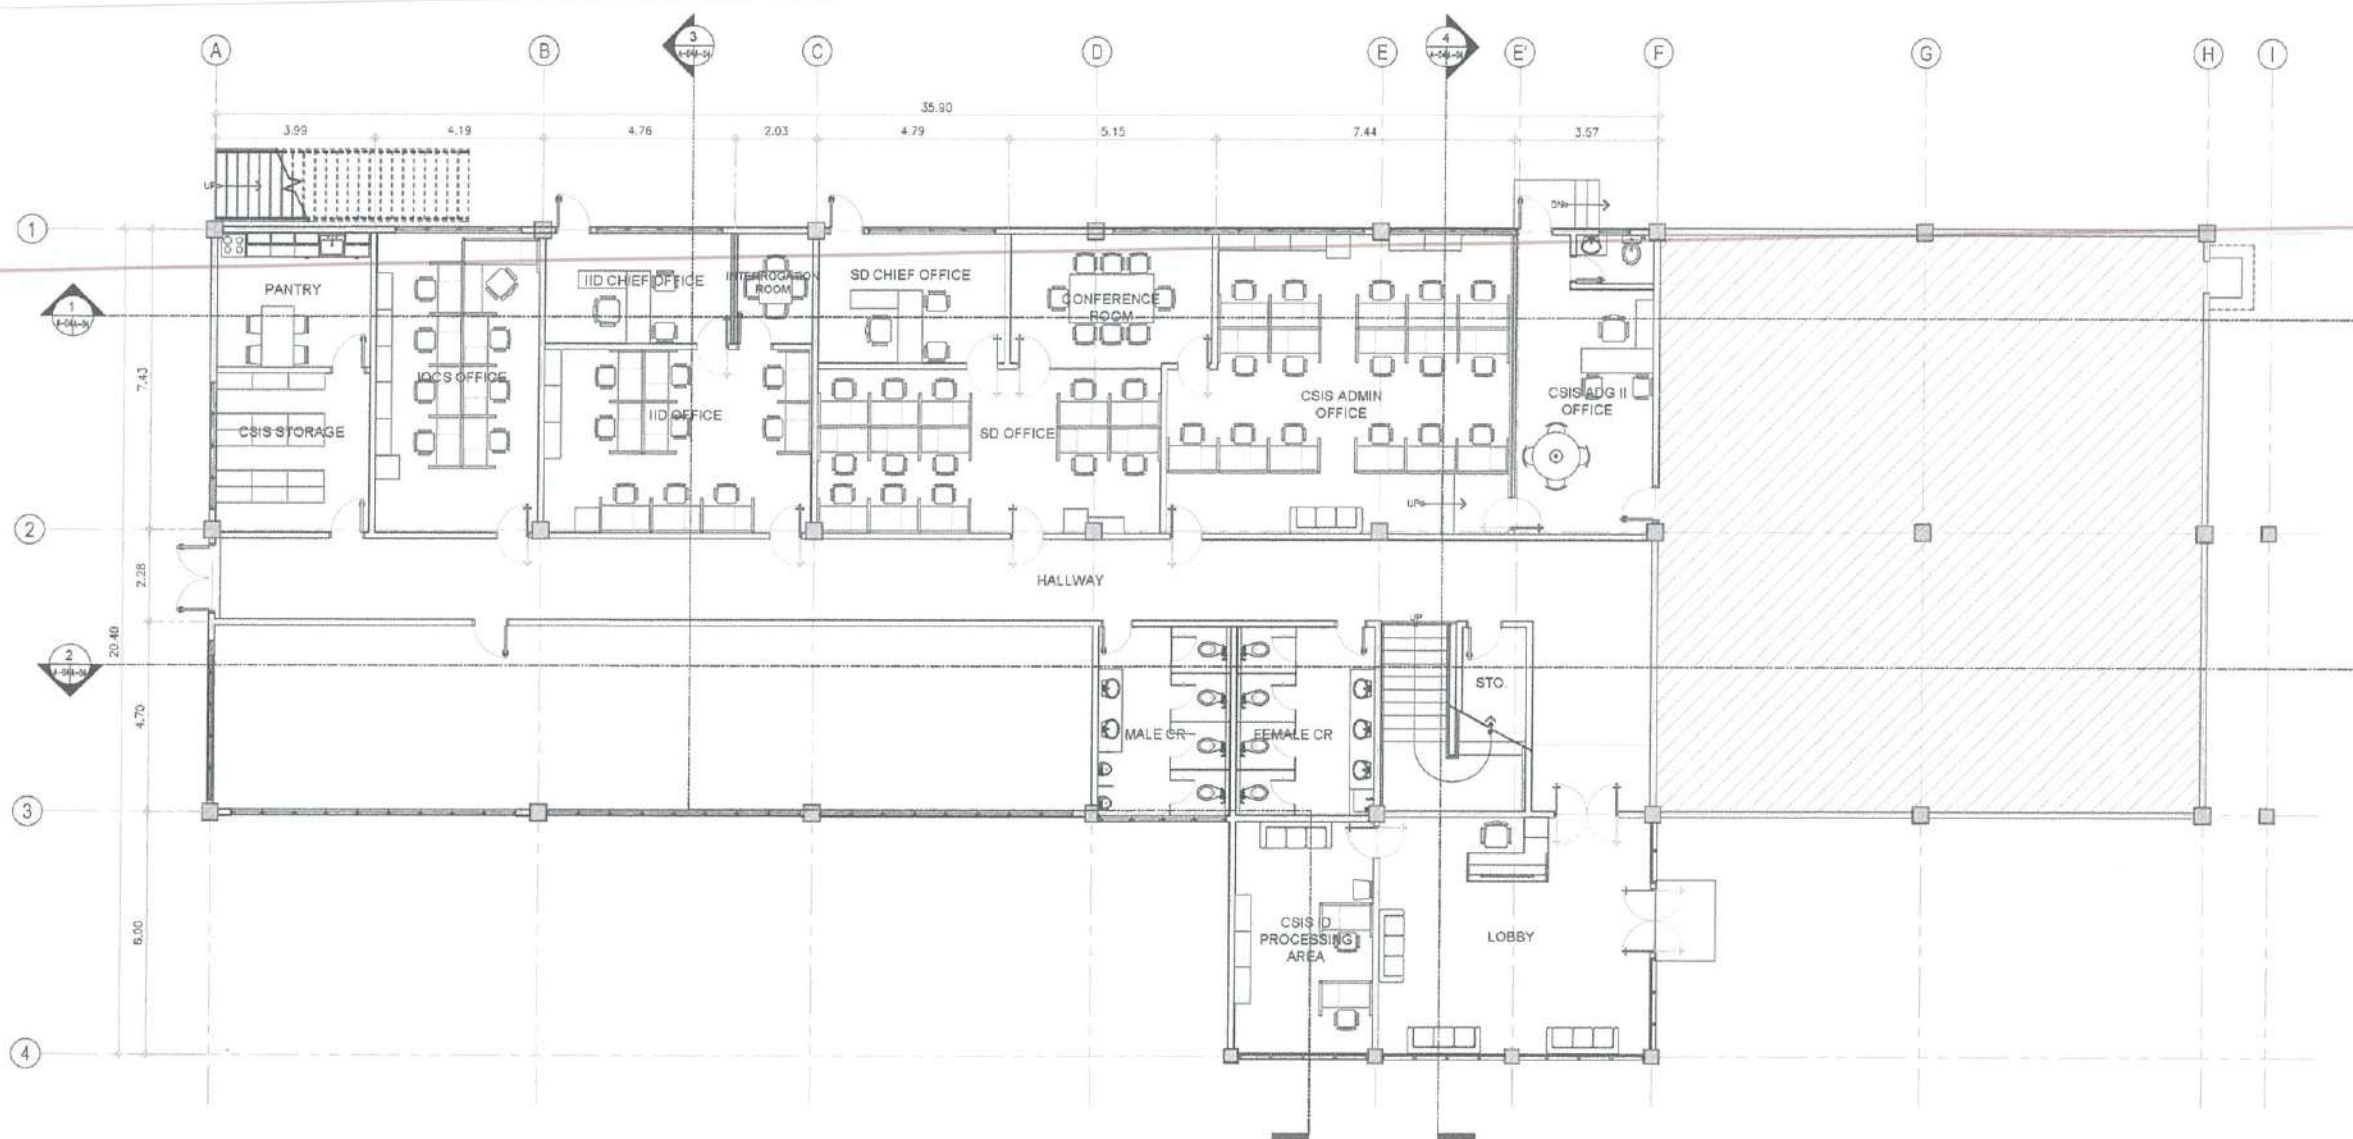

 1 GROUND FLOOR PLAN
A-03 A-03 SCALE: 1:100 M



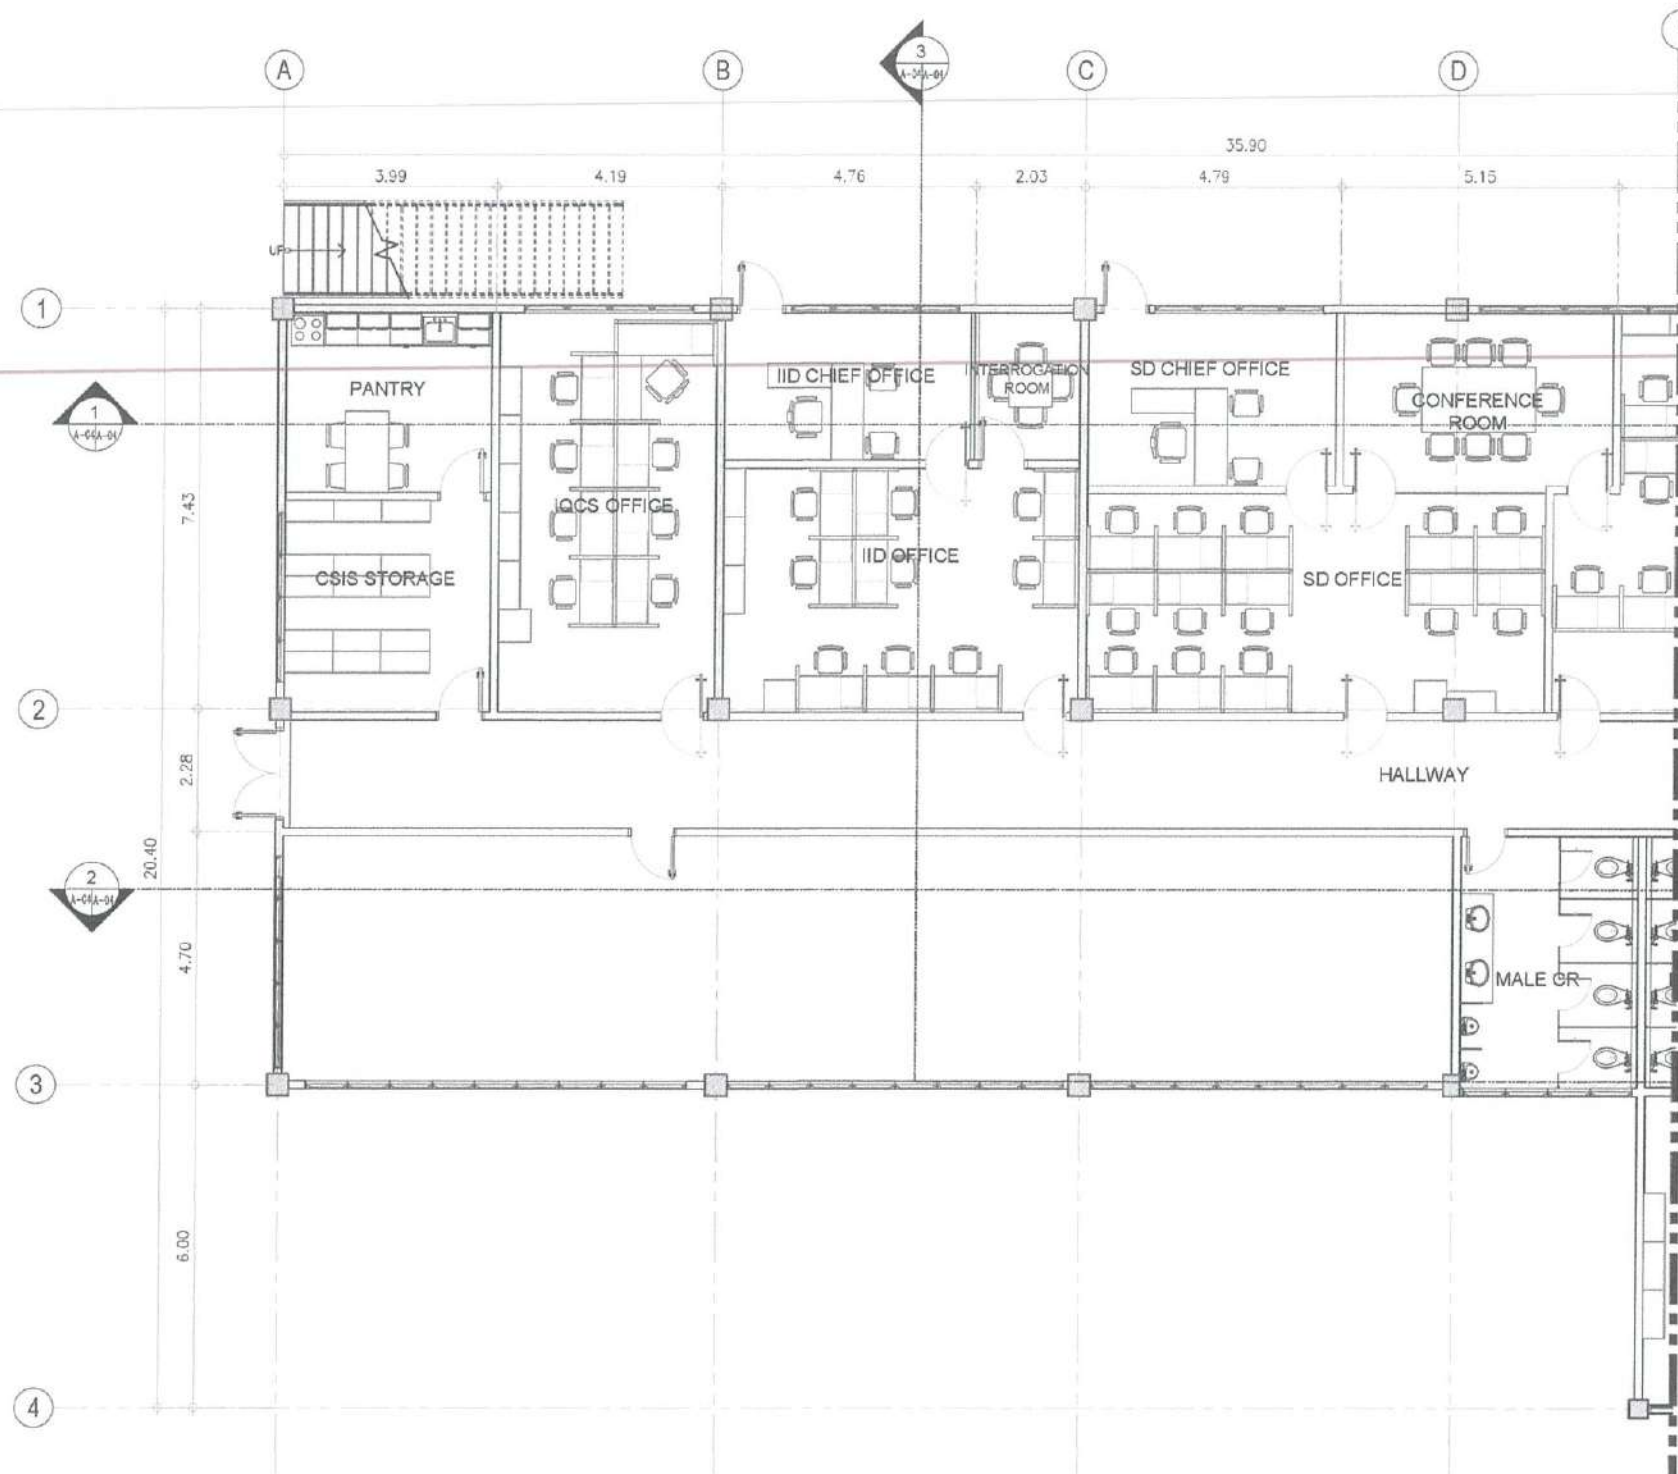

GROUND FLOOR
BLOW UP PLAN 1-1
SCALE: 1:75 M

BAR SCALE



REPUBLIC OF THE PHILIPPINES

CIVIL AVIATION AUTHORITY OF THE PHILIPPINES
AERODROME DEVELOPMENT AND MANAGEMENT SERVICE
NAIA RD. COR. N. AQUINO AVENUE, PASAY CITY

THIS DRAWINGS AND DESIGN IS EXCLUSIVE
PROPERTY OF CIVIL AVIATION AUTHORITY
OF THE PHILIPPINES AND SUCH MUST NOT BE
REPRODUCED, EXHIBITED, LOANED NOR
COPIED IN PART OR IN WHOLE WITHOUT
PROPER PERMISSION AND/OR WRITTEN
CONSENT FROM THE DIRECTOR GENERAL
CAAP.

AERODROME DEVELOPMENT
AND MANAGEMENT SERVICE

INFRASTRUCTURE DEVELOPMENT AND DESIGN
DIVISION

DESIGN STAFF: INITIAL / DATE
DESIGNED BY: IDDD
DRAWN BY: DRPG/MLR
CHECKED BY:

REVIEWED BY:

RAUL R. CRUCENA
Division Chief, IDDD-AED

SUBMITTED BY:

ARNEL F. BORLADO
Department Manager III, AED-ADMS

RECOMMEND APPROVAL:

LT COL VALENTINO A. DIONELA PAF (RET)
Assistant Director General II, ADMS

APPROVED BY:

CAPTAIN MANUEL ANTONIO L. TAMAYO
Director General

NOTES/REVISIONS:

PROJECT:

IMPROVEMENT/REHABILITATION
OF AIRWAYS FACILITY COMPLEX
BUILDING

LOCATION:

CAAP CENTRAL OFFICE
NAIA RD. COR. N. AQUINO AVENUE,
PASAY CITY


SHEET CONTENTS:

• GROUND FLOOR BLOW-UP PLAN

DRAWING SCALE: SHEET NO:


1:75 M A

17

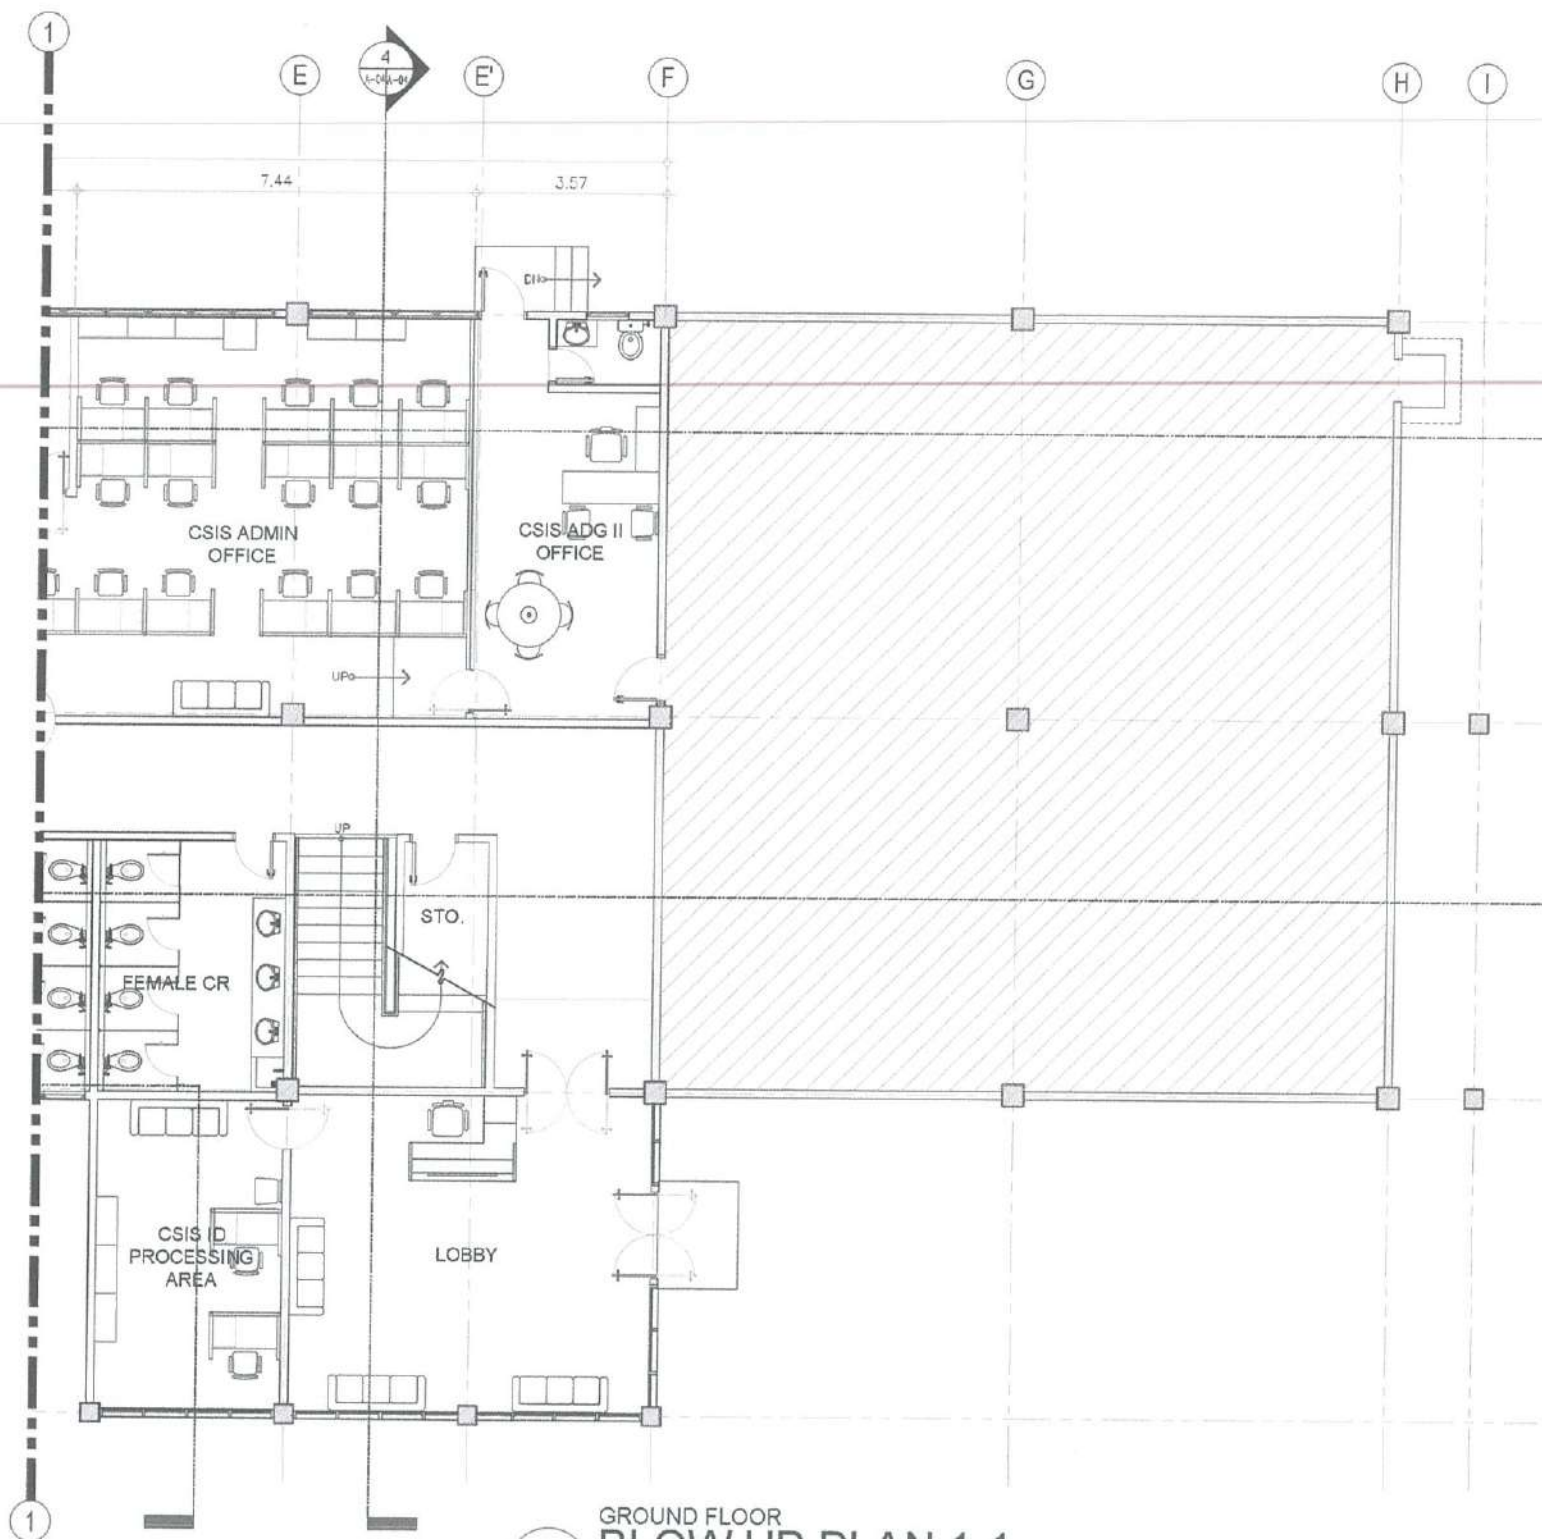

GROUND FLOOR
BLOW UP PLAN 1-1
SCALE: 1:75 M

 BAR SCALE



REPUBLIC OF THE PHILIPPINES
CIVIL AVIATION AUTHORITY OF THE PHILIPPINES
AERODROME DEVELOPMENT AND MANAGEMENT SERVICE
NAIA RD. 150 PASAY CITY

THIS DRAWINGS AND DESIGN IS EXCLUSIVE
PROPERTY OF CIVIL AVIATION AUTHORITY
OF THE PHILIPPINES AND SUCH MUST NOT BE
REPRODUCED, EXHIBITED, LOANED NOR
COPIED IN PART OR IN WHOLE WITHOUT
PROPER PERMISSION AND/OR WRITTEN
CONSENT FROM THE DIRECTOR GENERAL
CAAP.

AERODROME DEVELOPMENT
AND MANAGEMENT SERVICE

INFRASTRUCTURE DEVELOPMENT AND DESIGN
DIVISION

DESIGN STAFF:	INITIAL / DATE
DESIGNED BY:	IDDO
DRAWN BY:	DRPGMPLR
CHECKED BY:	

REVIEWED BY:

[Signature]
RAUL R. CAUCENA
Division Chief III, ADD-AED

SUBMITTED BY:
[Signature]
ARNEL F. BORLADO
Department Manager III, AED-ADMS

RECOMMEND APPROVAL:
[Signature]
LT COL VALENTINO A. DIONELA PAF (RET)
Assistant Director General II, ADMS

APPROVED BY:
[Signature]
CAPTAIN MANUEL ANTONIO L. TAMAYO
Director General


NOTES/REVISIONS:

PROJECT:
IMPROVEMENT/REHABILITATION
OF AIRWAYS FACILITY COMPLEX
BUILDING


LOCATION:
CAAP CENTRAL OFFICE
NAIA RD. COR. N. AQUINO AVENUE,
PASAY CITY

SHEET CONTENTS:
• GROUND FLOOR BLOW-UP PLAN

DRAWING SCALE:	SHEET NO.:
1:75 M	A
	17

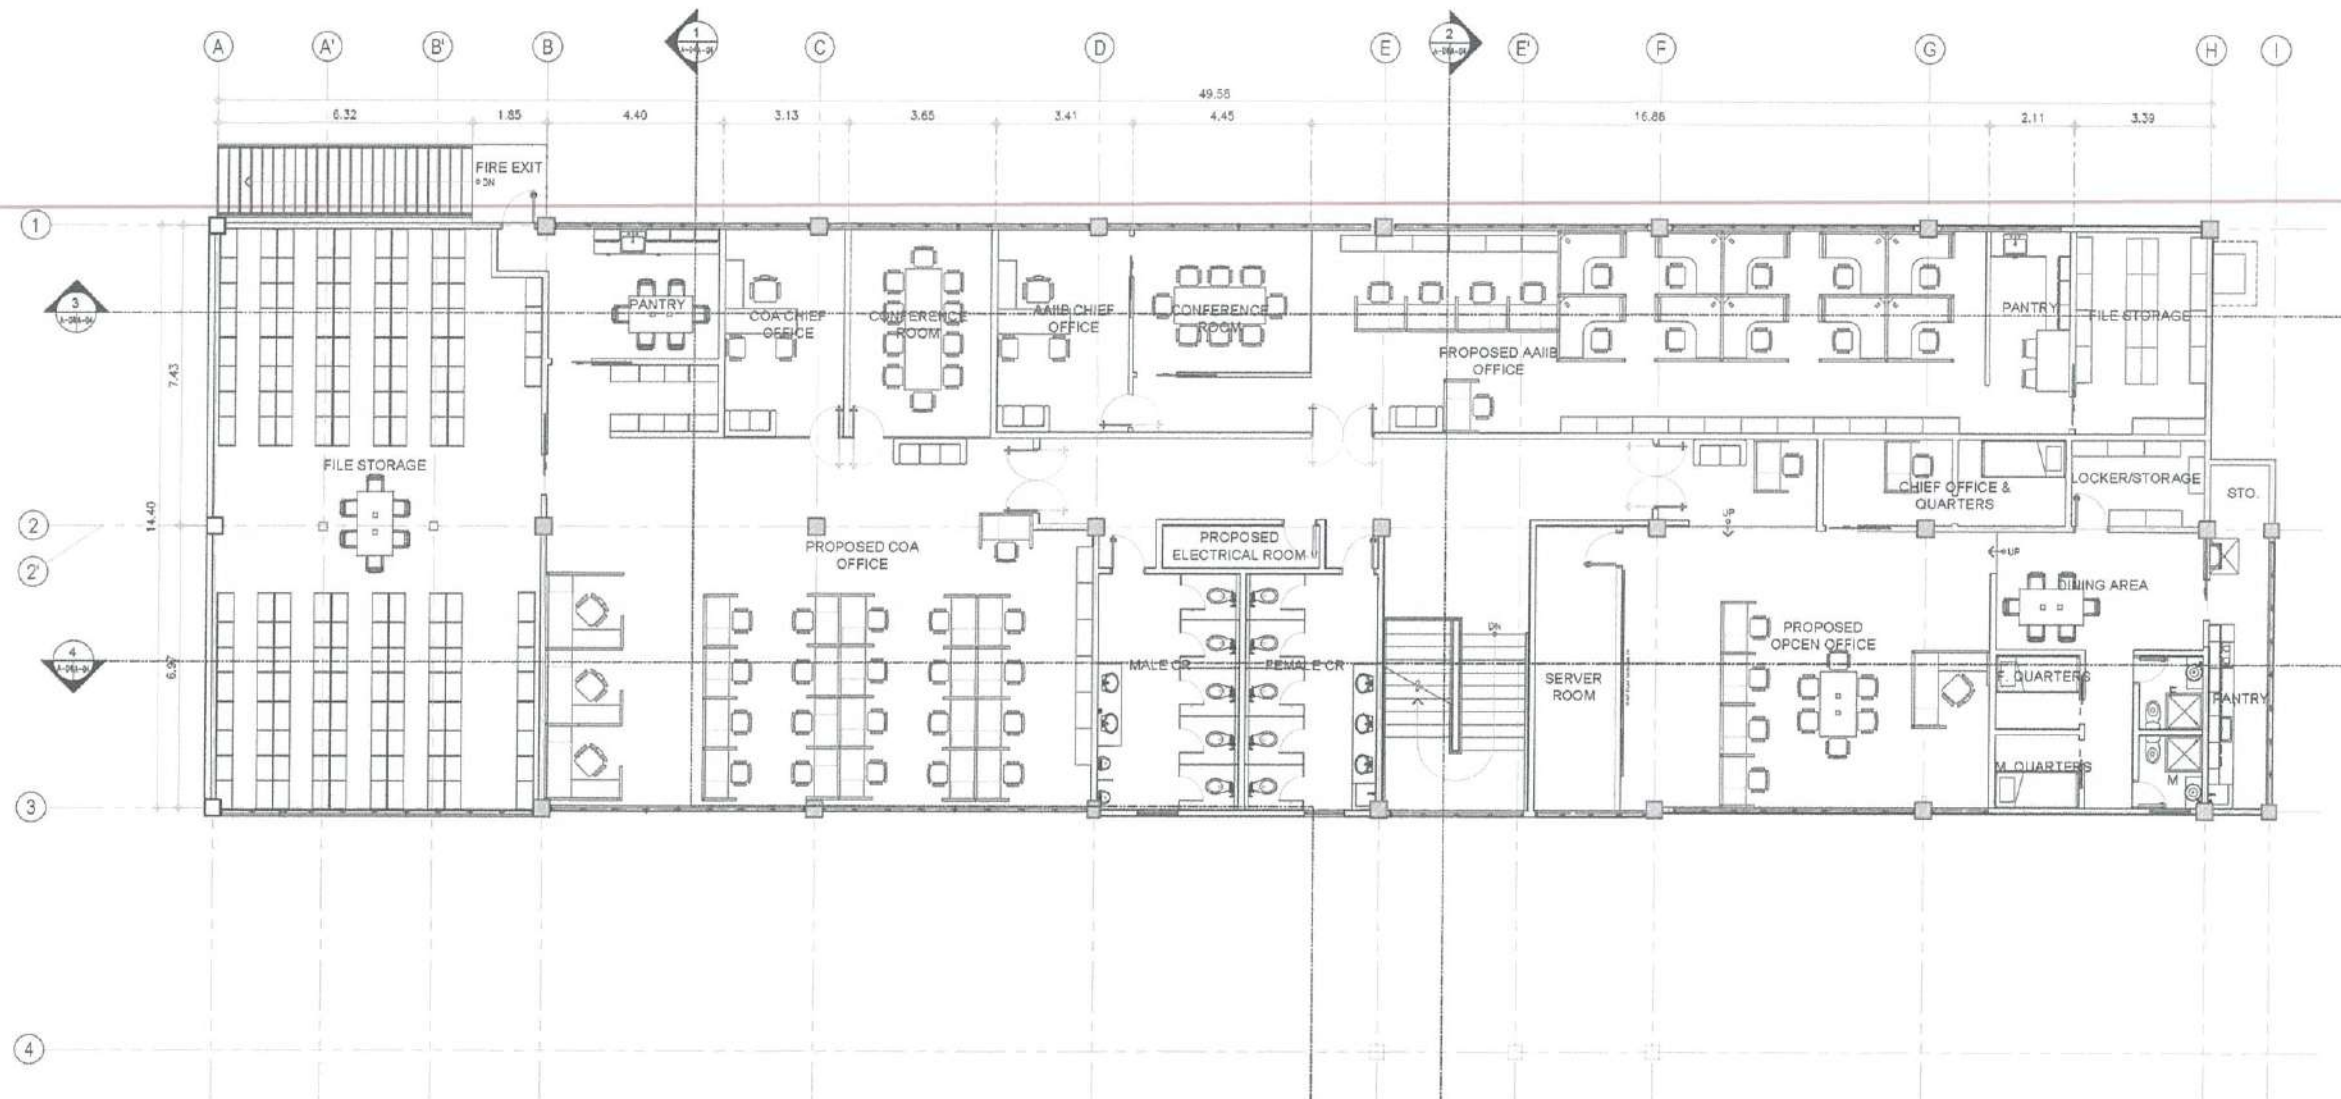

 1 SECOND FLOOR PLAN
A-04 A-05
SCALE: 1:100 M



REPUBLIC OF THE PHILIPPINES
CIVIL AVIATION AUTHORITY OF THE PHILIPPINES
AERODROME DEVELOPMENT AND MANAGEMENT SERVICE
NAIA ROAD, 1306 PASAY CITY

THIS DRAWINGS AND DESIGN IS EXCLUSIVE
PROPERTY OF CIVIL AVIATION AUTHORITY
OF THE PHILIPPINES AND SUCH MUST NOT BE
REPRODUCED, EXHIBITED, LOANED NOR
COPIED IN PART OR IN WHOLE WITHOUT
PROPER PERMISSION AND/OR WRITTEN
CONSENT FROM THE DIRECTOR GENERAL
CAAP.

AERODROME DEVELOPMENT
AND MANAGEMENT SERVICE

INFRASTRUCTURE DEVELOPMENT AND DESIGN
DIVISION

DESIGN STAFF: INITIAL / DATE
DESIGNED BY: IDDD
DRAWN BY: DRPG/MLR
CHECKED BY:

REVIEWED BY:

RAUL R. CRUCENA
Division Chief III, IDDD-AED

SUBMITTED BY:
ARNEL F. BORLADO
Department Manager III, AED-ADMS

RECOMMEND APPROVAL:
LT COL. VALENTINO A. DIONELA PAF (RET)
Assistant Director General II, ADMS

APPROVED BY:
CAPTAIN MANUEL ANTONIO L. TAMAYO
Director General


NOTES/REVISIONS:

PROJECT:
IMPROVEMENT/REHABILITATION
OF AIRWAYS FACILITY COMPLEX
BUILDING

LOCATION:
CAAP CENTRAL OFFICE
NAIA RD. COR. N. AQUINO AVENUE,
PASAY CITY


SHEET CONTENTS:
• SECOND FLOOR PLAN

DRAWING SCALE: 1:100 M
SHEET NO: A
04 17

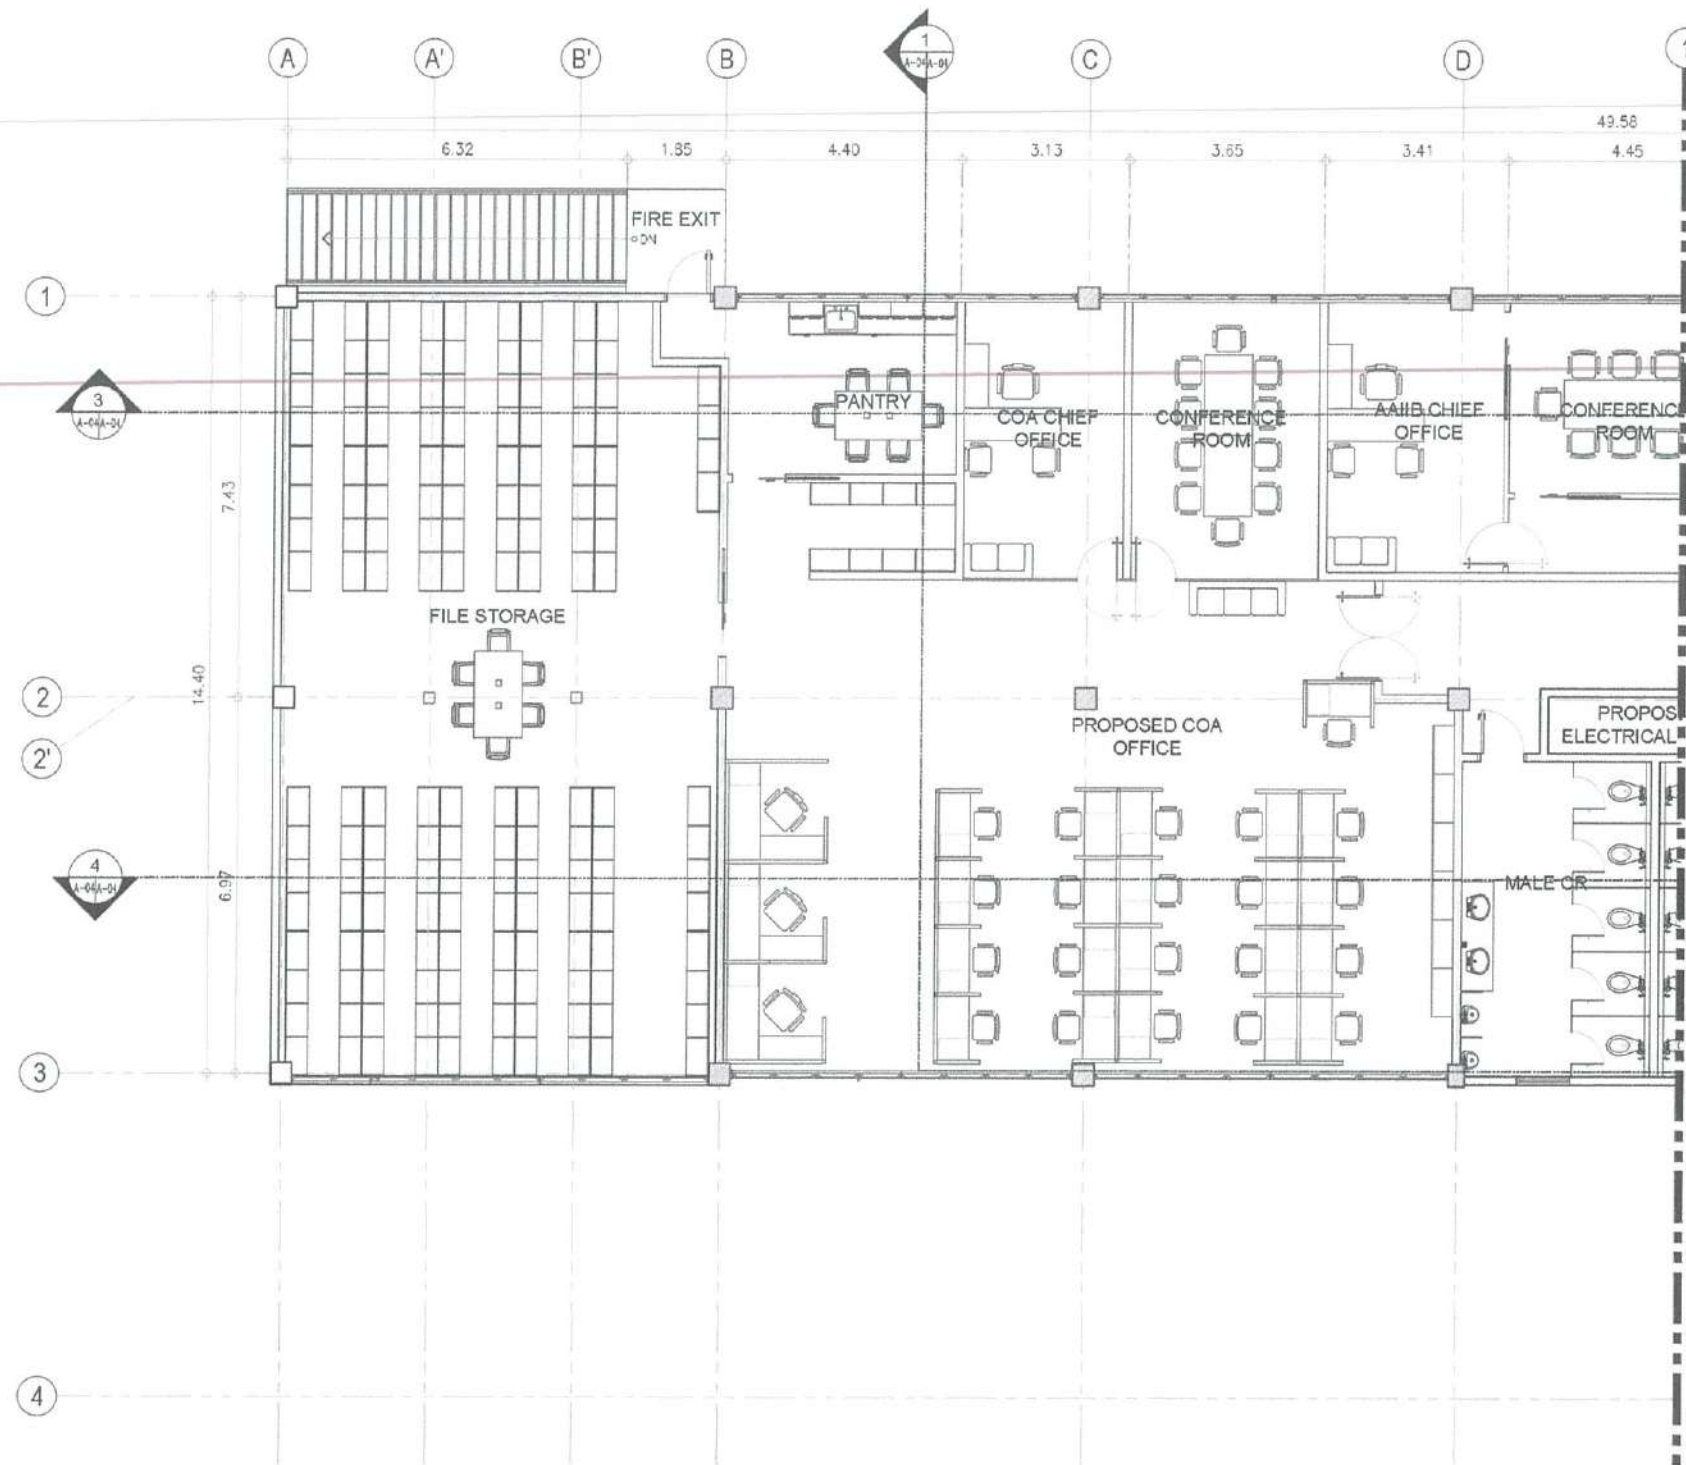

1
SECOND FLOOR
BLOW UP PLAN 1-1
SCALE: 1:75 M

 BAR SCALE



REPUBLIC OF THE PHILIPPINES
CIVIL AVIATION AUTHORITY OF THE PHILIPPINES
AERODROME DEVELOPMENT AND MANAGEMENT SERVICE
NAIA ROAD, 1306 PASAY CITY

THIS DRAWINGS AND DESIGN IS EXCLUSIVE
PROPERTY OF CIVIL AVIATION AUTHORITY
OF THE PHILIPPINES AND SUCH MUST NOT BE
REPRODUCED, EXHIBITED, LOANED NOR
COPIED IN PART OR IN WHOLE WITHOUT
PROPER PERMISSION AND/OR WRITTEN
CONSENT FROM THE DIRECTOR GENERAL
CAAP.

AERODROME DEVELOPMENT
AND MANAGEMENT SERVICE

INFRASTRUCTURE DEVELOPMENT AND DESIGN
DIVISION

DESIGN STAFF:	INITIAL / DATE
DESIGNED BY:	IDDO
DRAWN BY:	DRPG/AMPLR
CHECKED BY:	

REVIEWED BY:

[Signature]
RAUL P. CRUCENA
Division Chief III, IDDO-AED

SUBMITTED BY:

[Signature]
ARNEV F. BORLADO
Department Manager III, AED-ADMS

RECOMMEND APPROVAL:

[Signature]
LT COL VALENTINO A. DIONELA PAF (RET.)
Assistant Director General II, ADMS

APPROVED BY:

[Signature]
CAPTAIN MANUEL ARDITO L. TAMAYO
Director General

NOTES/REVISIONS:

PROJECT:

IMPROVEMENT/REHABILITATION
OF AIRWAYS FACILITY COMPLEX
BUILDING


LOCATION:

CAAP CENTRAL OFFICE
NAIA RD. COR. N. AQUINO AVENUE,
PASAY CITY

SHEET CONTENTS:

• SECOND FLOOR BLOW-UP PLAN

DRAWING SCALE:	SHEET NO.:
1:75 M	A
	17

 



REPUBLIC OF THE PHILIPPINES
CIVIL AVIATION AUTHORITY OF THE PHILIPPINES
AERODROME DEVELOPMENT AND MANAGEMENT SERVICE
NAIA ROAD, 1305 PASAY CITY

THIS DRAWING AND DESIGN IS EXCLUSIVE PROPERTY OF CIVIL AVIATION AUTHORITY OF THE PHILIPPINES AND SUCH MUST NOT BE REPRODUCED, EXHIBITED, LOANED NOR COPIED IN PART OR IN WHOLE WITHOUT PROPER PERMISSION AND/OR WRITTEN CONSENT FROM THE DIRECTOR GENERAL CAA.

AERODROME DEVELOPMENT AND MANAGEMENT SERVICE

INFRASTRUCTURE DEVELOPMENT AND DESIGN DIVISION

DESIGN STAFF: INITIAL DATE
DESIGNED BY: IDDO
DRAWN BY: DRPG/MLR
CHECKED BY:

REVIEWED BY:

RAUL R. CRUCENA
Division Chief (IDDO-AED)

SUBMITTED BY:

ARNEL F. BORLADO
Department Manager III, AED-ADMS

RECOMMEND APPROVAL:

LT COL. VALENTINO A. DIONELA PAF (RET)
Assistant Director General II, ADMS

APPROVED BY:

CAPTAIN MANUEL ANTONIO L. TAMAYO
Director General

NOTES/REVISIONS:

PROJECT:

IMPROVEMENT/REHABILITATION OF AIRWAYS FACILITY COMPLEX BUILDING

LOCATION:


CAAP CENTRAL OFFICE
NAIA RD, COR. N. AQUINO AVENUE,
PASAY CITY

SHEET CONTENTS:

• GROUND FLOOR DETAILED PLAN

DRAWING SCALE: SHEET NO.

1:100 M A
3a 17

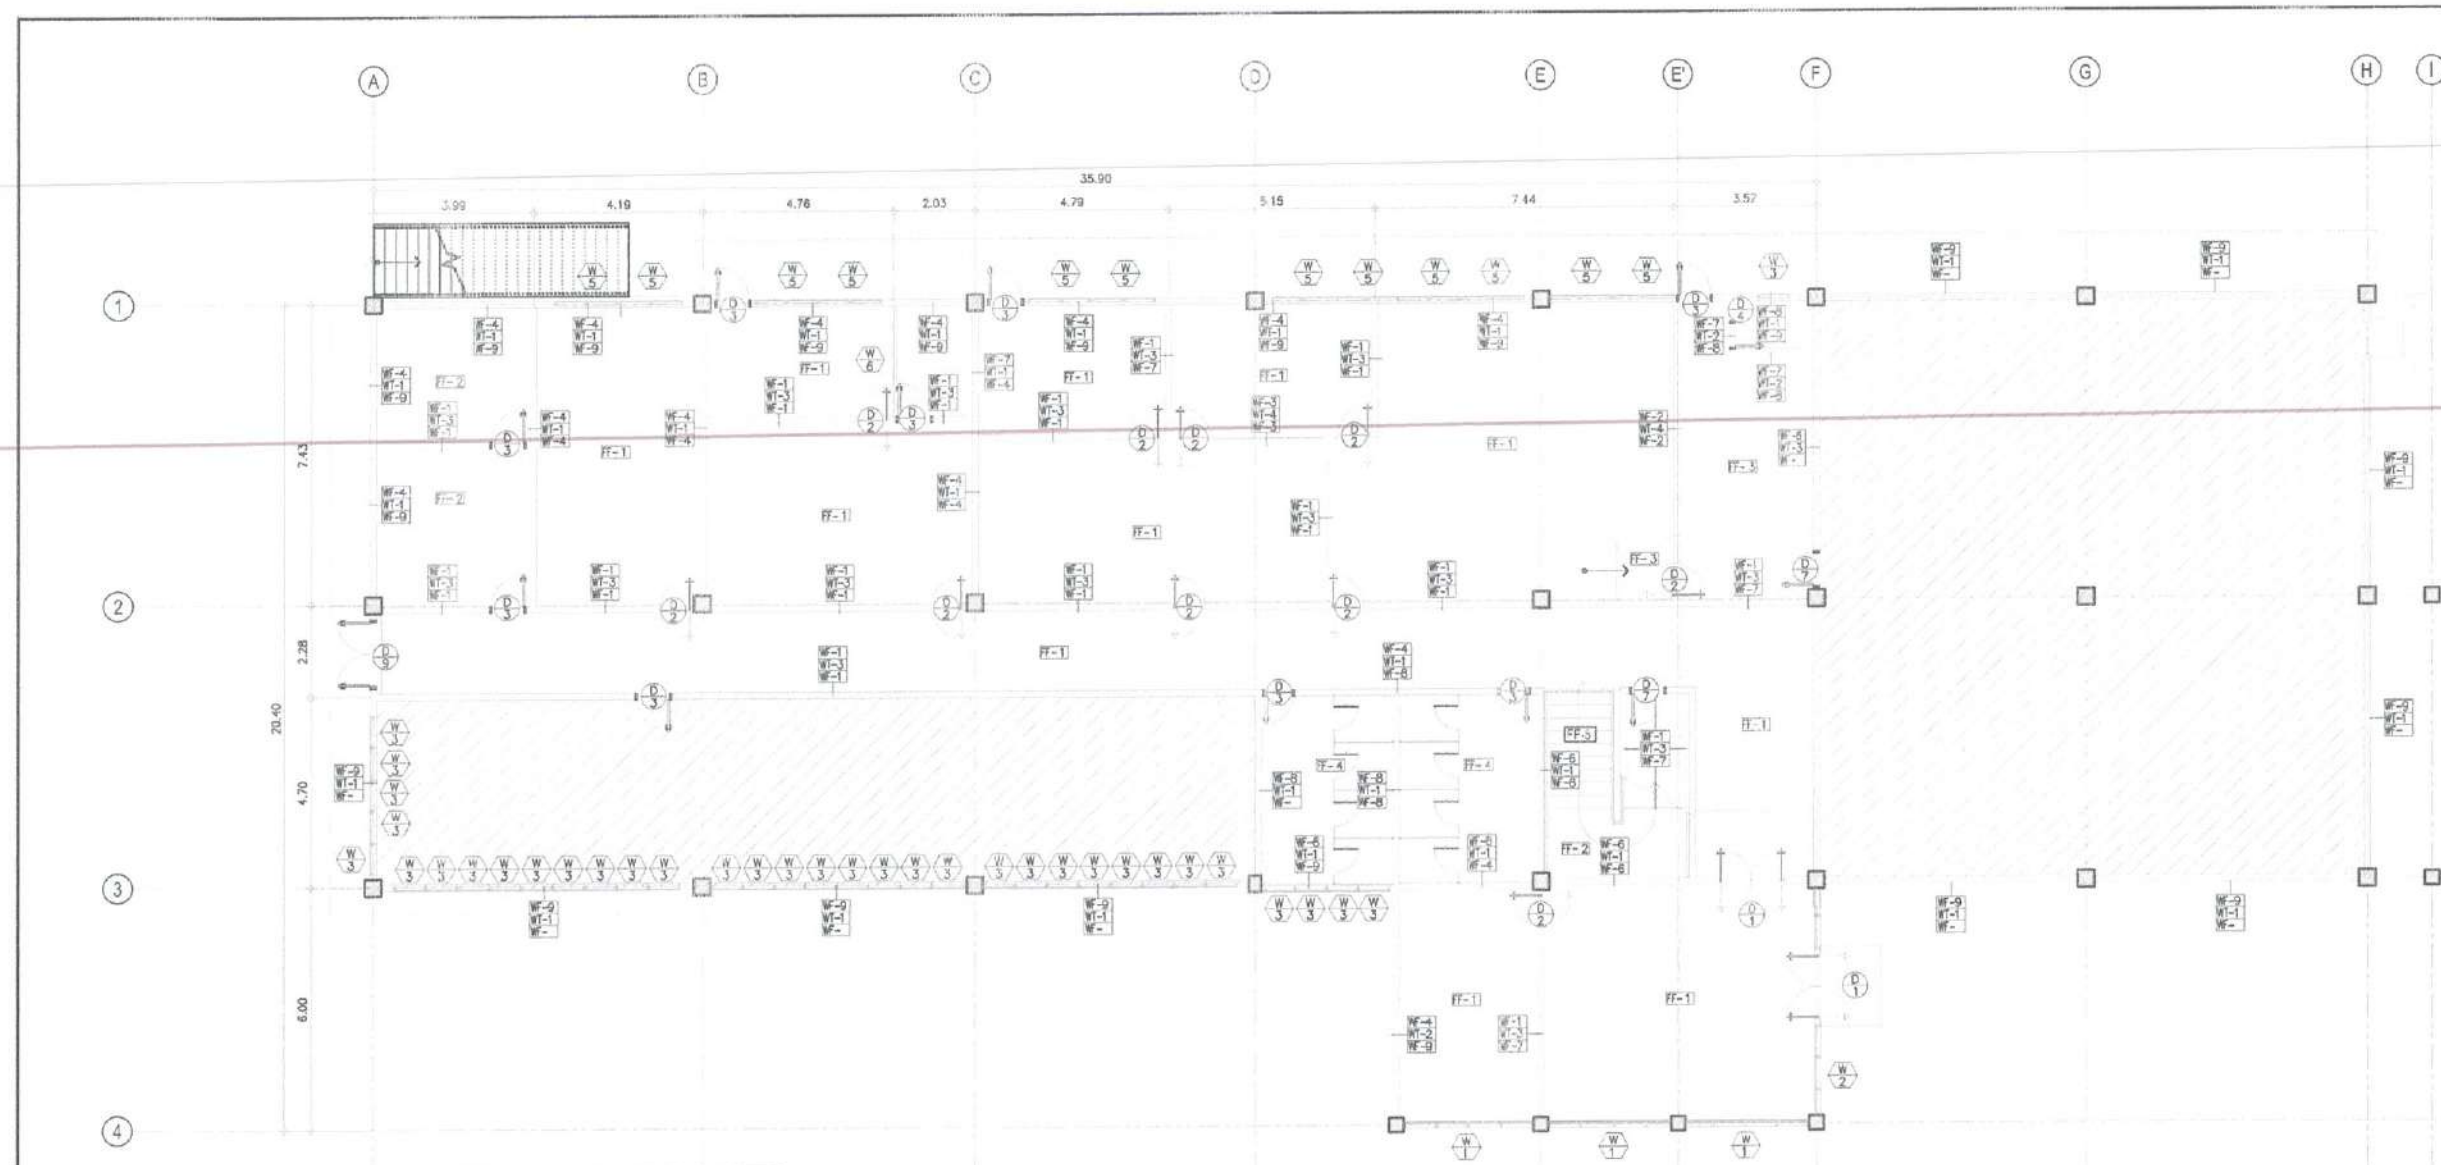

LEGEND

WF WALL FACING MARK
WT TYPE OF WALL
WF OPPOSITE WALL FACING MARK

REMARKS

GROUND FLOOR DETAILED FLOOR PLAN

SCALE: 1:100 M

SCHEDULE OF WALL FINISHES

MARK	FINISHES	REMARKS
WF-1	150mm THK. DRY WALL PARTITION IN 12mm THK. FIBER CEMENT BOARD PAINTED FINISH WITH FOAM ROCKWOOL INSULATION (DOUBLE SIDED)	
WF-2	12mm THK. FRAMELESS TEMPERED SMART GLASS (VERIFY ACTUAL FLOOR TO CEILING ELEVATION)	
WF-3	12mm THK. FRAMELESS TEMPERED GLASS (VERIFY ACTUAL FLOOR TO CEILING ELEVATION)	
WF-4	150mm THK. CHB WALL PAINTED WITH 3 COATS OF ACRYLIC LATEX SEMI-GLOSS FINISH	
WF-5	150mm THK. CHB WALL PAINTED WITH ELASTOMERIC MATTE FINISH (WHITE)	
WF-6	150mm THK. WALL PAINTED WITH LIMEWASH FINISH	
WF-7	200mm x 28mm WOOD PLASTIC COMPOSITE PANEL CLADDING ON DRY DRY WALL (VERIFY ACTUAL FLR TO CL ELEV.) PARTITION DARK OAK COLOR (SUBMIT SAMPLE FOR APPROVAL)	
WF-8	300mm x 600mm x 8mm THK. HOMOGENOUS PORCELAIN TILE (MATTE FINISH) IN CHB WALL (SUBMIT SAMPLE FOR APPROVAL)	
WF-9	150mm THK. CHB WALL PAINTED WITH ELASTOMERIC MATTE FINISH (BLUE)	

SCHEDULE OF FLOOR FINISHES

MARK	FINISHES	REMARKS
FF-1	10mm THK. x 600mm x 600mm HOMOGENOUS PORCELAIN FLOOR TILES POLISHED FINISH (SUBMIT SAMPLE FOR APPROVAL)	
FF-2	10mm THK. x 600mm x 600mm HOMOGENOUS PORCELAIN FLOOR TILES MATTE FINISH (SUBMIT SAMPLE FOR APPROVAL)	
FF-3	30mm THK. x 600mm x 600mm with 3mm THK. ANTI-STATIC HPL CERAMIC COATED STEEL RAISED FLOORING (SUBMIT SAMPLE FOR APPROVAL)	
FF-4	10mm THK. x 600mm x 600mm HOMOGENOUS PORCELAIN FLOOR TILES MATTE FINISH (SUBMIT SAMPLE FOR APPROVAL)	
FF-5	10mm THK. 300mm x 600mm HOMOGENOUS PORCELAIN FLOOR TILES WITH WOOD-LIKE MATTE FINISH (SUBMIT SAMPLE FOR APPROVAL)	FOR MAIN STAIR TREADS

SCHEDULE OF WALL TYPES

MARK	TYPES	REMARKS
WT-1	EXISTING CHB WALL	
WT-2	150mm THK. CHB WALL	
WT-3	12mm THK. FIBER BOARD ON METAL STUDS	
WT-4	12mm THK. TEMPERED GLASS PARTITION	

BAR SCALE





REPUBLIC OF THE PHILIPPINES
CIVIL AVIATION AUTHORITY OF THE PHILIPPINES
AERODROME DEVELOPMENT AND MANAGEMENT SERVICE
NAIA ROAD, PASAY CITY

THIS DRAWING AND DESIGN IS EXCLUSIVE PROPERTY OF CIVIL AVIATION AUTHORITY OF THE PHILIPPINES AND SUCH MUST NOT BE REPRODUCED, EXHIBITED, LOANED NOR COPIED IN PART OR IN WHOLE WITHOUT PROPER PERMISSION AND/OR WRITTEN CONSENT FROM THE DIRECTOR GENERAL CAA.

AERODROME DEVELOPMENT AND MANAGEMENT SERVICE

INFRASTRUCTURE DEVELOPMENT AND DESIGN DIVISION

DESIGN STAFF: INITIAL DATE
DESIGNED BY: IDDD
DRAWN BY: DRP/UMPLR
CHECKED BY:

REVIEWED BY:

RAUL R. CRUCENA
Division Chief III, IDDD-AED

SUBMITTED BY:
ARNEL F. BORLADO
Department Manager III, AED-ADMS

RECOMMEND APPROVAL:
L. JOSE VALENTINO A. DIONELA PAF (RET)
Assistant Director General III, ADMS

APPROVED BY:
CAPTAIN MANUEL ANTONIO L. TAVAYO
Director General


NOTES/REVISIONS:

PROJECT:
IMPROVEMENT/REHABILITATION OF AIRWAYS FACILITY COMPLEX BUILDING

LOCATION:
CAAP CENTRAL OFFICE
NAIA RD. COR. N. AQUINO AVENUE,
PASAY CITY


SHEET CONTENTS:
• DETAILED GROUND FLOOR BLOW-UP PLAN

DRAWING SCALE: 1:75 M
SHEET NO. A 17

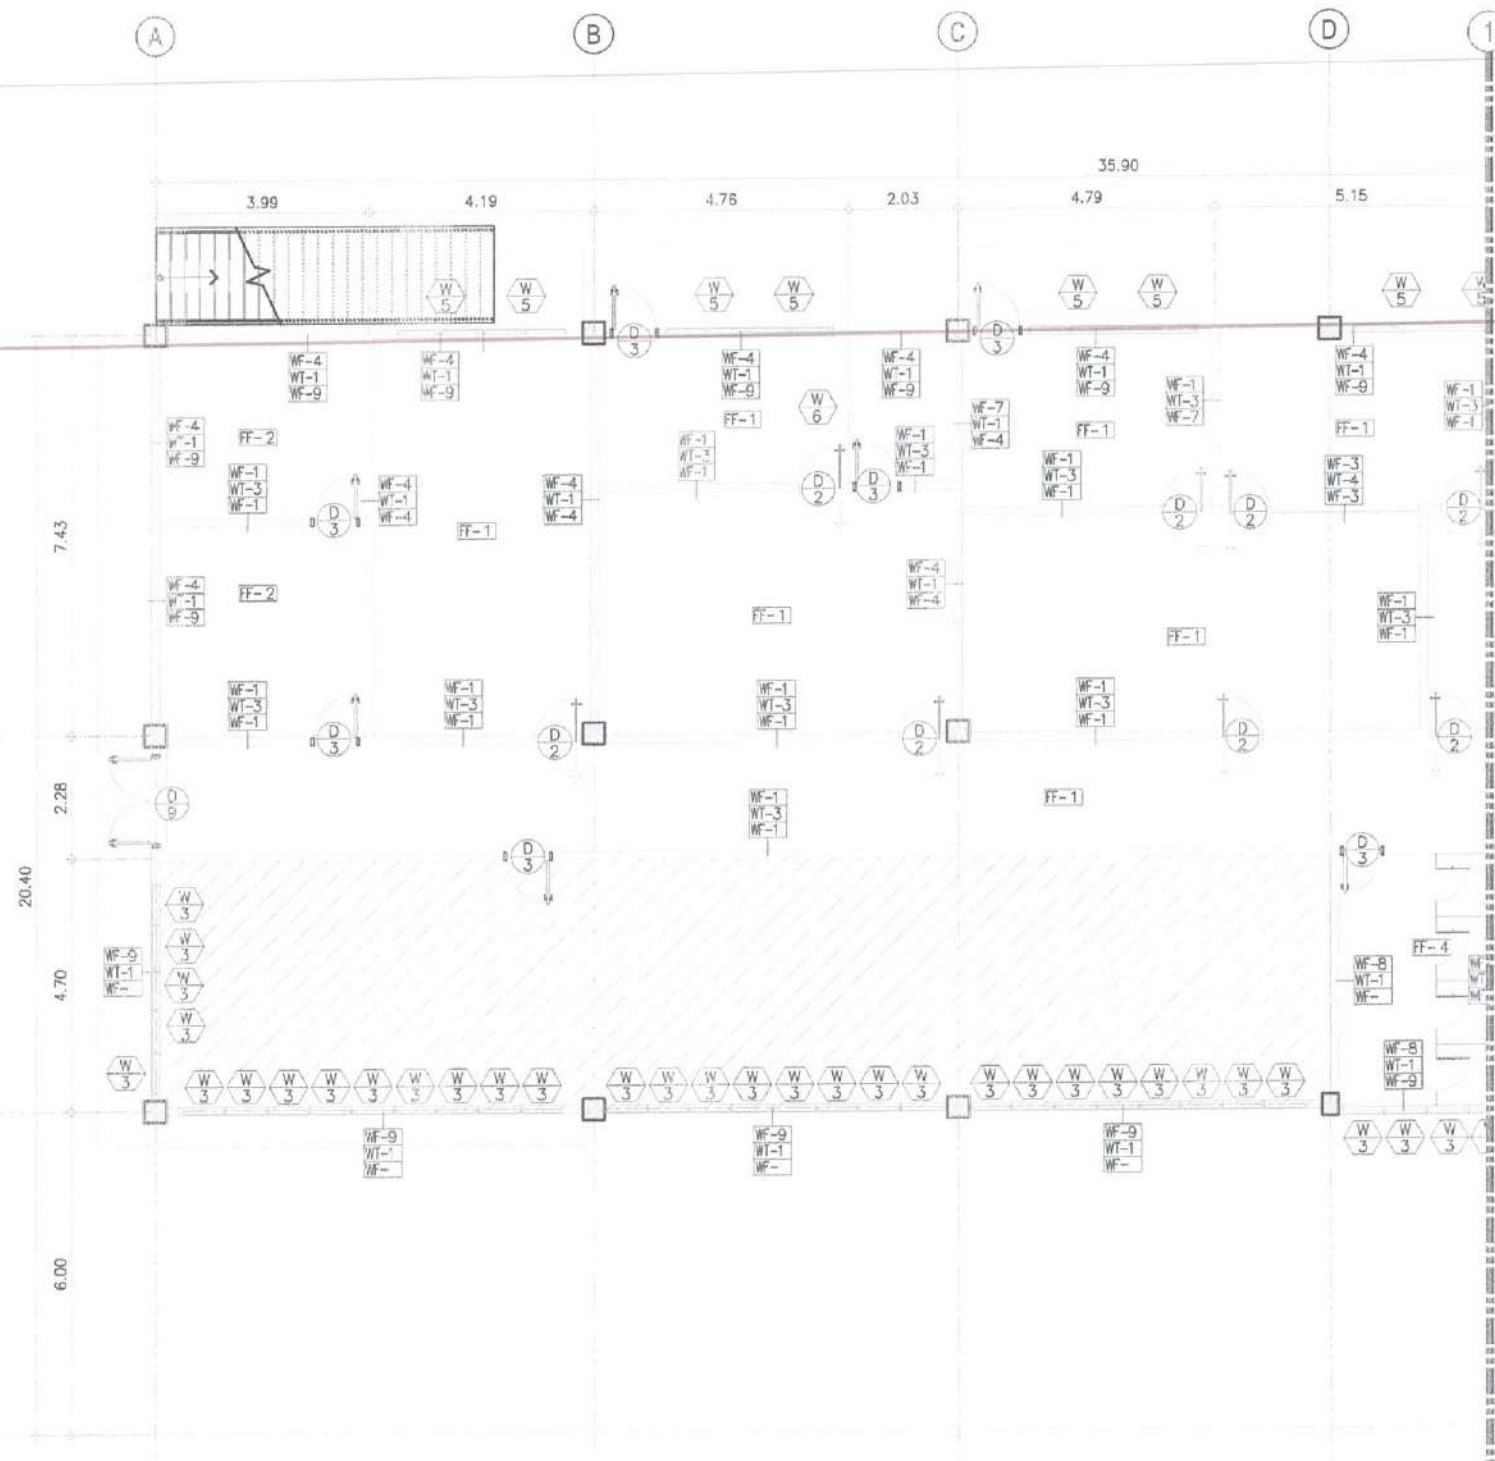

1 DETAILED GROUND FLOOR
BLOW UP PLAN 1-1
SCALE: 1:75 M

 BAR SCALE



LEGEND		REMARKS
WF	WALL FACING MARK	
WT	TYPE OF WALL	
WF	OPPOSITE WALL FACING MARK	

SCHEDULE OF WALL FINISHES		REMARKS
MARK	FINISHES	
WF-1	150mm THK DRY WALL PARTITION IN 12mm THK. FIBER CEMENT BOARD PAINTED FINISH WITH FOAM ROCKWOOL INSULATION (DOUBLE SIDED)	
WF-2	12mm THK. FRAMELESS TEMPERED SMART GLASS (VERIFY ACTUAL FLOOR TO CEILING ELEVATION)	
WF-3	12mm THK. FRAMELESS TEMPERED GLASS (VERIFY ACTUAL FLOOR TO CEILING ELEVATION)	
WF-4	150mm THK. CHB WALL PAINTED WITH 3 COATS OF ACRYLIC LATEX SEMI-GLOSS FINISH	
WF-5	150mm THK. CHB WALL PAINTED WITH ELASTOMERIC MATTE FINISH (WHITE)	
WF-6	150mm THK. WALL PAINTED WITH LIMEWASH FINISH	
WF-7	200mm x 28mm WOOD PLASTIC COMPOSITE PANEL CLADDING ON DRY DRY WALL (VERIFY ACTUAL FLR TO CL ELEV.) PARTITION: DARK OAK COLOR (SUBMIT SAMPLE FOR APPROVAL)	
WF-8	300mm x 600mm x 8mm THK. HOMOGENOUS PORCELAIN TILE (MATTE FINISH) IN CHB WALL (SUBMIT SAMPLE FOR APPROVAL)	
WF-9	150mm THK. CHB WALL PAINTED WITH ELASTOMERIC MATTE FINISH (BLUE)	

SCHEDULE OF FLOOR FINISHES		REMARKS
MARK	FINISHES	
FF-1	10mm THK. x 600mm x 600mm HOMOGENOUS PORCELAIN FLOOR TILES POLISHED FINISH (SUBMIT SAMPLE FOR APPROVAL)	
FF-2	10mm THK. x 600mm x 600mm HOMOGENOUS PORCELAIN FLOOR TILES MATTE FINISH (SUBMIT SAMPLE FOR APPROVAL)	
FF-3	30mm THK. x 600mm x 600mm with 3mm THK. ANTI-STATIC HPL CERAMIC COATED STEEL RAISED FLOORING (SUBMIT SAMPLE FOR APPROVAL)	
FF-4	10mm THK. x 600mm x 600mm HOMOGENOUS PORCELAIN FLOOR TILES MATTE FINISH (SUBMIT SAMPLE FOR APPROVAL)	
FF-5	10mm THK. 300mm x 600mm HOMOGENOUS PORCELAIN FLOOR TILES WITH WOOD-LIKE MATTE FINISH (SUBMIT SAMPLE FOR APPROVAL)	FOR MAIN STAIR TREADS

SCHEDULE OF WALL TYPES		REMARKS
MARK	TYPES	
WT-1	EXISTING CHB WALL	
WT-2	150mm THK. CHB WALL	
WT-3	12mm THK. FIBER BOARD ON METAL STUDS	
WT-4	12mm THK. TEMPERED GLASS PARTITION	



REPUBLIC OF THE PHILIPPINES
CIVIL AVIATION AUTHORITY OF THE PHILIPPINES
AERODROME DEVELOPMENT AND MANAGEMENT SERVICE
NAIA ROAD, PASAY CITY

THIS DRAWING AND DESIGN IS EXCLUSIVE PROPERTY OF CIVIL AVIATION AUTHORITY OF THE PHILIPPINES AND SUCH MUST NOT BE REPRODUCED, EXHIBITED, LOANED NOR COPIED IN PART OR IN WHOLE WITHOUT PROPER PERMISSION AND/OR WRITTEN CONSENT FROM THE DIRECTOR GENERAL CAA.

AERODROME DEVELOPMENT AND MANAGEMENT SERVICE

INFRASTRUCTURE DEVELOPMENT AND DESIGN DIVISION

DESIGN STAFF: INITIAL / DATE

DESIGNED BY: IDDD

DRAWN BY: DRP/MLR

CHECKED BY:

REVIEWED BY:

RAUL R. CRUCENA
Division Chief, IDDD/AED

SUBMITTED BY:

ARNEL F. BORLADO
Department Manager, I. AED-ADMS

RECOMMEND APPROVAL:

LT COL. VALENTINO A. DIONELA PAF (RET)
Assistant Director General, I. AED-ADMS

APPROVED BY:

CAPTAIN MANUEL ANTONIO L. TAMAYO
Director General

NOTES/REVISIONS:

PROJECT:

IMPROVEMENT/REHABILITATION OF AIRWAYS FACILITY COMPLEX BUILDING

LOCATION:

CAAP CENTRAL OFFICE
NAIA RD. COR. N. AQUINO AVENUE,
PASAY CITY

SHEET CONTENTS:

• DETAILED GROUND FLOOR BLOW-UP PLAN

DRAWING SCALE:

1:75 M

SHEET NO:

A


17

LEGEND		REMARKS
WF	WALL FACING MARK	
WT	TYPE OF WALL	
WF	OPPOSITE WALL FACING MARK	

SCHEDULE OF WALL FINISHES		REMARKS
MARK	FINISHES	
WF-1	150mm THK. DRY WALL PARTITION IN 12mm THK. FIBER CEMENT BOARD PAINTED FINISH WITH FOAM ROCKWOOL INSULATION (DOUBLE SIDED)	
WF-2	12mm THK. FRAMELESS TEMPERED SMART GLASS (VERIFY ACTUAL FLOOR TO CEILING ELEVATION)	
WF-3	12mm THK. FRAMELESS TEMPERED GLASS (VERIFY ACTUAL FLOOR TO CEILING ELEVATION)	
WF-4	150mm THK. CHB WALL PAINTED WITH 3 COATS OF ACRYLIC LATEX SEMI-GLOSS FINISH	
WF-5	150mm THK. CHB WALL PAINTED WITH ELASTOMERIC MATTE FINISH (WHITE)	
WF-6	150mm THK. WALL PAINTED WITH LIMEWASH FINISH	
WF-7	200mm x 28mm WOOD PLASTIC COMPOSITE PANEL CLADDING ON DRY WALL (VERIFY ACTUAL FLR TO CL ELEV.) PARTITION: DARK OAK COLOR (SUBMIT SAMPLE FOR APPROVAL)	
WF-8	300mm x 600mm x 8mm THK. HOMOGENOUS PORCELAIN TILE (MATTE FINISH) IN CHB WALL (SUBMIT SAMPLE FOR APPROVAL)	
WF-9	150mm THK. CHB WALL PAINTED WITH ELASTOMERIC MATTE FINISH (BLUE)	

SCHEDULE OF FLOOR FINISHES		REMARKS
MARK	FINISHES	
FF-1	10mm THK. x 600mm x 600mm HOMOGENOUS PORCELAIN FLOOR TILES POLISHED FINISH (SUBMIT SAMPLE FOR APPROVAL)	
FF-2	10mm THK. x 600mm x 600mm HOMOGENOUS PORCELAIN FLOOR TILES MATTE FINISH (SUBMIT SAMPLE FOR APPROVAL)	
FF-3	30mm THK. x 600mm x 600mm with 3mm THK. ANTI-STATIC HPL CERAMIC COATED STEEL RAISED FLOORING (SUBMIT SAMPLE FOR APPROVAL)	
FF-4	10mm THK. x 600mm x 600mm HOMOGENOUS PORCELAIN FLOOR TILES MATTE FINISH (SUBMIT SAMPLE FOR APPROVAL)	
FF-5	10mm THK. 300mm x 600mm HOMOGENOUS PORCELAIN FLOOR TILES WITH WOOD-LIKE MATTE FINISH (SUBMIT SAMPLE FOR APPROVAL)	FOR MAIN STAIR TREADS

SCHEDULE OF WALL TYPES		REMARKS
MARK	TYPES	
WT-1	EXISTING CHB WALL	
WT-2	150mm THK. CHB WALL	
WT-3	12mm THK. FIBER BOARD ON METAL STUDS	
WT-4	12mm THK. TEMPERED GLASS PARTITION	

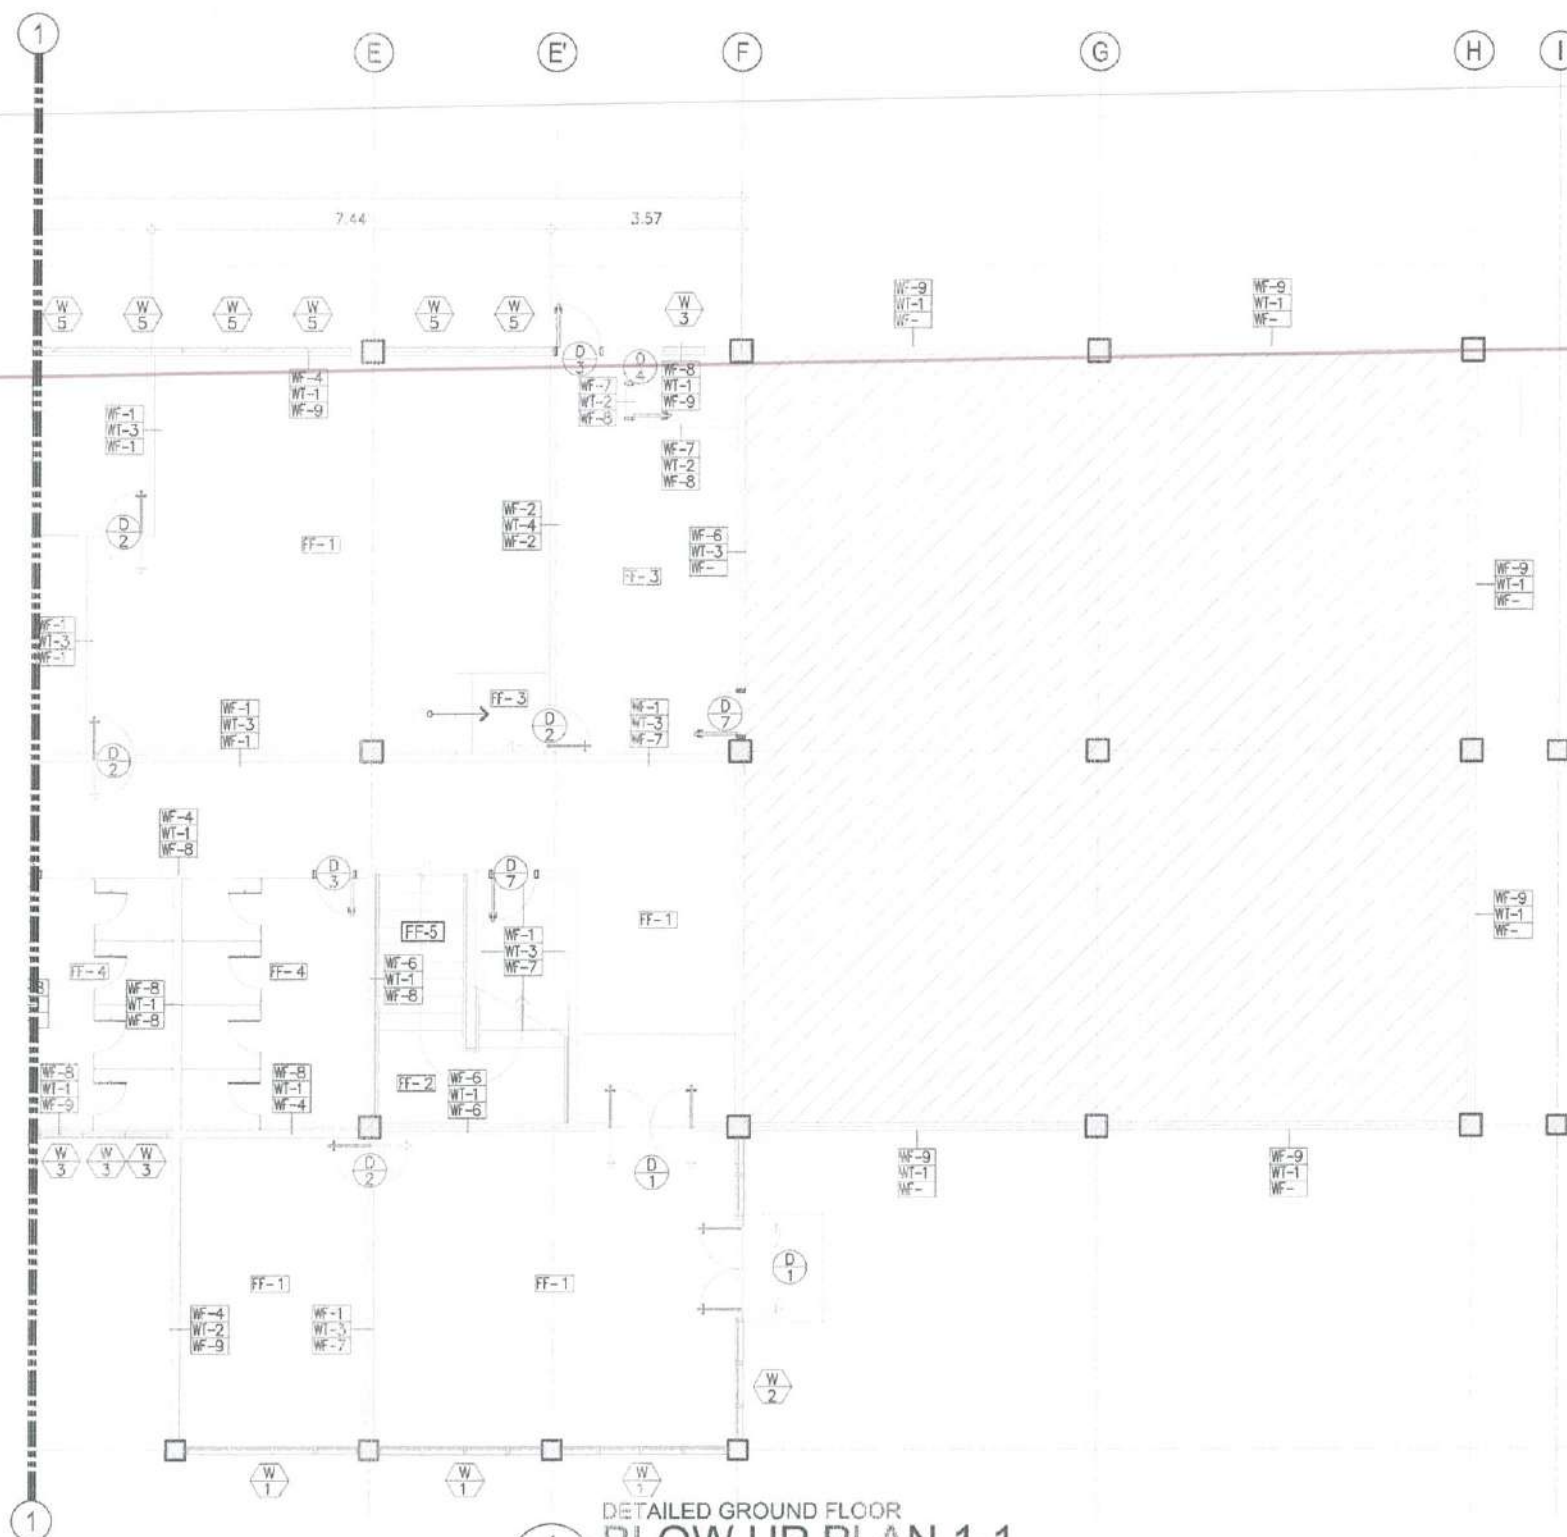

1
DETAILED GROUND FLOOR
BLOW UP PLAN 1-1
SCALE: 1:75 M

BAR SCALE





REPUBLIC OF THE PHILIPPINES
CIVIL AVIATION AUTHORITY OF THE PHILIPPINES
AERODROME DEVELOPMENT AND MANAGEMENT SERVICE
NAIA ROAD, PASAY CITY

THIS DRAWING AND DESIGN IS EXCLUSIVE PROPERTY OF CIVIL AVIATION AUTHORITY OF THE PHILIPPINES AND SUCH MUST NOT BE REPRODUCED, EXHIBITED, LOANED NOR COPIED IN PART OR IN WHOLE WITHOUT PROPER PERMISSION AND/OR WRITTEN CONSENT FROM THE DIRECTOR GENERAL CAA.

AERODROME DEVELOPMENT AND MANAGEMENT SERVICE

INFRASTRUCTURE DEVELOPMENT AND DESIGN DIVISION

DESIGN STAFF: INITIAL / DATE

DESIGNED BY: IDDD

DRAWN BY: DRPGMPUR

CHECKED BY:

REVIEWED BY:

RAUL N. CRUCENA
Division Chief III, IDDD-AED

SUBMITTED BY:

ARNEL F. BORLADO
Department Manager III, AED-AOMS

RECOMMEND APPROVAL:

LT COL. VALENTINO A. DIONELA PAF (RET)
Assistant Director General III, AOMS

APPROVED BY:

CAPTAIN MANUEL ANTONIO L. TAVAYO
Director General

NOTES/REVISIONS:

PROJECT:

IMPROVEMENT/REHABILITATION OF AIRWAYS FACILITY COMPLEX BUILDING

LOCATION:

CAAP CENTRAL OFFICE
NAIA RD., COR. N. AQUINO AVENUE,
PASAY CITY


SHEET CONTENTS

• SECOND FLOOR DETAILED PLAN

DRAWING SCALE: SHEET NO:

1:100 M A

4a 17

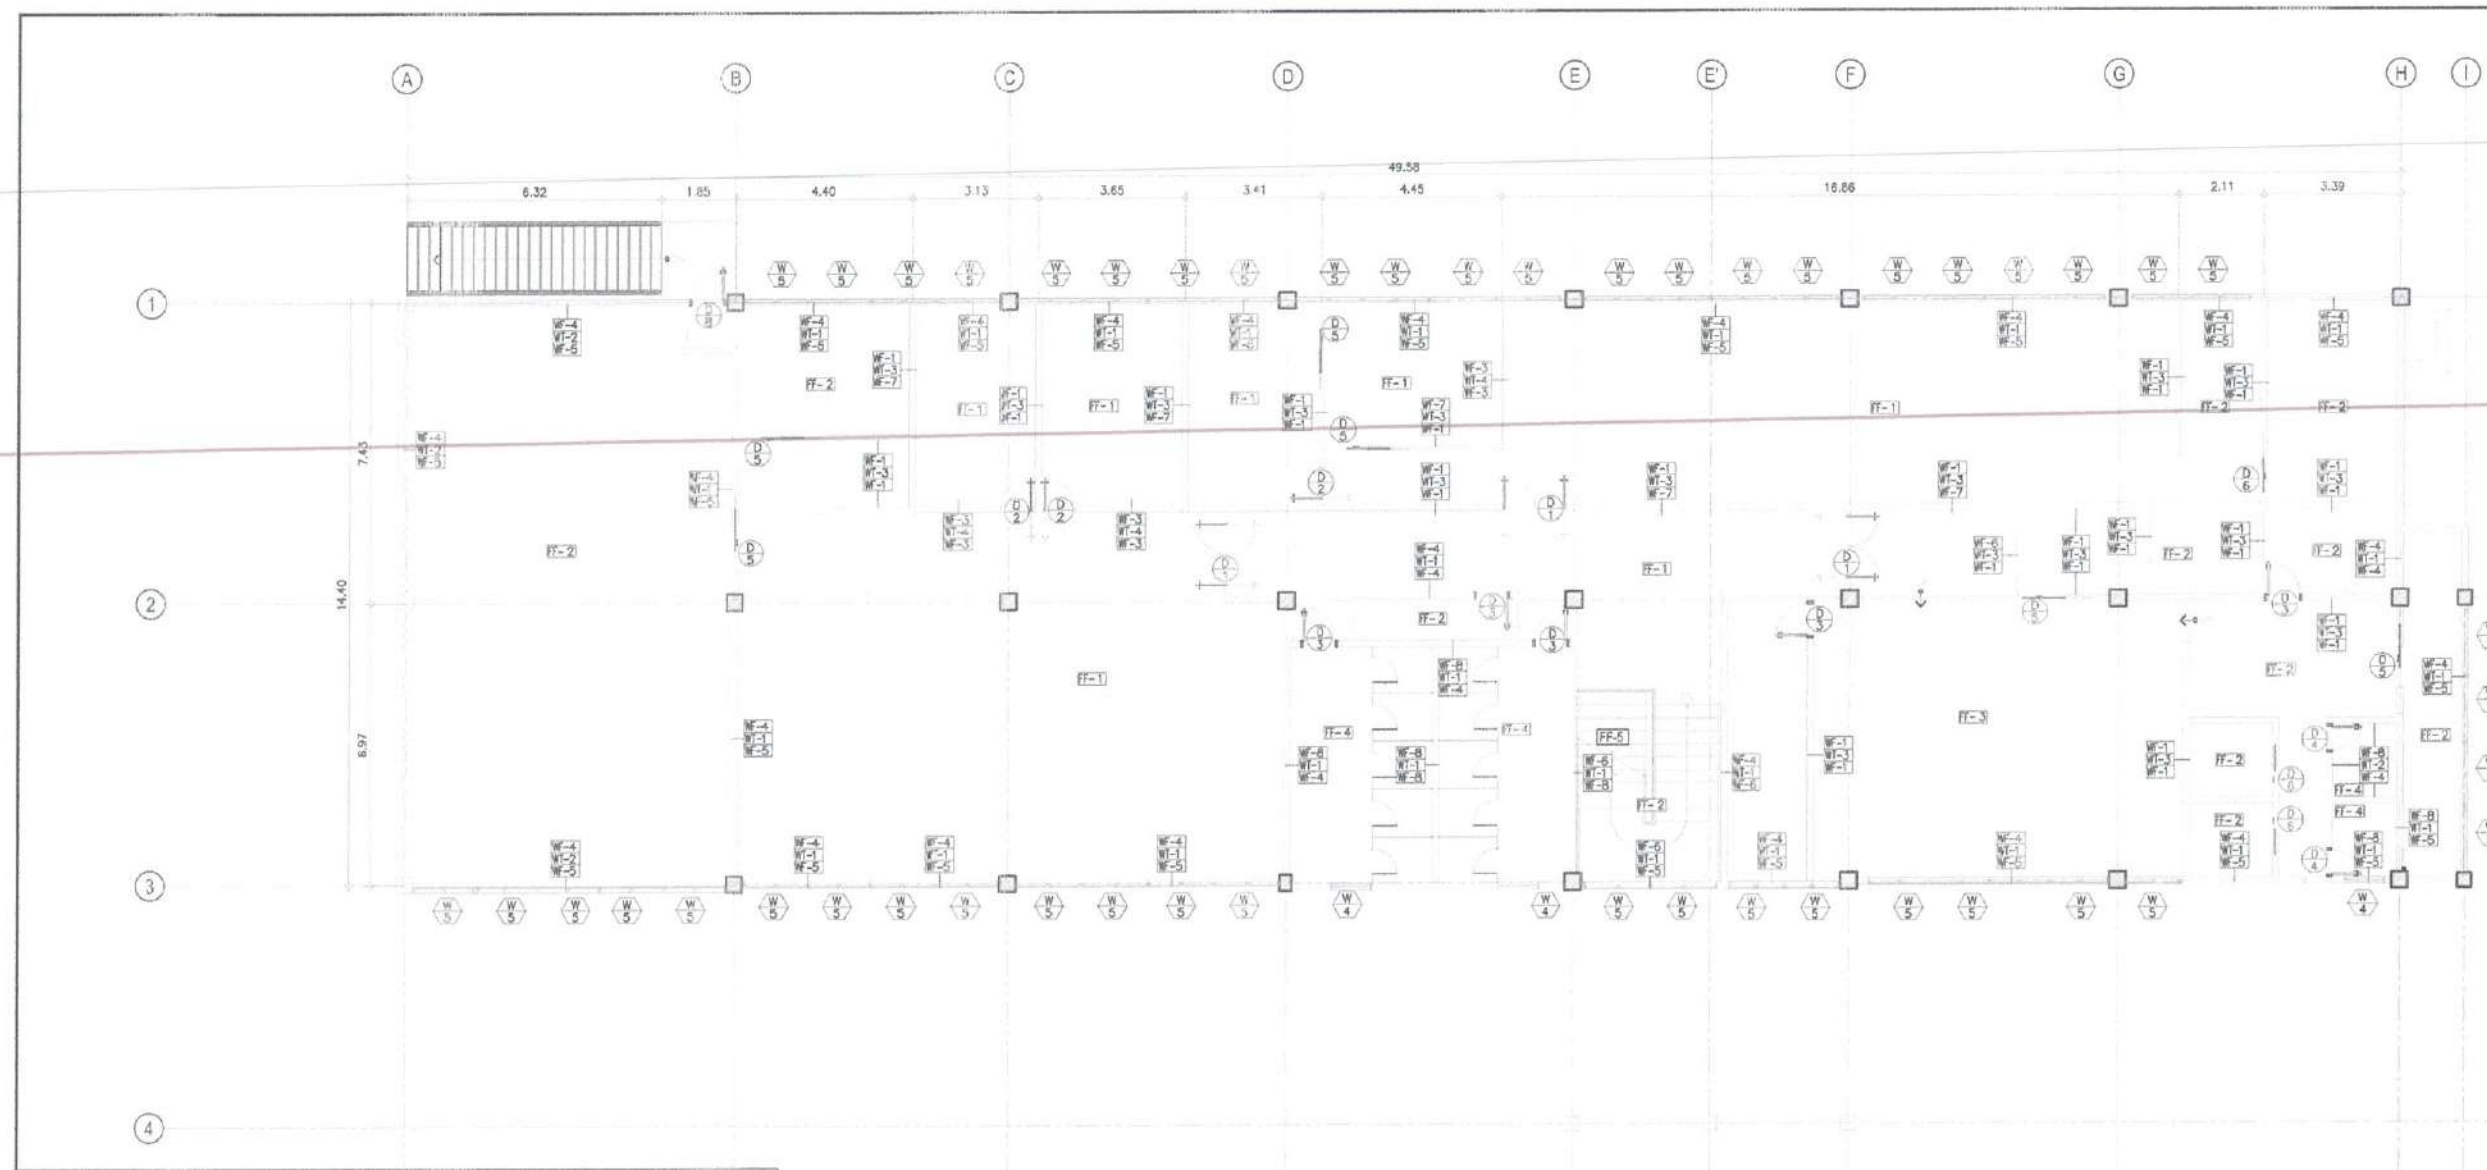

LEGEND


WF	WALL FACING MARK
WT	TYPE OF WALL
WF	OPPOSITE WALL FACING MARK

REMARKS


SECOND FLOOR DETAILED FLOOR PLAN

SCALE: 1:100 M

 BAR SCALE



SCHEDULE OF WALL FINISHES			SCHEDULE OF FLOOR FINISHES		
MARK	FINISHES	REMARKS	MARK	FINISHES	REMARKS
WF-1	150mm THK. DRY WALL PARTITION IN 12mm THK. FIBER CEMENT BOARD PAINTED FINISH WITH FOAM ROCKWOOL INSULATION (DOUBLE SIDED)		FF-1	10mm THK. x 600mm x 600mm HOMOGENEOUS PORCELAIN FLOOR TILES POLISHED FINISH (SUBMIT SAMPLE FOR APPROVAL)	
WF-2	12mm THK. FRAMELESS TEMPERED SMART GLASS (VERIFY ACTUAL FLOOR TO CEILING ELEVATION)		FF-2	10mm THK. x 600mm x 600mm HOMOGENEOUS PORCELAIN FLOOR TILES MATTE FINISH (SUBMIT SAMPLE FOR APPROVAL)	
WF-3	12mm THK. FRAMELESS TEMPERED GLASS (VERIFY ACTUAL FLOOR TO CEILING ELEVATION)		FF-3	30mm THK. x 600mm x 600mm with 3mm THK. ANTI-STATIC HPL CERAMIC COATED STEEL RAISED FLOORING (SUBMIT SAMPLE FOR APPROVAL)	
WF-4	150mm THK. CHB WALL PAINTED WITH 3 COATS OF ACRYLIC LATEX SEMI-GLOSS FINISH		FF-4	10mm THK. x 600mm x 600mm HOMOGENEOUS PORCELAIN FLOOR TILES MATTE FINISH (SUBMIT SAMPLE FOR APPROVAL)	
WF-5	150mm THK. CHB WALL PAINTED WITH ELASTOMERIC MATTE FINISH (WHITE)		FF-5	10mm THK. 300mm x 600mm HOMOGENEOUS PORCELAIN FLOOR TILES WITH WOOD-LIKE MATTE FINISH (SUBMIT SAMPLE FOR APPROVAL)	FOR MAIN STAIR TREADS
WF-6	150mm THK. WALL PAINTED WITH LIMEWASH FINISH		SCHEDULE OF WALL TYPES		
WF-7	200mm x 25mm WOOD PLASTIC COMPOSITE PANEL CLADDING ON DRY DRY WALL (VERIFY ACTUAL FLR TO CL ELEV.) PARTITION DARK OAK COLOR (SUBMIT SAMPLE FOR APPROVAL)		MARK	TYPES	REMARKS
WF-8	300mm x 600mm x 8mm THK. HOMOGENEOUS PORCELAIN TILE (MATTE FINISH) IN CHB WALL (SUBMIT SAMPLE FOR APPROVAL)		WT-1	EXISTING CHB WALL	
WF-9	150mm THK. CHB WALL PAINTED WITH ELASTOMERIC MATTE FINISH (BLUE)		WT-2	150mm THK. CHB WALL	
			WT-3	12mm THK. FIBER BOARD ON METAL STUDS	
			WT-4	12mm THK. TEMPERED GLASS PARTITION	

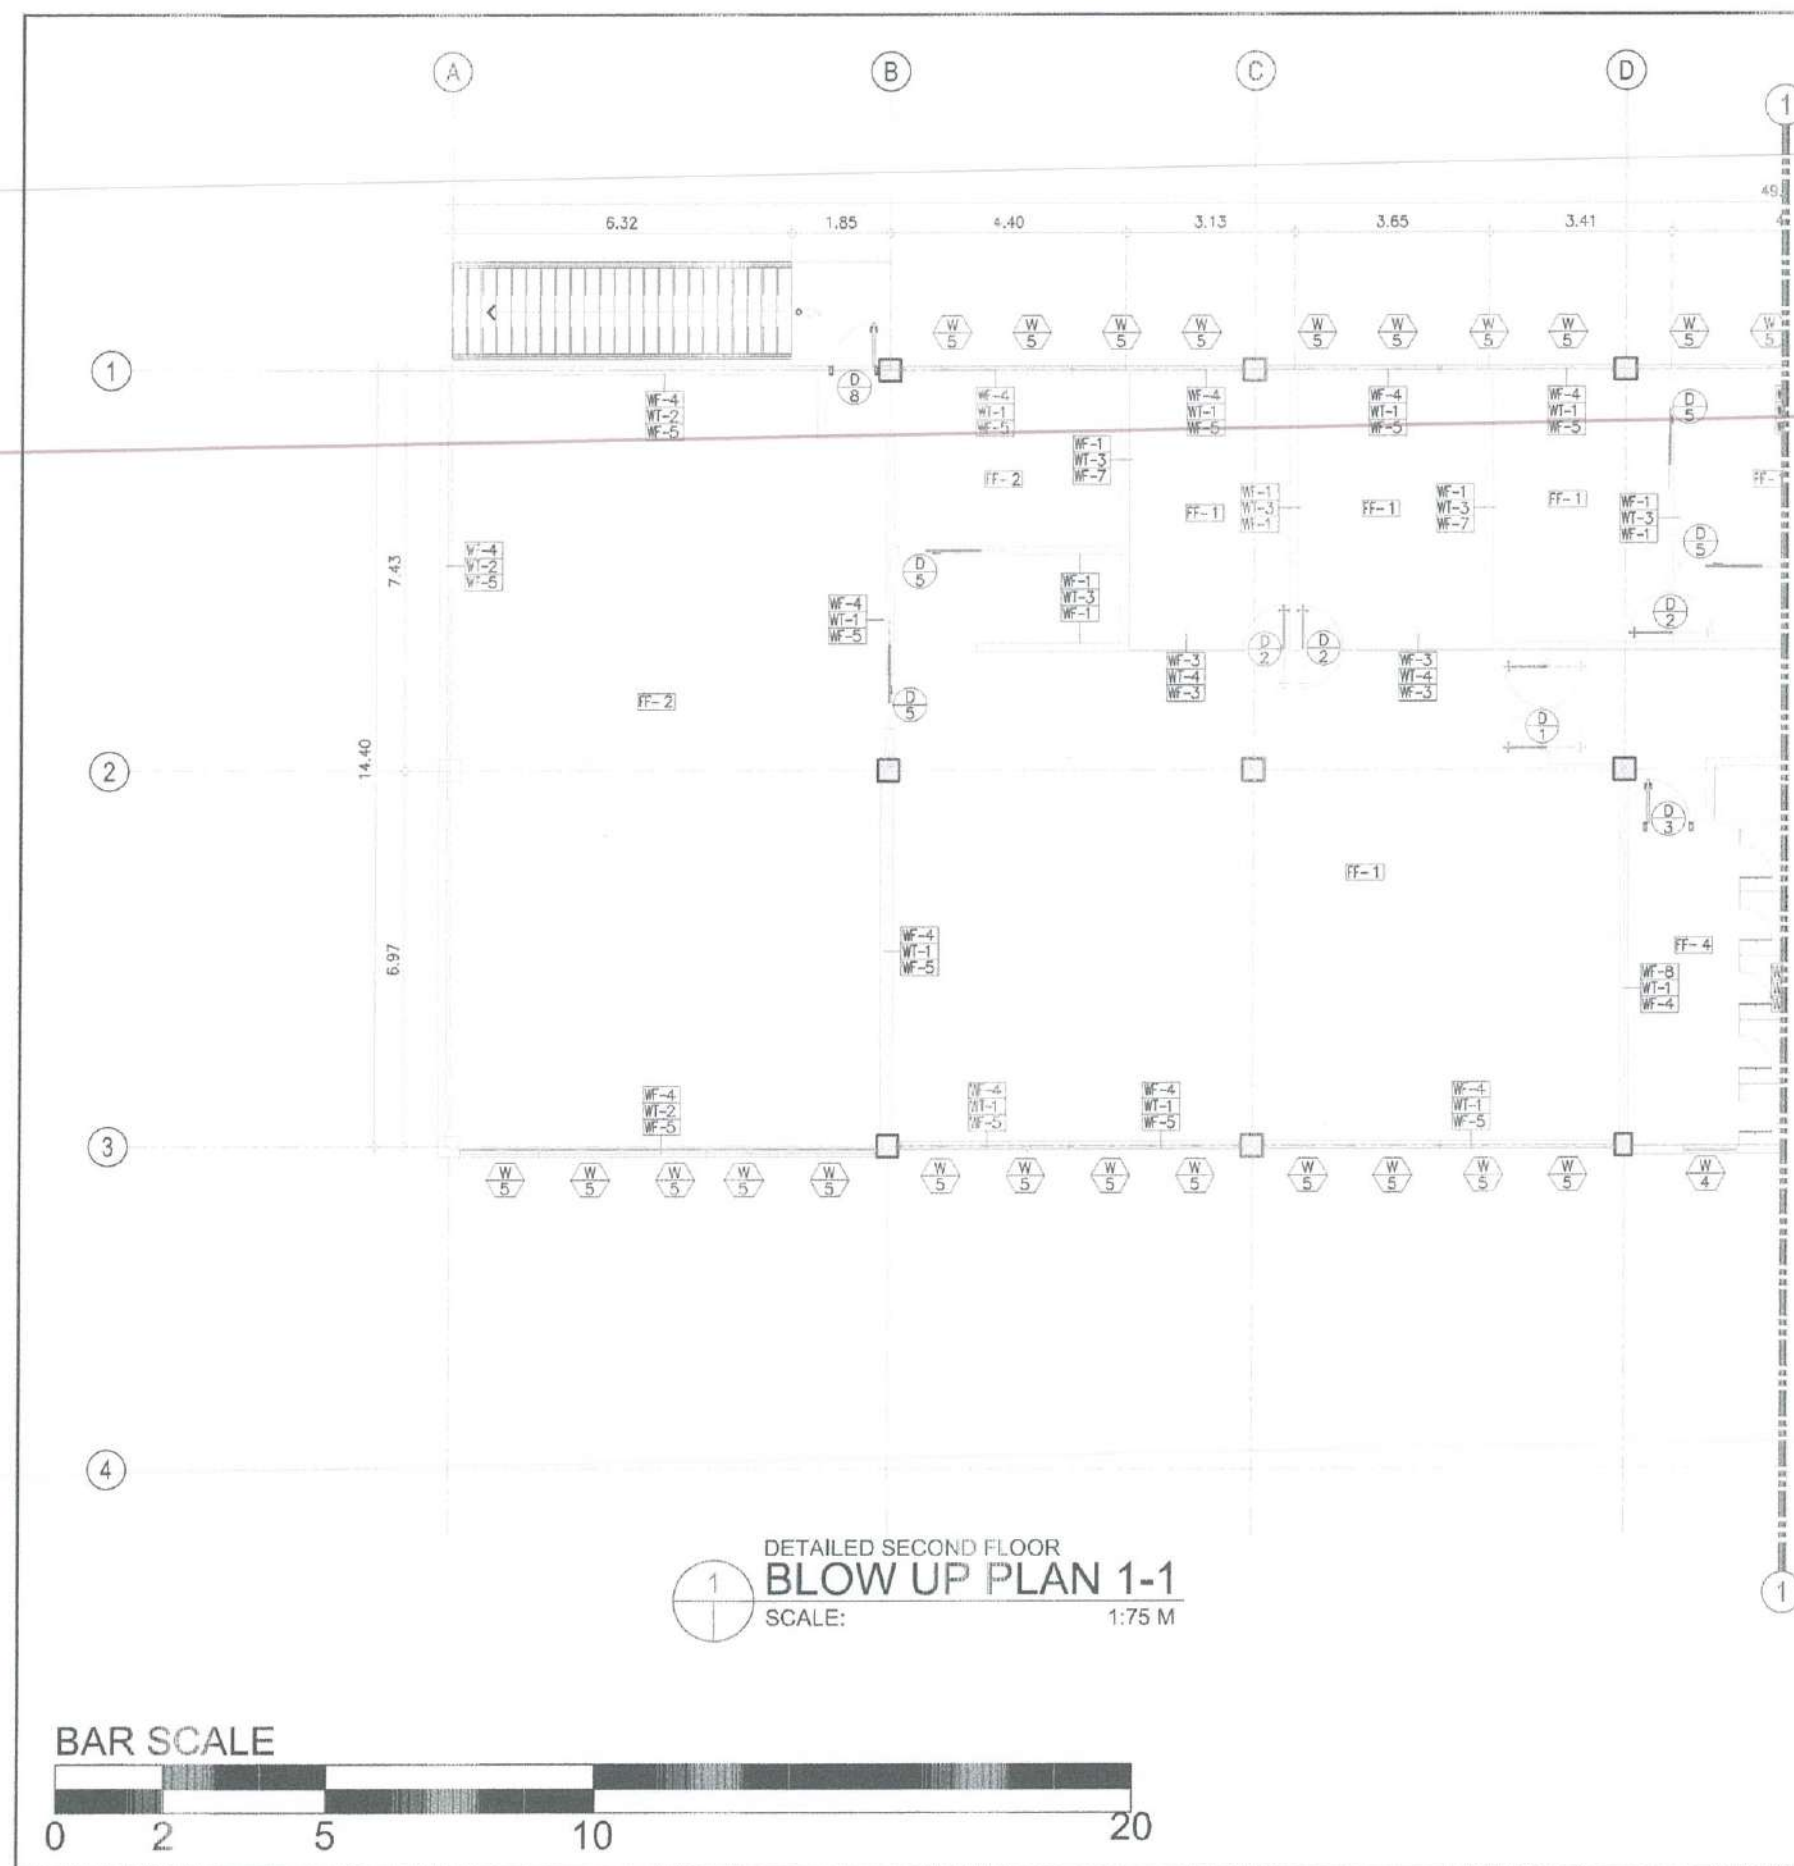

1
DETAILED SECOND FLOOR
BLOW UP PLAN 1-1
SCALE: 1:75 M

LEGEND		REMARKS
SCHEDULE OF WALL FINISHES		REMARKS
MARK	FINISHES	
WF-1	150mm THK. DRY WALL PARTITION IN 12mm THK. FIBER CEMENT BOARD PAINTED FINISH WITH FOAM ROCKWOOL INSULATION (DOUBLE SIDED)	
WF-2	12mm THK. FRAMELESS TEMPERED SMART GLASS (VERIFY ACTUAL FLOOR TO CEILING ELEVATION)	
WF-3	12mm THK. FRAMELESS TEMPERED GLASS (VERIFY ACTUAL FLOOR TO CEILING ELEVATION)	
WF-4	150mm THK. CHB WALL PAINTED WITH 3 COATS OF ACRYLIC LATEX SEMI-GLOSS FINISH	
WF-5	150mm THK. CHB WALL PAINTED WITH ELASTOMERIC MATTE FINISH (WHITE)	
WF-6	150mm THK. WALL PAINTED WITH LIMEWASH FINISH	
WF-7	200mm x 28mm WOOD PLASTIC COMPOSITE PANEL CLADDING ON DRY DRY WALL (VERIFY ACTUAL FLR TO CL ELEV.) PARTITION: DARK OAK COLOR (SUBMIT SAMPLE FOR APPROVAL)	
WF-8	300mm x 600mm x 8mm THK. HOMOGENOUS PORCELAIN TILE (MATTE FINISH) IN CHB WALL (SUBMIT SAMPLE FOR APPROVAL)	
WF-9	150mm THK. CHB WALL PAINTED WITH ELASTOMERIC MATTE FINISH (BLUE)	
SCHEDULE OF FLOOR FINISHES		REMARKS
MARK	FINISHES	
FF-1	10mm THK. x 600mm x 600mm HOMOGENOUS PORCELAIN FLOOR TILES POLISHED FINISH (SUBMIT SAMPLE FOR APPROVAL)	
FF-2	10mm THK. x 600mm x 600mm HOMOGENOUS PORCELAIN FLOOR TILES MATTE FINISH (SUBMIT SAMPLE FOR APPROVAL)	
FF-3	30mm THK. x 600mm x 600mm with 3mm THK. ANTI-STATIC HPL CERAMIC COATED STEEL RAISED FLOORING (SUBMIT SAMPLE FOR APPROVAL)	
FF-4	10mm THK. x 600mm x 600mm HOMOGENOUS PORCELAIN FLOOR TILES MATTE FINISH (SUBMIT SAMPLE FOR APPROVAL)	
FF-5	10mm THK. 300mm x 600mm HOMOGENOUS PORCELAIN FLOOR TILES WITH WOOD-LIKE MATTE FINISH (SUBMIT SAMPLE FOR APPROVAL)	FOR MAIN STAIR TREADS
SCHEDULE OF WALL TYPES		REMARKS
MARK	TYPES	
WT-1	EXISTING CHB WALL	
WT-2	150mm THK. CHB WALL	
WT-3	12mm THK. FIBER BOARD ON METAL STUDS	
WT-4	12mm THK. TEMPERED GLASS PARTITION	

REPUBLIC OF THE PHILIPPINES CIVIL AVIATION AUTHORITY OF THE PHILIPPINES AERODROME DEVELOPMENT AND MANAGEMENT SERVICE NAIA ROAD, 1385 PASAY CITY	
THIS DRAWINGS AND DESIGN IS EXCLUSIVE PROPERTY OF CIVIL AVIATION AUTHORITY OF THE PHILIPPINES AND SUCH MUST NOT BE REPRODUCED, EXHIBITED, LOANED NOR COPIED IN PART OR IN WHOLE WITHOUT PROPER PERMISSION AND/OR WRITTEN CONSENT FROM THE DIRECTOR GENERAL CAAP.	
AERODROME DEVELOPMENT AND MANAGEMENT SERVICE	
INFRASTRUCTURE DEVELOPMENT AND DESIGN DIVISION	
DESIGN STAFF:	INITIAL / DATE
DESIGNED BY:	DDG
DRAWN BY:	DRG/AMPLR
CHECKED BY:	
REVIEWED BY:	
 RAUL R. CRUZENA Division Chief (AED)-AED	
SUBMITTED BY:	
 ARNEL F. BORLADO Department Manager (B) AED-AEDMS	
RECOMMEND APPROVAL:	
 LT. COL. VALENTIN A. DIONELA PAF (RET) Assistant Director General (B) AEDMS	
APPROVED BY:	
 CAPTAIN RAFAEL ANTONIO L. AMAYO Director General (A) AEDMS	
NOTES/REVISIONS:	
PROJECT:	
IMPROVEMENT/REHABILITATION OF AIRWAYS FACILITY COMPLEX BUILDING	
LOCATION:	
CAAP CENTRAL OFFICE NAIA RD, COR. N. AQUINO AVENUE, PASAY CITY	
SHEET COMMENTS:	
• DETAILED SECOND FLOOR BLOW-UP PLAN	
DRAWING SCALE:	SHEET NO.
1:75 M	A 17



REPUBLIC OF THE PHILIPPINES
CIVIL AVIATION AUTHORITY OF THE PHILIPPINES
AERODROME DEVELOPMENT AND MANAGEMENT SERVICE
NAIA RD. 120 PASAY CITY

THIS DRAWINGS AND DESIGN IS EXCLUSIVE PROPERTY OF CIVIL AVIATION AUTHORITY OF THE PHILIPPINES AND SUCH MUST NOT BE REPRODUCED, EXHIBITED, LOANED NOR COPIED IN PART OR IN WHOLE WITHOUT PROPER PERMISSION AND/OR WRITTEN CONSENT FROM THE DIRECTOR GENERAL CAA.

AERODROME DEVELOPMENT AND MANAGEMENT SERVICE

INFRASTRUCTURE DEVELOPMENT AND DESIGN DIVISION

DESIGN STAFF: INITIAL / DATE
DESIGNED BY: IODD
DRAWN BY: DRPG/PLR
CHECKED BY:

REVIEWED BY:

RAUL R. CRUCENA
Division Chief, IODD-AED

SUBMITTED BY:

ARNEL F. BORLADO
Department Manager III, AED-ADMS

RECOMMEND APPROVAL:

LT COL. VALENTINO A. DIONELA PAF (RET.)
Assistant Director General III, ADMS

APPROVED BY:

CAPTAIN MAURICE JOYCE L. TAMAYO
Director

NOTES/REVISIONS:

PROJECT:

IMPROVEMENT/REHABILITATION OF AIRWAYS FACILITY COMPLEX BUILDING

LOCATION:


CAAP CENTRAL OFFICE
NAIA RD., COR. N. AQUINO AVENUE,
PASAY CITY

SHEET CONTENTS:

• DETAILED GROUND FLOOR BLOW-UP PLAN


DRAWING SCALE: SHEET NO:

1:75 M A 17

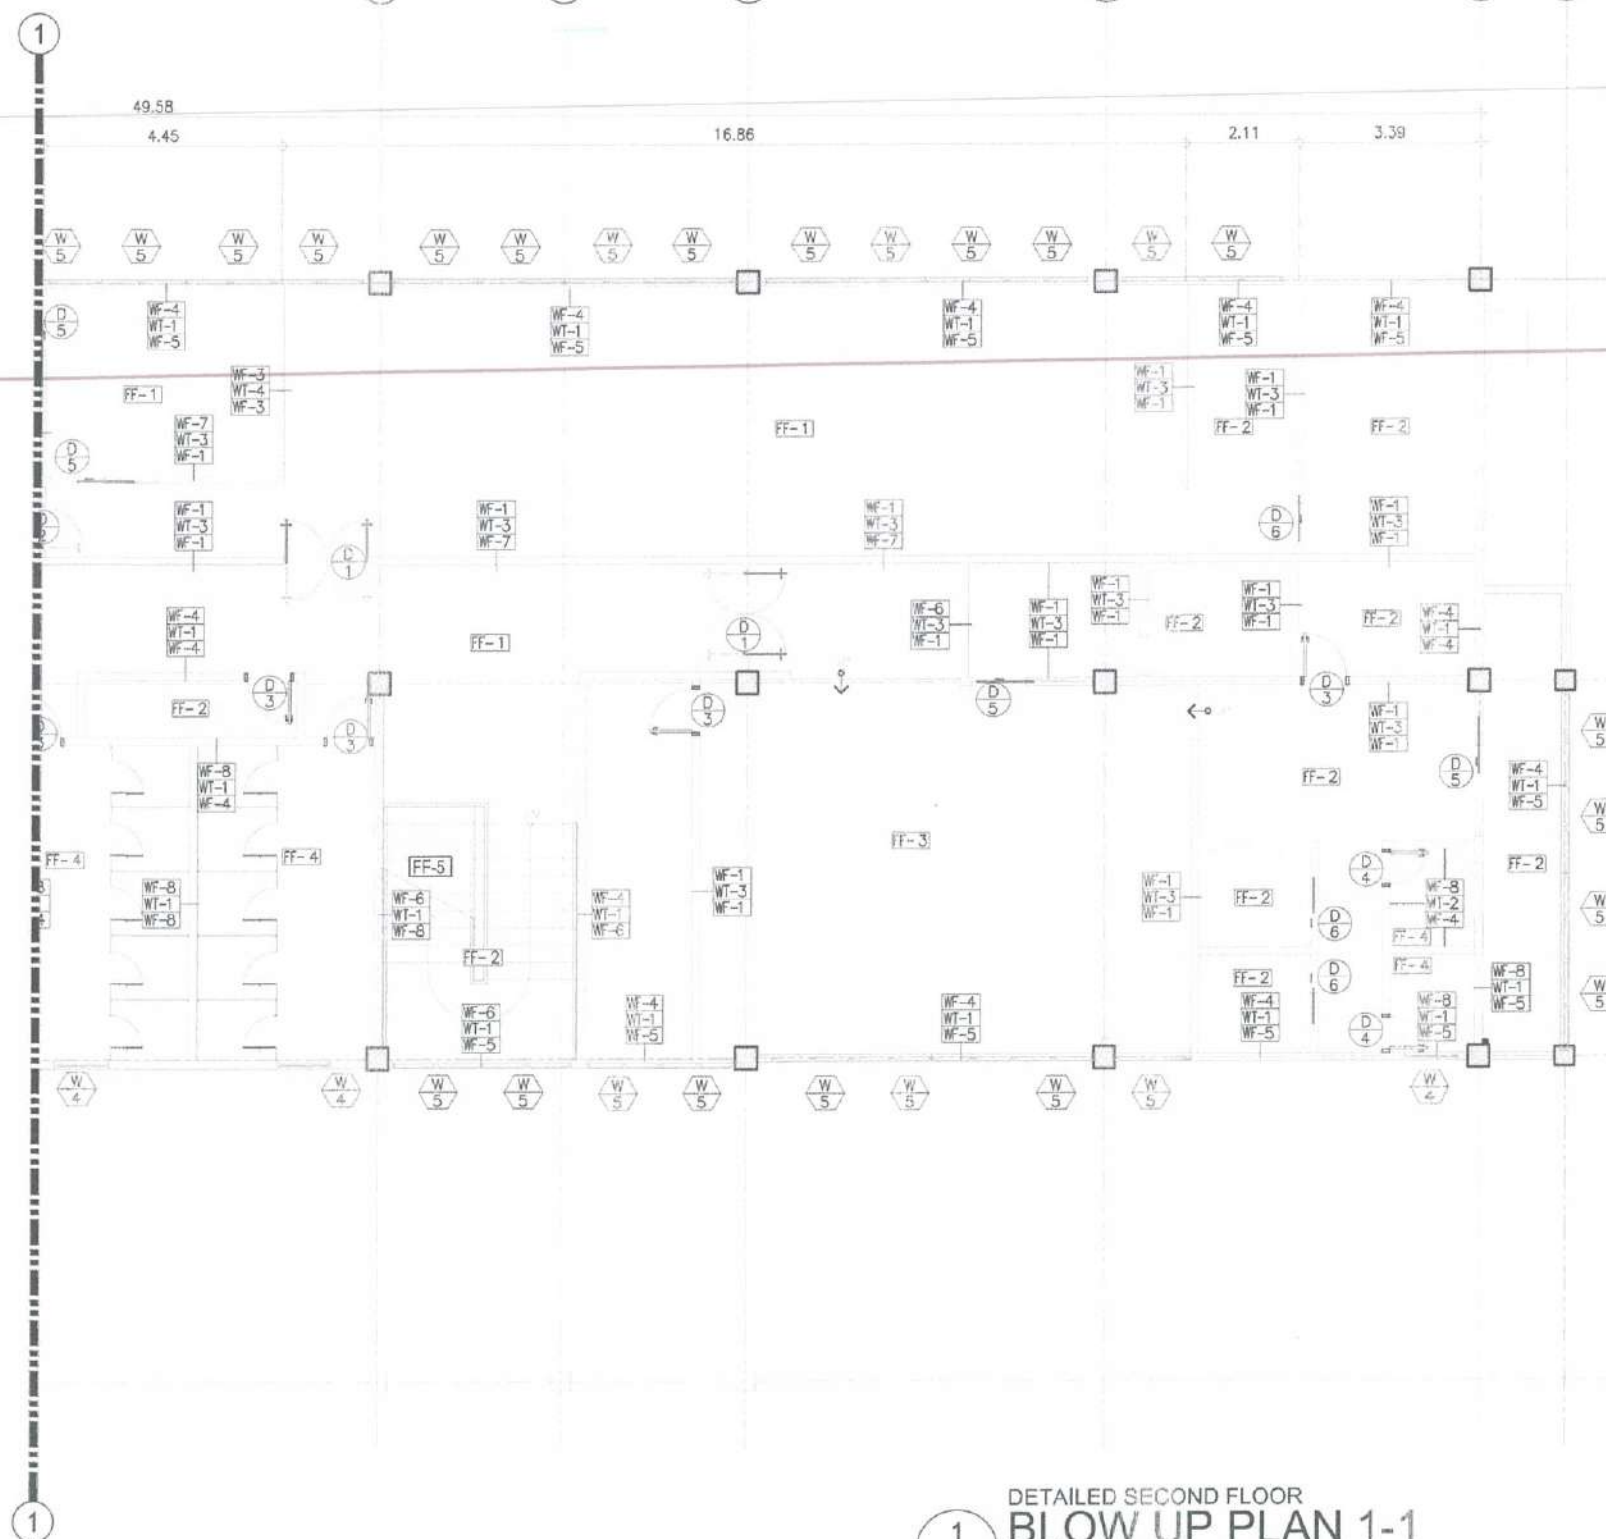

1
DETAILED SECOND FLOOR
BLOW UP PLAN 1-1
SCALE: 1:75 M

 BAR SCALE



LEGEND		REMARKS
WF	WALL FACING MARK	
WT	TYPE OF WALL	
WF	OPPOSITE WALL FACING MARK	

SCHEDULE OF WALL FINISHES		REMARKS
MARK	FINISHES	
WF-1	150mm THK. DRY WALL PARTITION IN 12mm THK. FIBER CEMENT BOARD PAINTED FINISH WITH FOAM ROCKWOOL INSULATION (DOUBLE SIDED)	
WF-2	12mm THK. FRAMELESS TEMPERED SMART GLASS (VERIFY ACTUAL FLOOR TO CEILING ELEVATION)	
WF-3	12mm THK. FRAMELESS TEMPERED GLASS (VERIFY ACTUAL FLOOR TO CEILING ELEVATION)	
WF-4	150mm THK. CHB WALL PAINTED WITH 3 COATS OF ACRYLIC LATEX SEMI-GLOSS FINISH	
WF-5	150mm THK. CHB WALL PAINTED WITH ELASTOMERIC MATTE FINISH (WHITE)	
WF-6	150mm THK. WALL PAINTED WITH LIMEWASH FINISH	
WF-7	200mm x 28mm WOOD PLASTIC COMPOSITE PANEL CLADDING ON DRY WALL (VERIFY ACTUAL FLR TO CL ELEV.) PARTITION: DARK OAK COLOR (SUBMIT SAMPLE FOR APPROVAL)	
WF-8	300mm x 600mm x 8mm THK. HOMOGENOUS PORCELAIN TILE (MATTE FINISH) IN CHB WALL (SUBMIT SAMPLE FOR APPROVAL)	
WF-9	150mm THK. CHB WALL PAINTED WITH ELASTOMERIC MATTE FINISH (BLUE)	

SCHEDULE OF FLOOR FINISHES		REMARKS
MARK	FINISHES	
FF-1	10mm THK. x 600mm x 600mm HOMOGENOUS PORCELAIN FLOOR TILES POLISHED FINISH (SUBMIT SAMPLE FOR APPROVAL)	
FF-2	10mm THK. x 600mm x 600mm HOMOGENOUS PORCELAIN FLOOR TILES MATTE FINISH (SUBMIT SAMPLE FOR APPROVAL)	
FF-3	30mm THK. x 600mm x 600mm with 3mm THK. ANTI-STATIC HPL CERAMIC COATED STEEL RAISED FLOORING (SUBMIT SAMPLE FOR APPROVAL)	
FF-4	10mm THK. x 600mm x 600mm HOMOGENOUS PORCELAIN FLOOR TILES MATTE FINISH (SUBMIT SAMPLE FOR APPROVAL)	
FF-5	10mm THK. 300mm x 600mm HOMOGENOUS PORCELAIN FLOOR TILES WITH WOOD-LIKE MATTE FINISH (SUBMIT SAMPLE FOR APPROVAL)	FOR MAIN STAIR TREADS

SCHEDULE OF WALL TYPES		REMARKS
MARK	TYPES	
WT-1	EXISTING CHB WALL	
WT-2	150mm THK. CHB WALL	
WT-3	12mm THK. FIBER BOARD ON METAL STUDS	
WT-4	12mm THK. TEMPERED GLASS PARTITION	



REPUBLIC OF THE PHILIPPINES
CIVIL AVIATION AUTHORITY OF THE PHILIPPINES
AERODROME DEVELOPMENT AND MANAGEMENT SERVICE
NAIA ROAD, 1055 PASAY CITY

THIS DRAWING AND DESIGN IS EXCLUSIVE PROPERTY OF CIVIL AVIATION AUTHORITY OF THE PHILIPPINES AND SUCH MUST NOT BE REPRODUCED, EXHIBITED, LOANED NOR COPIED IN PART OR IN WHOLE WITHOUT PROPER PERMISSION AND/OR WRITTEN CONSENT FROM THE DIRECTOR GENERAL CAA.

AERODROME DEVELOPMENT AND MANAGEMENT SERVICE

INFRASTRUCTURE DEVELOPMENT AND DESIGN DIVISION

DESIGN STAFF: INITIAL / DATE
DESIGNED BY: IDDD
DRAWN BY: DRPG/MLR
CHECKED BY:

REVIEWED BY:

RAUL R. CRUCENA
Division Chief, IDDD-AED

SUBMITTED BY:

ARNEL F. BORLADO
Department Manager III, AED-ADMS

RECOMMEND APPROVAL:

LT COL. VALENTINO A. DIONELA PAF (RET)
Assistant Director General III, ADMS

APPROVED BY:

CAPTAIN MARCELO L. TAVAYO
Director General

NOTES/REVISIONS:

PROJECT:

IMPROVEMENT/REHABILITATION OF AIRWAYS FACILITY COMPLEX BUILDING

LOCATION:

CAAP CENTRAL OFFICE
NAIA RD. COR. N. AQUINO AVENUE,
PASAY CITY


SHEET CONTENTS:

• GROUND FLOOR REFLECTED CEILING PLAN

DRAWING SCALE: SHEET NO:

1:100 M A

05 17

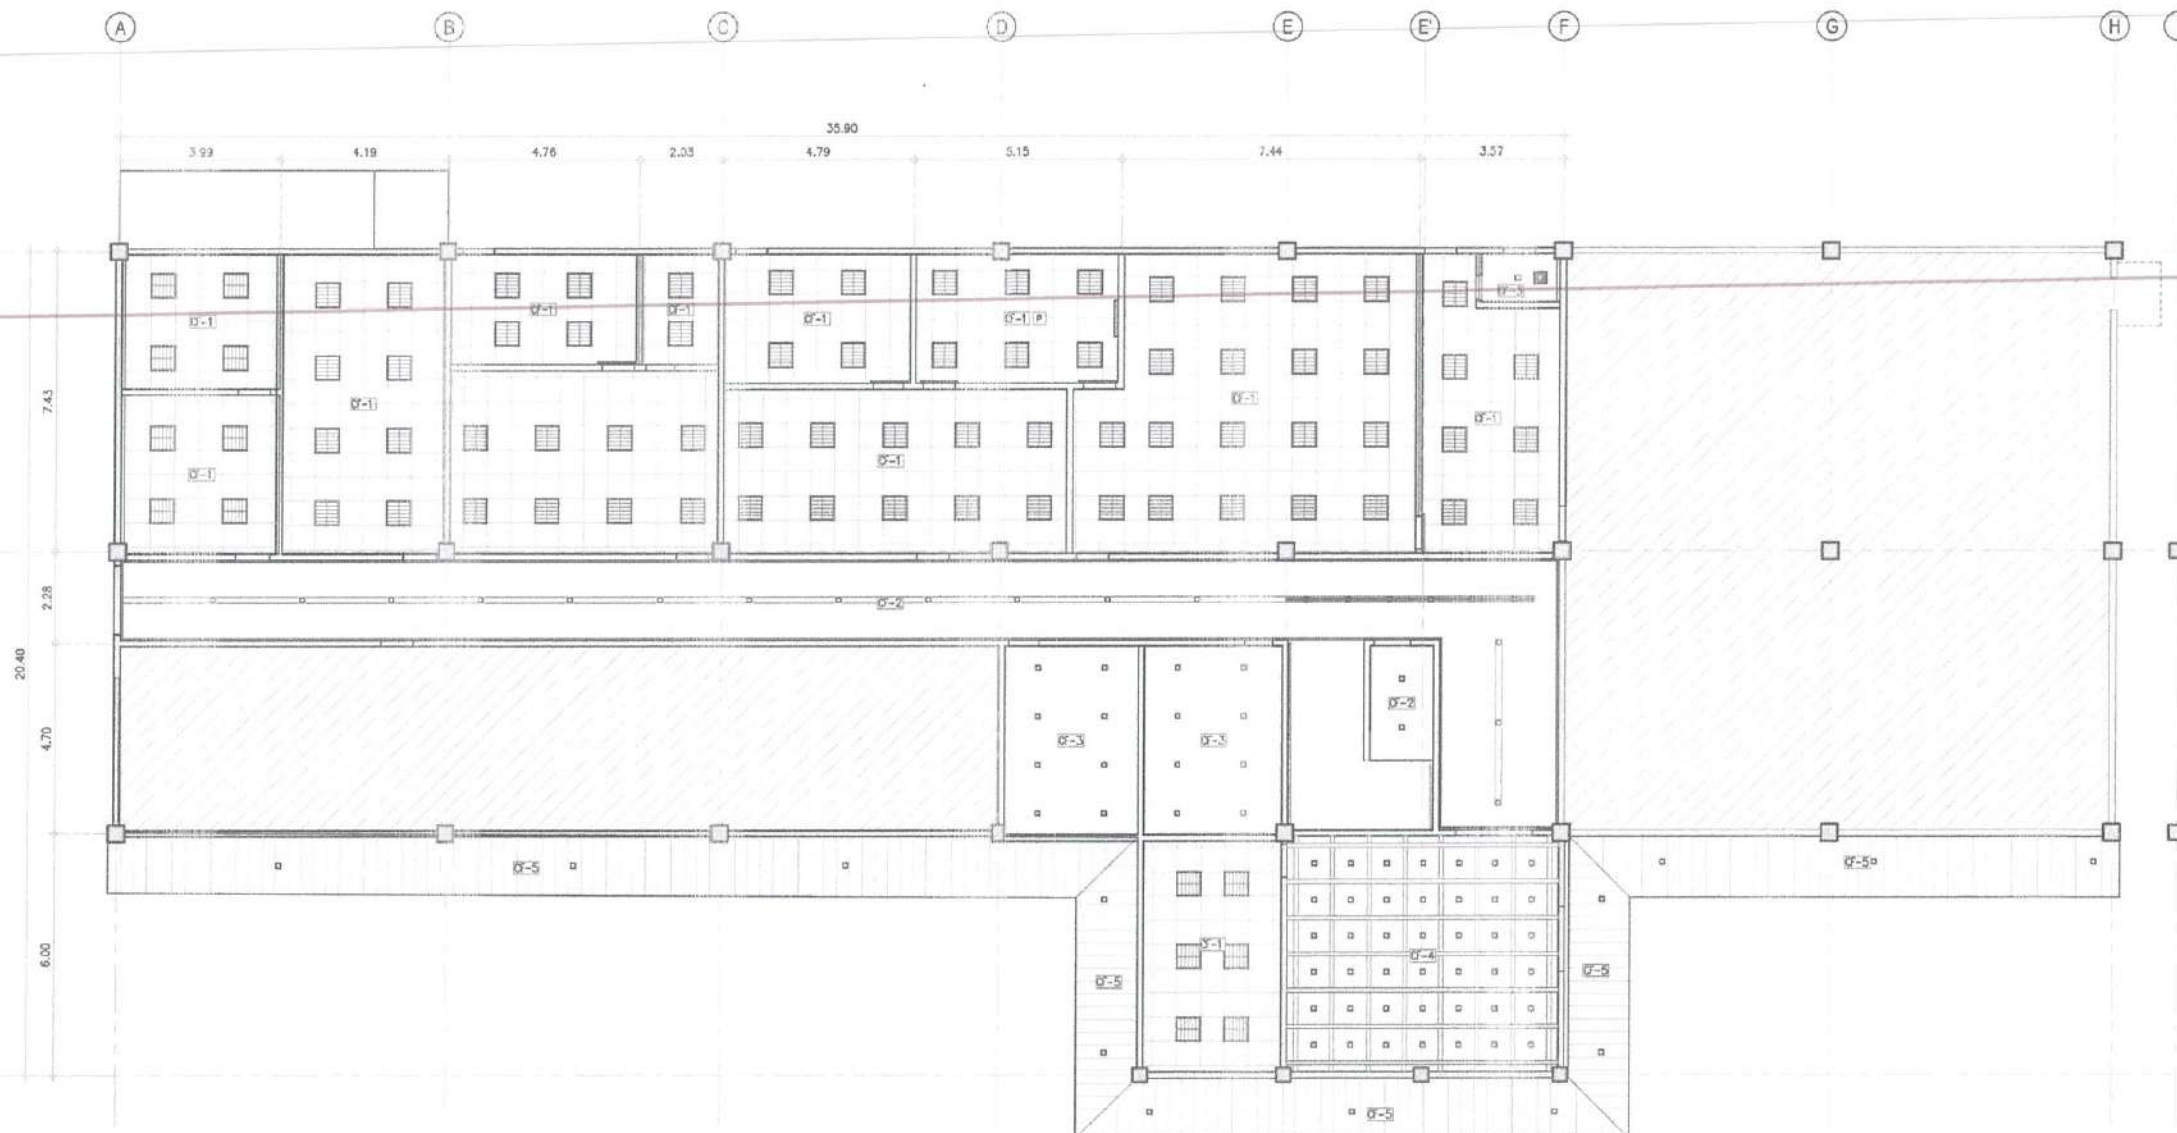


LEGEND

□	6" x 6" RECESSED SQUARE LED DOWNLIGHT
—	MONORAIL TRACK LIGHTING
■	RECESSED LOUVER TYPE LED LIGHTING FIXTURE
—	ROLL-UP FABRIC CURTAIN
■	CEILING MOUNTED EXHAUST FAN
■	CEILING MOUNTED PROJECTOR
—	CONCEALED PROJECTOR SCREEN
TAG	CEILING FINISHES
CF-1	9 MM THK. 600 MM X 600 MM PVC LAMINATED GYPSUM BOARD WITH FOIL BACKING ON SUSPENDED CEILING SYSTEM (ORANGE SKIN FINISH)
CF-2	12MM THK GYPSUM BOARD IN LATEX PAINT FINISH
CF-3	12MM THK MOISTURE RESISTANT GYPSUM BOARD IN LATEX PAINT FINISH
CF-4	1"x 4" KILN DRIED LUMBER @ 0.90M x 0.90M O.C. COFFERED CEILING ON 12MM THK MARINE PLYWOOD IN ENAMEL PAINT FLAT FINISH (COLOR: VERIFY ARCHITECT)
CF-5	1500MM X 110MM X 0.60MM METAL SPANDREL CEILING (COLOR: VERIFY ARCHITECT)

GROUND FLOOR
REFLECTED CEILING PLAN
SCALE: 1:100 M


BAR SCALE



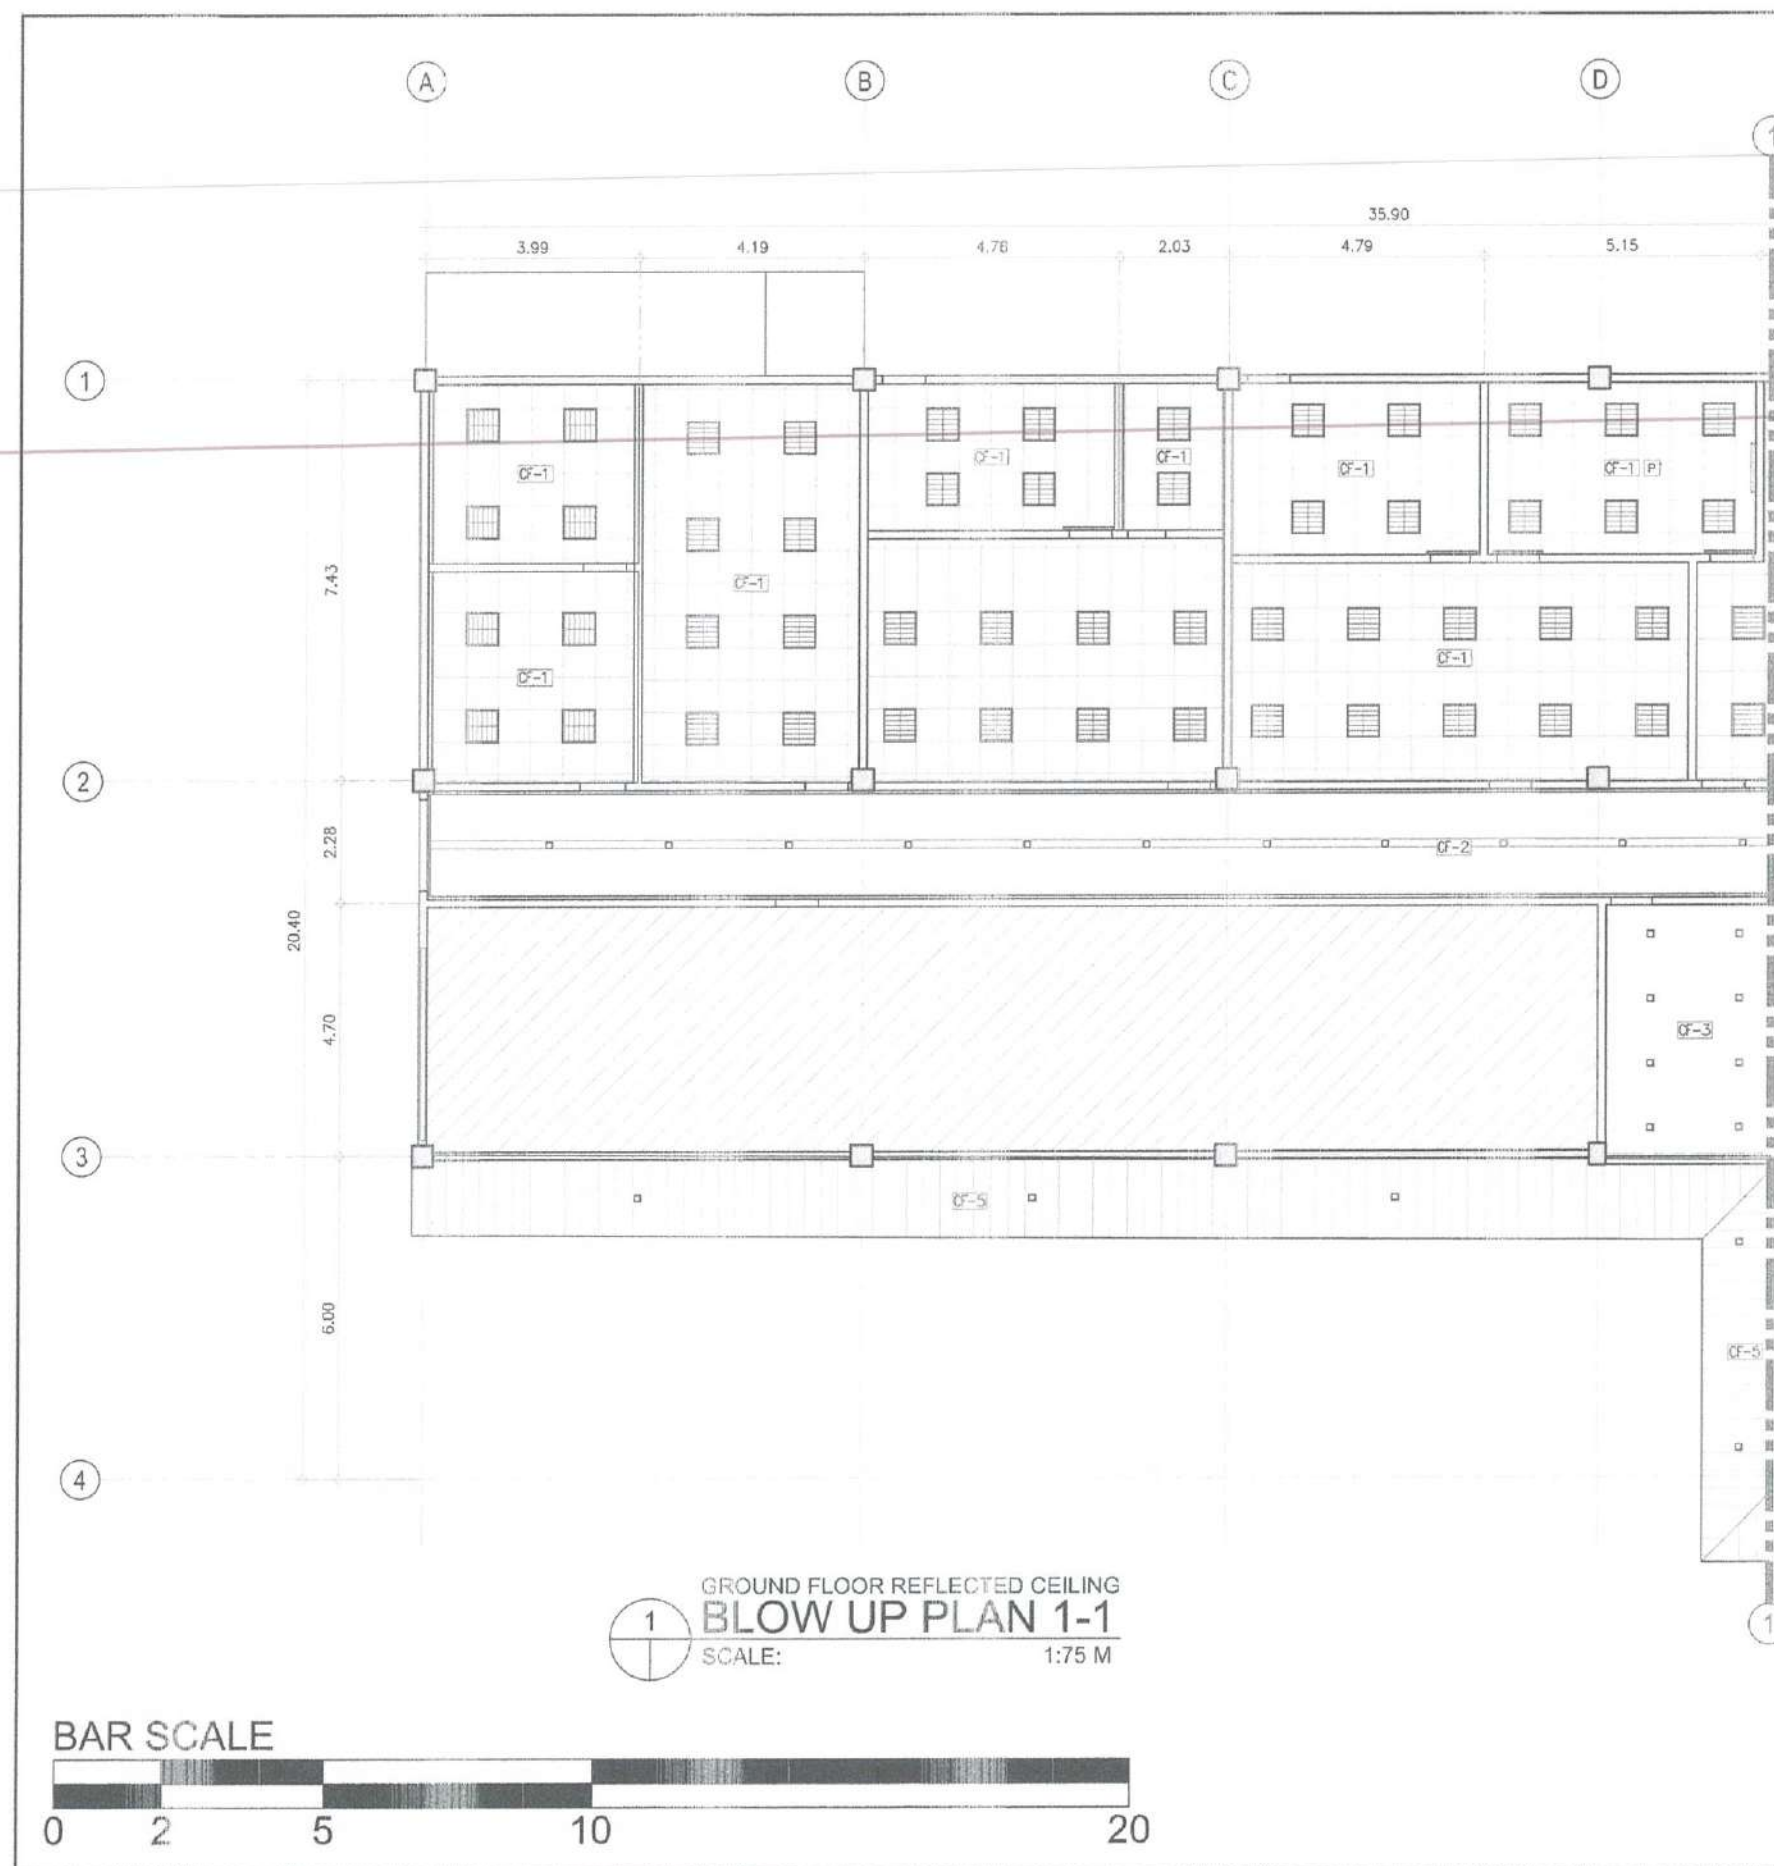


LEGEND	
	6" x 6" RECESSED SQUARE LED DOWNLIGHT
	MONORAIL TRACK LIGHTING
	RECESSED LOUVER TYPE LED LIGHTING FIXTURE
	ROLL-UP FABRIC CURTAIN
	CEILING MOUNTED EXHAUST FAN
	CEILING MOUNTED PROJECTOR
	CONCEALED PROJECTOR SCREEN
TAG	CEILING FINISHES
CF-1	9 MM THK. 600 MM X 600 MM PVC LAMINATED GYPSUM BOARD WITH FOIL BACKING ON SUSPENDED CEILING SYSTEM (ORANGE SKIN FINISH)
CF-2	12MM THK GYPSUM BOARD IN LATEX PAINT FINISH
CF-3	12MM THK MOISTURE RESISTANT GYPSUM BOARD IN LATEX PAINT FINISH
CF-4	1"x 4" KILN DRIED LUMBER @ 0.90M x 0.90M O.C. COFFERED CEILING ON 12MM THK. MARINE PLYWOOD IN ENAMEL PAINT FLAT FINISH (COLOR: VERIFY ARCHITECT)
CF-5	1500MM X 1100MM X 0.60MM METAL SPANDREL CEILING (COLOR: VERIFY ARCHITECT)

REPUBLIC OF THE PHILIPPINES CIVIL AVIATION AUTHORITY OF THE PHILIPPINES AERODROME DEVELOPMENT AND MANAGEMENT SERVICE NAIA RD. 128 PASAY CITY	
THIS DRAWINGS AND DESIGN IS EXCLUSIVE PROPERTY OF CIVIL AVIATION AUTHORITY OF THE PHILIPPINES AND SUCH MUST NOT BE REPRODUCED, EXHIBITED, LOANED NOR COPIED IN PART OR IN WHOLE WITHOUT PROPER PERMISSION AND/OR WRITTEN CONSENT FROM THE DIRECTOR GENERAL CAA.	
AERODROME DEVELOPMENT AND MANAGEMENT SERVICE	
INFRASTRUCTURE DEVELOPMENT AND DESIGN DIVISION	
DESIGN STAFF:	INITIAL / DATE
DESIGNED BY:	ICDD
DRAWN BY:	DRPS/MLR <i>M222</i>
CHECKED BY:	
REVIEWED BY: RAUL R. LUCENA Division Chief II, AED-ADM	
SUBMITTED BY: ARNEL F. BORLADO Department Manager III, AED-ADM	
RECOMMEND APPROVAL: LT COL. VALENTIN A. DIONELA PAF (RET) Assistant Director General II, ADM	
APPROVED BY: CAPTAIN MANUEL ANTONIO L. TAMAYO Director General	
NOTES/REVISIONS:	
PROJECT: IMPROVEMENT/REHABILITATION OF AIRWAYS FACILITY COMPLEX BUILDING	
LOCATION: CAAP CENTRAL OFFICE NAIA RD. COR. N. AQUINO AVENUE, PASAY CITY	
SHEET CONTENTS: • GROUND FLOOR REFLECTED CEILING BLOW-UP PLAN	
DRAWING SCALE:	SHEET NO:
1:75 M	A 17

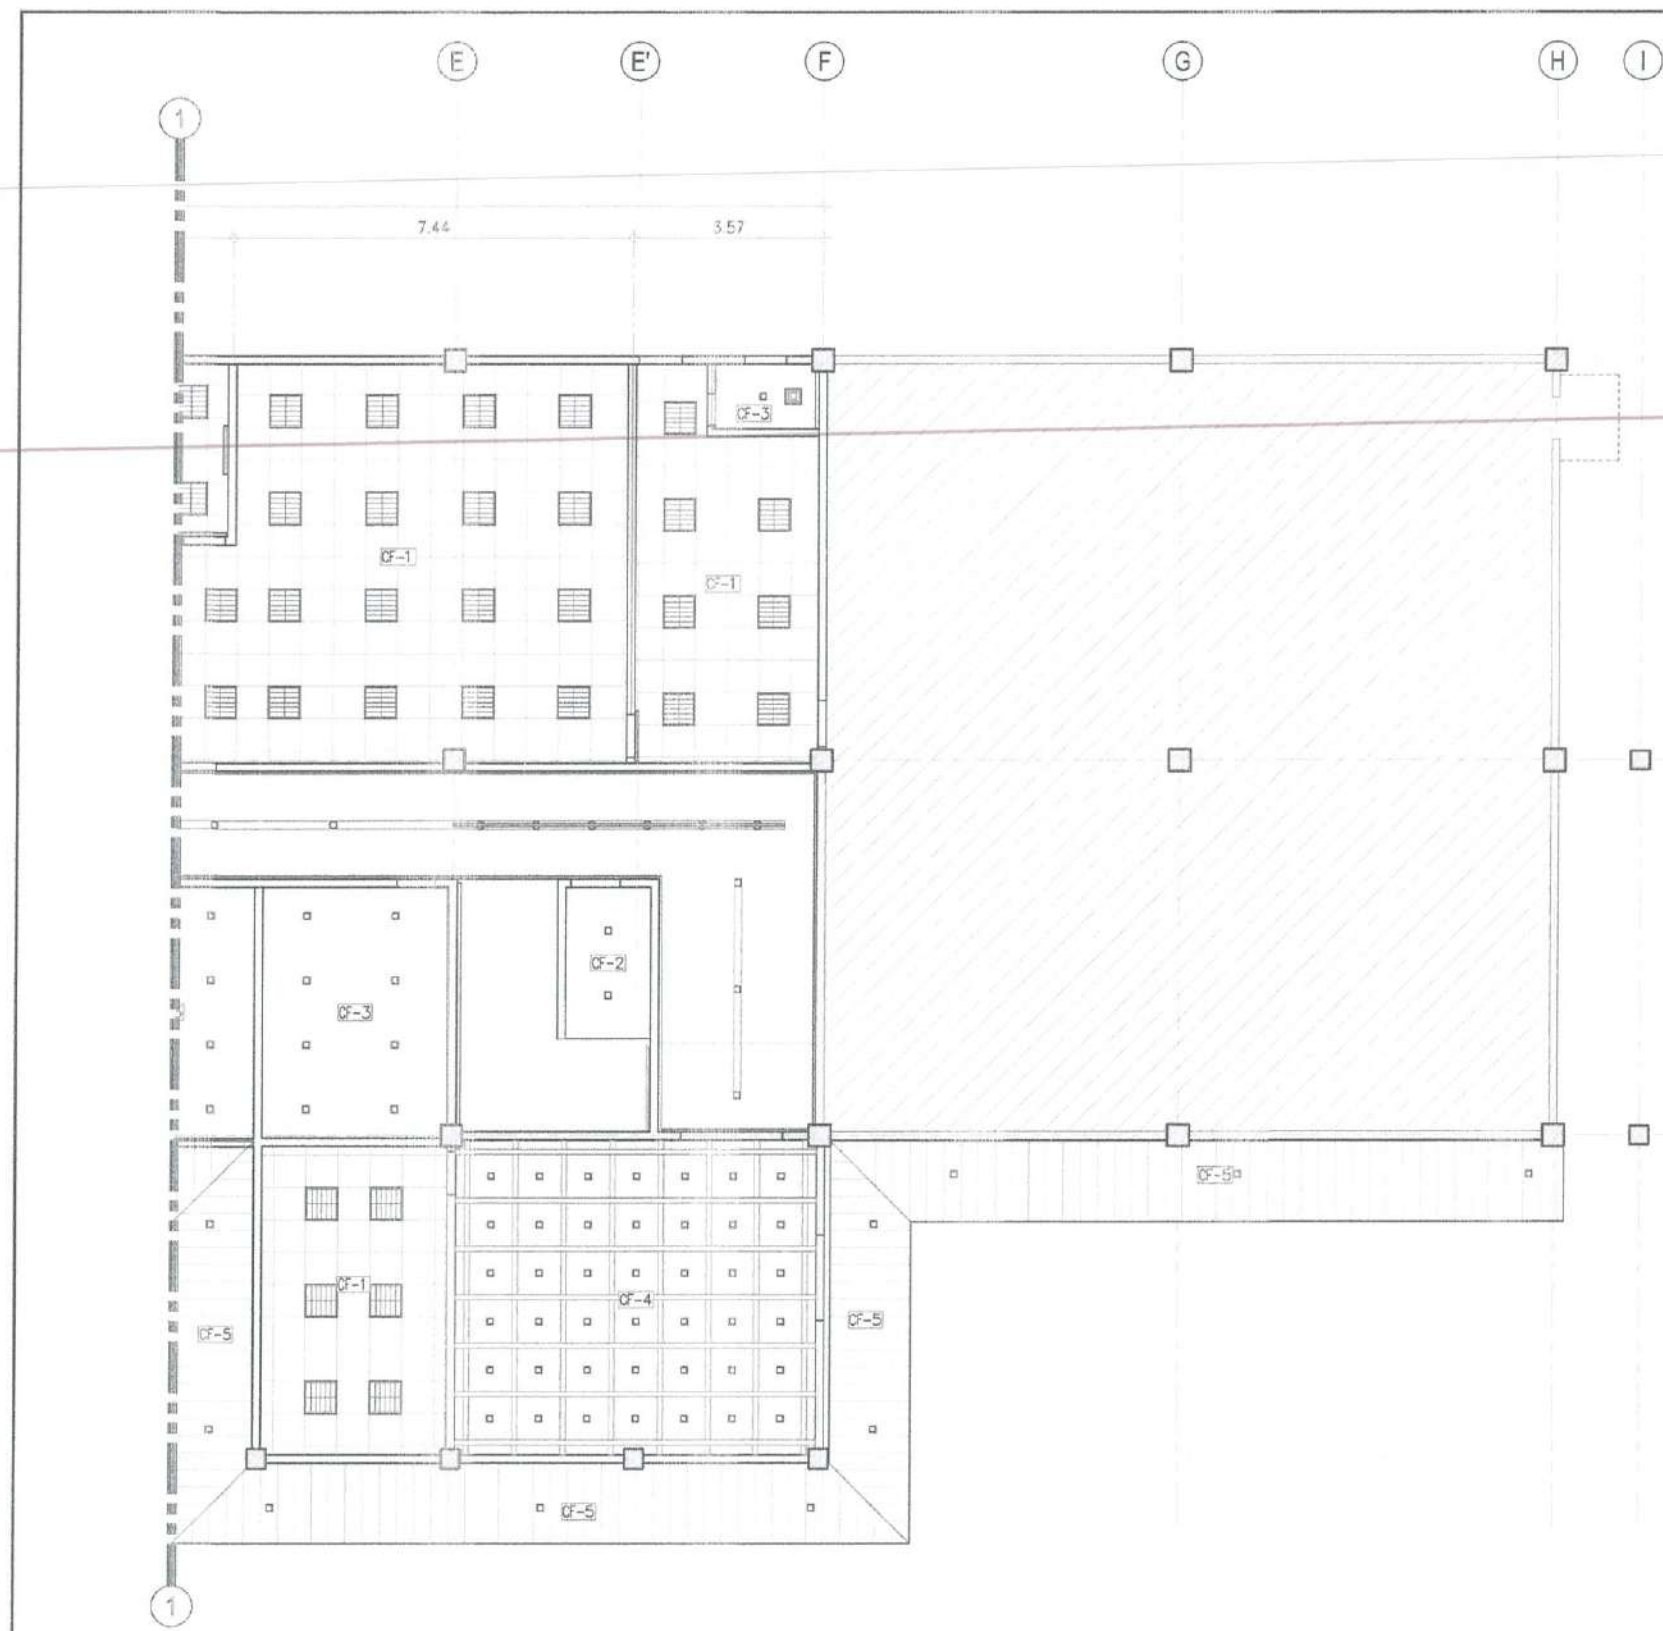

BAR SCALE

 

LEGEND	
	6" x 6" RECESSED SQUARE LED DOWNLIGHT
	MONORAIL TRACK LIGHTING
	RECESSED LOUVER TYPE LED LIGHTING FIXTURE
	ROLL-UP FABRIC CURTAIN
	CEILING MOUNTED EXHAUST FAN
	CEILING MOUNTED PROJECTOR
	CONCEALED PROJECTOR SCREEN
TAG CEILING FINISHES	
CF-1	9 MM THK, 600 MM X 600 MM PVC LAMINATED GYPSUM BOARD WITH FOIL BACKING ON SUSPENDED CEILING SYSTEM (ORANGE SKIN FINISH)
CF-2	12MM THK GYPSUM BOARD IN LATEX PAINT FINISH
CF-3	12MM THK MOISTURE RESISTANT GYPSUM BOARD IN LATEX PAINT FINISH
CF-4	1"x 4" KILN DRIED LUMBER @ 0.90M x 0.90M O.C. COFFERED CEILING ON 12MM THK. MARINE PLYWOOD IN ENAMEL PAINT FLAT FINISH (COLOR: VERIFY ARCHITECT)
CF-5	1500MM X 1125MM X 0.60MM METAL SPANDREL CEILING (COLOR: VERIFY ARCHITECT)

REPUBLIC OF THE PHILIPPINES CIVIL AVIATION AUTHORITY OF THE PHILIPPINES AERODROME DEVELOPMENT AND MANAGEMENT SERVICE NAIA ROAD, 1325 PASAY CITY	
THIS DRAWINGS AND DESIGN IS EXCLUSIVE PROPERTY OF CIVIL AVIATION AUTHORITY OF THE PHILIPPINES AND SUCH MUST NOT BE REPRODUCED, EXHIBITED, LOANED NOR COPIED IN PART OR IN WHOLE WITHOUT PROPER PERMISSION AND/OR WRITTEN CONSENT FROM THE DIRECTOR GENERAL CAA.	
AERODROME DEVELOPMENT AND MANAGEMENT SERVICE	
INFRASTRUCTURE DEVELOPMENT AND DESIGN DIVISION	
DESIGN STAFF:	INITIAL / DATE
DESIGNED BY:	EDD
DRAWN BY:	DRGSMPLR
CHECKED BY:	
REVIEWED BY: RAUL R. ORUCENA Division Chief, IDDS-AED	
SUBMITTED BY: ARNEL F. BORLADO Department Manager III, AED-ADMS	
RECOMMEND APPROVAL: LT COL. VALENTINO A. DIONELA (PAF-RET) Assistant Director General II, ADMS	
APPROVED BY: CAPTAIN MAYEL ANTONIO L. TAYAYO Director General	
NOTES/REVISIONS:	
PROJECT: IMPROVEMENT/REHABILITATION OF AIRWAYS FACILITY COMPLEX BUILDING	
LOCATION: CAAP CENTRAL OFFICE NAIA RD., COR. N. AQUINO AVENUE, PASAY CITY	
SHEET COMMENTS: • GROUND FLOOR REFLECTED CEILING BLOW-UP PLAN	
DRAWING SCALE:	SHEET NO:
	17



REPUBLIC OF THE PHILIPPINES
CIVIL AVIATION AUTHORITY OF THE PHILIPPINES
AERODROME DEVELOPMENT AND MANAGEMENT SERVICE
NAIA ROAD, 100 PASAY CITY

THIS DRAWINGS AND DESIGN IS EXCLUSIVE
PROPERTY OF CIVIL AVIATION AUTHORITY
OF THE PHILIPPINES AND SUCH MUST NOT BE
REPRODUCED, EXHIBITED, LOANED NOR
COPIED IN PART OR IN WHOLE WITHOUT
PROPER PERMISSION AND/OR WRITTEN
CONSENT FROM THE DIRECTOR GENERAL
CAA.

AERODROME DEVELOPMENT
AND MANAGEMENT SERVICE

INFRASTRUCTURE DEVELOPMENT AND DESIGN
DIVISION

DESIGN STAFF INITIAL / DATE
DESIGNED BY: IDDO
DRAWN BY: DRPG/MLR
CHECKED BY:

REVIEWED BY:

RAUL R. CRUCENA
Division Chief (IDDO/DAED)

SUBMITTED BY:
ARNEL F. BORLADO
Department Manager III (AED-ADMS)

RECOMMEND APPROVAL:

LT COL. VALENTINO A. DIONELA, PAF (RET.)
Assistant Director General II, ADMS

APPROVED BY:
CAPTAIN MANUEL L. TAMAYO
Director General

NOTES/REVISIONS:

PROJECT:
IMPROVEMENT/REHABILITATION
OF AIRWAYS FACILITY COMPLEX
BUILDING

 
LOCATION:
CAAP CENTRAL OFFICE
NAIA RD., COR. N. AQUINO AVENUE,
PASAY CITY

SHEET CONTENTS:
• GROUND FLOOR REFLECTED
CEILING PLAN

DRAWING SCALE: 1:100 M
SHEET NO. 06 17




1 SECOND FLOOR
REFLECTED CEILING PLAN
SCALE: 1:100 M




LEGEND

□	6" x 6" RECESSED SQUARE LED DOWNLIGHT
—	MONORAIL TRACK LIGHTING
■	RECESSED LOUVER TYPE LED LIGHTING FIXTURE
—	ROLL-UP FABRIC CURTAIN
■	CEILING MOUNTED EXHAUST FAN
P	CEILING MOUNTED PROJECTOR
—	CONCEALED PROJECTOR SCREEN
TAG	CEILING FINISHES
CF-1	9 MM THK. 600 MM X 600 MM PVC LAMINATED GYPSUM BOARD WITH FOIL BACKING ON SUSPENDED CEILING SYSTEM (ORANGE SKIN FINISH)
CF-2	12MM THK GYPSUM BOARD IN LATEX PAINT FINISH
CF-3	12MM THK MOISTURE RESISTANT GYPSUM BOARD IN LATEX PAINT FINISH
CF-4	1"x 4" KILN DRIED LUMBER @ 0.90M x 0.90M O.C. COFFERED CEILING ON 12MM THK MARINE PLYWOOD IN ENAMEL PAINT FLAT FINISH (COLOR: VERIFY ARCHITECT)
CF-5	1500MM X 110MM X 0.60MM METAL SPANDREL CEILING (COLOR: VERIFY ARCHITECT)

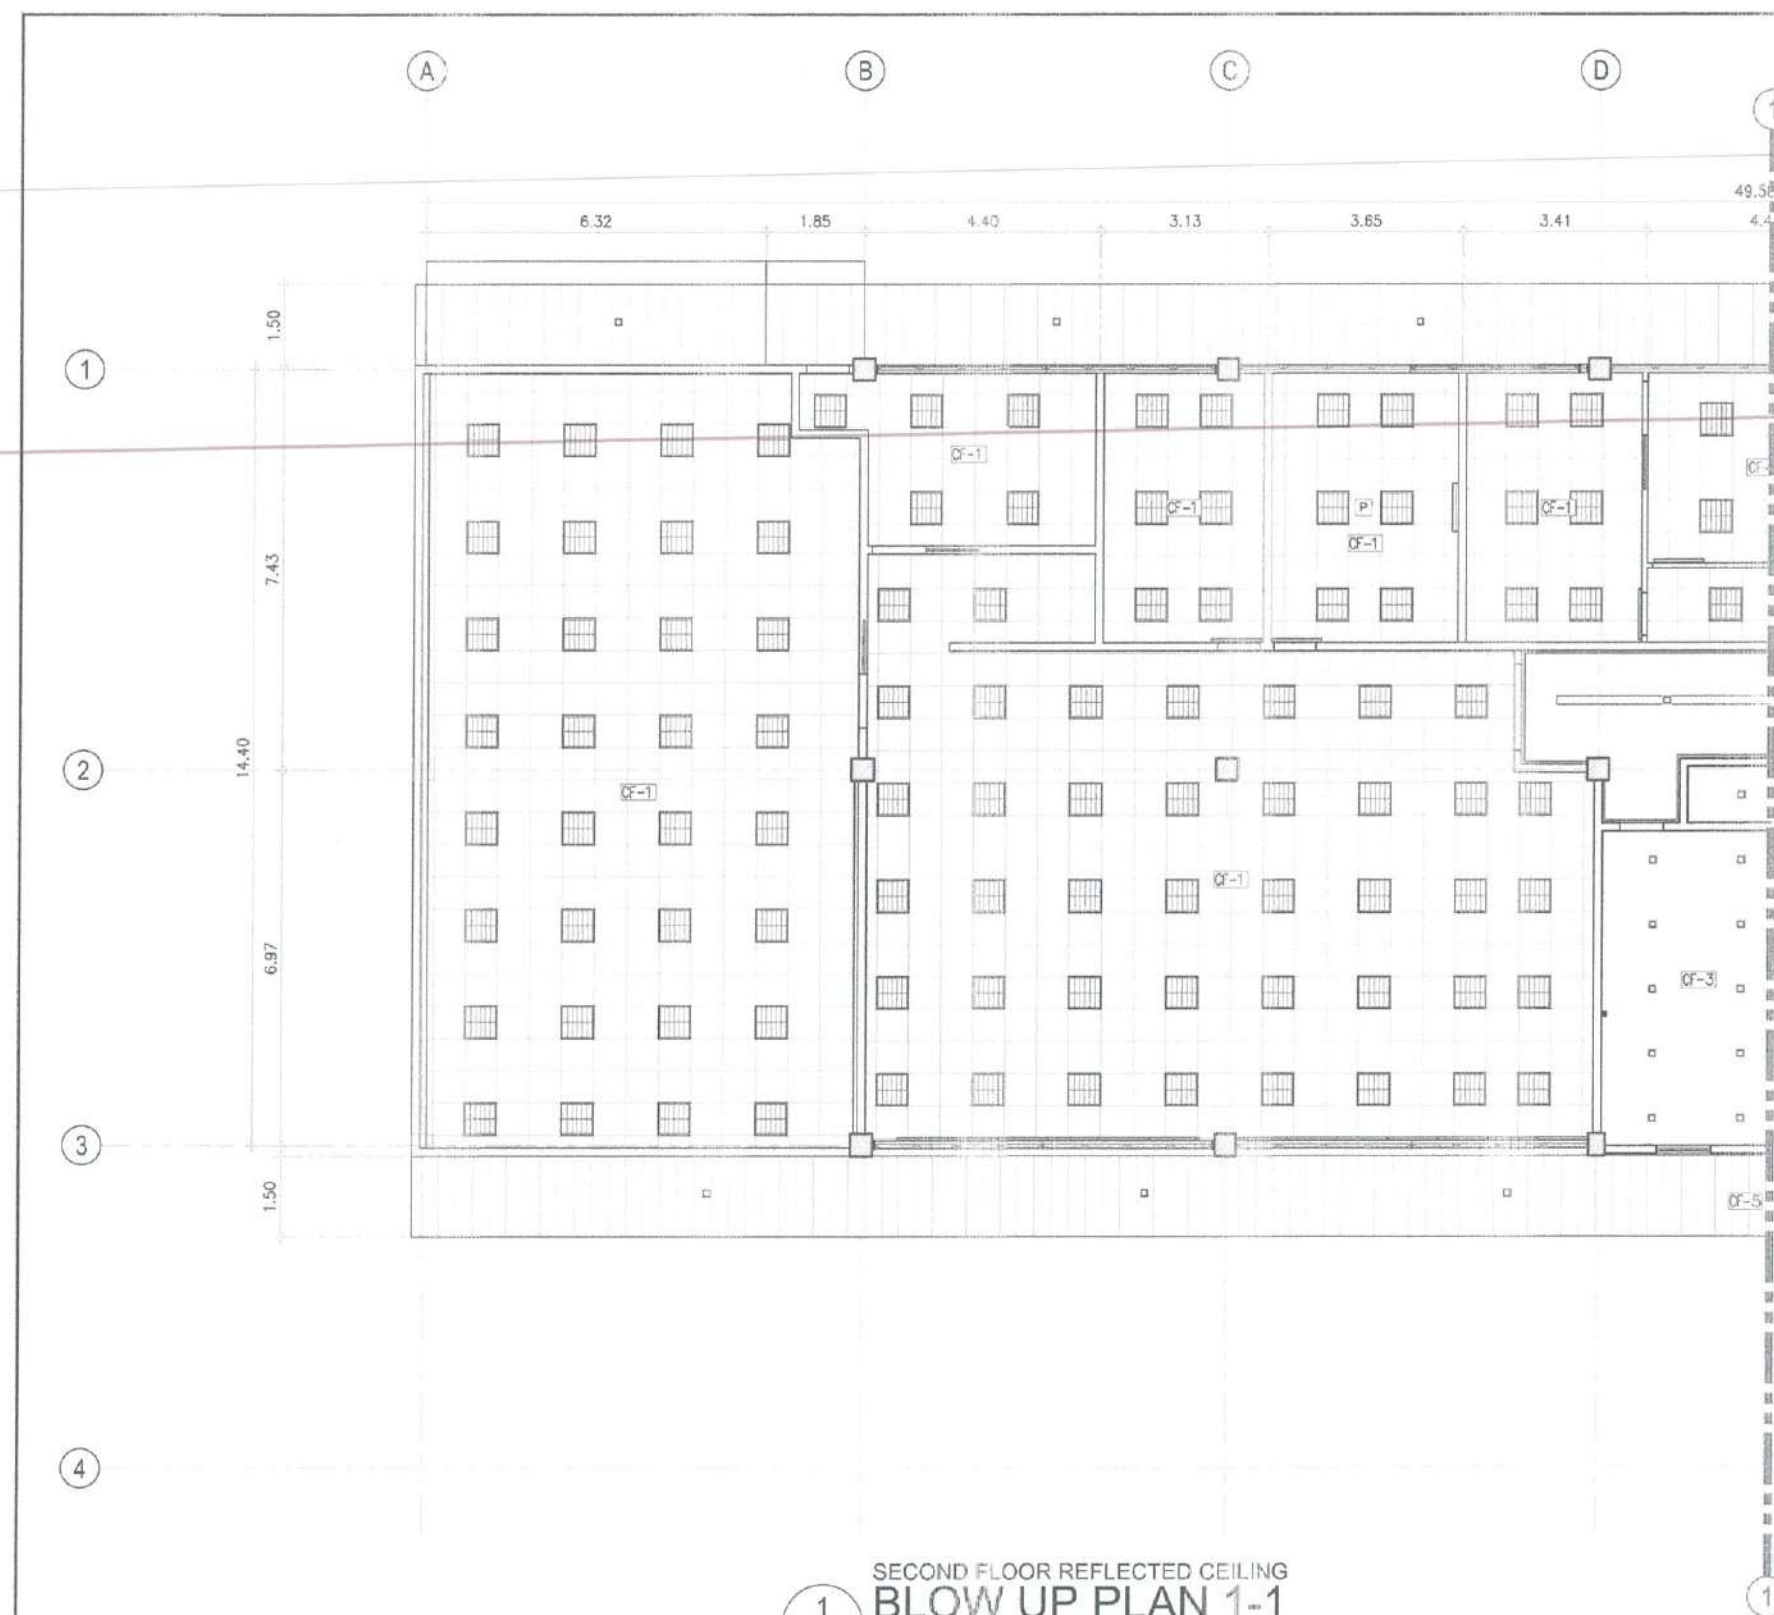


1
SECOND FLOOR REFLECTED CEILING
BLOW UP PLAN 1-1
SCALE: 1:75 M

 BAR SCALE




LEGEND	
	6" x 6" RECESSED SQUARE LED DOWNLIGHT
	MONORAIL TRACK LIGHTING
	RECESSED LOUVER TYPE LED LIGHTING FIXTURE
	ROLL-UP FABRIC CURTAIN
	CEILING MOUNTED EXHAUST FAN
	CEILING MOUNTED PROJECTOR
	CONCEALED PROJECTOR SCREEN
CEILING FINISHES	
CF-1	9 MM THK. 600 MM X 600 MM PVC LAMINATED GYPSUM BOARD WITH FOIL BACKING ON SUSPENDED CEILING SYSTEM (ORANGE SKIN FINISH)
CF-2	12MM THK GYPSUM BOARD IN LATEX PAINT FIN SH
CF-3	12MM THK MOISTURE RESISTANT GYPSUM BOARD IN LATEX PAINT FINISH
CF-4	1"x 4" KILN DRIED LUMBER @ 0.90M x 0.90M O.C. COFFERED CEILING ON 12MM THK. MARINE PLYWOOD IN ENAMEL PAINT FLAT FINISH (COLOR: VERIFY ARCHITECT)
CF-5	1500MM X 1125MM X 0.60MM METAL SPANDREL CEILING (COLOR: VERIFY ARCHITECT)

REPUBLIC OF THE PHILIPPINES CIVIL AVIATION AUTHORITY OF THE PHILIPPINES AERODROME DEVELOPMENT AND MANAGEMENT SERVICE NAIA ROAD, 1305 PASAY CITY	
THIS DRAWINGS AND DESIGN IS EXCLUSIVE PROPERTY OF CIVIL AVIATION AUTHORITY OF THE PHILIPPINES AND SUCH MUST NOT BE REPRODUCED, EXHIBITED, LOANED NOR COPIED IN PART OR IN WHOLE WITHOUT PROPER PERMISSION AND/OR WRITTEN CONSENT FROM THE DIRECTOR GENERAL CAA.	
AERODROME DEVELOPMENT AND MANAGEMENT SERVICE	
INFRASTRUCTURE DEVELOPMENT AND DESIGN DIVISION	
DESIGN STAFF:	INITIAL / DATE
DESIGNED BY: IDDD	
DRAWN BY: DRPG/MLR	
CHECKED BY:	
REVIEWED BY:	
 RAUL C. CRUZENA Division Chief, IDDD-AED	
SUBMITTED BY:	
 ARNEL F. BORLADO Department Manager III, AED-ADMS	
RECOMMEND APPROVAL:	
 LT COL. VALENTINO A. DIONELA PAF (RET) Assistant Director General II, ADMS	
APPROVED BY:	
 CAPTAIN MANOLO L. TAWAYO Director General	
NOTES/REVISIONS:	
PROJECT:	
IMPROVEMENT/REHABILITATION OF AIRWAYS FACILITY COMPLEX BUILDING	
LOCATION:	
CAAP CENTRAL OFFICE NAIA RD. COR. N. AQUINO AVENUE, PASAY CITY	
SHEET CONTENTS:	
• SECOND FLOOR REFLECTED CEILING BLOW-UP PLAN	
DRAWING SCALE:	SHEET NO:
1:75 M	A 17

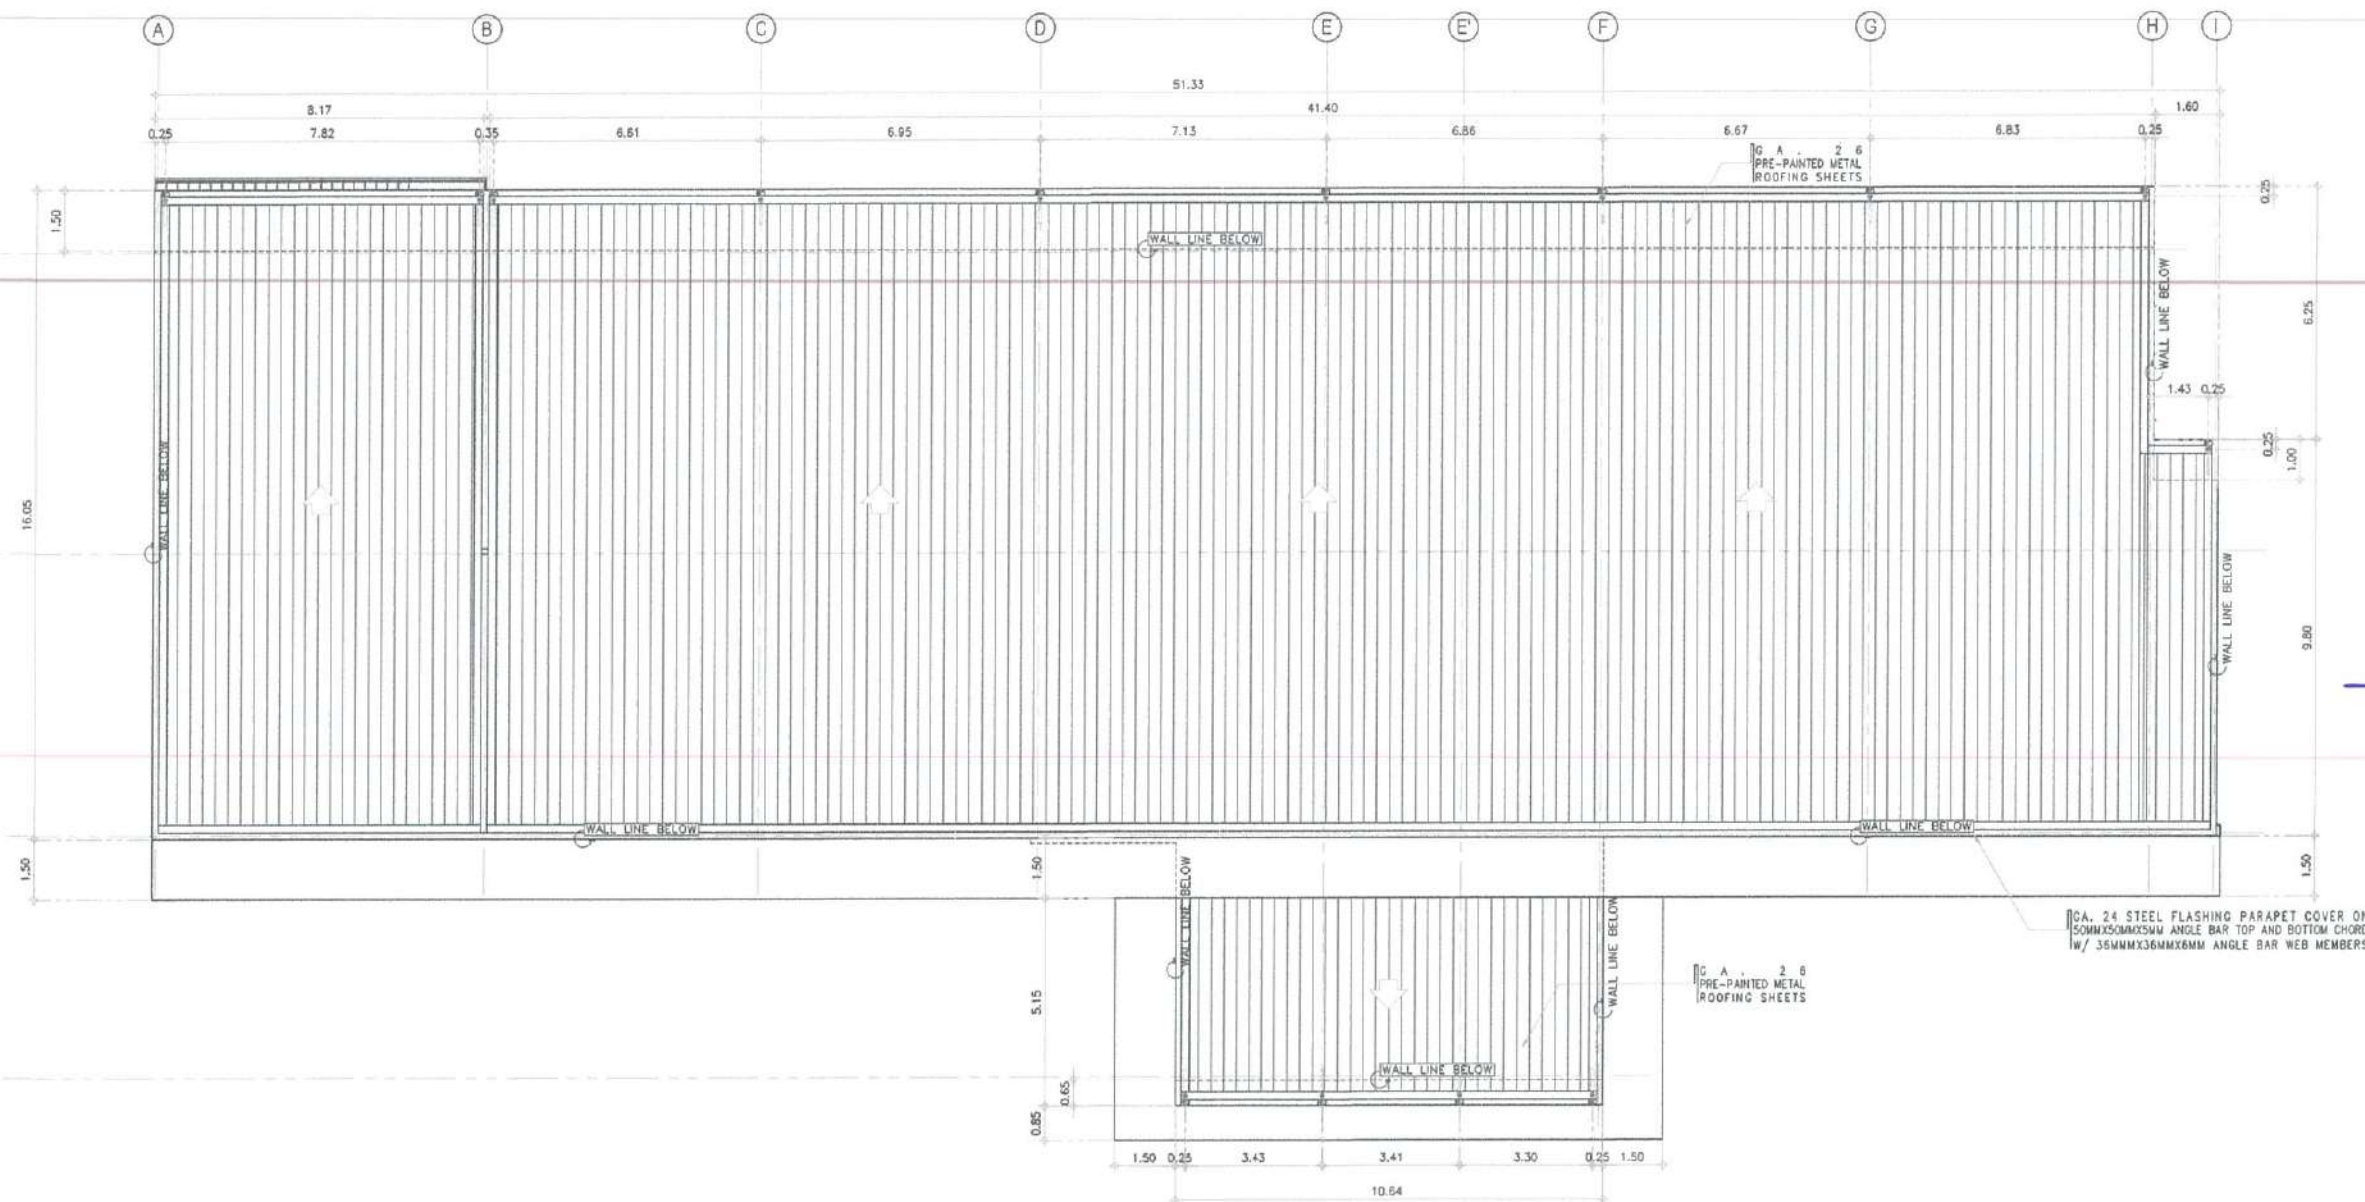

1 ROOF PLAN
A-07 A-07 SCALE: 1:100 M

 

REPUBLIC OF THE PHILIPPINES

CIVIL AVIATION AUTHORITY OF THE PHILIPPINES
AERODROME DEVELOPMENT AND MANAGEMENT SERVICE
NAIA ROAD, PASAY CITY

THIS DRAWINGS AND DESIGN IS EXCLUSIVE
PROPERTY OF CIVIL AVIATION AUTHORITY
OF THE PHILIPPINES AND SUCH MUST NOT BE
REPRODUCED, EXHIBITED, LOANED NOR
COPIED IN PART OR IN WHOLE WITHOUT
PROPER PERMISSION AND/OR WRITTEN
CONSENT FROM THE DIRECTOR GENERAL
CAAP.

AERODROME DEVELOPMENT
AND MANAGEMENT SERVICE

INFRASTRUCTURE DEVELOPMENT AND DESIGN
DIVISION

DESIGN STAFF: INITIAL / DATE
DESIGNED BY: IDDO
DRAWN BY: DRPGAMPUR
CHECKED BY:

REVIEWED BY:

RAUL R. CRUCENA
Division Chief, IDDO-AED

SUBMITTED BY:
ARNEL F. BORLADO
Department Manager III, AED-ADMS

RECOMMEND APPROVAL:
LT COL VALENTINO A. DIONELA PAF (RET)
Assistant Director General II, ADMS

APPROVED BY:
CAPTAIN MANUEL ANTONIO L. ZAMAYO
Director General

NOTES/REVISIONS:

PROJECT:
IMPROVEMENT/REHABILITATION
OF AIRWAYS FACILITY COMPLEX
BUILDING

LOCATION:
CAAP CENTRAL OFFICE
NAIA RD. COR. N. AQUINO AVENUE,
PASAY CITY

SHEET CONTENTS:
• ROOF PLAN

DRAWING SCALE: 1:100 M
SHEET NO.: A
07 17



REPUBLIC OF THE PHILIPPINES

CIVIL AVIATION AUTHORITY OF THE PHILIPPINES
AERODROME DEVELOPMENT AND MANAGEMENT SERVICE
NAIA RD. 138 PASAY CITY

THIS DRAWING AND DESIGN IS EXCLUSIVE
PROPERTY OF CIVIL AVIATION AUTHORITY
OF THE PHILIPPINES AND SUCH MUST NOT BE
REPRODUCED, EXHIBITED, LOANED NOR
COPIED IN PART OR IN WHOLE WITHOUT
PROPER PERMISSION AND/OR WRITTEN
CONSENT FROM THE DIRECTOR GENERAL
CAAP.

AERODROME DEVELOPMENT
AND MANAGEMENT SERVICE

INFRASTRUCTURE DEVELOPMENT AND DESIGN
DIVISION

DESIGN STAFF:	INITIAL / DATE
DESIGNED BY:	ICDD
DRAWN BY:	DRP/ANPLR
CHECKED BY:	

REVIEWED BY:

RAUL R. CRUCENA
Division Chief III, IDDD-AED

SUBMITTED BY:

ARNEL F. BORLADO
Department Manager II, AED-ADMS

RECOMMEND APPROVAL:

LT COL VALENTINO A. DIONELA PAF (RET)
Assistant Director General II, ADMS

APPROVED BY:

CAPTAIN MANUEL ANTONIO L. TAMAYO
Director General

NOTES/REVISIONS:

PROJECT:

IMPROVEMENT/REHABILITATION
OF AIRWAYS FACILITY COMPLEX
BUILDING

LOCATION:

CAAP CENTRAL OFFICE
NAIA RD. COR. N. AQUINO AVENUE,
PASAY CITY

SHEET CONTENTS:


* ELEVATIONS

DRAWING SCALE:


SHEET NO.:

1 : 100 M

A
08 17

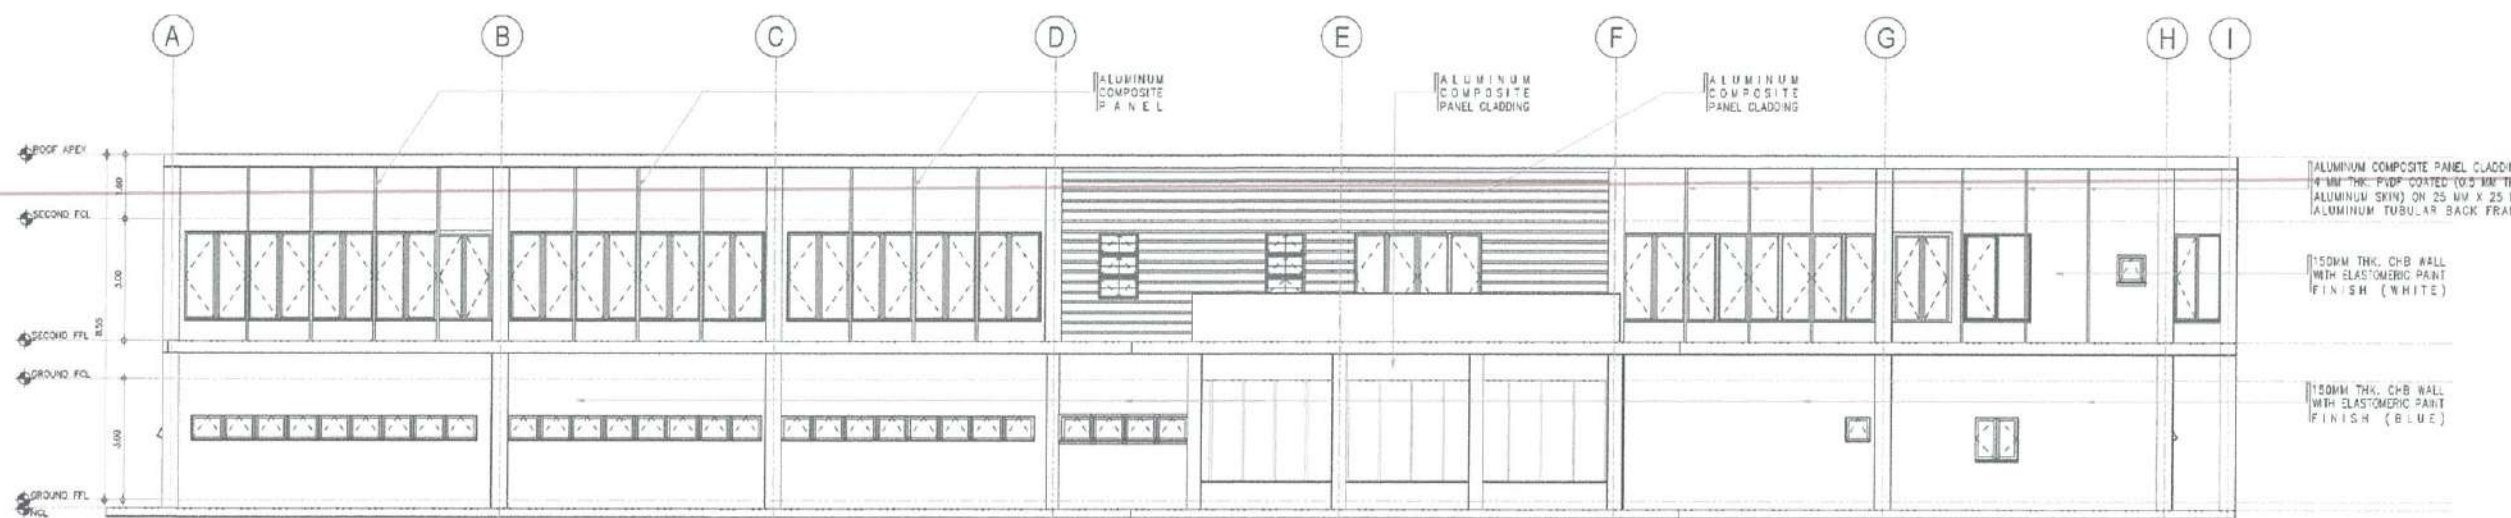

1 FRONT ELEVATION
A-084-08 SCALE: 1 : 100 M

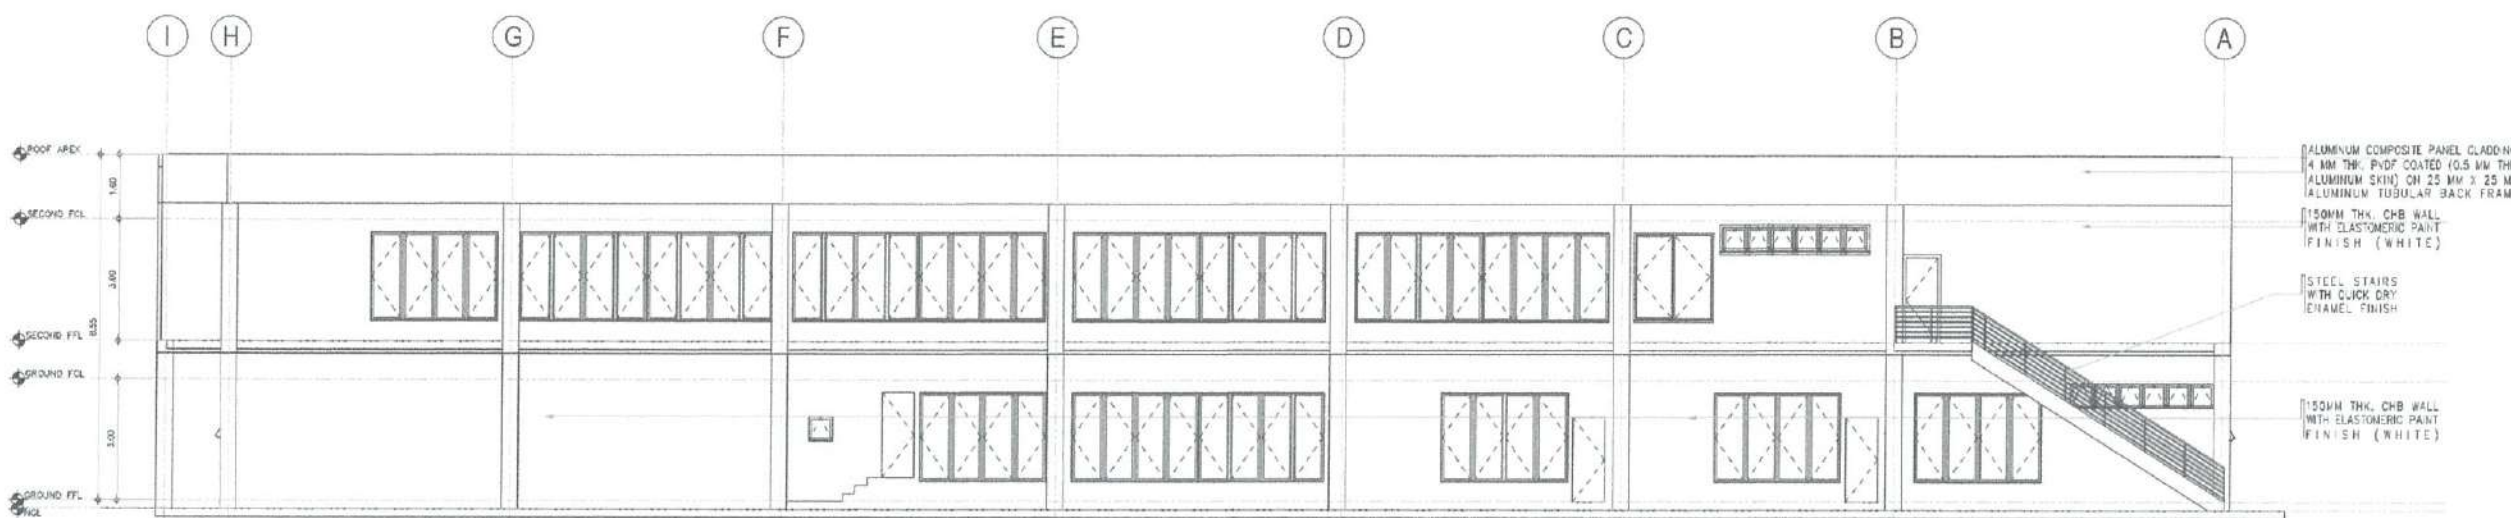

2 REAR ELEVATION
A-084-08 SCALE: 1 : 100 M



REPUBLIC OF THE PHILIPPINES
CIVIL AVIATION AUTHORITY OF THE PHILIPPINES
AERODROME DEVELOPMENT AND MANAGEMENT SERVICE
NAIA RD., 130 PASAY CITY

THE DRAWINGS AND DESIGN IS EXCLUSIVE
PROPERTY OF CIVIL AVIATION AUTHORITY
OF THE PHILIPPINES AND SUCH MUST NOT BE
REPRODUCED, EXHIBITED, LOANED NOR
COPIED IN PART OR IN WHOLE WITHOUT
PROPER PERMISSION AND/OR WRITTEN
CONSENT FROM THE DIRECTOR GENERAL
CAAP

AERODROME DEVELOPMENT
AND MANAGEMENT SERVICE

INFRASTRUCTURE DEVELOPMENT AND DESIGN
DIVISION

DESIGN STAFF: INITIAL / DATE
DESIGNED BY: IDDD
DRAWN BY: DRPGMPLR
CHECKED BY:

REVIEWED BY:

RAUL R. CRUZENA
Division Chief III, IDDD-AED

SUBMITTED BY:

ARNEL F. BORLADO
Department Manager III, AED-ADMS

RECOMMEND APPROVAL:

LT COL. VALENTINO A. DIONELA PAF (RET)
Assistant Director General II, ADMS

APPROVED BY:

CAPTAIN MANUEL ANTONIO L. TAMAYO
Director General I, CAAP

NOTES/REVISIONS:

PROJECT:

IMPROVEMENT/REHABILITATION
OF AIRWAYS FACILITY COMPLEX
BUILDING

LOCATION:


CAAP CENTRAL OFFICE
NAIA RD. COR. N. AQUINO AVENUE,
PASAY CITY

SHEET CONTENTS:


• ELEVATIONS

DRAWING SCALE: SHEET NO.

1 : 100 M A
09 17

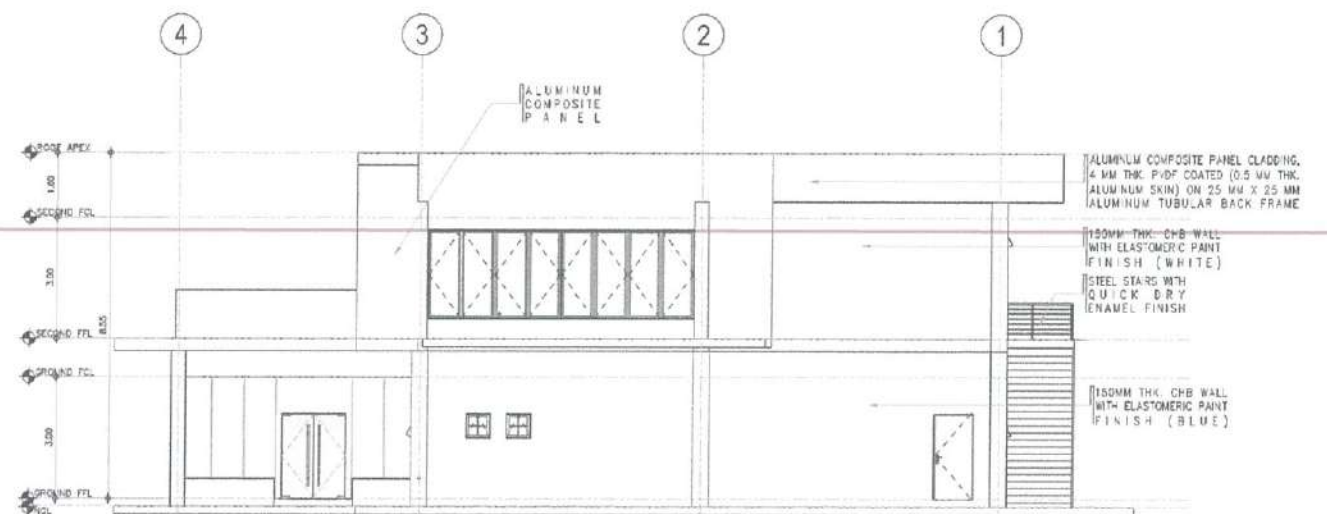

1 RIGHT-SIDE ELEVATION
A-09A-09 SCALE: 1 : 100 M

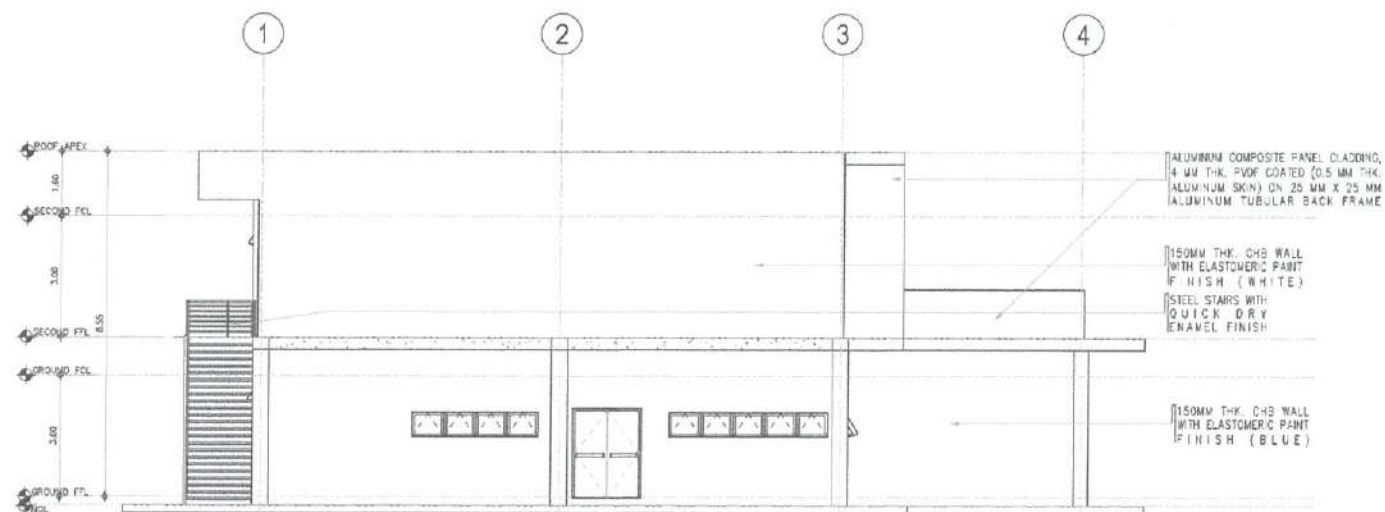

2 LEFT-SIDE ELEVATION
A-09A-09 SCALE: 1 : 100 M



REPUBLIC OF THE PHILIPPINES
CIVIL AVIATION AUTHORITY OF THE PHILIPPINES
AERODROME DEVELOPMENT AND MANAGEMENT SERVICE
NAIA ROAD, 1300 PASAY CITY

THIS DRAWINGS AND DESIGN IS EXCLUSIVE
PROPERTIES OF CIVIL AVIATION AUTHORITY
OF THE PHILIPPINES AND SUCH MUST NOT BE
REPRODUCED, EXHIBITED, LOANED NOR
COPIED IN PART OR IN WHOLE WITHOUT
PROPER PERMISSION AND/OR WRITTEN
CONSENT FROM THE DIRECTOR GENERAL
CAAP.

AERODROME DEVELOPMENT
AND MANAGEMENT SERVICE

INFRASTRUCTURE DEVELOPMENT AND DESIGN
DIVISION

DESIGN STAFF: INITIAL / DATE
DESIGNED BY: IODD
DRAWN BY: DRP/GMPLR
CHECKED BY:

REVIEWED BY:

RAUL R. CRUCENA
Division Chief III, IODD-AED

SUBMITTED BY:
ARNEL F. BORLADO
Department Manager III, AED-ADMS

RECOMMEND APPROVAL:
LT COL VALENTINO A. DIONELA PAF (RET)
Assistant Director General II, ADMS

APPROVED BY:
CAPTAIN MANUEL ANTONIO L. TAMAYO
Director General


NOTES/REVISIONS:

PROJECT:
IMPROVEMENT/REHABILITATION
OF AIRWAYS FACILITY COMPLEX
BUILDING


LOCATION:
CAAP CENTRAL OFFICE
NAIA RD. COR. N. AQUINO AVENUE,
PASAY CITY

SHEET CONTENTS:
• SECTIONS
• BLOW-UP SECTIONS


DRAWING SCALE: AS SHOWN
SHEET NO: A
11 17

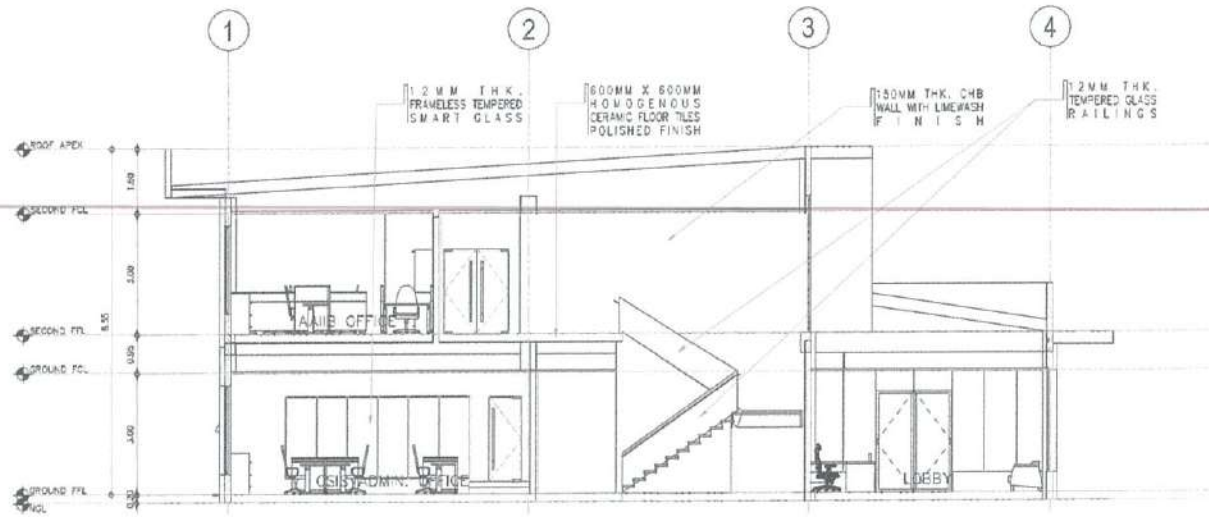


1 CROSS SECTION THRU '3'
A-11/A-11 SCALE: 1 : 100 M

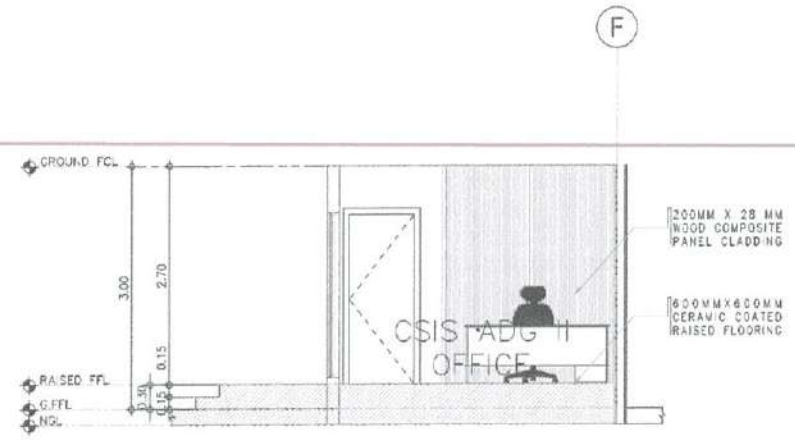

3 RAISED FLOORING @ ADG II OFFICE
A-11/A-11 BLOW UP SECTION SCALE: 1 : 50 M

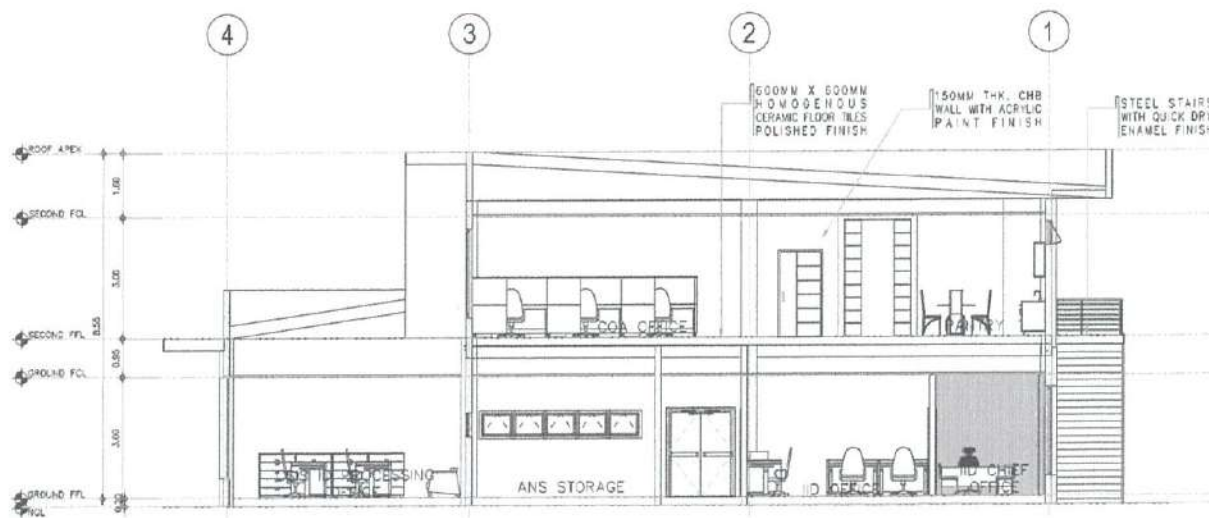

2 CROSS SECTION THRU '4'
A-11/A-11 SCALE: 1 : 100 M

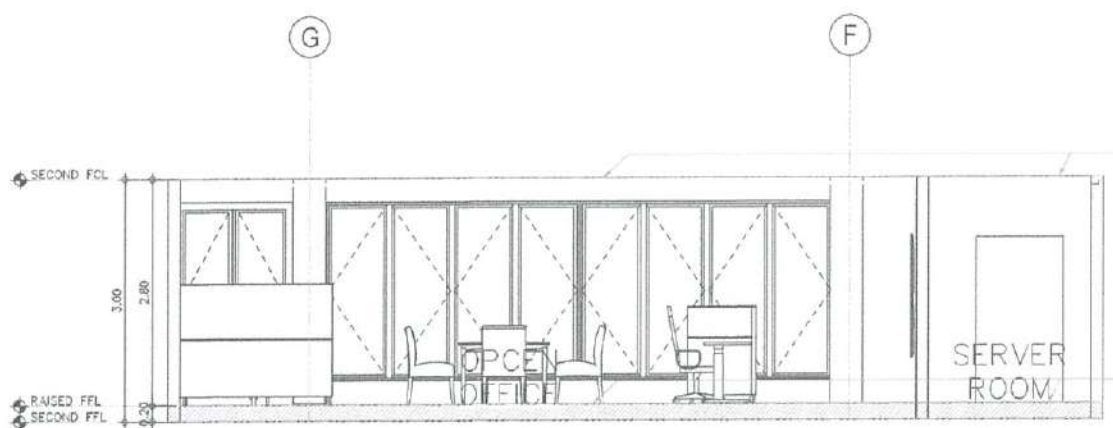

4 RAISED FLOORING @ OPCEM OFFICE
A-11/A-11 BLOW UP SECTION SCALE: 1 : 50 M



REPUBLIC OF THE PHILIPPINES
CIVIL AVIATION AUTHORITY OF THE PHILIPPINES
AERODROME DEVELOPMENT AND MANAGEMENT SERVICE
NAIA ROAD, 1300 PASAY CITY

THIS DRAWINGS AND DESIGN IS EXCLUSIVE
PROPERTY OF CIVIL AVIATION AUTHORITY
OF THE PHILIPPINES AND SUCH MUST NOT BE
REPRODUCED, EXHIBITED, LOANED NOR
COPIED IN PART OR IN WHOLE WITHOUT
PROPER PERMISSION AND/OR WRITTEN
CONSENT FROM THE DIRECTOR GENERAL
CAAP.

AERODROME DEVELOPMENT
AND MANAGEMENT SERVICE

INFRASTRUCTURE DEVELOPMENT AND DESIGN
DIVISION

DESIGN STAFF: INITIAL / DATE
DESIGNED BY: IDDD
DRAWN BY: DRPQ/MLR
CHECKED BY:
REVIEWED BY:

REVIEWED BY:
RAUL R. CRUCENA
Division Chief III, IDDD-AED

SUBMITTED BY:
ARNEL F. BORLADO
Department Manager III, AED-ADM

RECOMMEND APPROVAL:
LT COL VALENTINO A. DIONELA PAF (RET)
Assistant Director General II, ADM

APPROVED BY:
CAPTAIN MANUEL ANTONIO L. TAMAYO
Director General


NOTES/REVISIONS:

PROJECT:
IMPROVEMENT/REHABILITATION
OF AIRWAYS FACILITY COMPLEX
BUILDING

LOCATION:
CAAP CENTRAL OFFICE
NAIA RD. COR. N. AQUINO AVENUE,
PASAY CITY


SHEET CONTENTS:
• STAIR DETAILS

DRAWING SCALE: AS SHOWN
SHEET NO: A
17

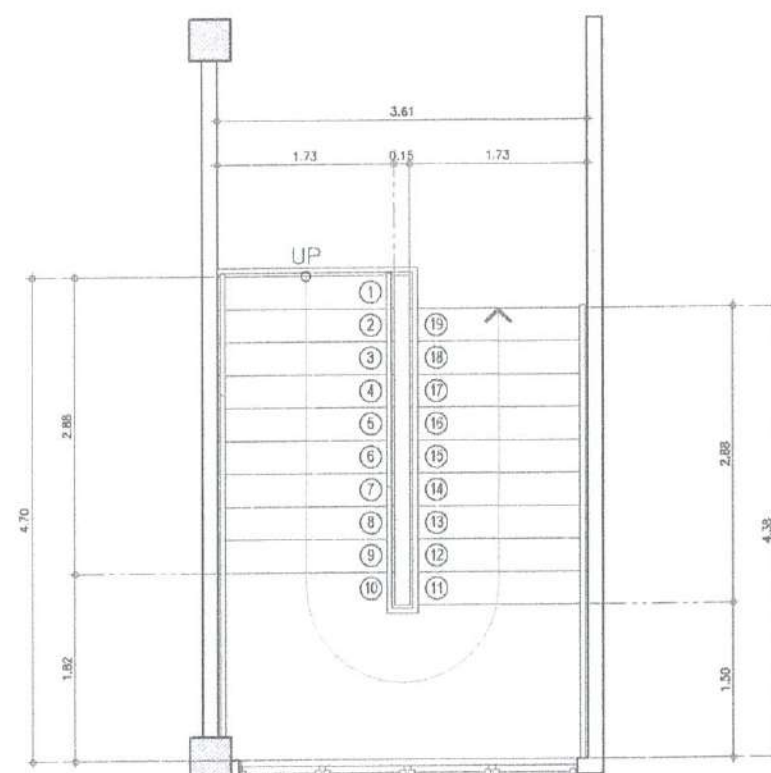

PLAN

1 STAIR DETAILS
SCALE: 1 : 40 M

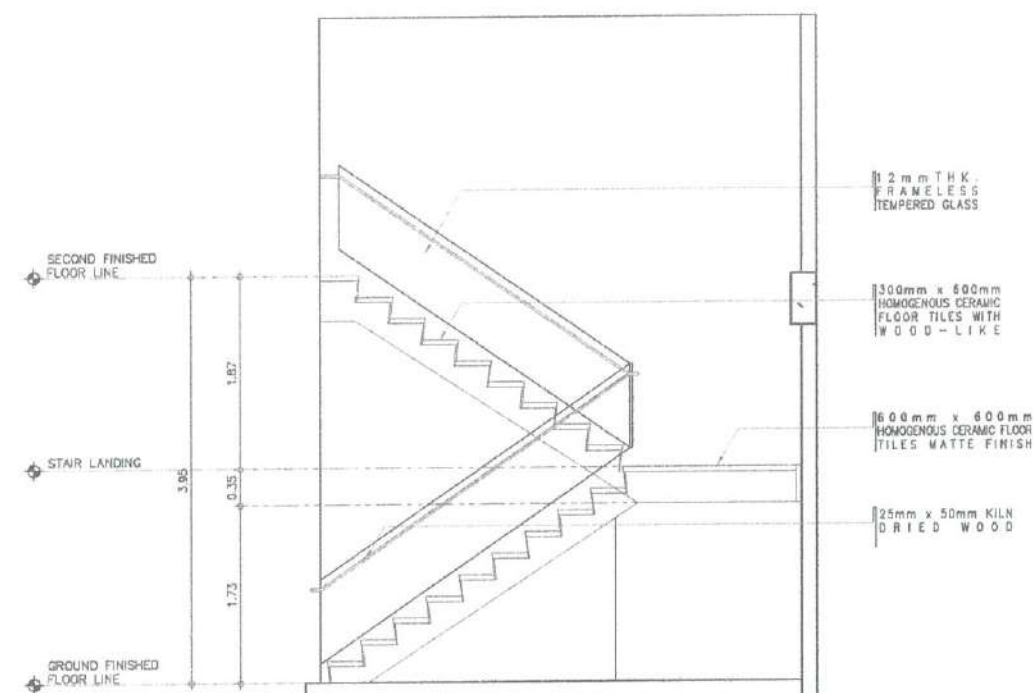

SECTION



REPUBLIC OF THE PHILIPPINES
CIVIL AVIATION AUTHORITY OF THE PHILIPPINES
AERODROME DEVELOPMENT AND MANAGEMENT SERVICE
NAIA ROAD, 1305 PASAY CITY

THIS DRAWINGS AND DESIGN IS EXCLUSIVE
PROPERTY OF CIVIL AVIATION AUTHORITY
OF THE PHILIPPINES AND SUCH MUST NOT BE
REPRODUCED, EXHIBITED, LOANED NOR
COPIED IN PART OR IN WHOLE WITHOUT
PROPER PERMISSION AND/OR WRITTEN
CONSENT FROM THE DIRECTOR GENERAL
CAAP.

AERODROME DEVELOPMENT
AND MANAGEMENT SERVICE

INFRASTRUCTURE DEVELOPMENT AND DESIGN
DIVISION

DESIGN STAFF: INITIAL / DATE
DESIGNED BY: ODD
DRAWN BY: DRPG/MLR
CHECKED BY: *[Signature]*

REVIEWED BY:

[Signature]
RAUL P. CRUCENA
Division Chief III, ID DO-AED

SUBMITTED BY:

[Signature]
ARNE F. BORLADO
Department Manager III, AED-ADMS

RECOMMEND APPROVAL:

[Signature]
LT COL VALENTINO A. DIONELA, PAF (RET)
Assistant Director General II, ADMS

APPROVED BY:

[Signature]
CAPTAIN MANUEL ANTONIO L. TAMAYO
Director General

NOTES/REVISIONS:

PROJECT:

IMPROVEMENT/REHABILITATION
OF AIRWAYS FACILITY COMPLEX
BUILDING


LOCATION:

CAAP CENTRAL OFFICE
NAIA RD. COR. N. AQUINO AVENUE,
PASAY CITY


SHEET CONTENTS:

• SIGNAGE LAYOUT PLAN

DRAWING SCALE: 1:100 M
SHEET NO: A
12 17

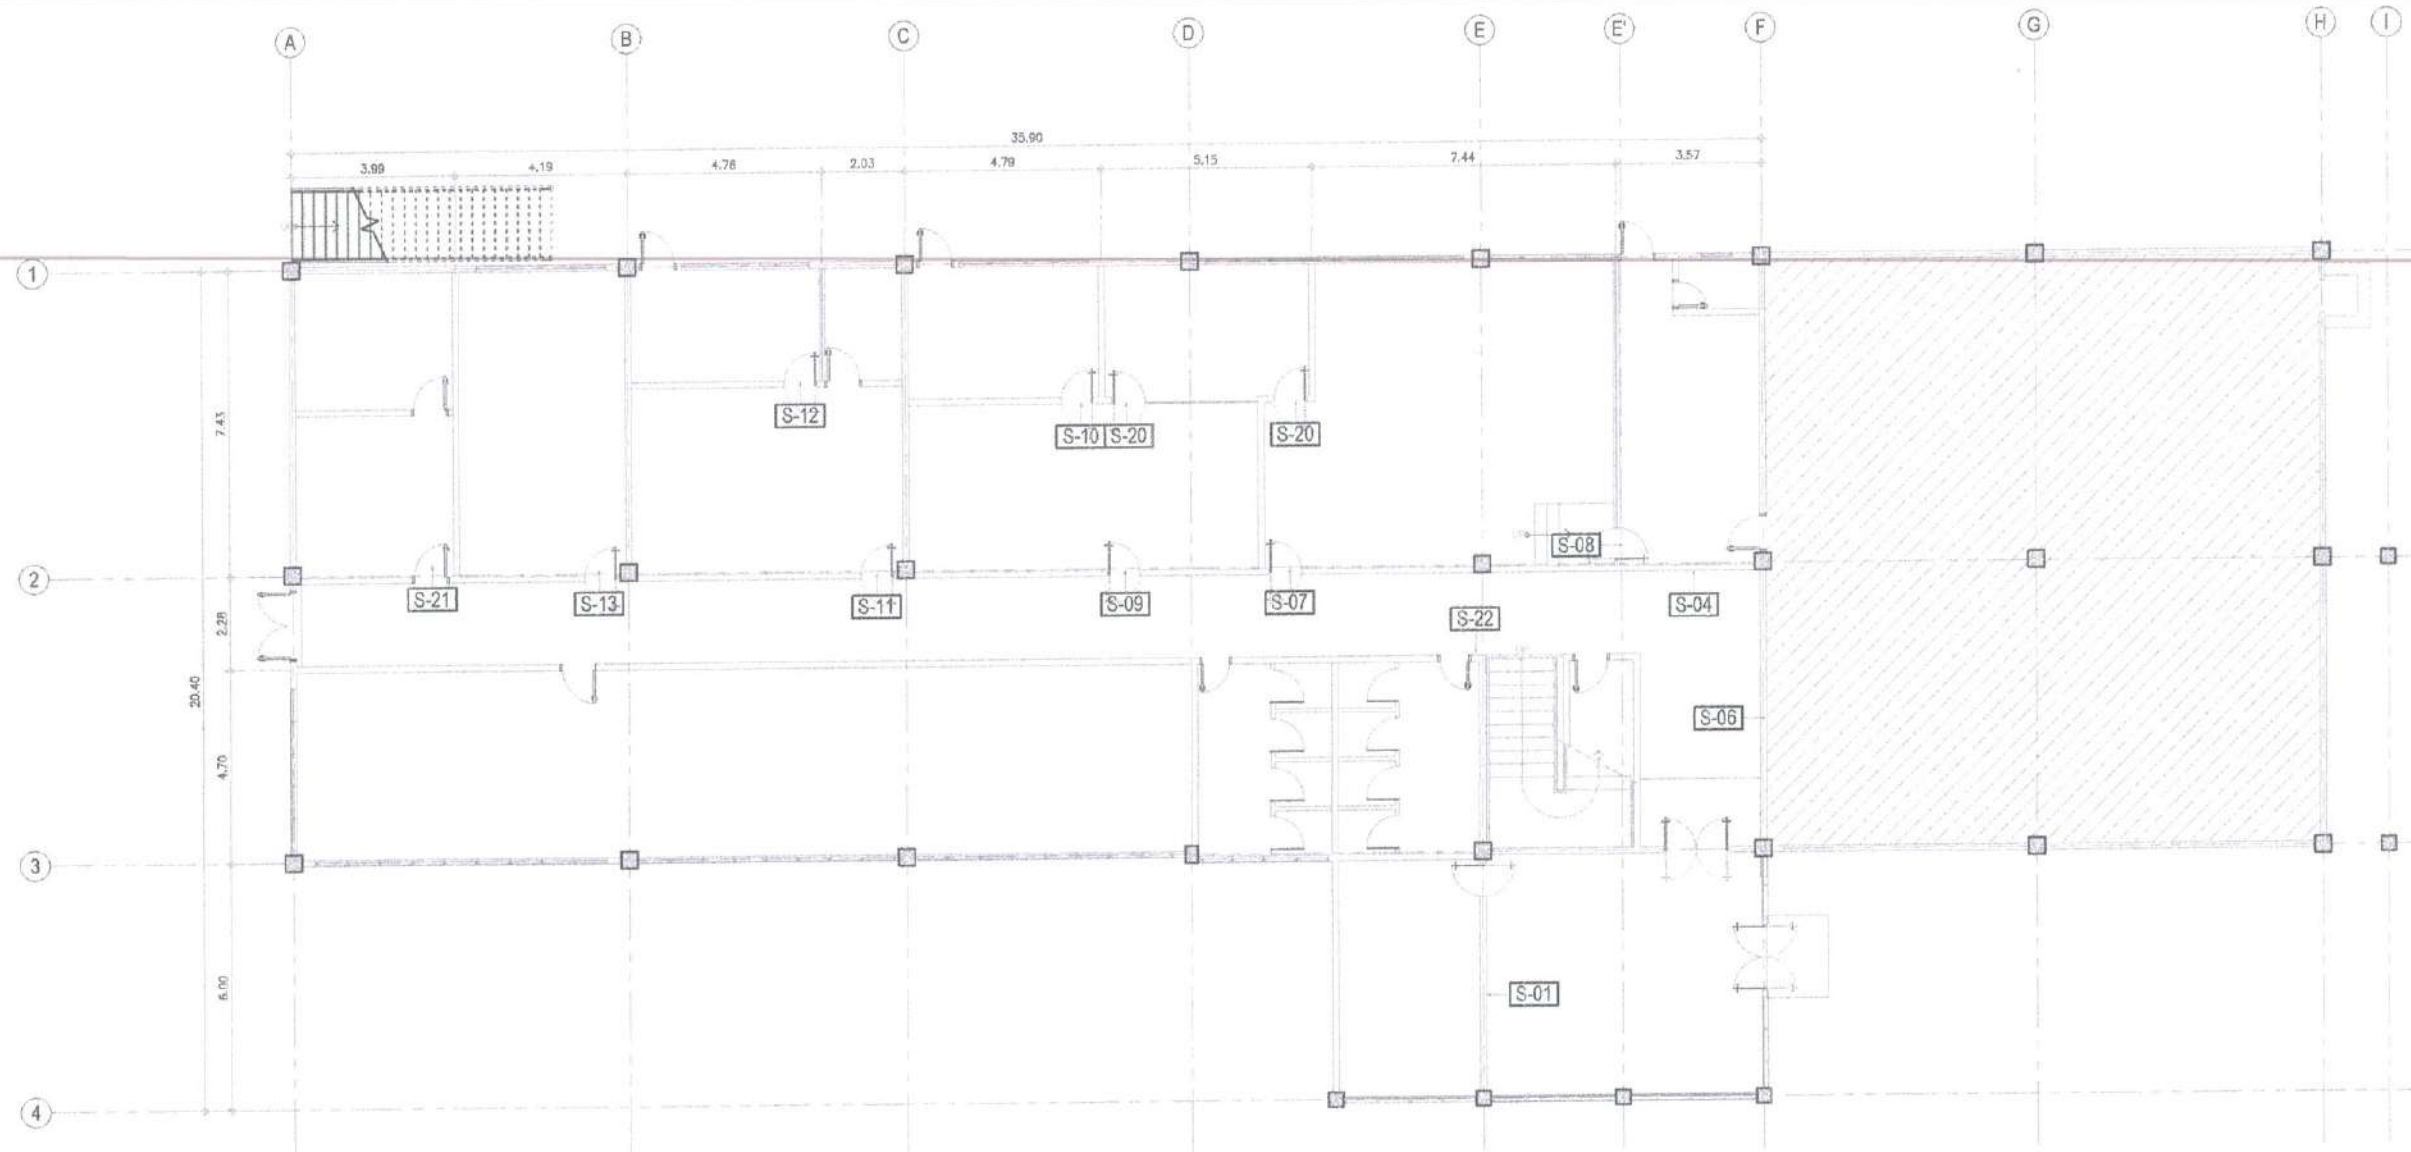

 GROUND FLOOR
SIGNAGE LAYOUT PLAN
SCALE: 1:100 M





REPUBLIC OF THE PHILIPPINES
CIVIL AVIATION AUTHORITY OF THE PHILIPPINES
AERODROME DEVELOPMENT AND MANAGEMENT SERVICE
NAIA RD. 1388 PASAY CITY

THIS DRAWING AND DESIGN IS EXCLUSIVE
PROPERTY OF CIVIL AVIATION AUTHORITY
OF THE PHILIPPINES AND SUCH MUST NOT BE
REPRODUCED, EXHIBITED, LOANED NOR
COPIED IN PART OR IN WHOLE WITHOUT
PROPER PERMISSION AND/OR WRITTEN
CONSENT FROM THE DIRECTOR GENERAL
CAAP.

AERODROME DEVELOPMENT
AND MANAGEMENT SERVICE

INFRASTRUCTURE DEVELOPMENT AND DESIGN
DIVISION

DESIGN STAFF: INITIAL / DATE
DESIGNED BY: IDDD
DRAWN BY: DRPG/MLR
CHECKED BY: *[Signature]*

REVIEWED BY:
[Signature]
RAUL A. CRUCENA
Division Chief, IDDD-AED

SUBMITTED BY:
[Signature]
ARNEL F. BORLADO
Department Manager II, AED-ADMS

RECOMMEND APPROVAL:
[Signature]
LT COL. VALENTINO A. DIONELA PAF (RET)
Assistant Director General II, ADMS

APPROVED BY:
[Signature]
CAPTAIN MAURICIO ANTONIO L. TAMAYO
Director General


NOTES/REVISIONS:

PROJECT:
IMPROVEMENT/REHABILITATION
OF AIRWAYS FACILITY COMPLEX
BUILDING


LOCATION:
CAAP CENTRAL OFFICE
NAIA RD. COR. N. AQUINO AVENUE,
PASAY CITY


SHEET CONTENTS:
* SIGNAGE LAYOUT PLAN

DRAWING SCALE: 1:100 M
SHEET NO.: A
13 17

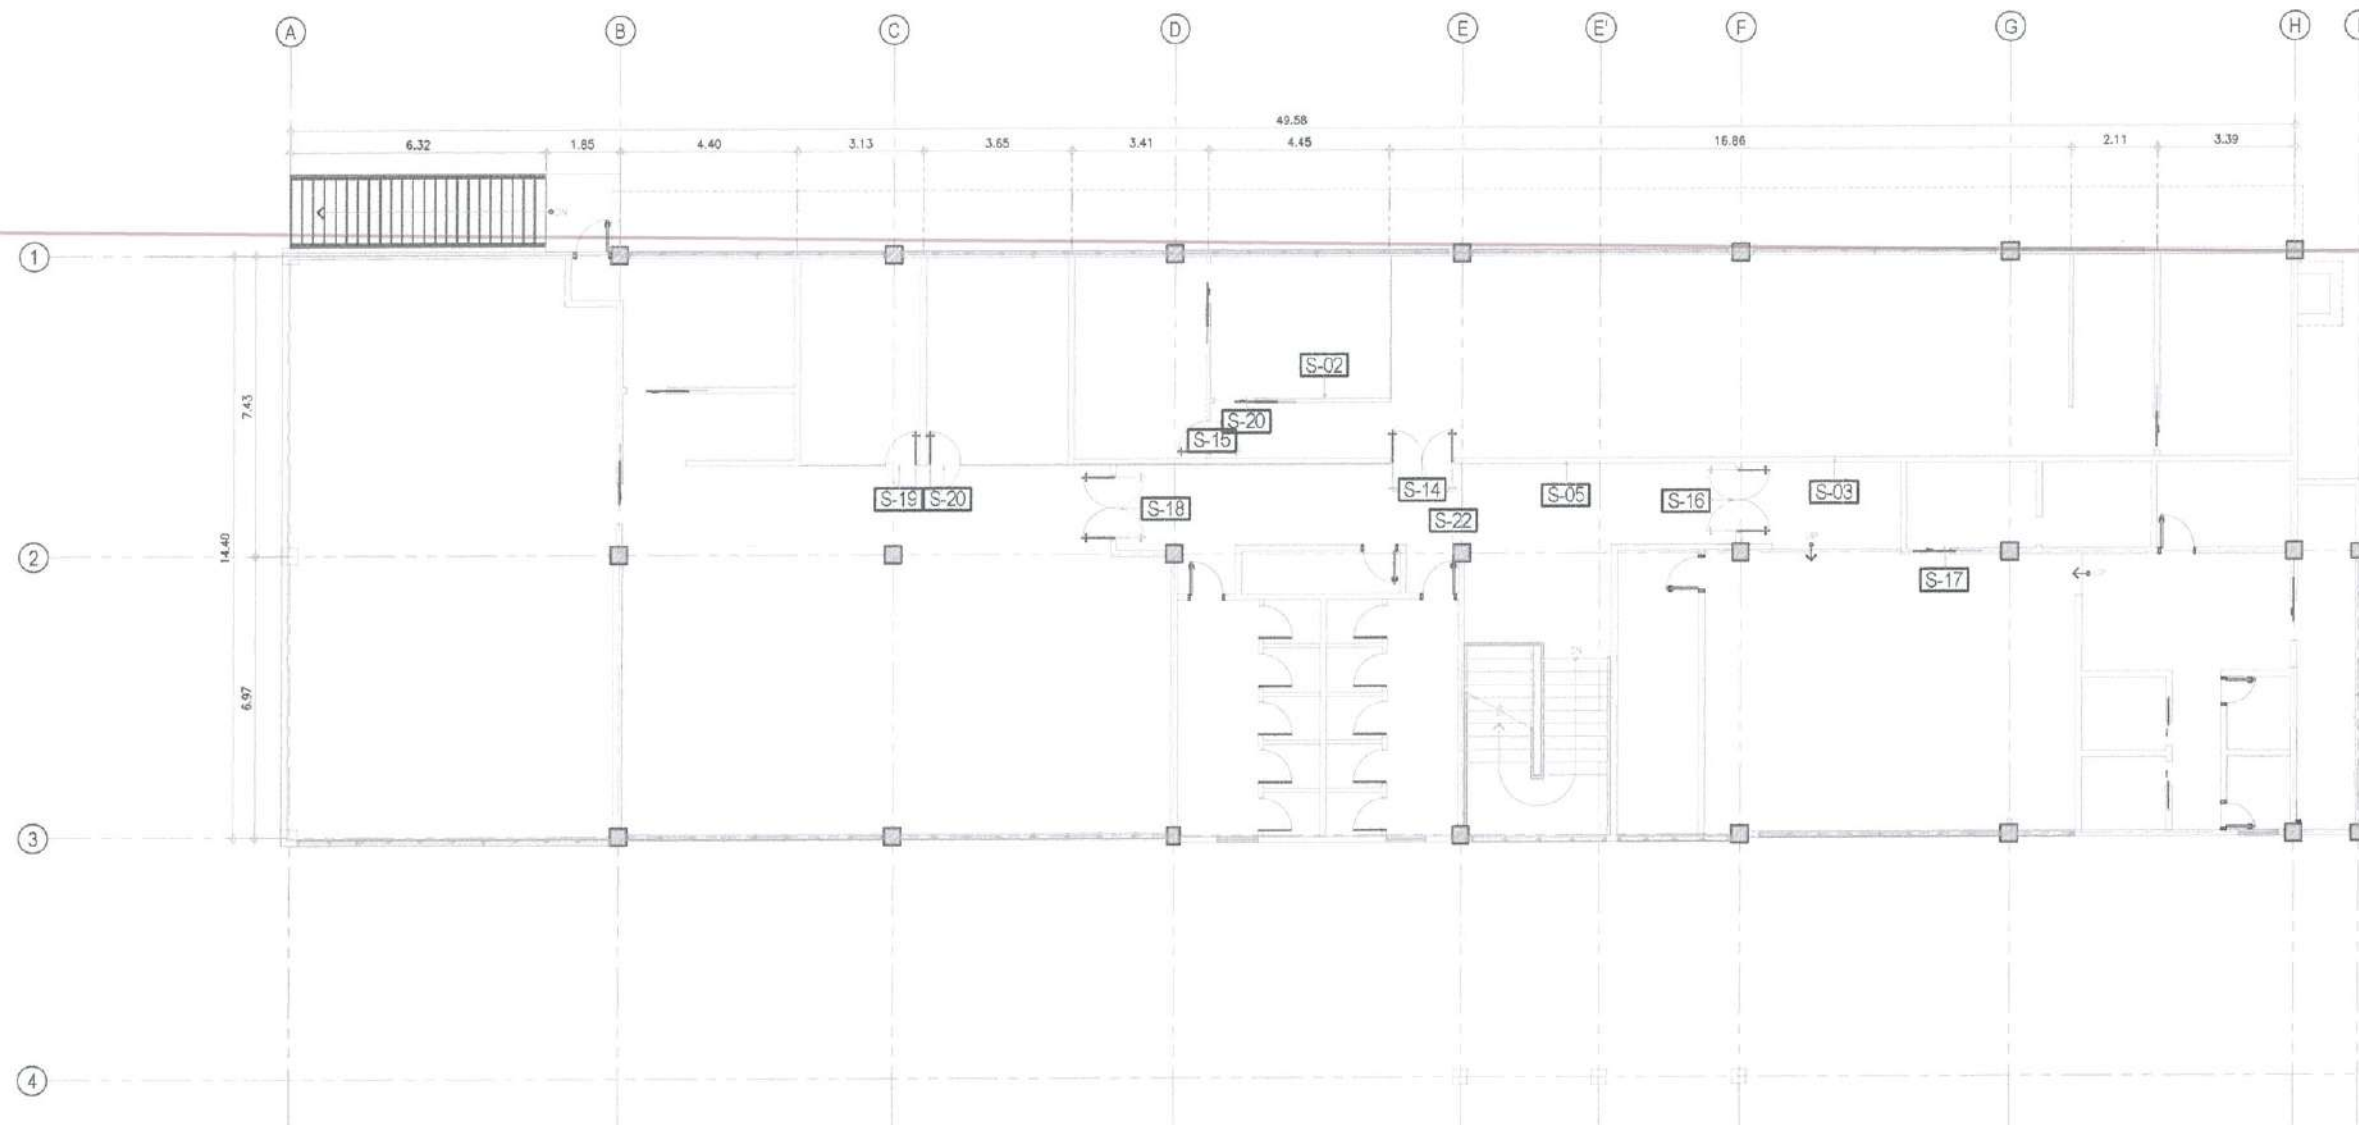


 1
A-13 A-13
SECOND FLOOR
SIGNAGE LAYOUT PLAN
SCALE: 1:100 M




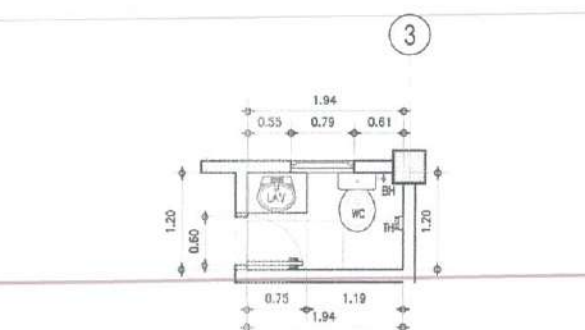


1 CSIS ADG II OFFICE
TOILET DETAIL PLAN
SCALE: 1:50 M

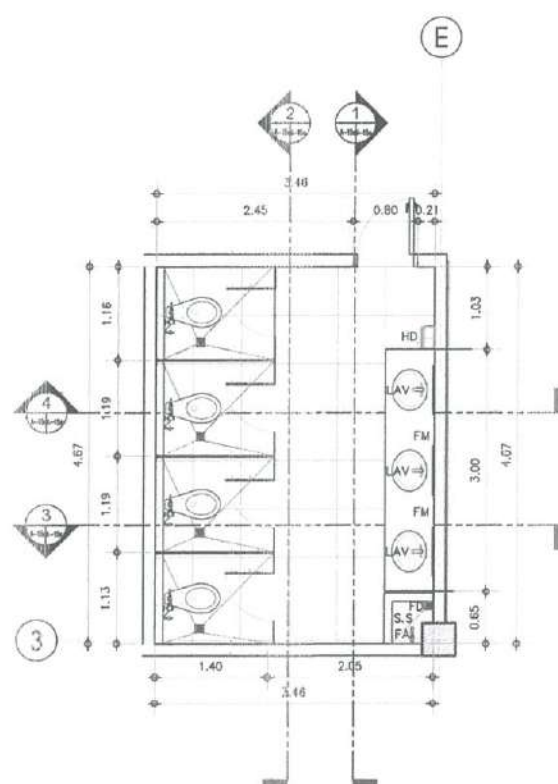


6 FEMALE CR @ GROUND FLOOR
TOILET DETAIL PLAN
SCALE: 1:50 M

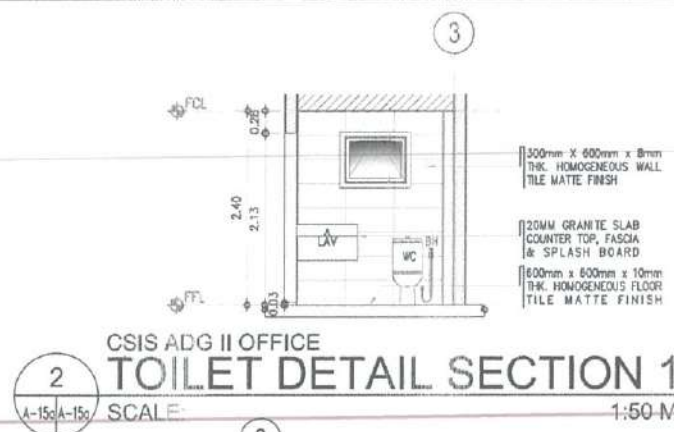


2 CSIS ADG II OFFICE
TOILET DETAIL SECTION 1
SCALE: 1:50 M

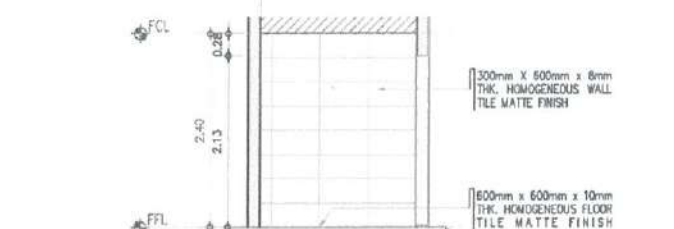


4 CSIS ADG II OFFICE
TOILET DETAIL SECTION 3
SCALE: 1:50 M

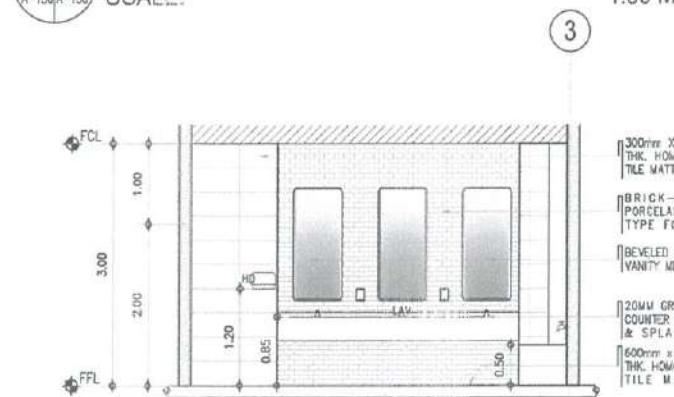

7 FEMALE CR @ GROUND FLOOR
TOILET DETAIL SECTION 1
SCALE: 1:50 M

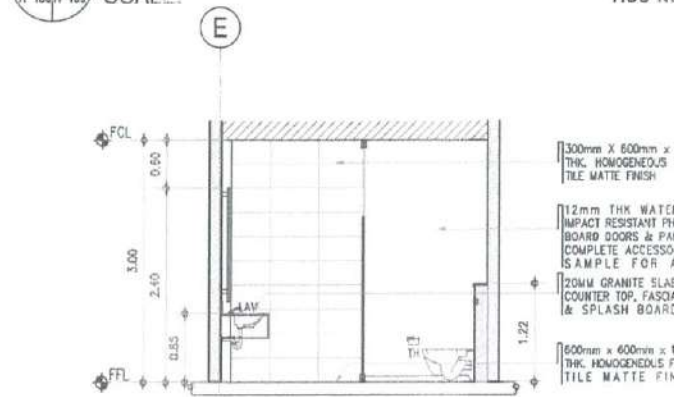


9 FEMALE CR @ GROUND FLOOR
TOILET DETAIL SECTION 3
SCALE: 1:50 M

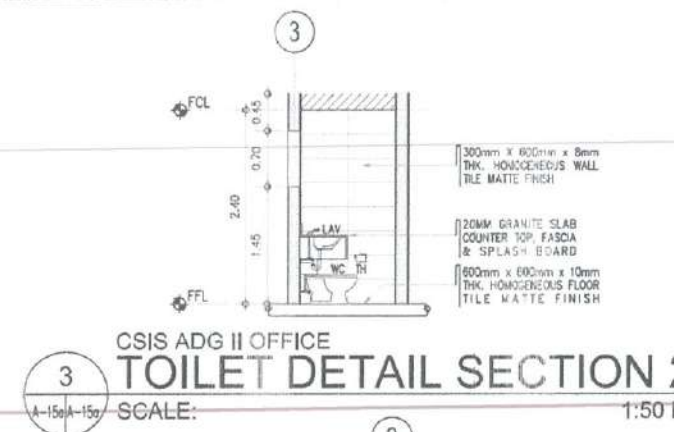


3 CSIS ADG II OFFICE
TOILET DETAIL SECTION 2
SCALE: 1:50 M








5 CSIS ADG II OFFICE
TOILET DETAIL SECTION 4
SCALE: 1:50 M

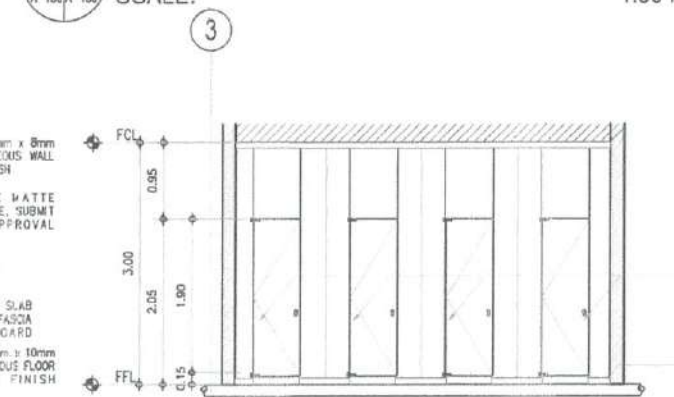


8 FEMALE CR @ GROUND FLOOR
TOILET DETAIL SECTION 2
SCALE: 1:50 M

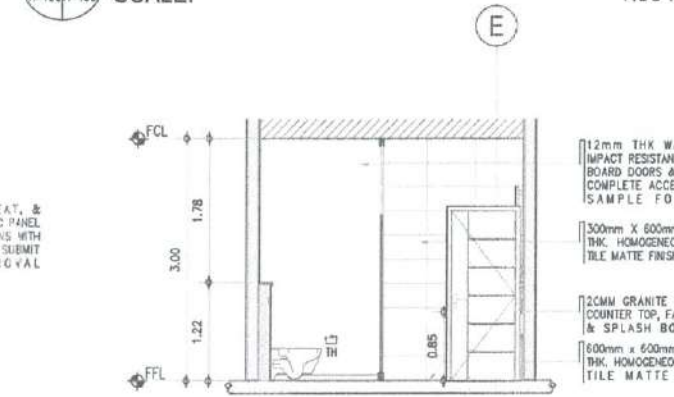


10 FEMALE CR @ GROUND FLOOR
TOILET DETAIL SECTION 4
SCALE: 1:50 M

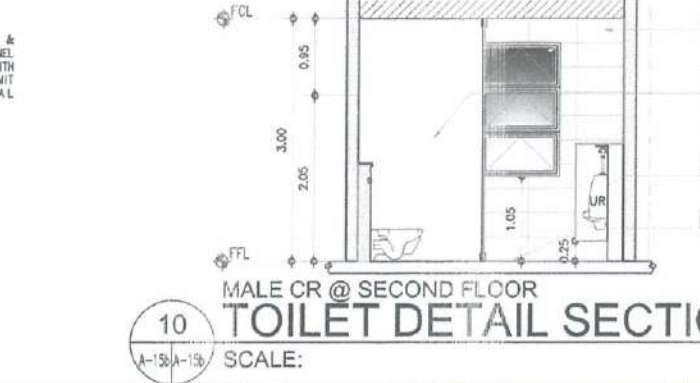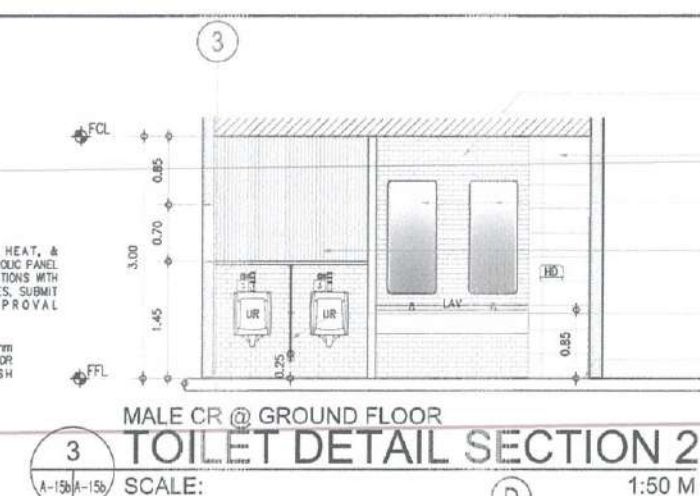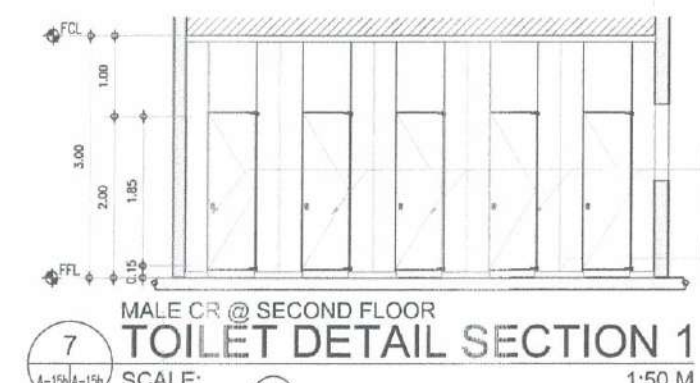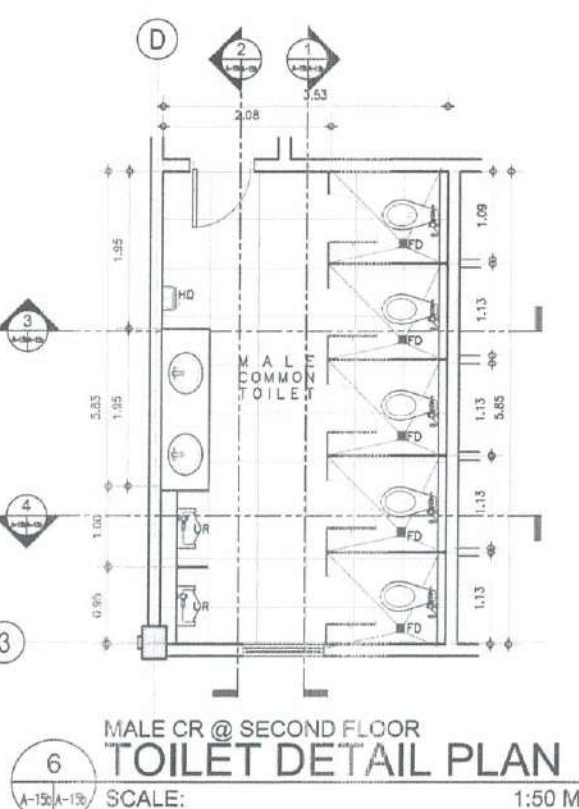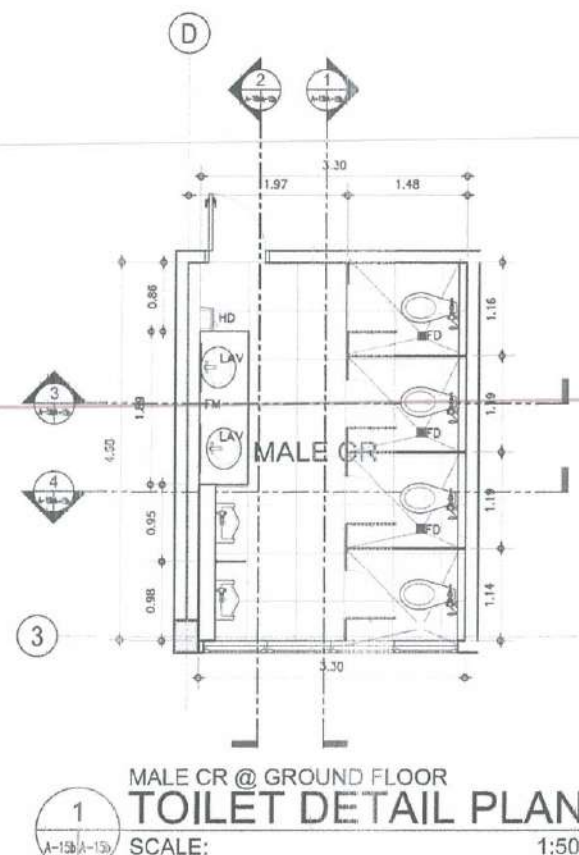


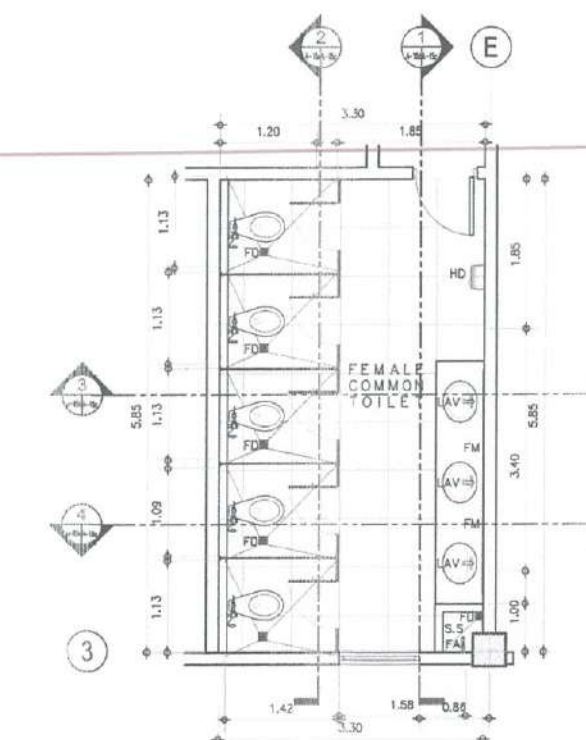


1
A-15c/A-15c
FEMALE CR @ SECOND FLOOR
TOILET DETAIL PLAN
SCALE: 1:50 M

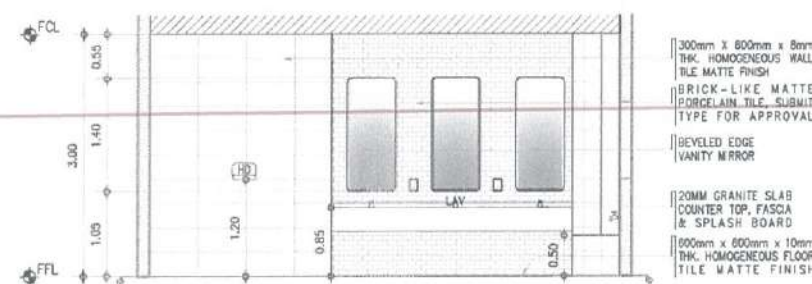


2
A-15c/A-15c
FEMALE CR @ GROUND FLOOR
TOILET DETAIL SECTION 1
SCALE: 1:50 M

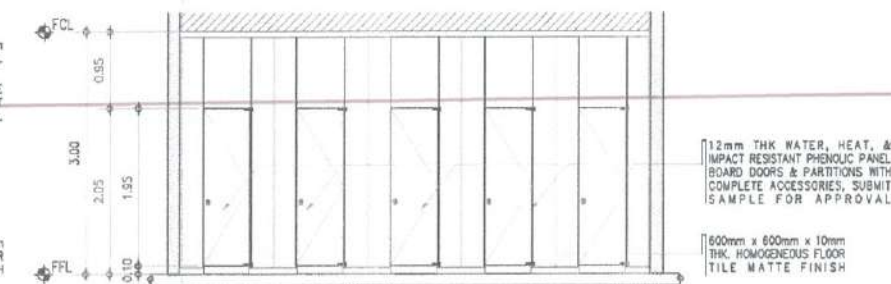


3
A-15c/A-15c
FEMALE CR @ GROUND FLOOR
TOILET DETAIL SECTION 2
SCALE: 1:50 M

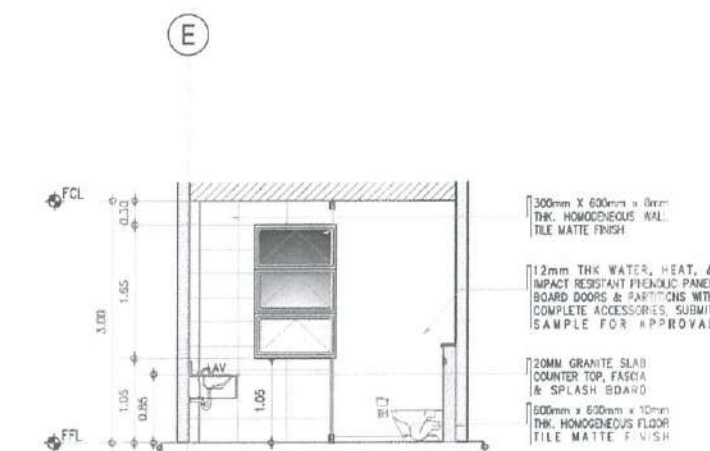


4
A-15c/A-15c
FEMALE CR @ GROUND FLOOR
TOILET DETAIL SECTION 3
SCALE: 1:50 M

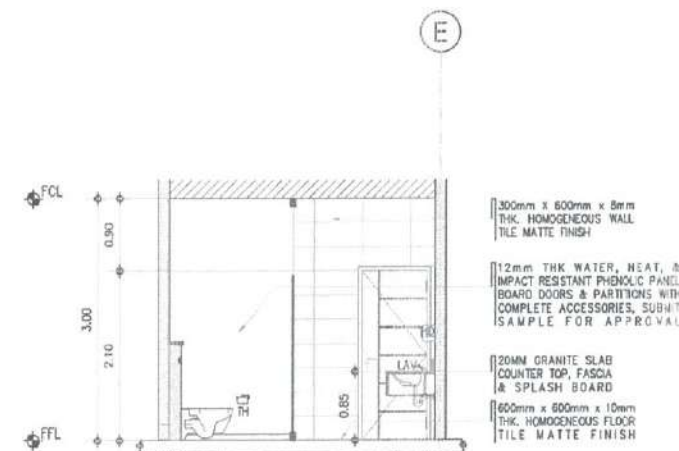

5
A-15c/A-15c
FEMALE CR @ GROUND FLOOR
TOILET DETAIL SECTION 4
SCALE: 1:50 M

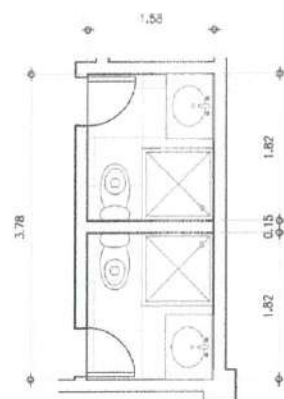


1
A-154/A-154
FEMALE & MALE CR @ OPCEN OFFICE
TOILET DETAIL PLAN
SCALE: 1:50 M

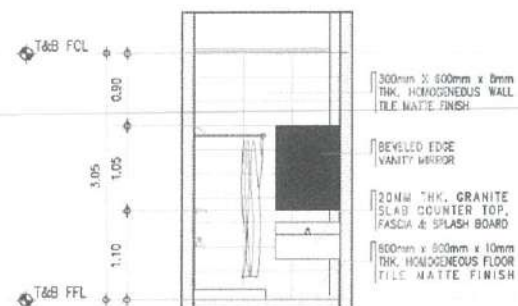


2
A-154/A-154
FEMALE & MALE CR @ OPCEN OFFICE
TOILET DETAIL SECTION 1
SCALE: 1:50 M




4
A-154/A-154
FEMALE & MALE CR @ OPCEN OFFICE
TOILET DETAIL SECTION 3
SCALE: 1:50 M

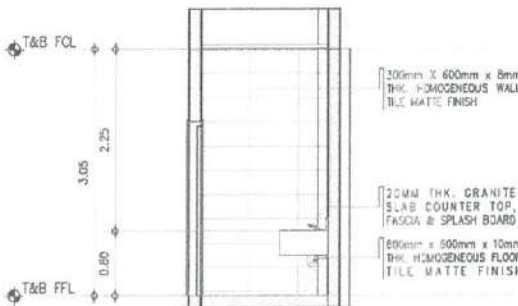


6
A-154/A-154
FEMALE & MALE CR @ OPCEN OFFICE
TOILET DETAIL SECTION 5
SCALE: 1:50 M

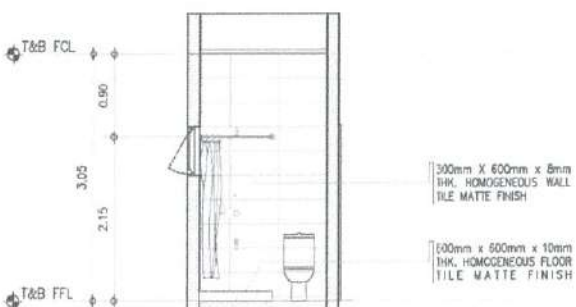


8
A-154/A-154
FEMALE & MALE CR @ OPCEN OFFICE
TOILET DETAIL SECTION 7
SCALE: 1:50 M

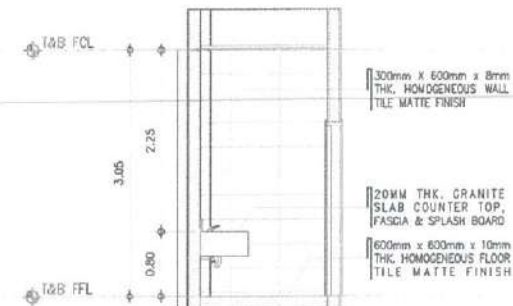


3
A-154/A-154
FEMALE & MALE CR @ OPCEN OFFICE
TOILET DETAIL SECTION 2
SCALE: 1:50 M

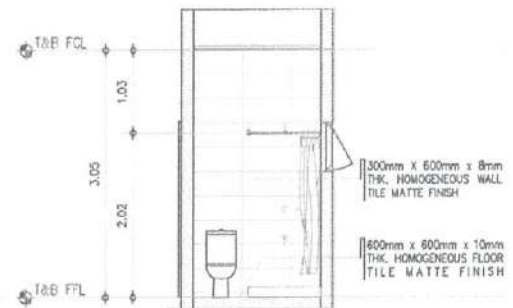

5
A-154/A-154
FEMALE & MALE CR @ OPCEN OFFICE
TOILET DETAIL SECTION 4
SCALE: 1:50 M

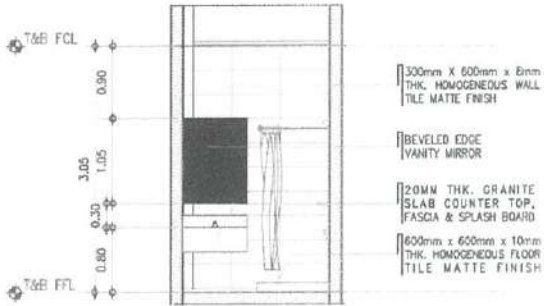

7
A-154/A-154
FEMALE & MALE CR @ OPCEN OFFICE
TOILET DETAIL SECTION 6
SCALE: 1:50 M

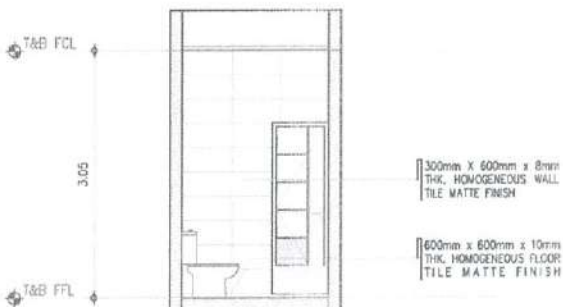

9
A-154/A-154
FEMALE & MALE CR @ OPCEN OFFICE
TOILET DETAIL SECTION 8
SCALE: 1:50 M



REPUBLIC OF THE PHILIPPINES
CIVIL AVIATION AUTHORITY OF THE PHILIPPINES
AERODROME DEVELOPMENT AND MANAGEMENT SERVICE
NAIA ROAD, PASAY CITY

THIS DRAWING AND DESIGN IS EXCLUSIVE PROPERTY OF CIVIL AVIATION AUTHORITY OF THE PHILIPPINES AND SUCH MUST NOT BE REPRODUCED, EXHIBITED, LOANED NOR COPIED IN PART OR IN WHOLE WITHOUT PROPER PERMISSION AND/OR WRITTEN CONSENT FROM THE DIRECTOR GENERAL CAA.

AERODROME DEVELOPMENT AND MANAGEMENT SERVICE

INFRASTRUCTURE DEVELOPMENT AND DESIGN DIVISION

DESIGN STAFF: INITIAL / DATE
DESIGNED BY: RGD
DRAWN BY: DRPG/MLR
CHECKED BY:

REVIEWED BY:

RAUL R. CRUCENA
Division Chief III, RGD-AED

SUBMITTED BY:

ARNEL F. BORLADO
Department Manager III, AED-ADMS

RECOMMEND APPROVAL:

LT COL. VALENTINO A. DIONELA PAF (RET)
Assistant Director General III, ADMS

APPROVED BY:

CAPTAIN MARIE ANTONIO L. TANAYO
Division Chief III

NOTES/REVISIONS:

PROJECT:

IMPROVEMENT/REHABILITATION OF AIRWAYS FACILITY COMPLEX BUILDING

LOCATION:

CAAP CENTRAL OFFICE
NAIA RD. COR. N. AQUINO AVENUE,
PASAY CITY

SHEET CONTENTS:

• TOILET DETAILS

DRAWING SCALE: SHEET NO:

1:50 M A
15d 17

NOTE: 1. VERIFY ACTUAL DIMENSIONS & JOISTS BEFORE FABRICATION.
2. MAKE ACTUAL SHOP DRAWING FOR CHECKING.
3. RESPONSIBILITY OF CONTRACTOR TO CHECK/ESTIMATE THE FURNITURES BASED ON THE PLANS.



REPUBLIC OF THE PHILIPPINES
CIVIL AVIATION AUTHORITY OF THE PHILIPPINES
AERODROME DEVELOPMENT AND MANAGEMENT SERVICE
NAIA ROAD, 1205 PASAY CITY

THIS DRAWINGS AND DESIGN IS EXCLUSIVE PROPERTIES OF CIVIL AVIATION AUTHORITY OF THE PHILIPPINES AND SUCH MUST NOT BE REPRODUCED, EXHIBITED, LOANED NOR COPIED IN PART OR IN WHOLE WITHOUT PROPER PERMISSION AND/OR WRITTEN CONSENT FROM THE DIRECTOR GENERAL CAA-P.

AERODROME DEVELOPMENT AND MANAGEMENT SERVICE

INFRASTRUCTURE DEVELOPMENT AND DESIGN DIVISION

DESIGN STAFF: INITIAL / DATE
DESIGNED BY: IDDD
DRAWN BY: DRPG/MLR
CHECKED BY: *[Signature]*

REVIEWED BY:

[Signature]
RAUL R. CRUCENA
Division Chief (IDDD/AE)

SUBMITTED BY:

[Signature]
ARNEL F. BORLADO
Department Manager III, AED/ADMS

RECOMMEND APPROVAL:

[Signature]
LT COL. VALENTINO A. DIGNELA PATI (RET.)
Assistant Director General III, ADMS

APPROVED BY:

[Signature]
CAPTAIN MARCOS ANTONIO L. TAVAYO
Director General









NOTES/REVISIONS:

PROJECT:
IMPROVEMENT/REHABILITATION OF AIRWAYS FACILITY COMPLEX BUILDING

LOCATION:
CAAP CENTRAL OFFICE
NAIA RD. COR. N. AQUINO AVENUE,
PASAY CITY













SHEET CONTENTS:
• SCHEDULE OF FURNITURES

DRAWING SCALE: NTS
SHEET NO.: A
16 17

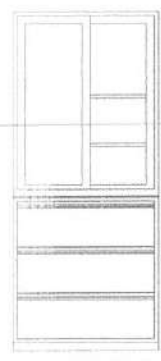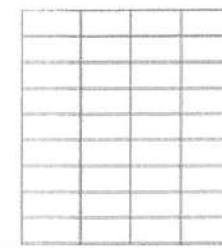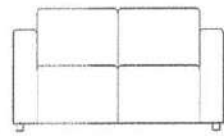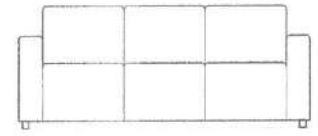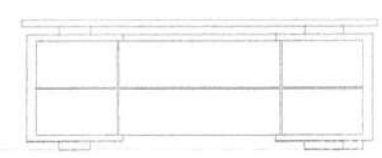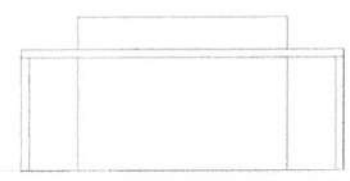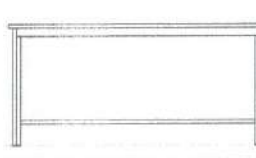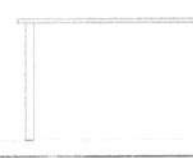 EXECUTIVE OFFICE CHAIR POLISHED ALUMINUM BASED HIGH BACK REST IN LEATHER UPHOLSTERY WITH CASTERS, TILT SWIVEL MECHANISM, SEAT HEIGHT ADJUSTMENT AND TILT LOCK FEATURE, WITH HEAD & ARM REST. DIMENSIONS: HARDWARES: LOCATION: CSIS CHIEF OFFICES, COA OFFICES, AAIB CHIEF OFFICE NO. OF SETS: 9 SETS	 STAFF OFFICE CHAIR POLISHED ALUMINUM BASED MID-HIGH BACK REST IN LEATHER UPHOLSTERY WITH CASTERS, TILT SWIVEL MECHANISM, SEAT HEIGHT ADJUSTMENT AND TILT LOCK FEATURE, WITH HEAD & ARM REST. DIMENSIONS: HARDWARES: LOCATION: SEE PLAN NO. OF SETS: 121 SETS	 VISITOR OFFICE CHAIR STAINLESS STEEL FRAMED LOW BACK REST IN MESH FABRIC UPHOLSTERY WITH ARM REST. DIMENSIONS: HARDWARES: LOCATION: CSIS ID PROCESSING ROOM, ALL CHIEF OFFICES NO. OF SETS: 11 SETS	 3 LAYER STEEL DRAWER STEEL CASING 3-DRAWER CABINET DIMENSIONS: 450MM (W) x 900MM (L) x 950MM (H) HARDWARES: LOCATION: SEE PLAN NO. OF SETS: 18 SETS	 3 LAYER STEEL DRAWER WITH CABINET STEEL CASING 3-DRAWER CABINET WITH STEEL CASED GLASS CABINET DIMENSIONS: 450MM (W) x 900MM (L) x 2100MM (H) HARDWARES: LOCATION: SEE PLAN NO. OF SETS: 61 SETS
 9 LAYER SHELVES STEEL CASING SHELVES IN WOOD-GRAIN LIKE LAMINATE FINISH DIMENSIONS: 400MM (W) x 2700MM (L) x 2900MM (H) HARDWARES: LOCATION: COA STORAGE NO. OF SETS: 39 SETS	 2-SEATER SOFA HARD WOOD FRAMED LOW BACK REST SOFA IN FABRIC UPHOLSTERY. DIMENSIONS: 1300MM (W) x 650MM (L) x 750MM (H) HARDWARES: LOCATION: COA OFFICE, AAIB CHIEF OFFICE, OPCEN OFFICE NO. OF SETS: 4 SETS	 3-SEATER SOFA HARD WOOD FRAMED LOW BACK REST SOFA IN FABRIC UPHOLSTERY. DIMENSIONS: 1800MM (L) x 650MM (W) x 750MM (H) HARDWARES: LOCATION: LOBBY, CSIS OFFICES, COA OFFICE NO. OF SETS: 6 SETS	 LARGE FORMAT DISPLAY TV 55" LARGE FORMAT DISPLAY TELEVISION DIMENSIONS: 55" HARDWARES: LOCATION: OPCEN OFFICE NO. OF SETS: 8 SETS	 MOTORIZED PROJECTOR SCREEN MOTORIZED PROJECTOR SCREEN: 1400MM x 1500MM DIMENSIONS: 1400MM x 1500MM HARDWARES: LOCATION: CONFERENCE ROOMS NO. OF SETS: 3 SETS
 EXECUTIVE OFFICE DESK HARD WOOD FRAMED WITH MDF BOARD TOP & SIDE COVER IN WOODGRAIN-LIKE LAMINATE FINISH. DIMENSIONS: 1800MM (L) x 600MM (W) x 750MM (H) HARDWARES: LOCATION: ALL CHIEF OFFICES (EXCEPT OPCEN CHIEF) NO. OF SETS: 5 SETS	 LOBBY DESK HARD WOOD FRAMED WITH 3/4" MDF BOARD TOP & SIDE COVER IN WOODGRAIN-LIKE LAMINATE (VERIFY ARCHITECT) DIMENSIONS: 2000MM(L) x 750MM(W) x 880MM(L) x 600MM(W) x 750MM (H) HARDWARES: BUILT-IN LOCK LOCATION: LOBBY NO. OF SETS: 1 SET	 DINING TABLE HARD WOOD FRAMED MDF 25mm THK. BOARD TOP IN WOODGRAIN-LIKE LAMINATE FINISH. DIMENSIONS: 1600MM (L) x 600MM (W) x 750MM (H) HARDWARES: LOCATION: SEE PLAN NO. OF SETS: 4 SETS	 DINING CHAIR WOODEN HIGH BACK CHAIR WOODGRAIN-LIKE LAMINATE FINISH. DIMENSIONS: 450MM (W) x 500MM (L) x 1200MM (H) HARDWARES: LOCATION: SEE PLAN NO. OF SETS: 24 SETS	 CONFERENCE TABLE HARD WOOD FRAMED MDF BOARD TOP IN WOODGRAIN-LIKE LAMINATE FINISH. DIMENSIONS: 1200MM (W) x 2100MM (L) x 750MM (H) HARDWARES: LOCATION: CONFERENCE ROOMS NO. OF SETS: 4 SETS











1 SCHEDULE OF FURNITURES
SCALE: NTS

  NOTE: 1. VERIFY ACTUAL DIMENSION & JOBSITE BEFORE FABRICATION.
2. RESPONSIBILITY OF CONTRACTOR TO CHECK/ESTIMATE THE FURNITURES BASED ON THE PLANS.

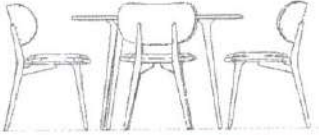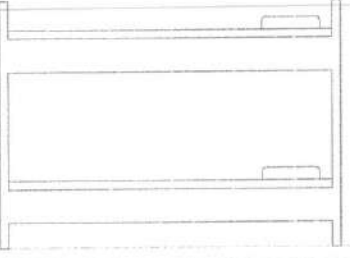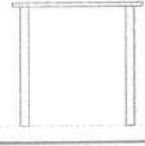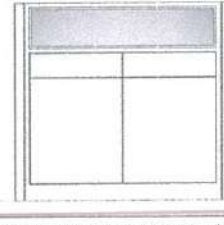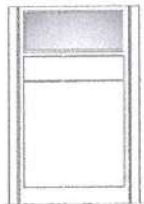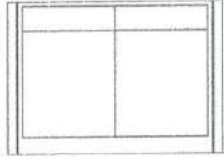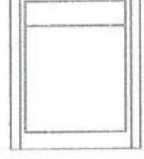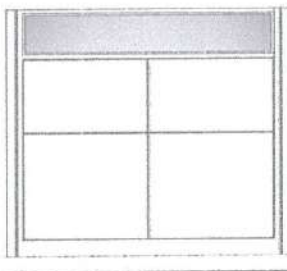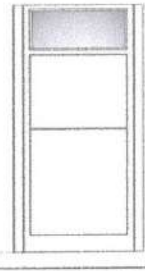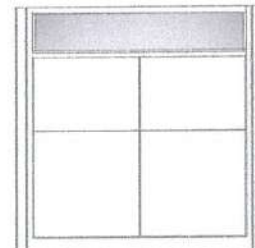					  REPUBLIC OF THE PHILIPPINES CIVIL AVIATION AUTHORITY OF THE PHILIPPINES AERODROME DEVELOPMENT AND MANAGEMENT SERVICE NAIA ROAD 1300 PASAY CITY THIS DRAWINGS AND DESIGN IS EXCLUSIVE PROPERTY OF CIVIL AVIATION AUTHORITY OF THE PHILIPPINES AND SUCH MUST NOT BE REPRODUCED, EXHIBITED, LOANED NOR COPIED IN PART OR IN WHOLE WITHOUT PROPER PERMISSION AND/OR WRITTEN CONSENT FROM THE DIRECTOR GENERAL CAAP. AERODROME DEVELOPMENT AND MANAGEMENT SERVICE INFRASTRUCTURE DEVELOPMENT AND DESIGN DIVISION DESIGN STAFF: INITIAL / DATE DESIGNED BY: IDDD DRAWN BY: DRPGM/PLR CHECKED BY:
4 SEATER ROUND TABLE HARD WOOD FRAMED MDF BOARD TOP IN WOODGRAIN-LIKE LAMINATE FINISH. WOODEN HIGH BACK CHAIR WOODGRAIN-LIKE LAMINATE FINISH. DIMENSIONS: 3800MM² HARDWARES: LOCATION: CSIS ADG II OFFICE NO. OF SETS: 1 SET	SINGLE BUNK BED HARD WOOD FRAMED MDF BOARD TOP IN WOODGRAIN-LIKE LAMINATE FINISH WITH TWO SINGLE BED SIZED MATTRESS. DIMENSIONS: 2100MM (L) x 910MM (W) x 1500MM (H) HARDWARES: LOCATION: OPEN MALE & FEMALE QUARTERS NO. OF SETS: 2 SETS	SINGLE BED HARD WOOD FRAMED MDF BOARD TOP IN WOODGRAIN-LIKE LAMINATE FINISH WITH SINGLE BED SIZED MATTRESS. DIMENSIONS: 2100MM (L) x 910MM (W) x 550MM (H) HARDWARES: LOCATION: OPEN CHIEF OFFICE NO. OF SETS: 1 SET	4 SEATER SQUARE TABLE HARD WOOD FRAMED MDF BOARD TOP IN WOODGRAIN-LIKE LAMINATE FINISH. DIMENSIONS: 800MM (L) x 800MM (W) x 750MM (H) HARDWARES: LOCATION: INTERROGATION ROOM NO. OF SETS: 1 SET	OFFICE MODULAR PARTITION/WORKSTATION ALUMINUM FRAME WITH 2-TONE FABRIC PANEL COVERING AND GLASS PANEL WITH FROSTED FILM; CONVENIENCE OUTLET HOLE & COMMUNICATION DATA OUTLET HOLE READY DIMENSIONS: 1300MM(L) x 1200MM (H) HARDWARES: LOCATION: SEE PLAN NO. OF SETS: 40 SETS	REVIEWED BY: RAUL R. CRUCENA Division Chief III, IDDD-AED SUBMITTED BY: ARNELIF BORLADO Department Manager III, AED-ADMS RECOMMEND APPROVAL: LT COL VALENTINO A. DIONELA PAF (RET) Assistant Director General II, ADMS APPROVED BY: CAPTAIN MANUEL ANTONIO L. TAMAYO Director General
					
OFFICE MODULAR PARTITION/WORKSTATION ALUMINUM FRAME WITH 2-TONE FABRIC PANEL COVERING AND GLASS PANEL WITH FROSTED FILM; CONVENIENCE OUTLET HOLE & COMMUNICATION DATA OUTLET HOLE READY DIMENSIONS: 800MM(L) x 1200MM (H) HARDWARES: LOCATION: SEE PLAN NO. OF SETS: 92 SETS	OFFICE MODULAR PARTITION/WORKSTATION ALUMINUM FRAME WITH 2-TONE FABRIC PANEL COVERING; CONVENIENCE OUTLET HOLE & COMMUNICATION DATA OUTLET HOLE READY DIMENSIONS: 1300MM(L) x 900MM (H) HARDWARES: LOCATION: SEE PLAN NO. OF SETS: 4 SETS	OFFICE MODULAR PARTITION/WORKSTATION ALUMINUM FRAME WITH 2-TONE FABRIC PANEL COVERING; CONVENIENCE OUTLET HOLE & COMMUNICATION DATA OUTLET HOLE READY DIMENSIONS: 800MM(L) x 900MM (H) HARDWARES: LOCATION: SEE PLAN NO. OF SETS: 5 SETS	OFFICE MODULAR PARTITION/WORKSTATION ALUMINUM FRAME WITH 2-TONE FABRIC PANEL COVERING AND GLASS PANEL WITH FROSTED FILM; CONVENIENCE OUTLET HOLE & COMMUNICATION DATA OUTLET HOLE READY DIMENSIONS: 1800MM(L) x 1500MM (H) HARDWARES: LOCATION: SEE PLAN NO. OF SETS: 10 SETS	OFFICE MODULAR PARTITION/WORKSTATION ALUMINUM FRAME WITH 2-TONE FABRIC PANEL COVERING AND GLASS PANEL WITH FROSTED FILM; CONVENIENCE OUTLET HOLE & COMMUNICATION DATA OUTLET HOLE READY DIMENSIONS: 800MM(L) x 1500MM (H) HARDWARES: LOCATION: SEE PLAN NO. OF SETS: 4 SETS	
					
OFFICE MODULAR PARTITION/WORKSTATION ALUMINUM FRAME WITH 2-TONE FABRIC PANEL COVERING AND GLASS PANEL WITH FROSTED FILM; CONVENIENCE OUTLET HOLE & COMMUNICATION DATA OUTLET HOLE READY DIMENSIONS: 1500MM(L) x 1500MM (H) HARDWARES: LOCATION: SEE PLAN NO. OF SETS: 21 SETS	OFFICE MODULAR PARTITION/WORKSTATION ALUMINUM FRAME WITH 2-TONE FABRIC PANEL COVERING AND GLASS PANEL WITH FROSTED FILM; CONVENIENCE OUTLET HOLE & COMMUNICATION DATA OUTLET HOLE READY DIMENSIONS: 600MM(L) x 1500MM (H) HARDWARES: LOCATION: SEE PLAN NO. OF SETS: 10 SETS				

1 SCHEDULE OF FURNITURES
A-17 A-17 SCALE: NTS

DRAWING SCALE:	SHEET NO:
NTS	A
	17 17

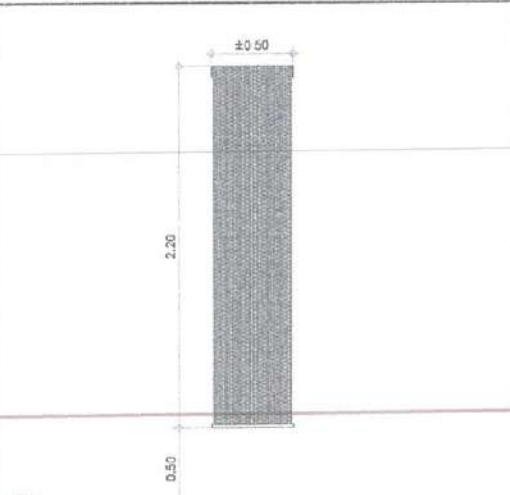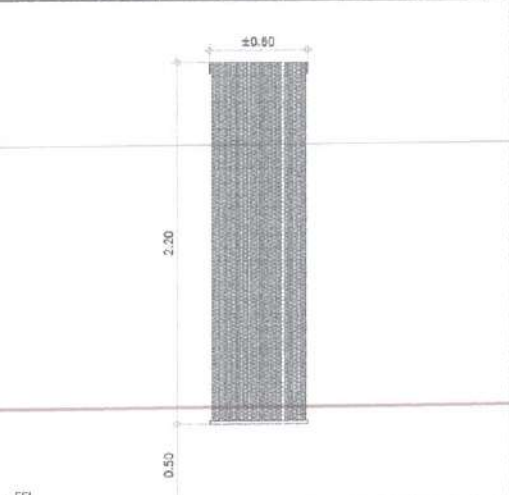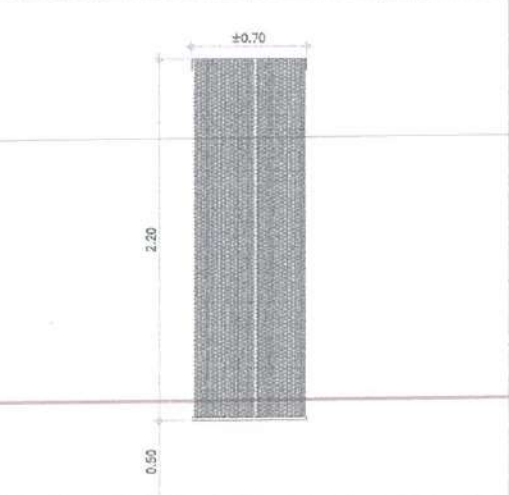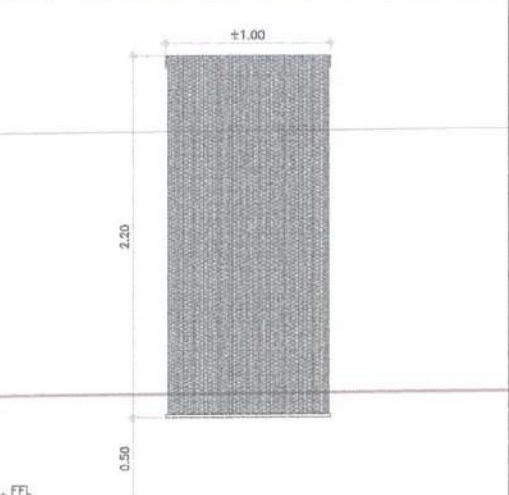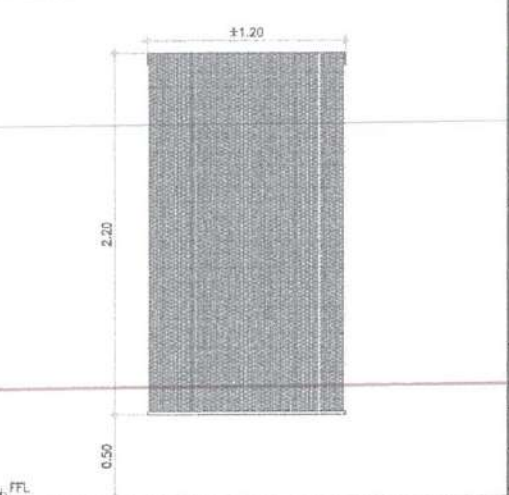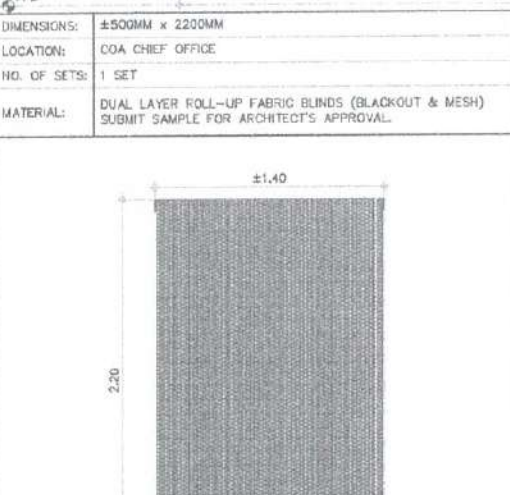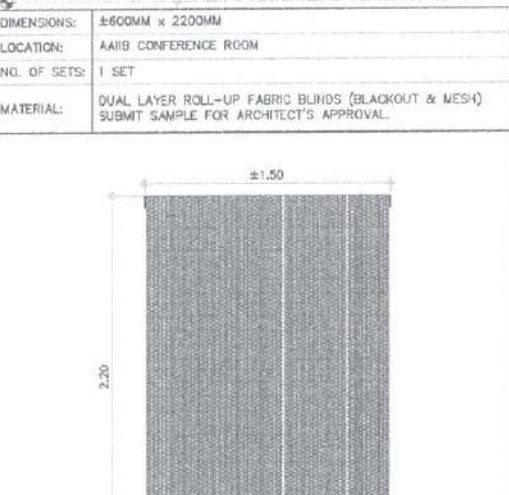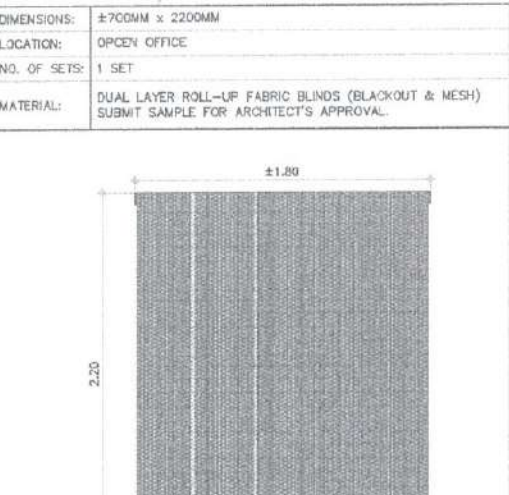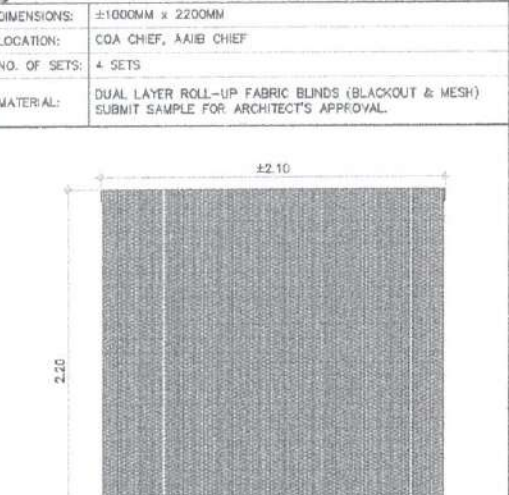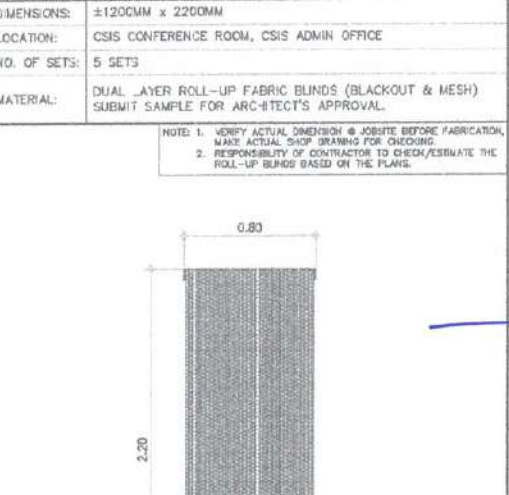																					
DIMENSIONS: ±500MM x 2200MM LOCATION: COA CHIEF OFFICE NO. OF SETS: 1 SET MATERIAL: DUAL LAYER ROLL-UP FABRIC BLINDS (BLACKOUT & MESH) SUBMIT SAMPLE FOR ARCHITECT'S APPROVAL.		DIMENSIONS: ±600MM x 2200MM LOCATION: AAIB CONFERENCE ROOM NO. OF SETS: 1 SET MATERIAL: DUAL LAYER ROLL-UP FABRIC BLINDS (BLACKOUT & MESH) SUBMIT SAMPLE FOR ARCHITECT'S APPROVAL.		DIMENSIONS: ±700MM x 2200MM LOCATION: OPCEY OFFICE NO. OF SETS: 1 SET MATERIAL: DUAL LAYER ROLL-UP FABRIC BLINDS (BLACKOUT & MESH) SUBMIT SAMPLE FOR ARCHITECT'S APPROVAL.		DIMENSIONS: ±1000MM x 2200MM LOCATION: COA CHIEF, AAIB CHIEF NO. OF SETS: 4 SETS MATERIAL: DUAL LAYER ROLL-UP FABRIC BLINDS (BLACKOUT & MESH) SUBMIT SAMPLE FOR ARCHITECT'S APPROVAL.		DIMENSIONS: ±1200MM x 2200MM LOCATION: CSIS CONFERENCE ROOM, CSIS ADMIN OFFICE NO. OF SETS: 5 SETS MATERIAL: DUAL LAYER ROLL-UP FABRIC BLINDS (BLACKOUT & MESH) SUBMIT SAMPLE FOR ARCHITECT'S APPROVAL.		DIMENSIONS: ±1400MM x 2200MM LOCATION: AAIB OFFICE, OPCEY OFFICE NO. OF SETS: 2 SETS MATERIAL: DUAL LAYER ROLL-UP FABRIC BLINDS (BLACKOUT & MESH) SUBMIT SAMPLE FOR ARCHITECT'S APPROVAL.		DIMENSIONS: ±1500MM x 2200MM LOCATION: IQCS, IID CHIEF, SD CHIEF & CSIS ADMIN OFFICE NO. OF SETS: 8 SETS MATERIAL: DUAL LAYER ROLL-UP FABRIC BLINDS (BLACKOUT & MESH) SUBMIT SAMPLE FOR ARCHITECT'S APPROVAL.		DIMENSIONS: ±1800MM x 2200MM LOCATION: COA CONFERENCE ROOM, SERVER ROOM NO. OF SETS: 3 SETS MATERIAL: DUAL LAYER ROLL-UP FABRIC BLINDS (BLACKOUT & MESH) SUBMIT SAMPLE FOR ARCHITECT'S APPROVAL.		DIMENSIONS: ±2100MM x 2200MM LOCATION: COA OFFICE, COA & AAIB CONF. ROOM, AAIB OFFICE, OPCEY NO. OF SETS: 17 SETS MATERIAL: DUAL LAYER ROLL-UP FABRIC BLINDS (BLACKOUT & MESH) SUBMIT SAMPLE FOR ARCHITECT'S APPROVAL.		DIMENSIONS: ±800MM x 2200MM LOCATION: ALL CHIEF OFFICES, CSIS CONFERENCE ROOM DOORS NO. OF SETS: 9 SETS MATERIAL: DUAL LAYER ROLL-UP FABRIC BLINDS (BLACKOUT & MESH) SUBMIT SAMPLE FOR ARCHITECT'S APPROVAL.		REPUBLIC OF THE PHILIPPINES CIVIL AVIATION AUTHORITY OF THE PHILIPPINES AERODROME DEVELOPMENT AND MANAGEMENT SERVICE NAIA ROAD, 1305 PASAY CITY THIS DRAWINGS AND DESIGN IS EXCLUSIVE PROPERTY OF CIVIL AVIATION AUTHORITY OF THE PHILIPPINES AND SUCH MUST NOT BE REPRODUCED, EXHIBITED, LOANED NOR COPIED IN PART OR IN WHOLE WITHOUT PROPER PERMISSION AND/OR WRITTEN CONSENT FROM THE DIRECTOR GENERAL, CAAP. AERODROME DEVELOPMENT AND MANAGEMENT SERVICE INFRASTRUCTURE DEVELOPMENT AND DESIGN DIVISION DESIGN STAFF: INITIAL / DATE DESIGNED BY: IDDD DRAWN BY: DRPGMPLR CHECKED BY: REVIEWED BY: RAUL R. CRUCENA Division Chief II, IDDD-AED SUBMITTED BY: ARNEL F. BORLADO Department Manager III, AED-ADMS RECOMMEND APPROVAL: LT COL VALERINO A. DIONELA PAF (RET) Assistant Director General II, ADMS APPROVED BY: CAPTAIN MAURICIO L. TAMAYO Division Chief NOTES/REVISIONS: PROJECT: IMPROVEMENT/REHABILITATION OF AIRWAYS FACILITY COMPLEX BUILDING LOCATION: CAAP CENTRAL OFFICE NAIA RD. COR. N. AQUINO AVENUE, PASAY CITY SHEET CONTENTS: SCHEDULE OF ROLL-UP FABRIC BLINDS DRAWING SCALE: 1:25 M SHEET NO: A 17a 17	



SCHEDULE OF ROLL-UP FABRIC BLINDS

SCALE:

1:25 M

A. GENERAL

1. CONSTRUCTION NOTES AND TYPICAL DETAILS APPLY TO ALL UNLESS OTHERWISE SHOWN OR NOTED. MODIFY TYPICAL DETAILS AS DIRECTED TO MEET SPECIAL CONDITIONS.
2. SHOP DRAWINGS WITH ERECTION AND PLACING DIAGRAMS OF ALL STRUCTURAL STEEL, MISCELLANEOUS IRON, PRE-CAST CONCRETE ETC. SHALL BE SUBMITTED FOR ENGINEER'S APPROVAL BEFORE FABRICATION.
3. CONTRACTOR SHALL VERIFY ALL DIMENSIONS BEFORE ALL WORK IS TO BEGIN. COORDINATE WITH MECHANICAL, ELECTRICAL CONTRACTORS FOR CONDUITS, PIPE SLEEVES, ETC. TO BE EMBEDDED IN CONCRETE.
4. IT SHALL BE THE CONTRACTOR'S RESPONSIBILITY TO PROVIDE ADEQUATE SHORINGS AND BRACING OF THE STRUCTURE FOR ALL LOADS THAT MAYBE IMPOSED DURING CONSTRUCTION.

B. CONCRETE AND REINFORCEMENT

1. ALL MATERIALS WORKMANSHIP SHALL CONFORM WITH THE LATEST BUILDING CODE OF AMERICAN CONCRETE INSTITUTE (ACI-318).
1. ALL CONCRETE SHALL DEVELOP A MINIMUM COMPRESSIVE STRENGTH AT THE END OF TWENTY EIGHT (28) DAYS WITH CORRESPONDING MAXIMUM SIZE AGGREGATE AND SLUMPS AS FOLLOWS

LOCATION	28 DAYS STRENGTH	MAX. SIZE AGGREGATE	MAX. SLUMP
SLAB ON GRADE	3500 PSI	1 in. (25 mm)	4 in. (100 mm)
WALL FOOTING			
SUSPENDED SLAB			
COUNTER TOP			
FOUNDATION & COLUMN, BEAM	3500 PSI	3/4 in. (19 mm)	4 in. (100 mm)
ALL OTHERS	3500 PSI	3/4 in. (19 mm)	5 in. (125 mm)

3. REINFORCING BARS SHALL CONFORM TO ASTM A615 GRADE 40 FOR #12 & SMALLER REINFORCING BARS SHALL CONFORM TO ASTM A615 GRADE 60 FOR #10 & BIGGER
4. IN GENERAL, THE LATEST EDITION OF ACI-315, MANUAL OF STANDARD PRACTICE DETAILING REINFORCED CONCRETE STRUCTURES SHALL BE ADHERED TO UNLESS OTHERWISE SHOWN OR NOTED.
5. MAINTAIN MINIMUM CONCRETE COVER FOR REINFORCING STEEL AS FOLLOWS.

	3/4 in. (19mm)
SUSPENDED SLABS	1 1/2 in. (38mm)
SLAB ON GRADE	1 in. (25mm)
WALLS ABOVE GRADE	1 1/2 in. (38mm)
BEAM STIRRUPS AND COLUMN TIES	
WHERE CONCRETE IS EXPOSED TO EARTH BUT FOURED AGAINST FORMS	2 in. (50mm)
WHERE CONCRETE IS DEPOSITED DIRECTLY AGAINST EARTH	3 in (75mm)

6. SPICES SHALL BE SECURELY WIRED AND SMALL LAP OR EXTEND IN ACCORDANCE WITH TABLE 1 (TABLE OF LAP SPICE AND ANCHORAGE LENGTH) UNLESS OTHERWISE SHOWN ON DRAWINGS, SPICES SHALL BE STAGGERED WHENEVER POSSIBLE.
7. ALL ANCHOR BOLTS, DOWELS, AND OTHER INSERTS, SHALL BE PROPERLY POSITIONED AND SECURED IN PLACE PRIOR TO PLACING OF CONCRETE.
8. CONTRACTOR SHALL NOTE AND PROVIDE ALL MISCELLANEOUS CURBS, SILLS, TOOLS, EQUIPMENTS AND MECHANICAL BASES THAT ARE REQUIRED BY THE ARCHITECTURAL, ELECTRICAL, AND MECHANICAL DRAWINGS.
9. ALL CONCRETE SHALL BE KEPT MOIST FOR A MINIMUM OF SEVEN (7) CONCRETE DAYS IMMEDIATELY AFTER POURING BY THE USE OF WET BURLAP, FOG SPRAYING, CURING COMPOUNDS OR OTHER APPROVED METHODS.
10. STRIPPING OF FORMS AND SHORES
REFER TO TECHNICAL SPECIFICATIONS

C. CAMBER REQUIREMENTS

1. UNLESS PHERWISE NOTED ON THE PLANS OR SPECIFICATIONS, CAMBER ALL R.C BEAMS AT LEAST 10mm PER EVERY 4000mm OF CLEAR SPAN EXCEPT CANTILEVERS WHICH SHALL BE 50mm FOR EVERY 3000mm OF CLEAR SPAN.
2. UNLESS OTHERWISE NOTED IN PLANS OR SPECIFICATIONS, CAMBERS ALL SLABS 6mm PER 3000mm OF SHORTER SPAN AND 14mm. FOR EVERY 2000mm OF SLABS CANTILEVER SPAN.

D. MASONRY AND CONCRETE BLOCKS

1. ALL-LOAD BEARING TYPE CONCRETE BLOCKS SHALL HAVE A UNIT WEIGHT NOT TO EXCEED 80 PCF. FOR LOAD BEARING TYPE CONCRETE BLOCKS A MINIMUM COMPRESSIVE STRENGTH OF 8.50 MPa, SHALL BE DEVELOPED
2. PROVIDE 1-#16 VERTICAL BARS AT CORNERS, INTERSECTIONS, END OF WALLS, EACH SIDE OF OPENINGS.
3. UNTEL BEAMS SHALL BEAR AT LEAST 8 INCHES (200 MM.) ON EACH SIDE OF MASONRY WALL OPENING.
4. WALL REINFORCEMENTS SHALL BE AS FOLLOWS:

WALL THICKNESS	VERTICAL REINFORCEMENT	HORIZONTAL REINFORCEMENT
8 IN. (200 mm)	#12 @ 400 mm	#10 @ 600 mm
6 IN (150 mm)	#10 @ 600 mm	#10 @ 600 mm
4 IN. (100 mm)	#10 @ 600 mm	#10 @ 600 mm


5. REINFORCING BARS SHALL BE LAPPED A MINIMUM OF 40 BARS DIAMETERS WHERE SPICED DOWELS FROM CONCRETE FOOTINGS OR SLABS EXTEND INTO THE BLOCK WALL A MINIMUM OF 40 BAR DIAMETERS, AND DOWELS TO MATCH VERTICAL REINFORCEMENTS OF WALL.
6. ALL CELLS CONTAINING REINFORCING BARS OR INSERTS SHALL BE SOLIDLY FILLED WITH CONCRETE GROUT, (REFER TO SPECIFICATIONS).

E. STEEL NOTES:

1. ALL STRUCTURAL STEEL SHAPES SHALL CONFORM TO STD. REQUIREMENTS OF AISI FOR ASTM A36 STEEL
2. ALL COLD FORMED STEEL SHAPES SHALL CONFORM TO STD. REQUIREMENTS OF AISI FOR JS G3141 SPOC
3. ALL WELDS SHALL CONFORM WITH AWS STD.
4. CONNECTORS
BOLTS ASTM A307 OR ASTM A325 AS SPECIFIED
WELDS E60XX ELECTRODE

F. FOUNDATION

1. FOUNDATION IS DESIGNED BASED ON THE ASSUMPTION OF 120 KPA SOIL BEARING CAPACITY FOR FOOTING NOT LESS THAN 1.5M.
2. FOUNDATION SHALL REST ON NATURAL SOIL, UNLESS OTHERWISE NOTED BY THE ENGINEER, NO PART OF THE FOUNDATION SHALL REST ON FILL.
3. THE CONTRACTOR SHALL NOTIFY THE ENGINEER AFTER FOOTING EXCAVATION HAVE BEEN COMPLETED AND PRIOR TO CONCRETING TO CONFIRM THE DESIGN SOIL BEARING CAPACITY.
4. THE CONTRACTOR SHALL HAVE THE SOLE RESPONSIBILITY TO DEVISE & IMPLEMENT EXCAVATION PROCEDURES THAT WILL ENSURE SAFETY OF LIFE & PROPERTY.

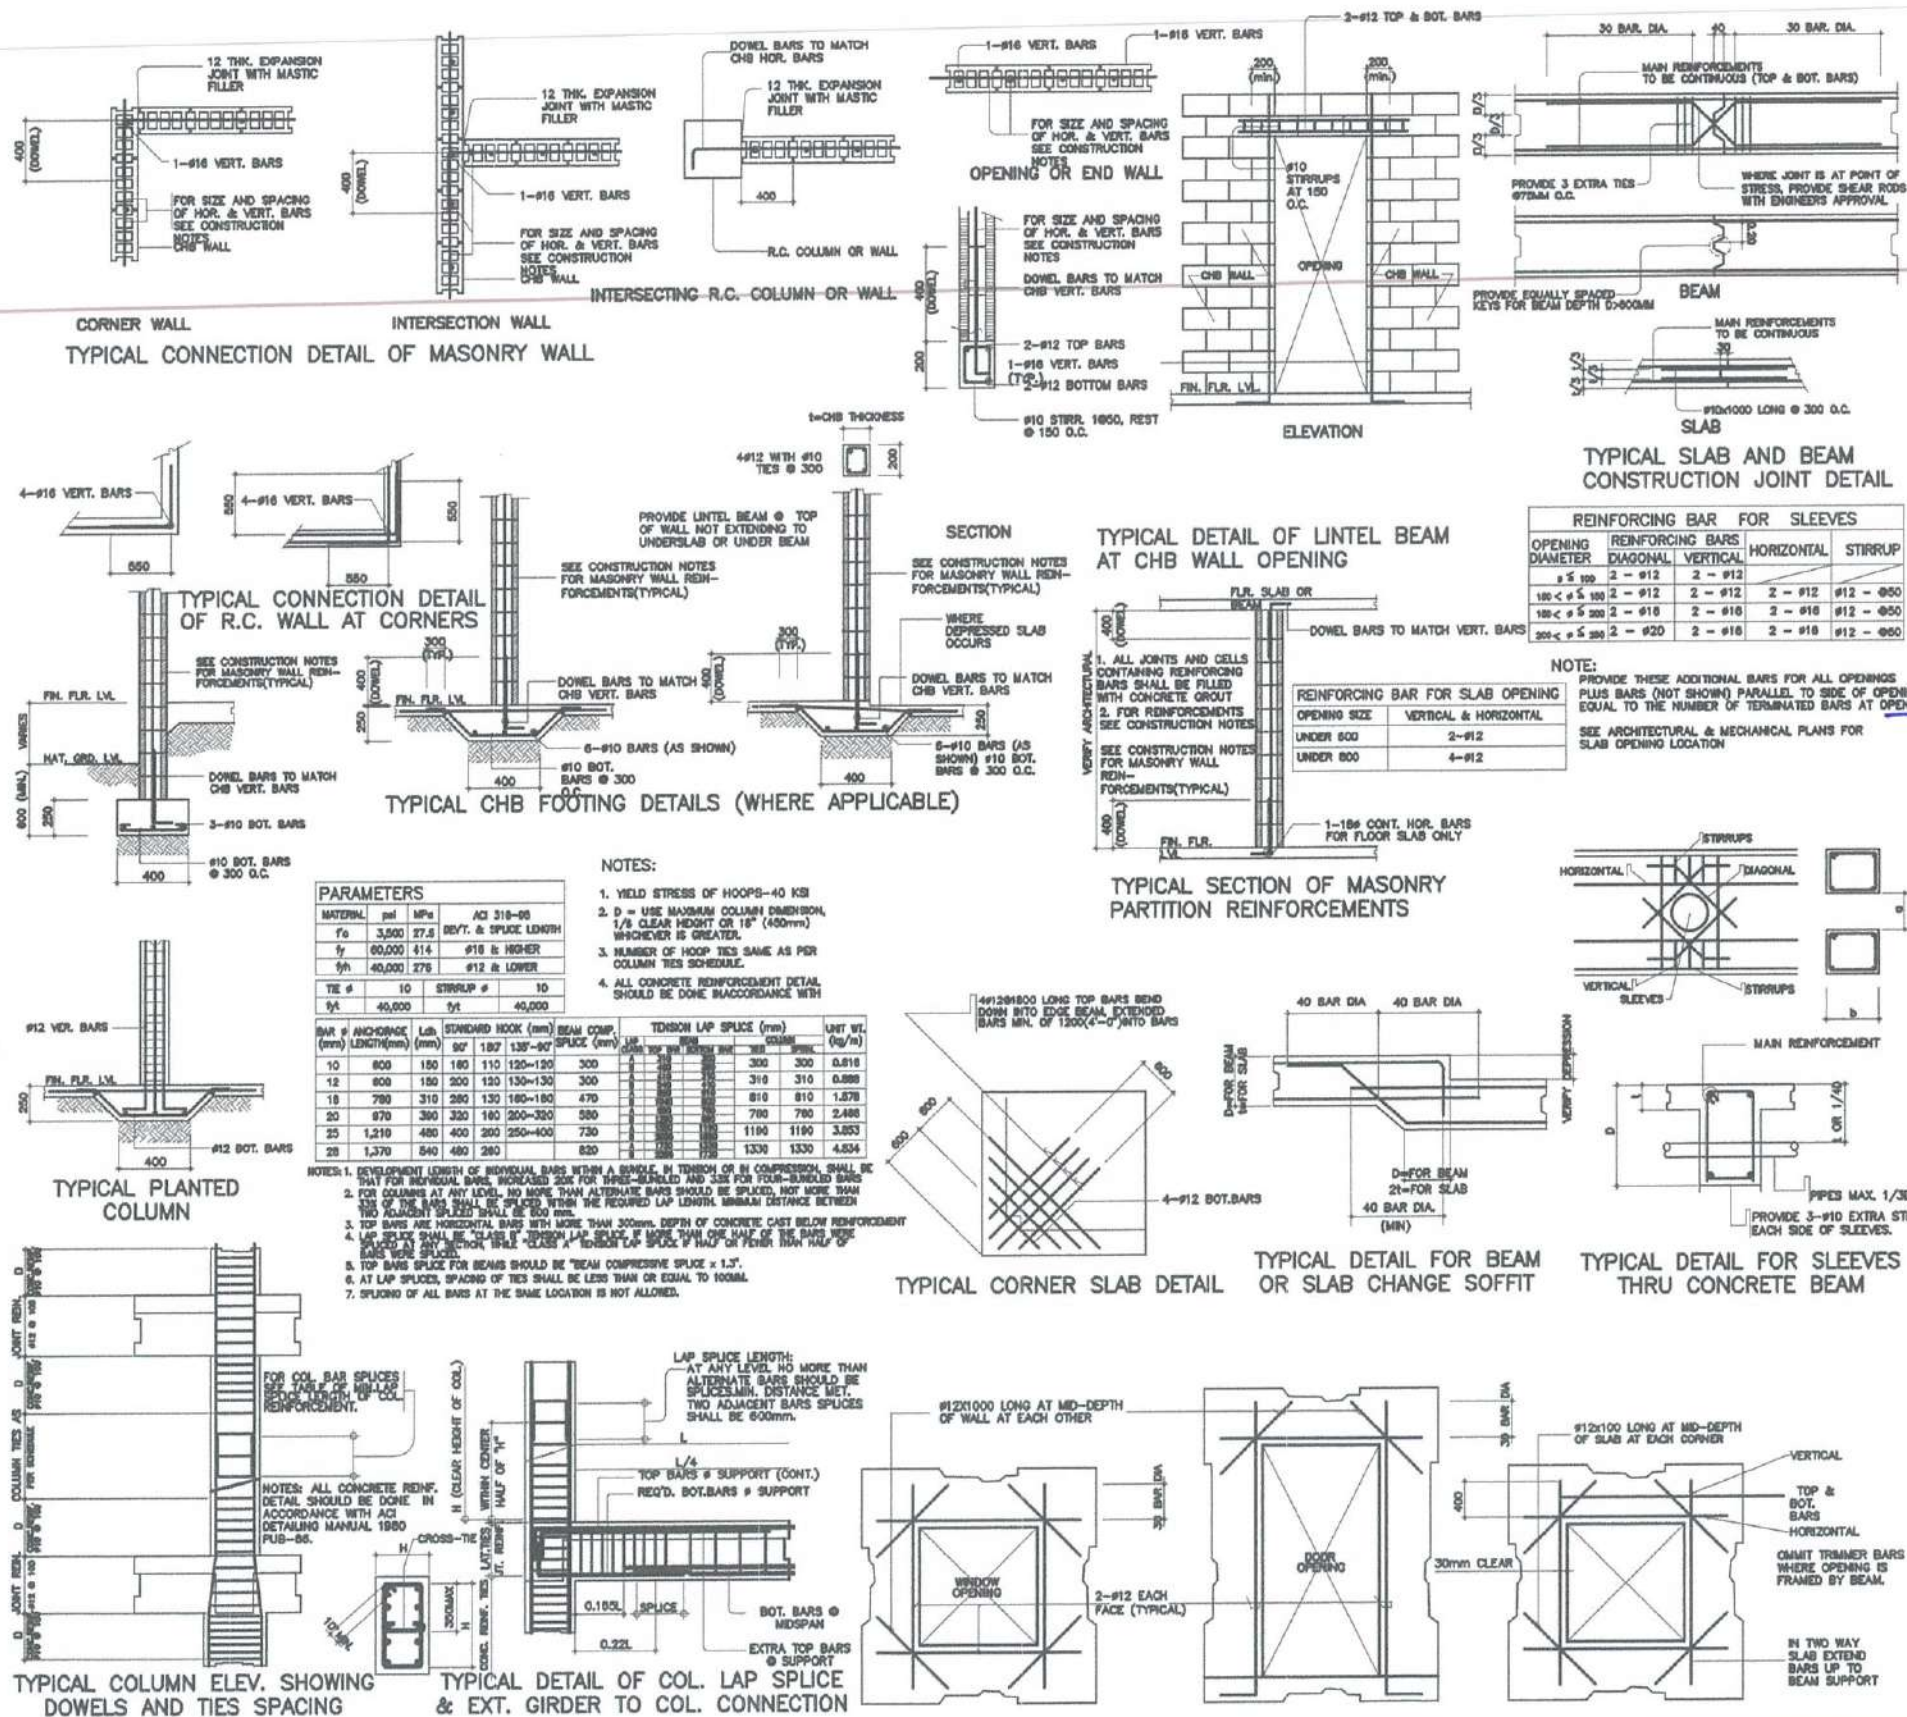



REPUBLIC OF THE PHILIPPINES
CIVIL AVIATION AUTHORITY OF THE PHILIPPINES
AERODROME DEVELOPMENT AND MANAGEMENT SERVICE
NAIA ROAD, 1900 PASAY CITY

THIS DRAWINGS AND DESIGN IS EXCLUSIVE
PROPERTY OF CIVIL AVIATION AUTHORITY
OF THE PHILIPPINES AND SUCH MUST NOT BE
REPRODUCED, EXHIBITED, LOANED NOR
COPIED IN PART OR IN WHOLE WITHOUT
PROPER PERMISSION AND/OR WRITTEN
CONSENT FROM THE DIRECTOR GENERAL
CAAP.

AERODROME DEVELOPMENT
AND MANAGEMENT SERVICE

INFRASTRUCTURE DEVELOPMENT AND DESIGN
DIVISION

DESIGN STAFF: INITIAL / DATE

DESIGNED BY: 1000

DRAWN BY: KAG

CHECKED BY:

REVIEWED BY:

RAUL R. CRUZENA
Division Chief II, IDDD-AED

SUBMITTED BY:

ARNEL F. BORLADO
Department Manager II, AED-ADMS

RECOMMENDED APPROVAL:

LT COL. VALENTINO A. DICONELA PAF (RET)
Assistant Director General II, ADMS

APPROVED BY:

CAPTAIN MANUEL ANTONIO L. TAMAYO
Director General

NOTES/REVISIONS:

PROJECT:

IMPROVEMENT/REHABILITATION
OF AIRWAYS FACILITY COMPLEX
BUILDING

LOCATION:


CAAP CENTRAL OFFICE
NAIA RD. COR. N. AQUINO AVENUE,
PASAY CITY

SHEET CONTENTS:


FOUNDATION PLAN

DRAWING SCALE: SHEET NO:


AS SHOWN 02 08

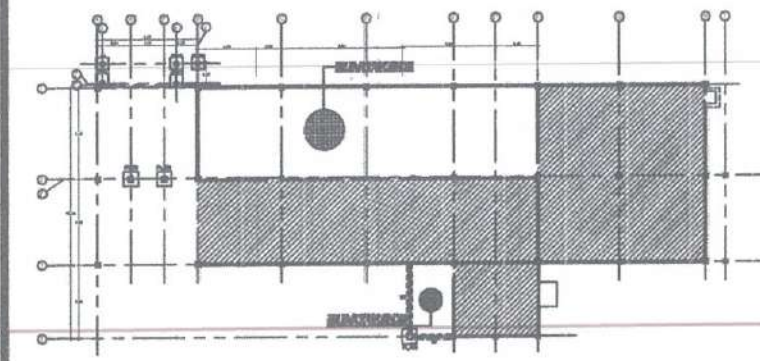


KEY PLAN

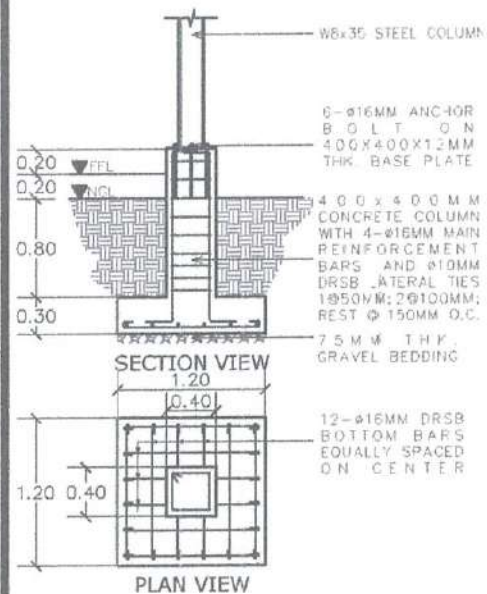


P1/C1

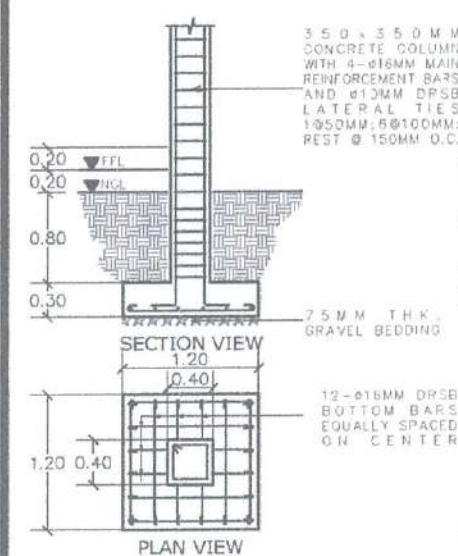


F1/C2

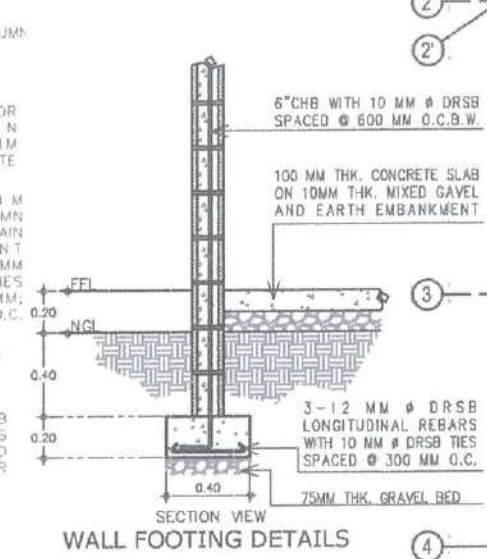


SP1/SC1

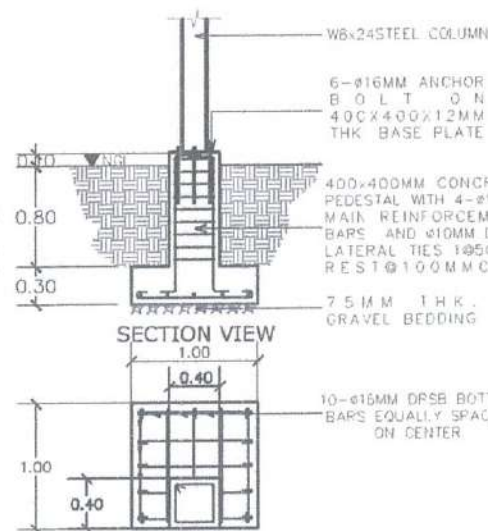


SP2/SC1

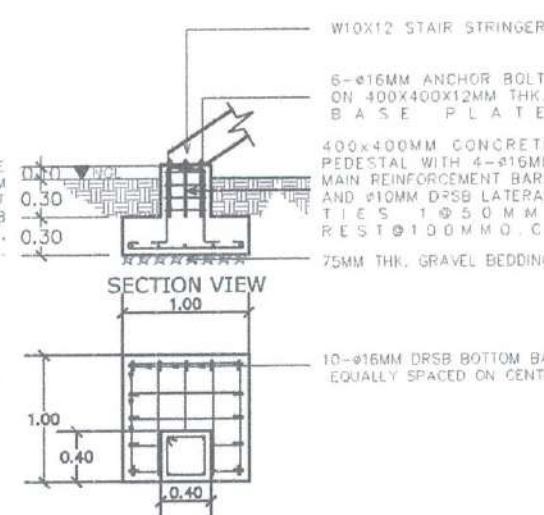

SP3


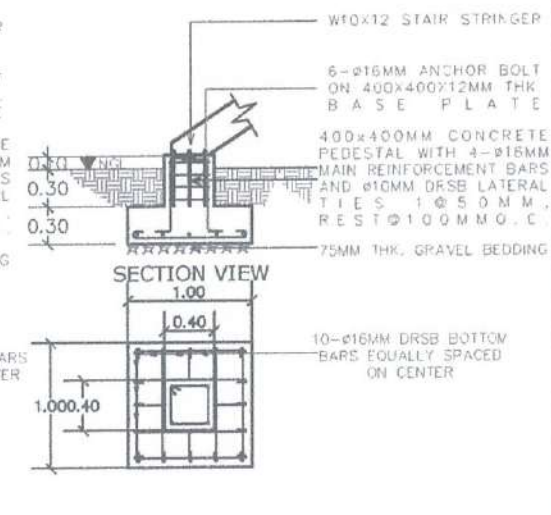


SP4

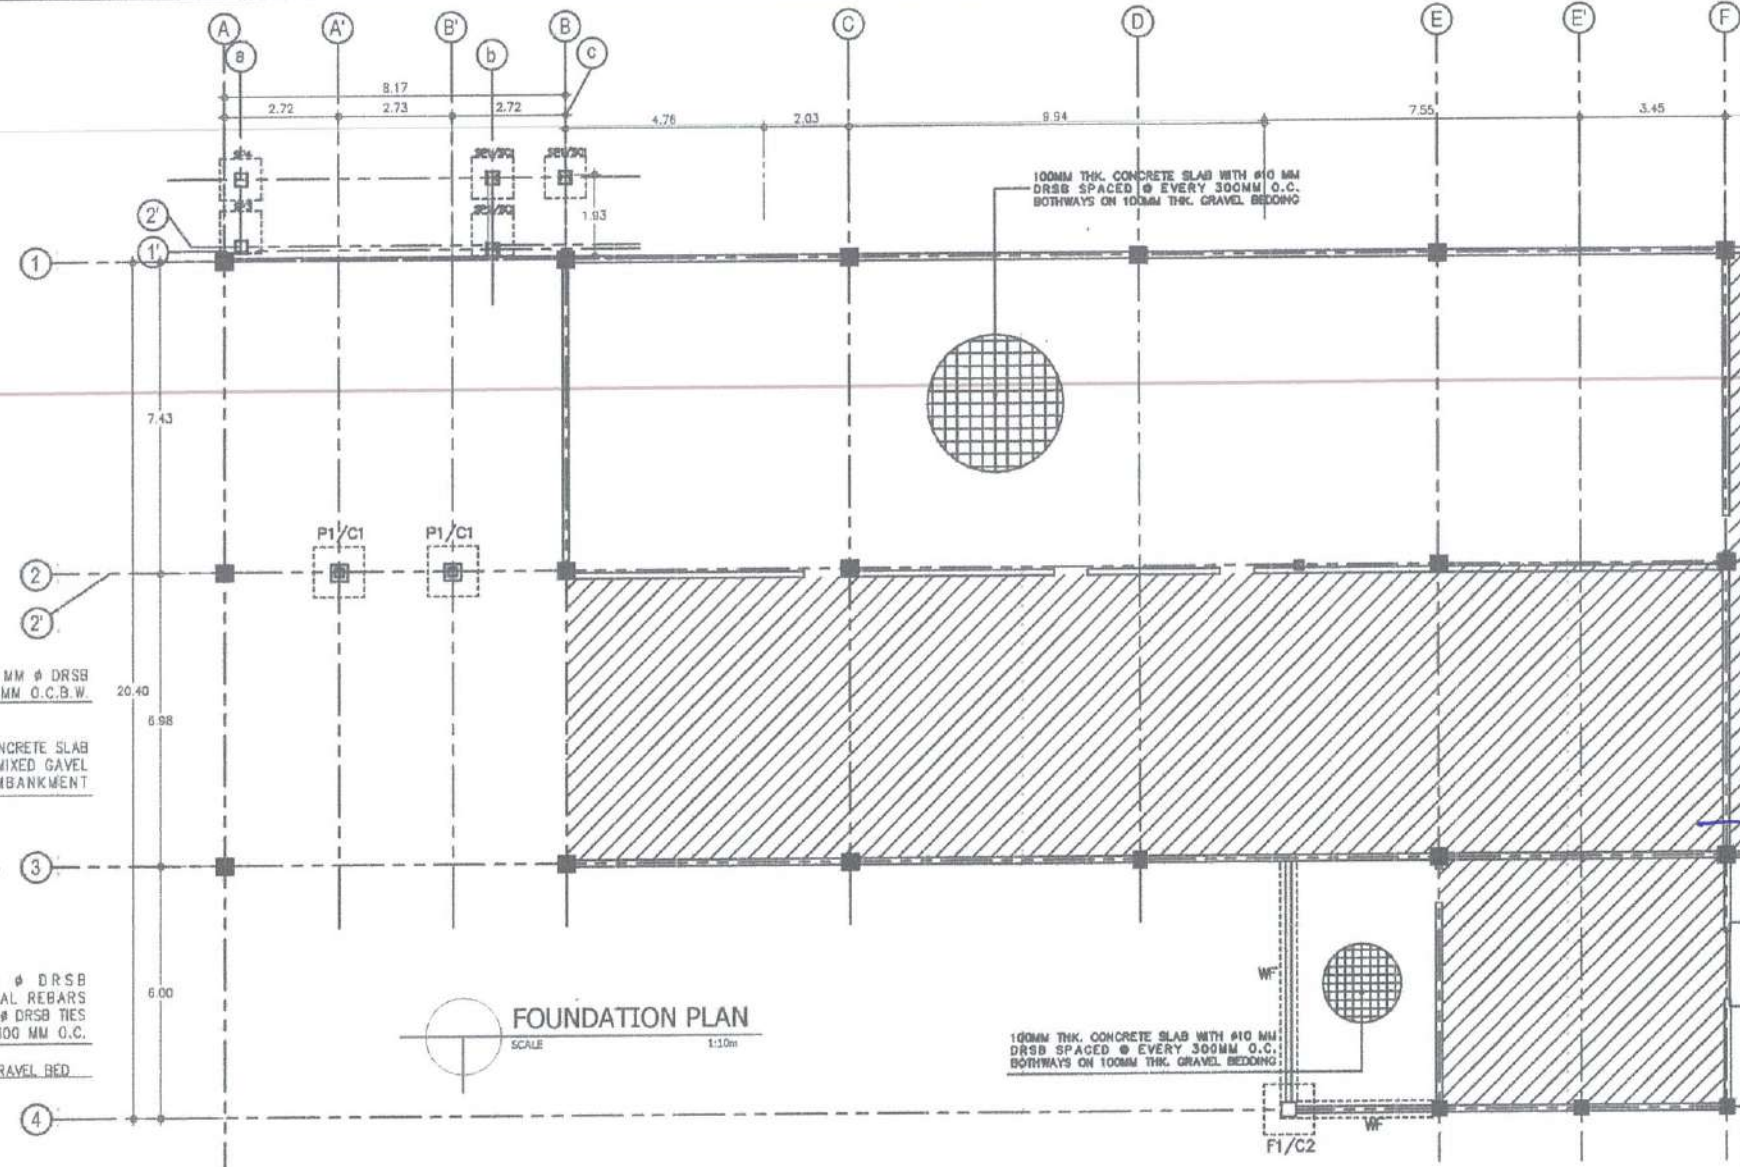

FOUNDATION PLAN

SCALE 1:10m

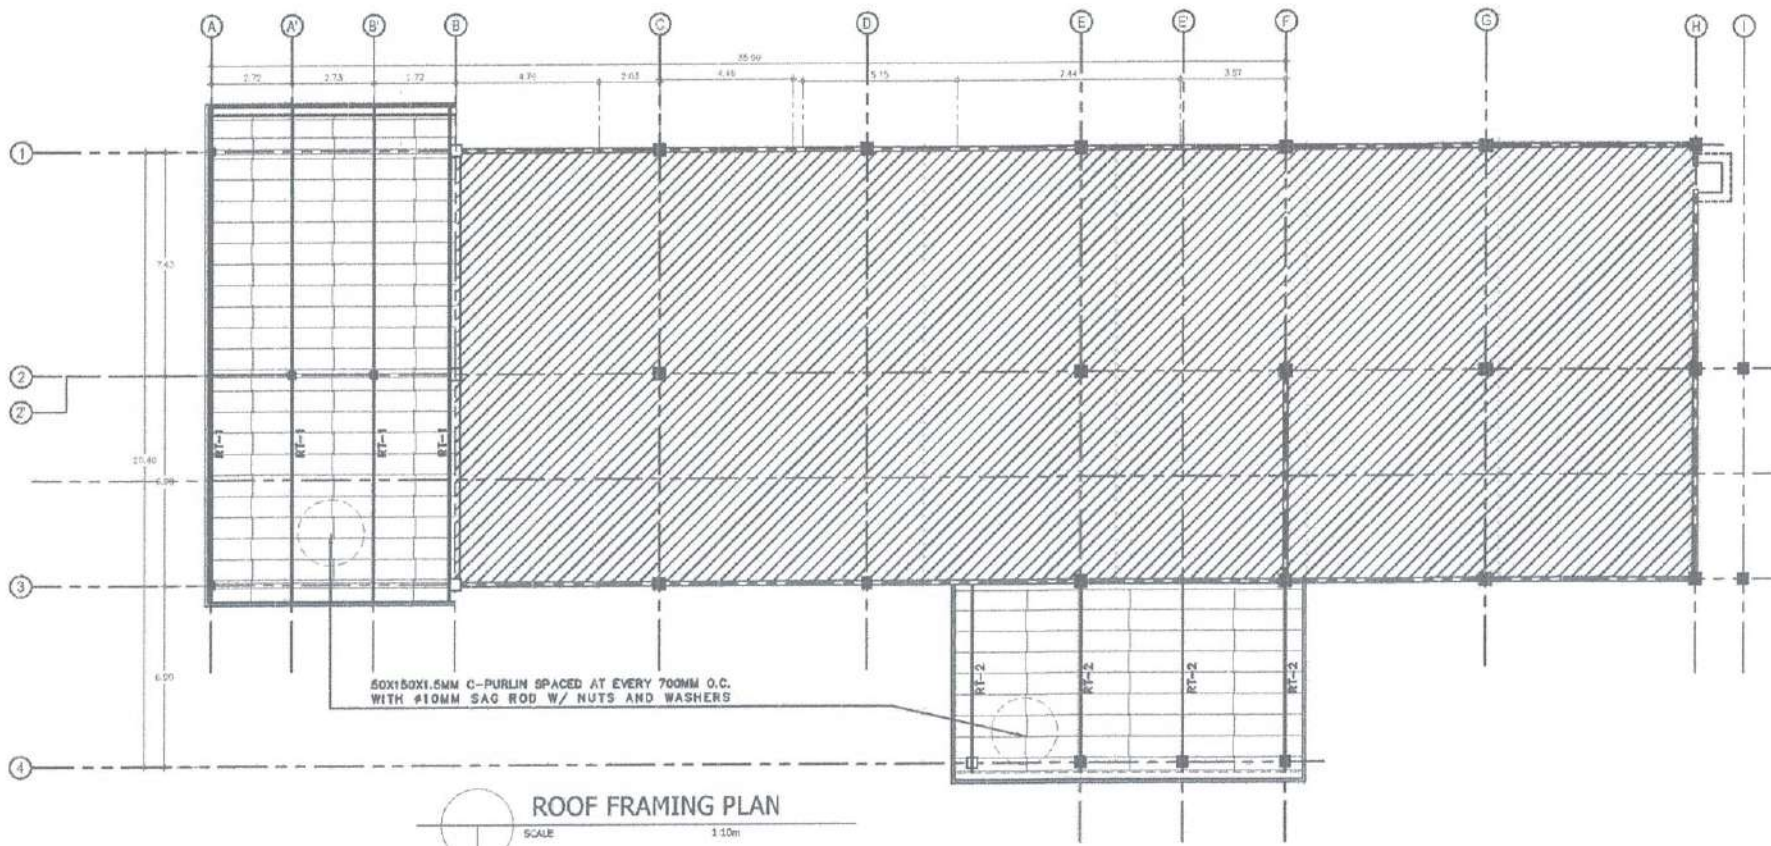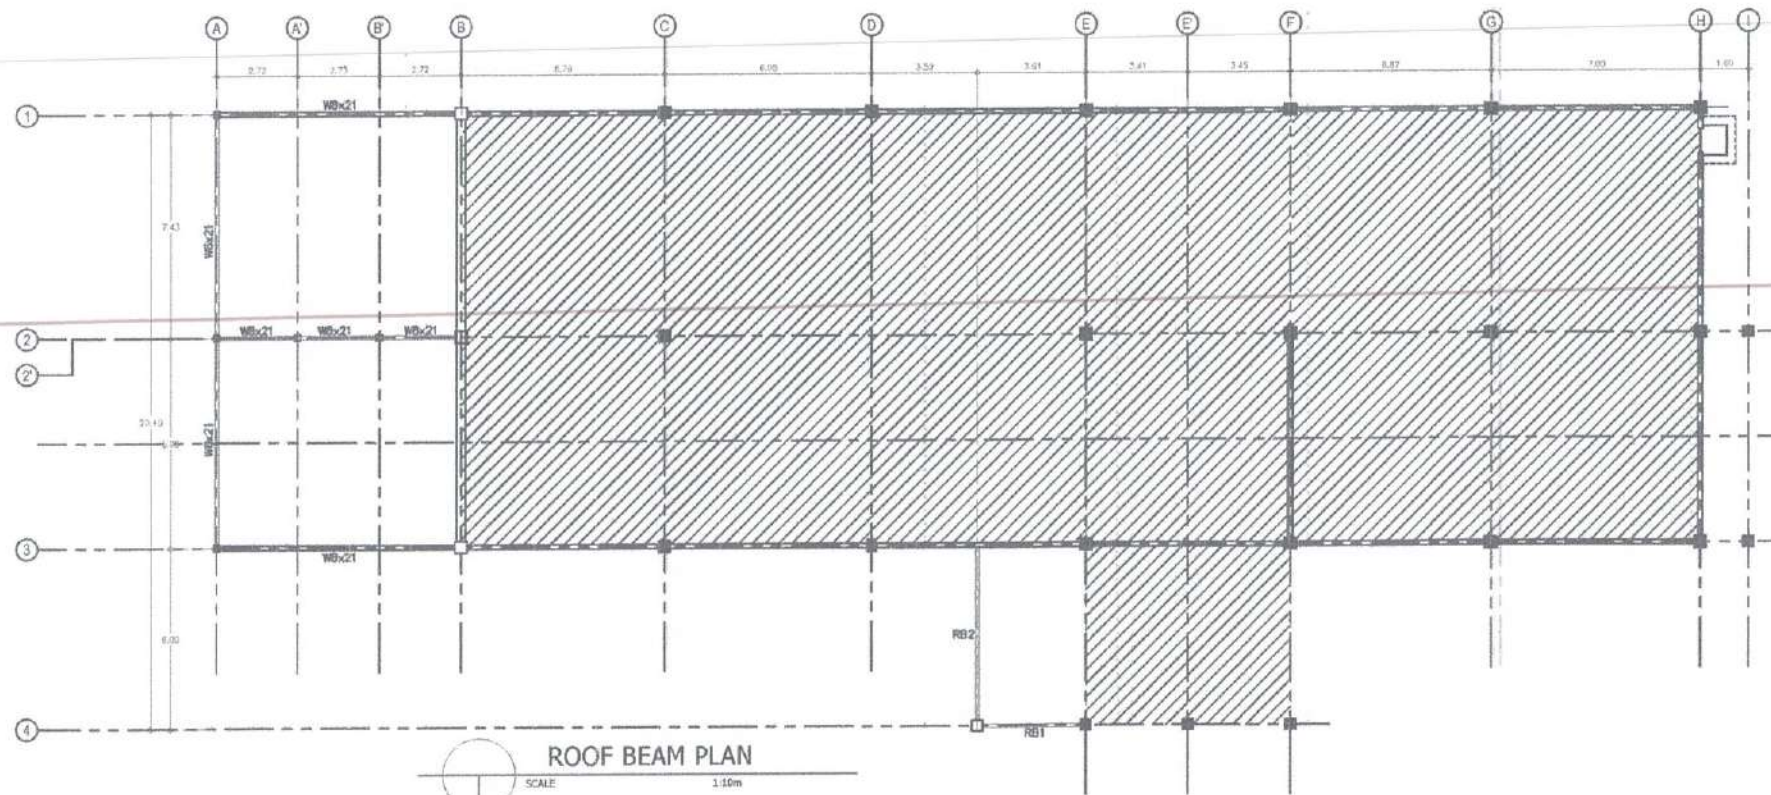

REPUBLIC OF THE PHILIPPINES
CIVIL AVIATION AUTHORITY OF THE PHILIPPINES
AERODROME DEVELOPMENT AND MANAGEMENT SERVICE
NAIA ROAD, PASAY CITY

THIS DRAWINGS AND DESIGN IS EXCLUSIVE PROPERTY OF CIVIL AVIATION AUTHORITY OF THE PHILIPPINES AND SUCH MUST NOT BE REPRODUCED, EXHIBITED, LOANED NOR COPIED IN PART OR IN WHOLE WITHOUT PROPER PERMISSION AND/OR WRITTEN CONSENT FROM THE DIRECTOR GENERAL CAAP.

AERODROME DEVELOPMENT AND MANAGEMENT SERVICE

INFRASTRUCTURE DEVELOPMENT AND DESIGN DIVISION

DESIGN STAFF	INITIAL / DATE
DESIGNED BY: IDDD	
DRAWN BY: KAG	
CHECKED BY:	

REVIEWED BY:

RAUL R. CRUCENA
Division Chief II, IDDD-AED

SUBMITTED BY:

ARNEL F. BORLADO
Department Manager II, AED-ADMS

RECOMMEND APPROVAL:

LT COL-VALENTINO A. DIONELA PAF (RET)
Assistant Director General II, ADMS

APPROVED BY:

CAPTAIN MANUEL ANTONIO L. TAMAYO
Director General

NOTES/REVISIONS:

PROJECT:









IMPROVEMENT/REHABILITATION OF AIRWAYS FACILITY COMPLEX BUILDING

LOCATION:

CAAP CENTRAL OFFICE
NAIA RD. COR N. AQUINO AVENUE,
PASAY CITY

SHEET CONTENTS:

DRAWING SCALE	SHEET NO.
1:10	5-3
	03 06

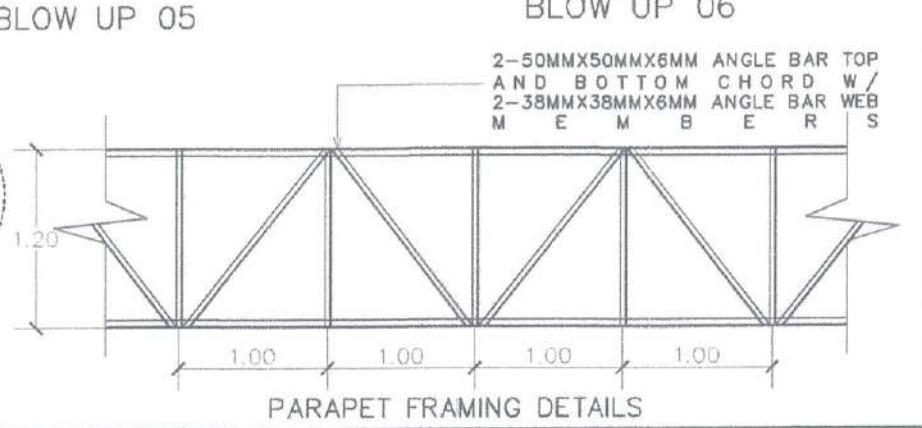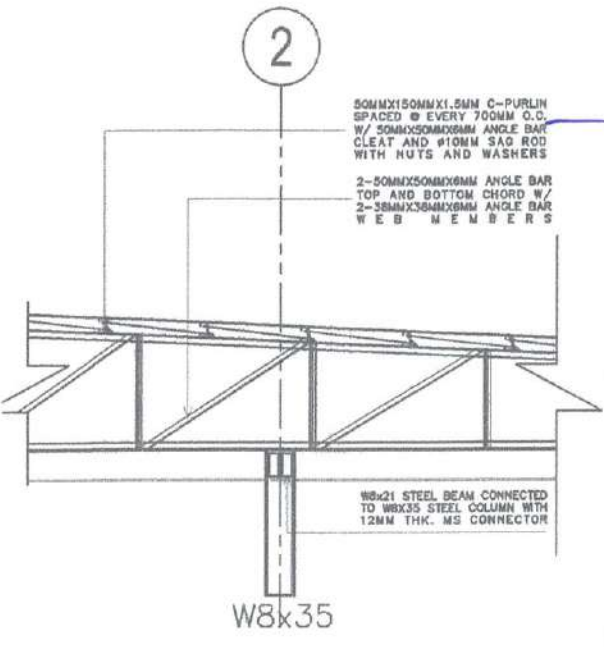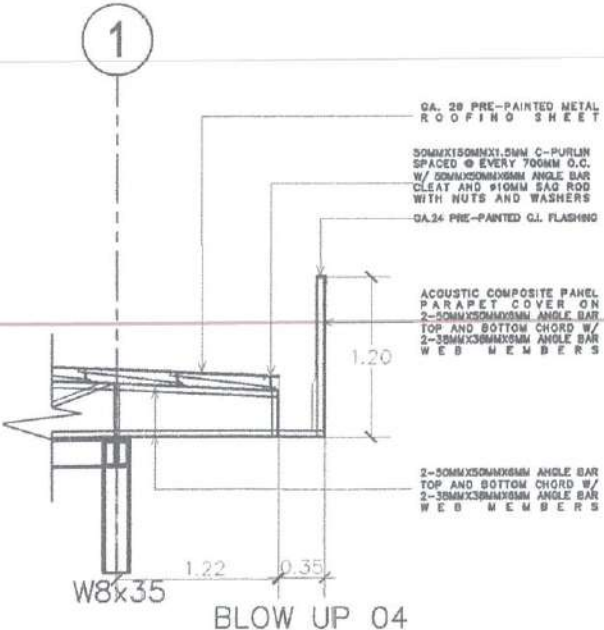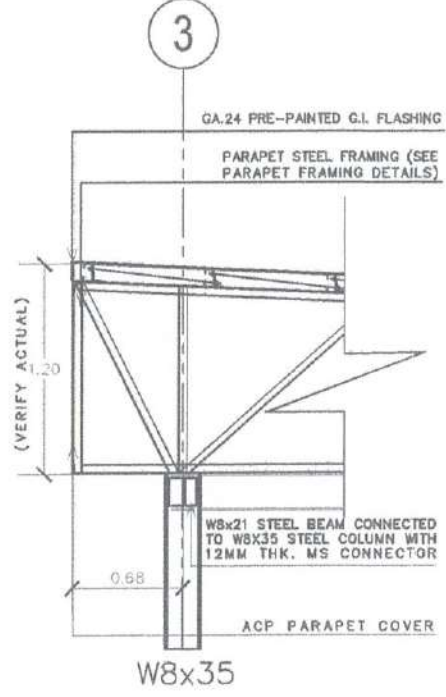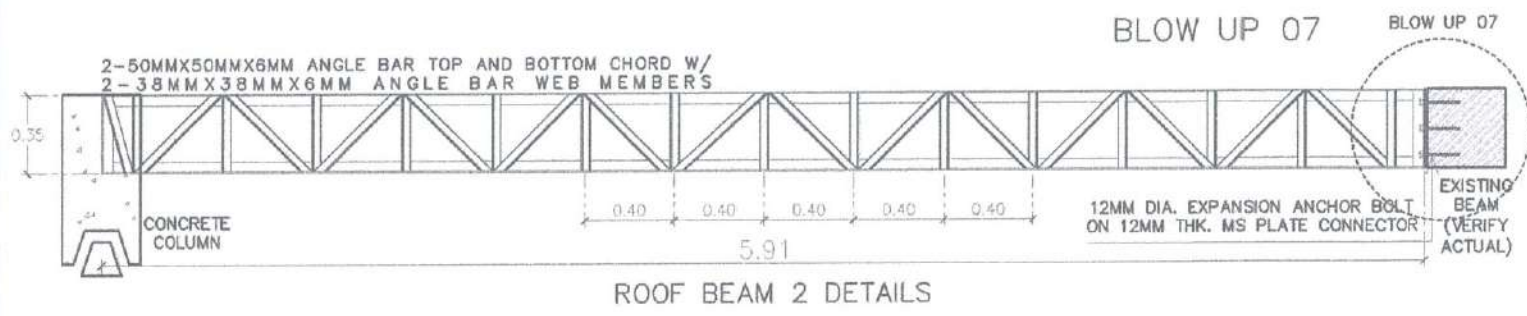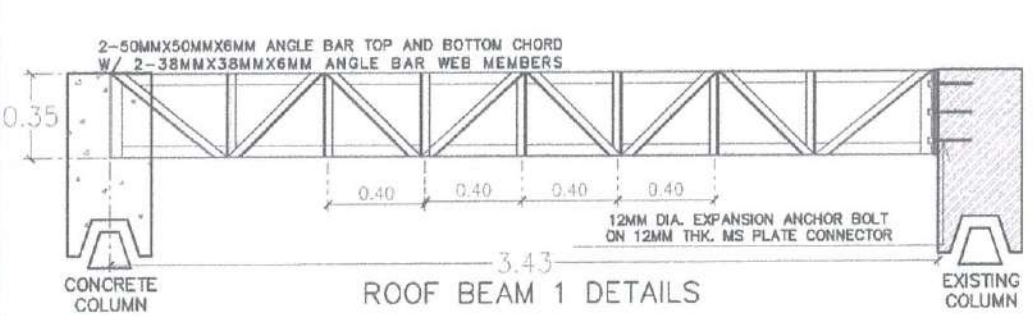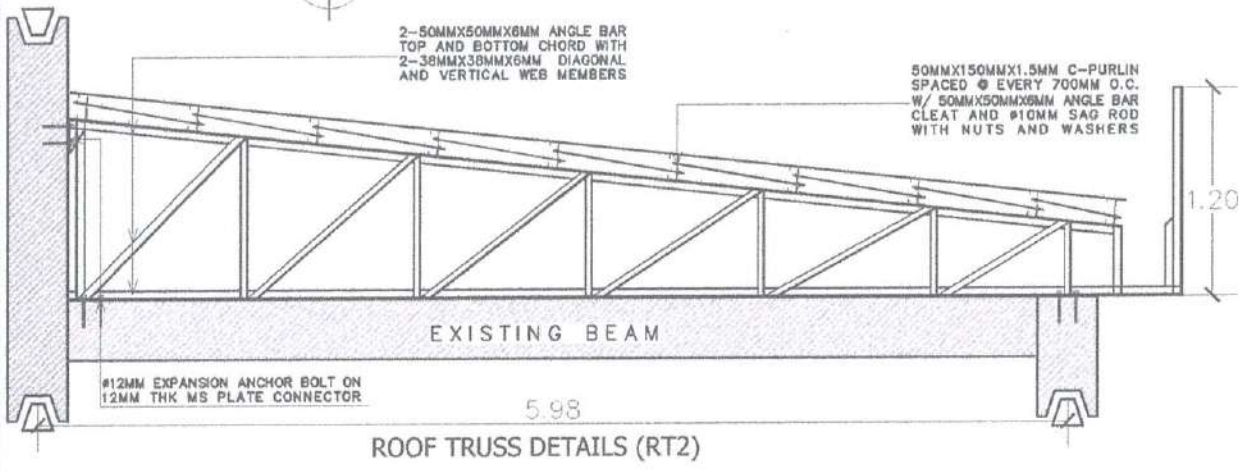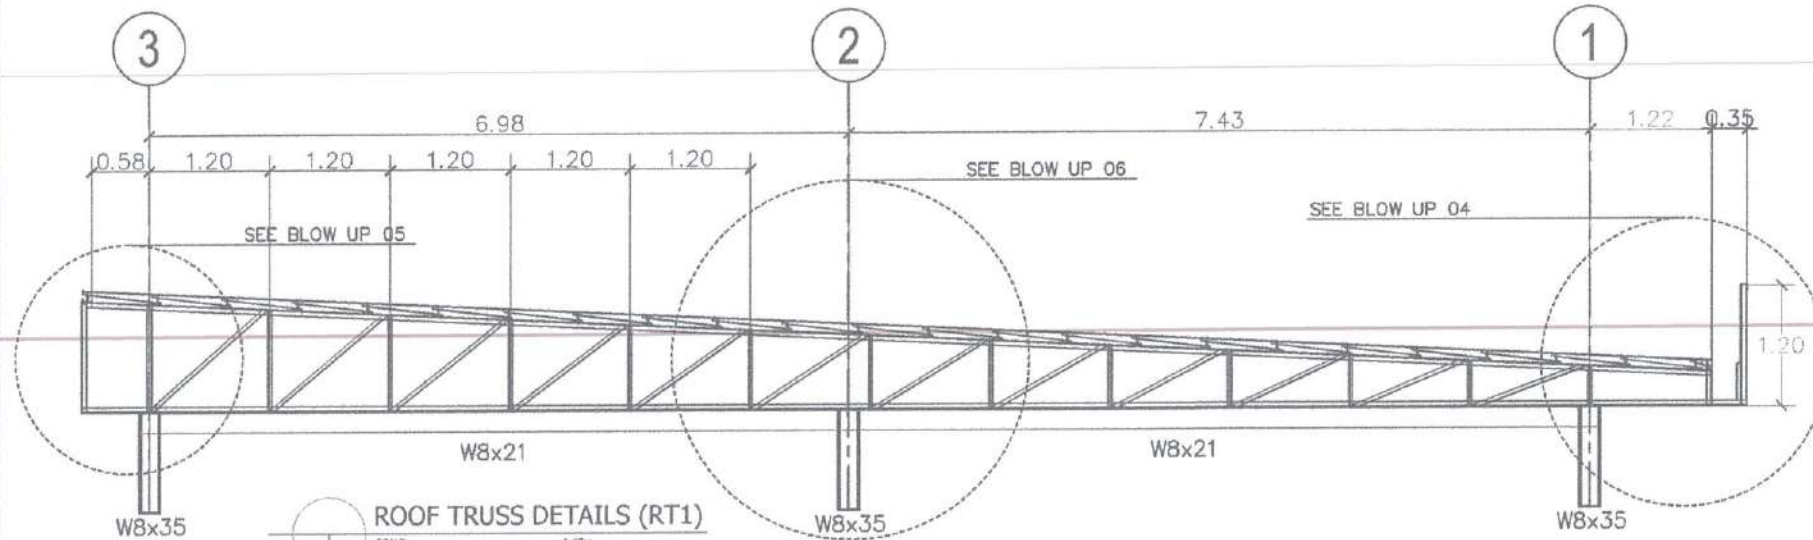

REPUBLIC OF THE PHILIPPINES
CIVIL AVIATION AUTHORITY OF THE PHILIPPINES
AERODROME DEVELOPMENT AND MANAGEMENT SERVICE
1000 PASAY CITY

THIS DRAWING AND DESIGN IS EXCLUSIVE PROPERTY OF CIVIL AVIATION AUTHORITY OF THE PHILIPPINES AND SUCH MUST NOT BE REPRODUCED, EXHIBITED, LOANED NOR COPIED IN PART OR IN WHOLE WITHOUT PROPER PERMISSION AND/OR WRITTEN CONSENT FROM THE DIRECTOR GENERAL CAAP.

AERODROME DEVELOPMENT AND MANAGEMENT SERVICE
INFRASTRUCTURE DEVELOPMENT AND DESIGN DIVISION

DESIGN STAFF: INITIAL / DATE

DESIGNED BY: IDDD

DRAWN BY: KAG

CHECKED BY:

REVIEWED BY:

SUBMITTED BY:

RECOMMEND APPROVAL:

APPROVED BY:

NOTES/REVISIONS:

PROJECT: IMPROVEMENT/REHABILITATION OF AIRWAYS FACILITY COMPLEX BUILDING

LOCATION: CAAP CENTRAL OFFICE NAIA RD. COR. N. AQUINO AVENUE, PASAY CITY

SHEET CONTENTS:

TRUSS DETAILS

DRAWING SCALE: AS SHOWN

SHEET NO: 3-4

04 05

RAUL R. CRUCENA
Division Chief, IDDD-AED

ARNE F. BORLADO
Department Manager III, AED-ADMS

COL. VICENTINO A. DIONELA PAF (RET)
Assistant Director General II, ADMS

CAPTAIN MANUEL ANTONIO L. TAMAYO
Director General



REPUBLIC OF THE PHILIPPINES
CIVIL AVIATION AUTHORITY OF THE PHILIPPINES
AERODROME DEVELOPMENT AND MANAGEMENT SERVICE
NAIA ROAD, PASAY CITY

THIS DRAWING AND DESIGN IS EXCLUSIVE
PROPERTY OF CIVIL AVIATION AUTHORITY
OF THE PHILIPPINES AND SUCH MUST NOT BE
REPRODUCED, EXHIBITED, LOANED NOR
COPIED IN PART OR IN WHOLE WITHOUT
PROPER PERMISSION AND/OR WRITTEN
CONSENT FROM THE DIRECTOR GENERAL
CAAP

AERODROME DEVELOPMENT
AND MANAGEMENT SERVICE

INFRASTRUCTURE DEVELOPMENT AND DESIGN
DIVISION

DESIGN STAFF	INITIAL / DATE
DESIGNED BY	ICDD
DRAWN BY	KAS
CHECKED BY	

REVIEWED BY

RAUL R. CRUCENA
Division Office Head, ICDD-ADM

SUBMITTED BY

ARNEL F. BORLADO
Department Manager II, AED-ADM

RECOMMEND APPROVAL

LT COL VALERINO A. DIONELA PAF (RET)
Assistant Director General II, ADM

APPROVED BY

CAPTAIN MAURICE ANTONIO L. TANKYO
Director General

NOTES/REVISIONS

PROJECT

IMPROVEMENT/REHABILITATION
OF AIRWAYS FACILITY COMPLEX
BUILDING

LOCATION

CAAP CENTRAL OFFICE
NAIA RD. COR. N. AQUINO AVENUE,
PASAY CITY

SHEET CONTENTS

STAIR DETAILS

DRAWING SCALE


AS SHOWN


SHEET NO.

3/05





36

06

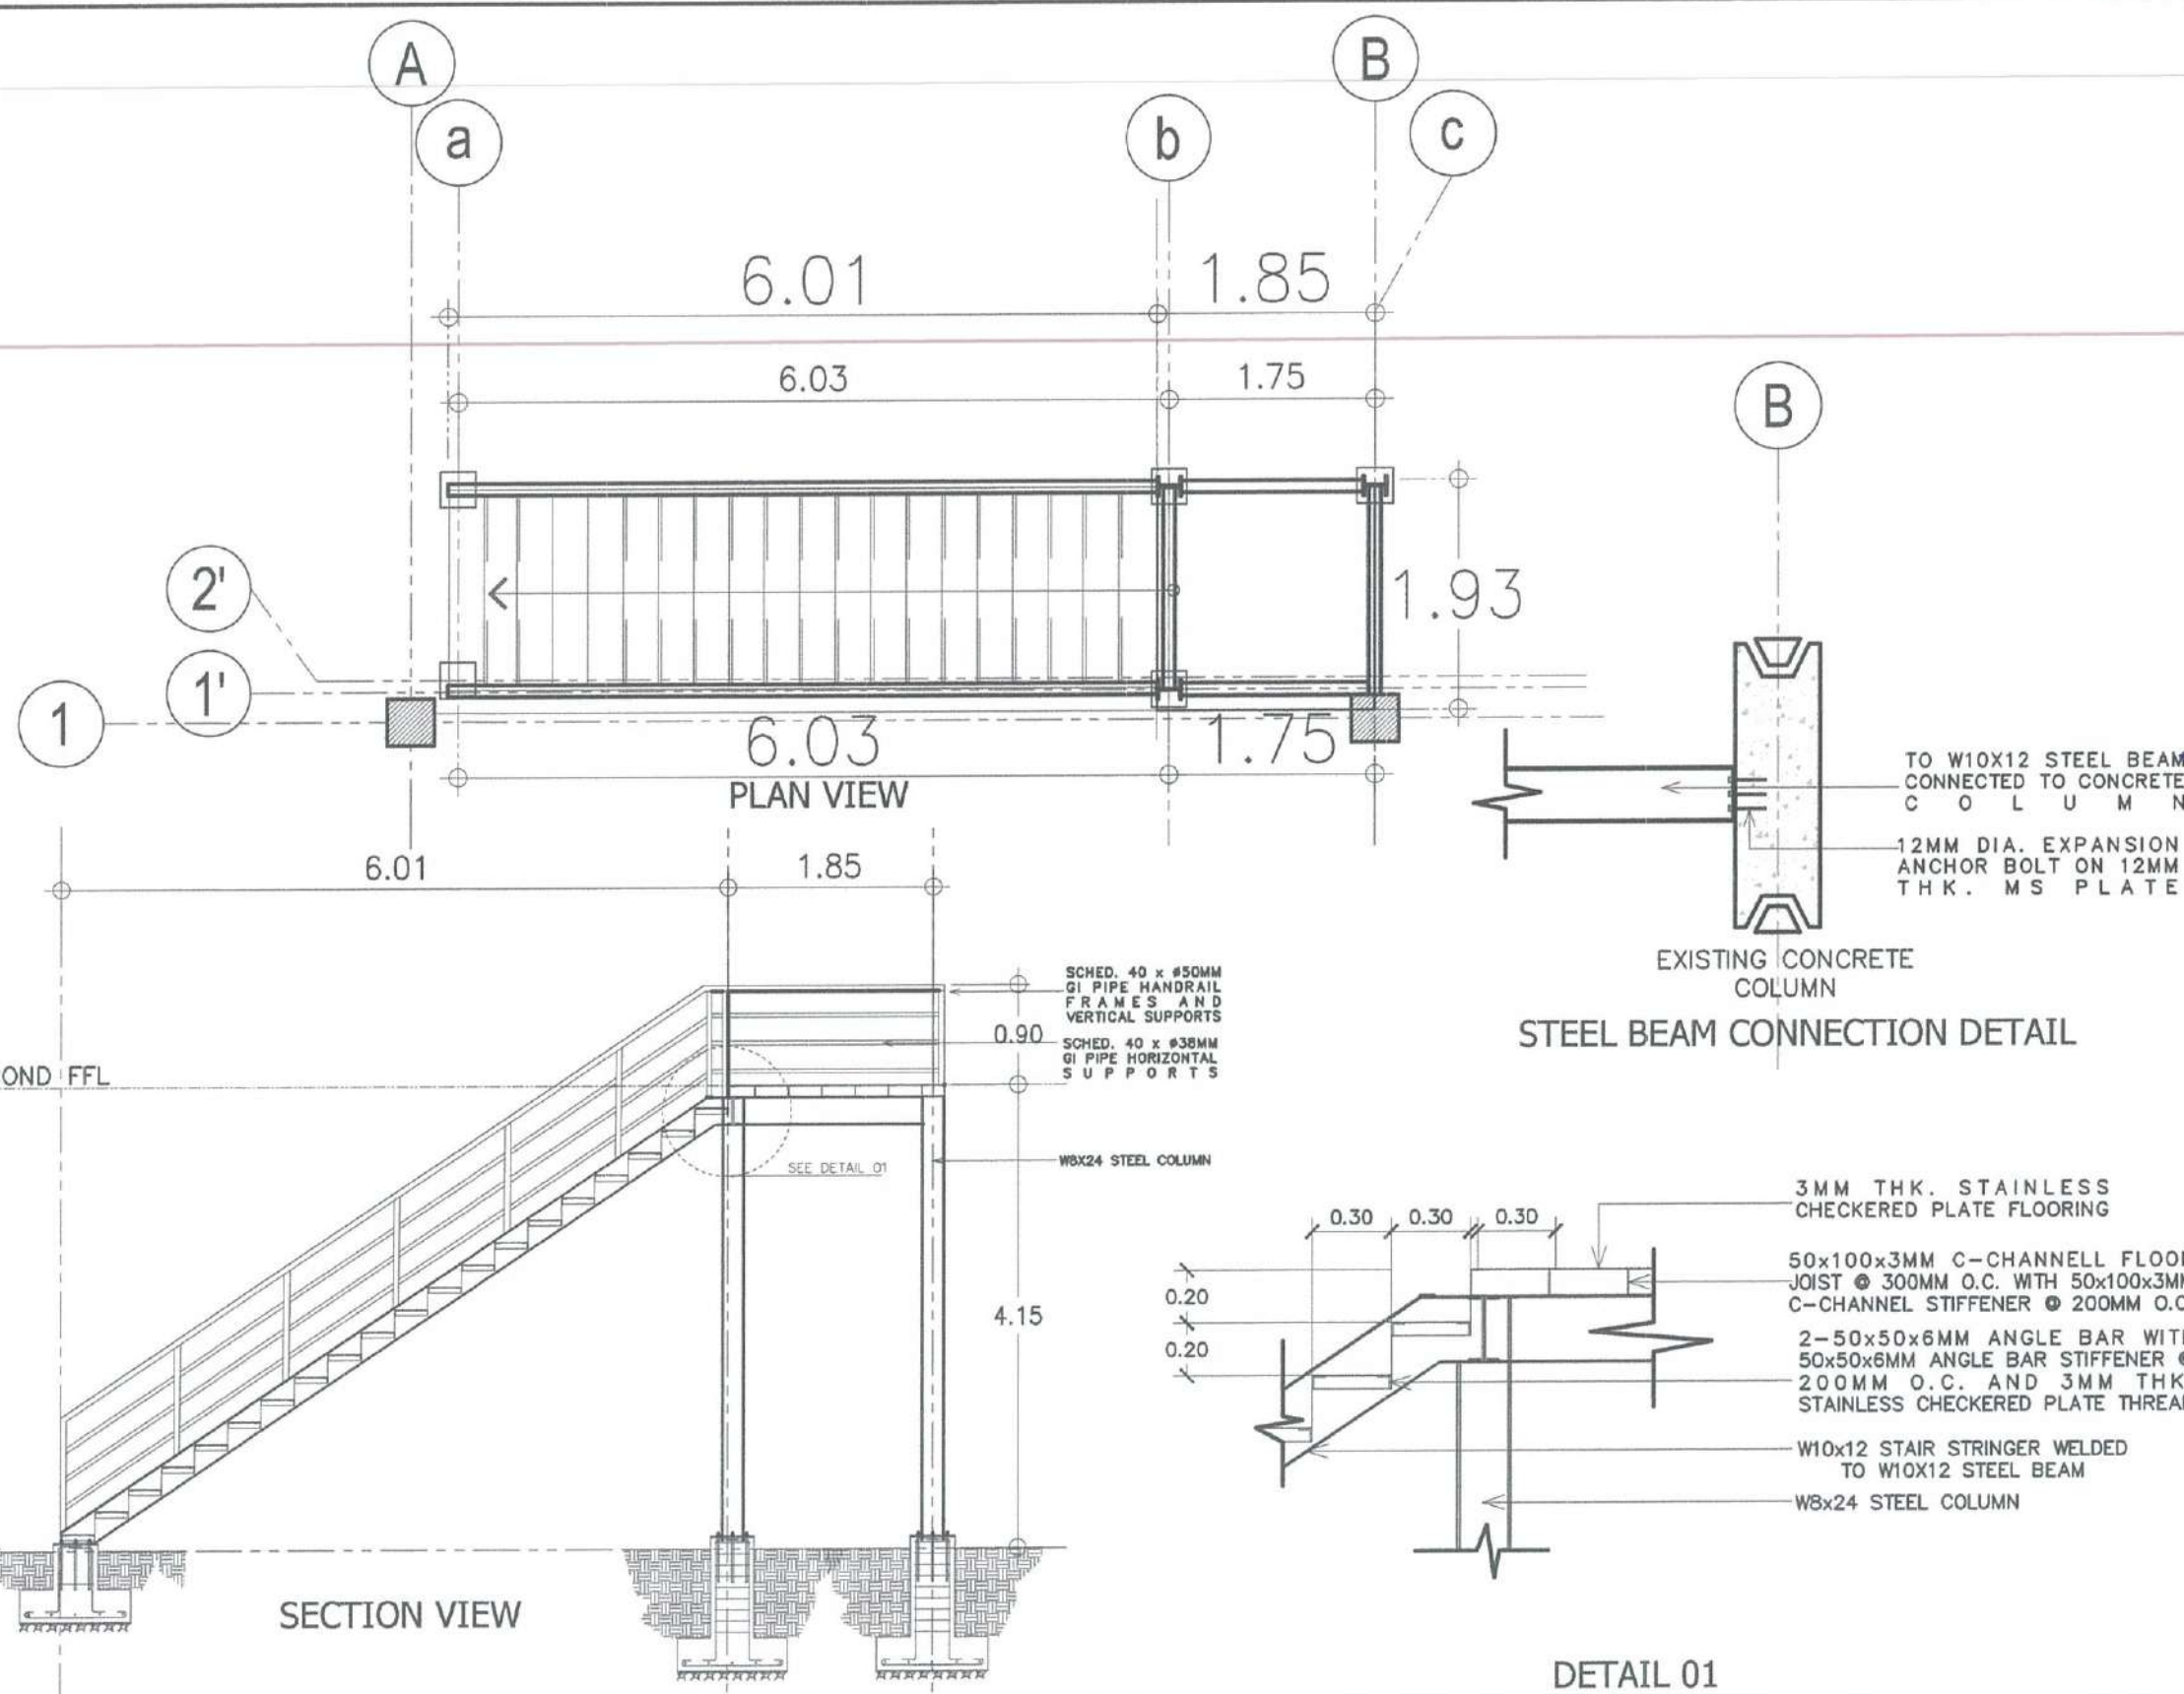

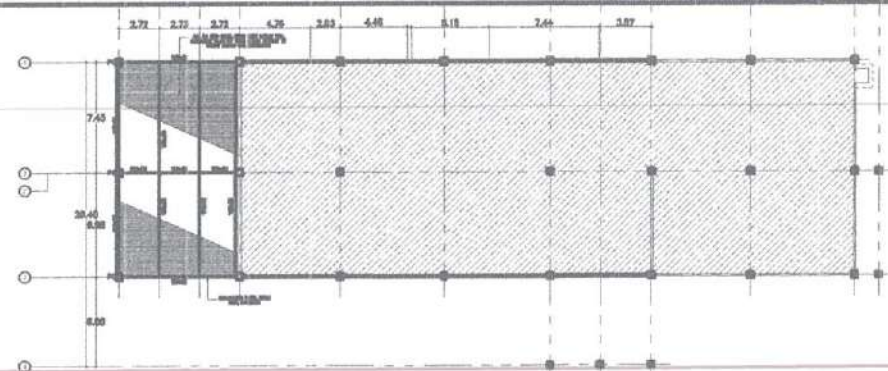

W8x35 STEEL COLUMN SPlicing
CONNECTION WITH 12MM THK. MS
C O N N E C T O R

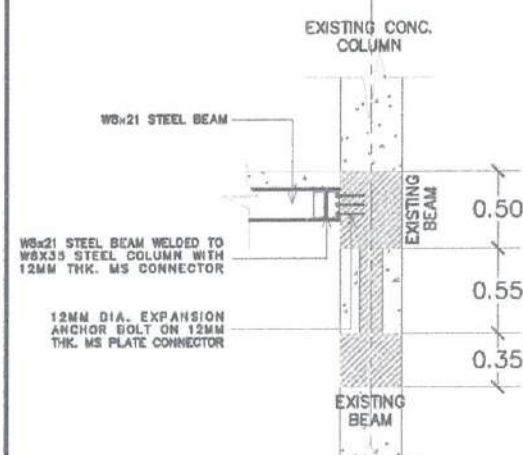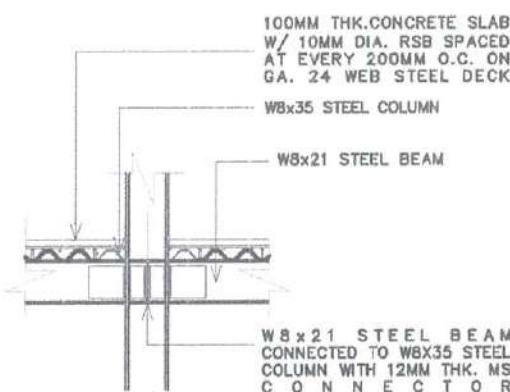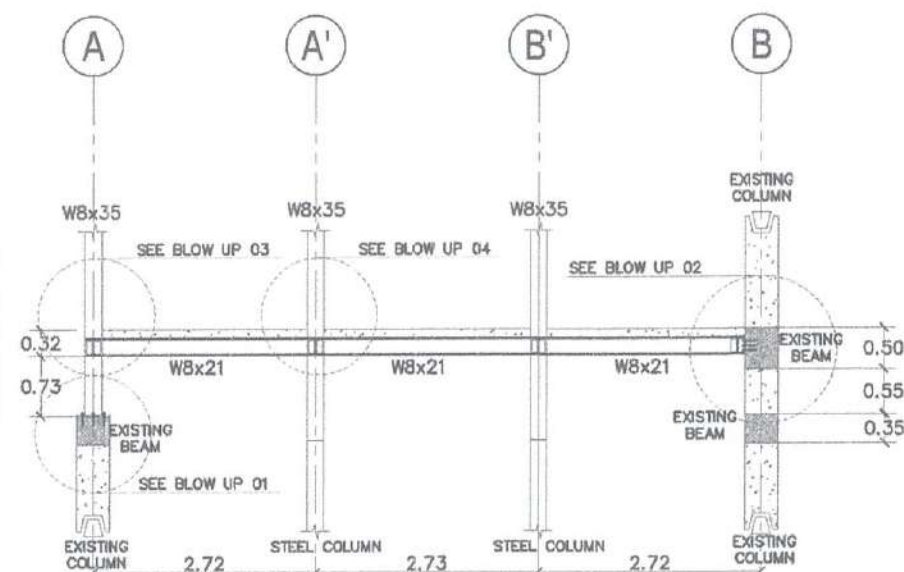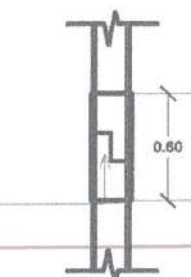

ACOUSTIC COMPOSITE PANEL
CLADDING WITH DRY WALL INTERIOR
WALL ON 50MMx50MMx5MM ANGLE
BAR FRAMING SPACED @ EVERY
600MM O.C. BOTHWAYS

W8x35 PLANTED STEEL COLUMN W/
12MM THK. MS PLATE STIFFENER
SPACED AT EVERY 1300MM O.C.

6" THK. CHS EXTERIOR WALL W/
10MM DIA. VERTICAL AND
HORIZONTAL BARS SPACED @ EVERY
600MM O.C. BOTHWAYS

100MM THK. CONCRETE SLAB
W/ 10MM DIA. RSB SPACED
AT EVERY 200MM O.C. ON
GA. 24 WEB STEEL DECK



1.0MM THK. STEEL EDGE TRIM, H=100MM

4" THK. CHS WALL COVER W/ 10MM
DIA. VERTICAL BARS SPACED AT
EVERY 600MM O.C. AND HORIZONTAL
BARS SPACED @ EVERY 500MM O.C.

12MM THK. MS PLATE CONNECTOR

W8x21 STEEL BEAM

6-#12MM EXPANSION ANCHOR
BOLT WITH NUTS AND WASHERS
ON 400mm x 400mm x 12MM
THK. BASE PLATE

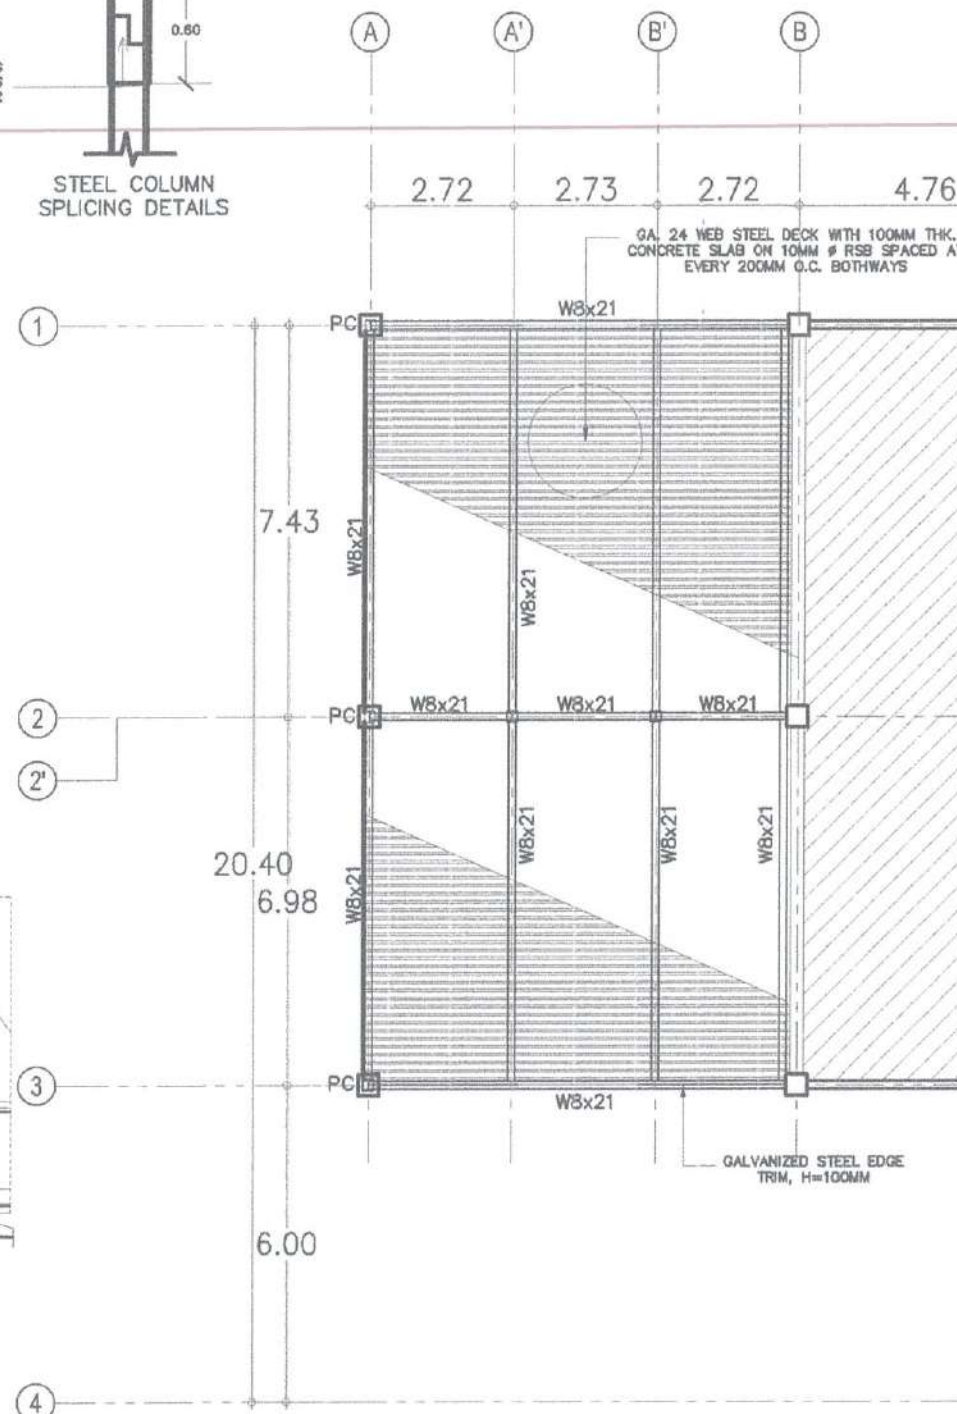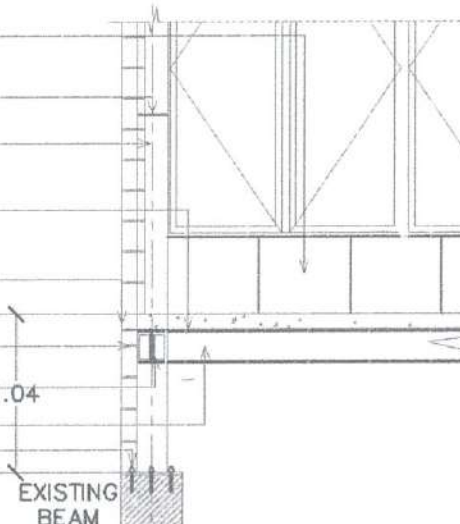

SCALE 1:20m



THIS DRAWING AND DESIGN IS EXCLUSIVE
PROPERTY OF CIVIL AVIATION AUTHORITY
OF THE PHILIPPINES AND SUCH MUST NOT BE
REPRODUCED, EXHIBITED, LOANED NOR
COPIED IN PART OR IN WHOLE WITHOUT
PROPER PERMISSION AND/OR WRITTEN
CONSENT FROM THE DIRECTOR GENERAL
CAAP.

AERODROME DEVELOPMENT
AND MANAGEMENT SERVICE

INFRASTRUCTURE DEVELOPMENT AND DESIGN
DIVISION

DESIGN STAFF: INITIAL / DATE

DESIGNED BY: RDO

DRAWN BY: KAG

CHECKED BY:

REVIEWED BY:

RAUL R. CRUCENA
Division Chief, I/OO-AED

SUBMITTED BY:

ARNEL F. BORLADO
Department Manager, I/OO-ADM

RECOMMEND APPROVAL:

LT COL. VENTURINO A. DIONEL A. FAF (RET)
Assistant Director General, I/OO-ADM

APPROVED BY:

CAPTAIN MANUEL ANTONIO L. TAMAYO
Director General

NOTES/REVISIONS:

PROJECT:
IMPROVEMENT/REHABILITATION
OF AIRWAYS FACILITY COMPLEX
BUILDING


LOCATION:

CAAP CENTRAL OFFICE
NAIA RD. COR. N. AQUINO AVENUE,
PASAY CITY

SHEET CONTENTS:

DRAWING SCALE: SHEET NO:

AS SHOWN 05 06 07

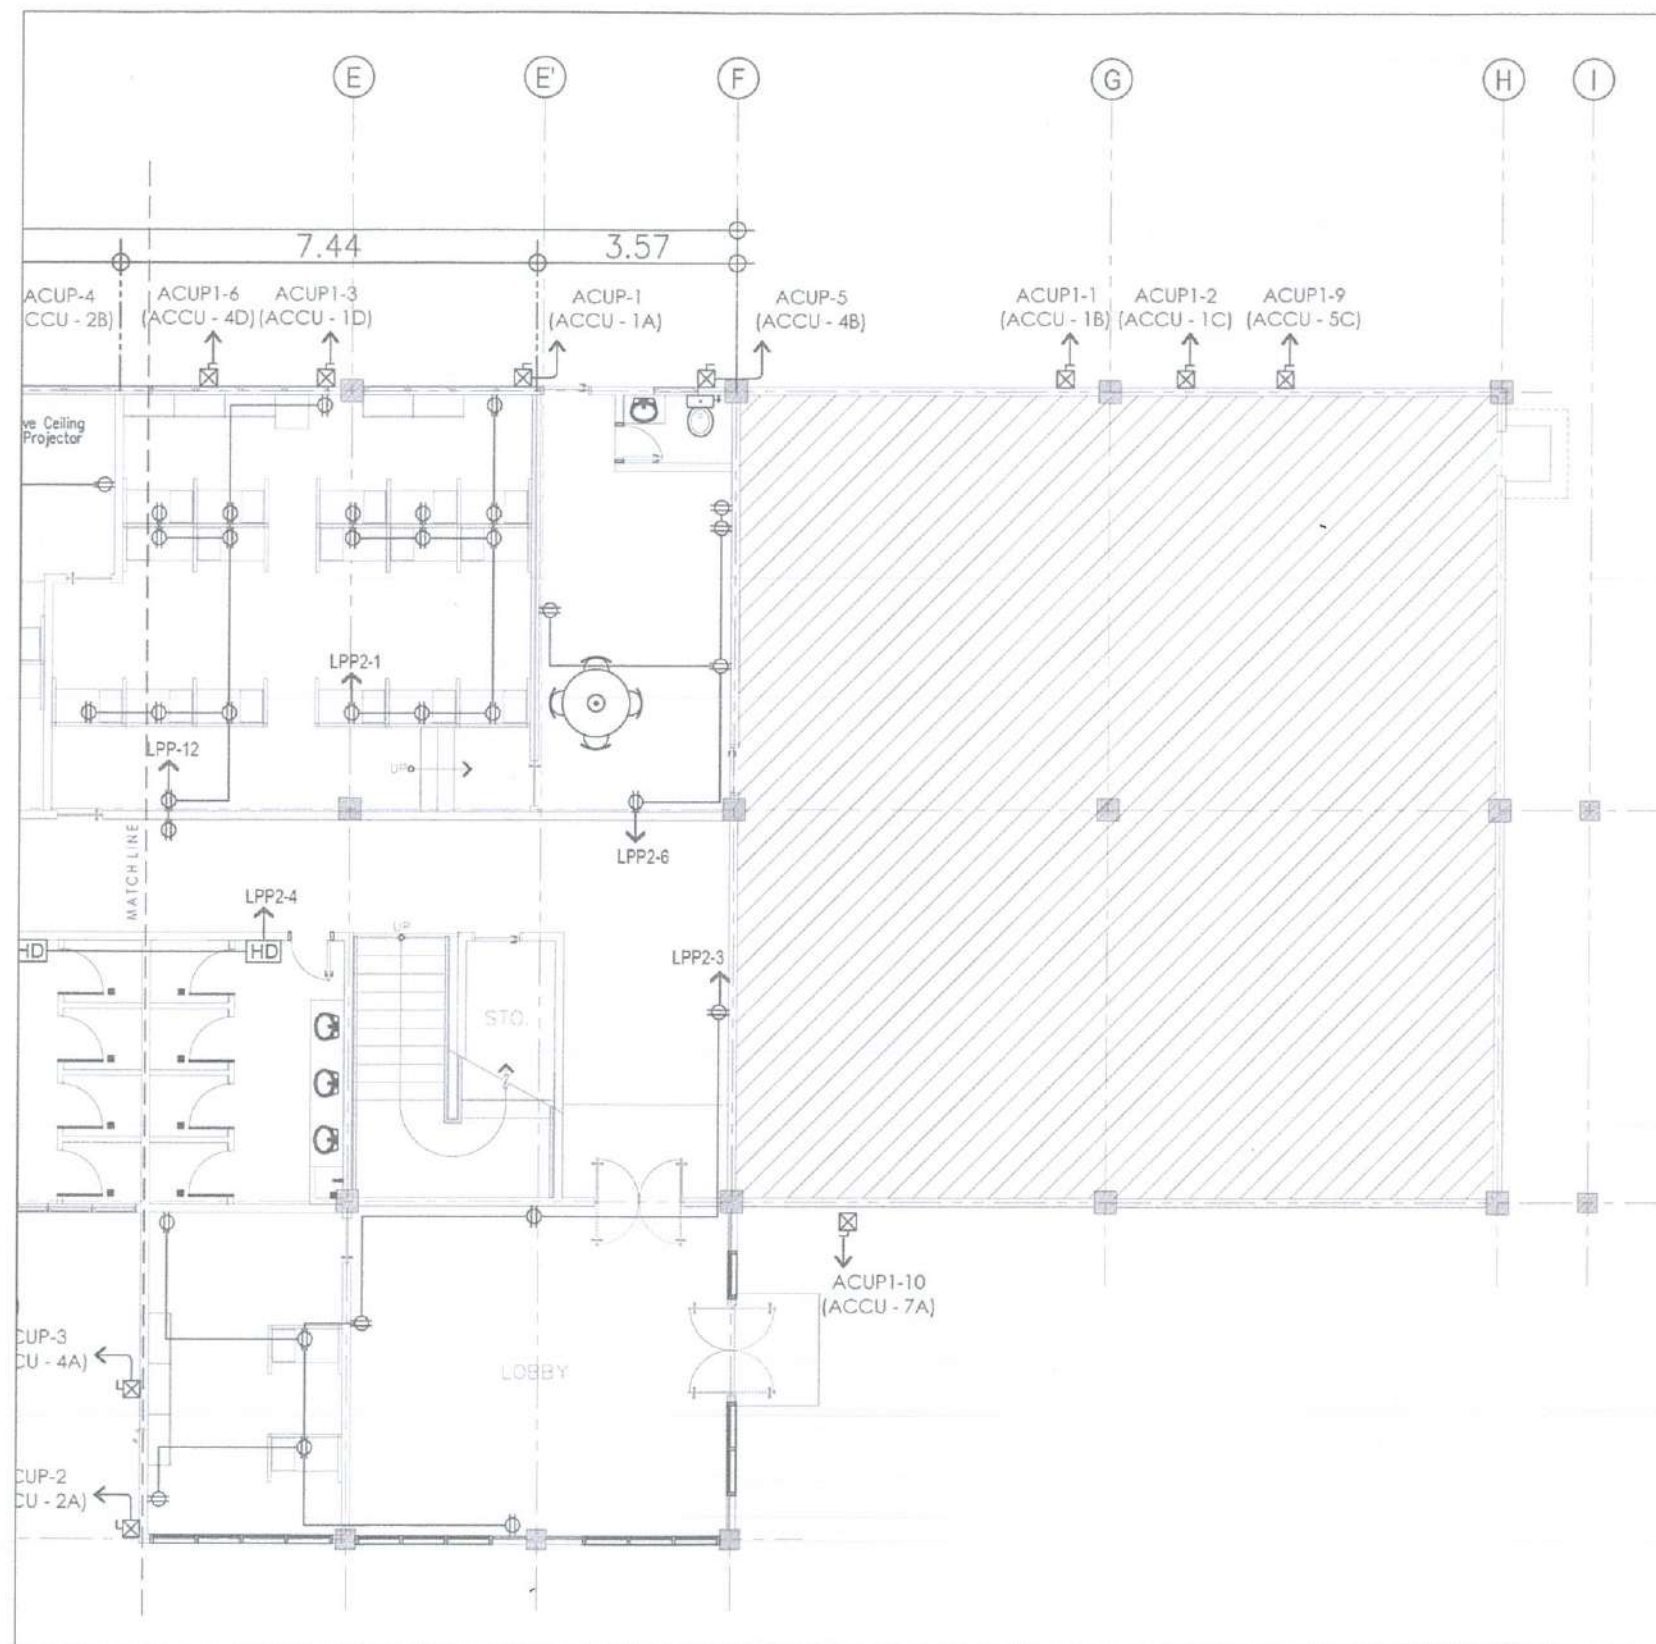

1
E 11
PARTIAL GROUND FLOOR
POWER LAYOUT PLAN
SCALE: 1:75M



CIVIL AVIATION AUTHORITY OF THE PHILIPPINES
BAGONG PILIPINAS

THIS DRAWINGS AND DESIGN IS EXCLUSIVE PROPERTIES OF CIVIL AVIATION AUTHORITY OF THE PHILIPPINES AND MUST NOT BE REPRODUCED, EXHIBITED, LOANED NOR COPIED IN PART OR IN WHOLE WITHOUT PROPER PERMISSION AND/OR WRITTEN CONSENT FROM THE DIRECTOR GENERAL CAAP.

AERODROME DEVELOPMENT AND MANAGEMENT SERVICE

INFRASTRUCTURE DEVELOPMENT AND DESIGN DIVISION

DESIGN STAFF	INITIAL / DATE
DESIGNED BY: RMD	
DRAWN BY: JPCJR	
CHECKED BY: RUAJR	

REVIEWED BY:

[Signature]
RAUL R. CRUCENA
Division Chief III, DOD - ADMS

SUBMITTED BY:

[Signature]
ARNEL F. BORLADO
Department Manager III, AED-ADMS

RECOMMENDED APPROVAL:

[Signature]
LT COL VALENTINO A. DIONELA PAF RET.
Assistant Director General II, ADMS

APPROVED:

[Signature]
CAPTAIN MARCELO L. TAMAYO
Director General

NOTES/REVISIONS:

PROJECT:

IMPROVEMENT/REHABILITATION OF AIRWAYS FACILITY COMPLEX BUILDING


LOCATION:

CAAP CENTRAL OFFICE
NAIA ROAD COR. N. AQUINO AVE,
PASAY CITY

SHEET CONTENTS:

PARTIAL GROUND FLOOR
POWER LAYOUT PLAN

DRAWING SCALE:	SHEET NO:
AS SHOWN	E-11

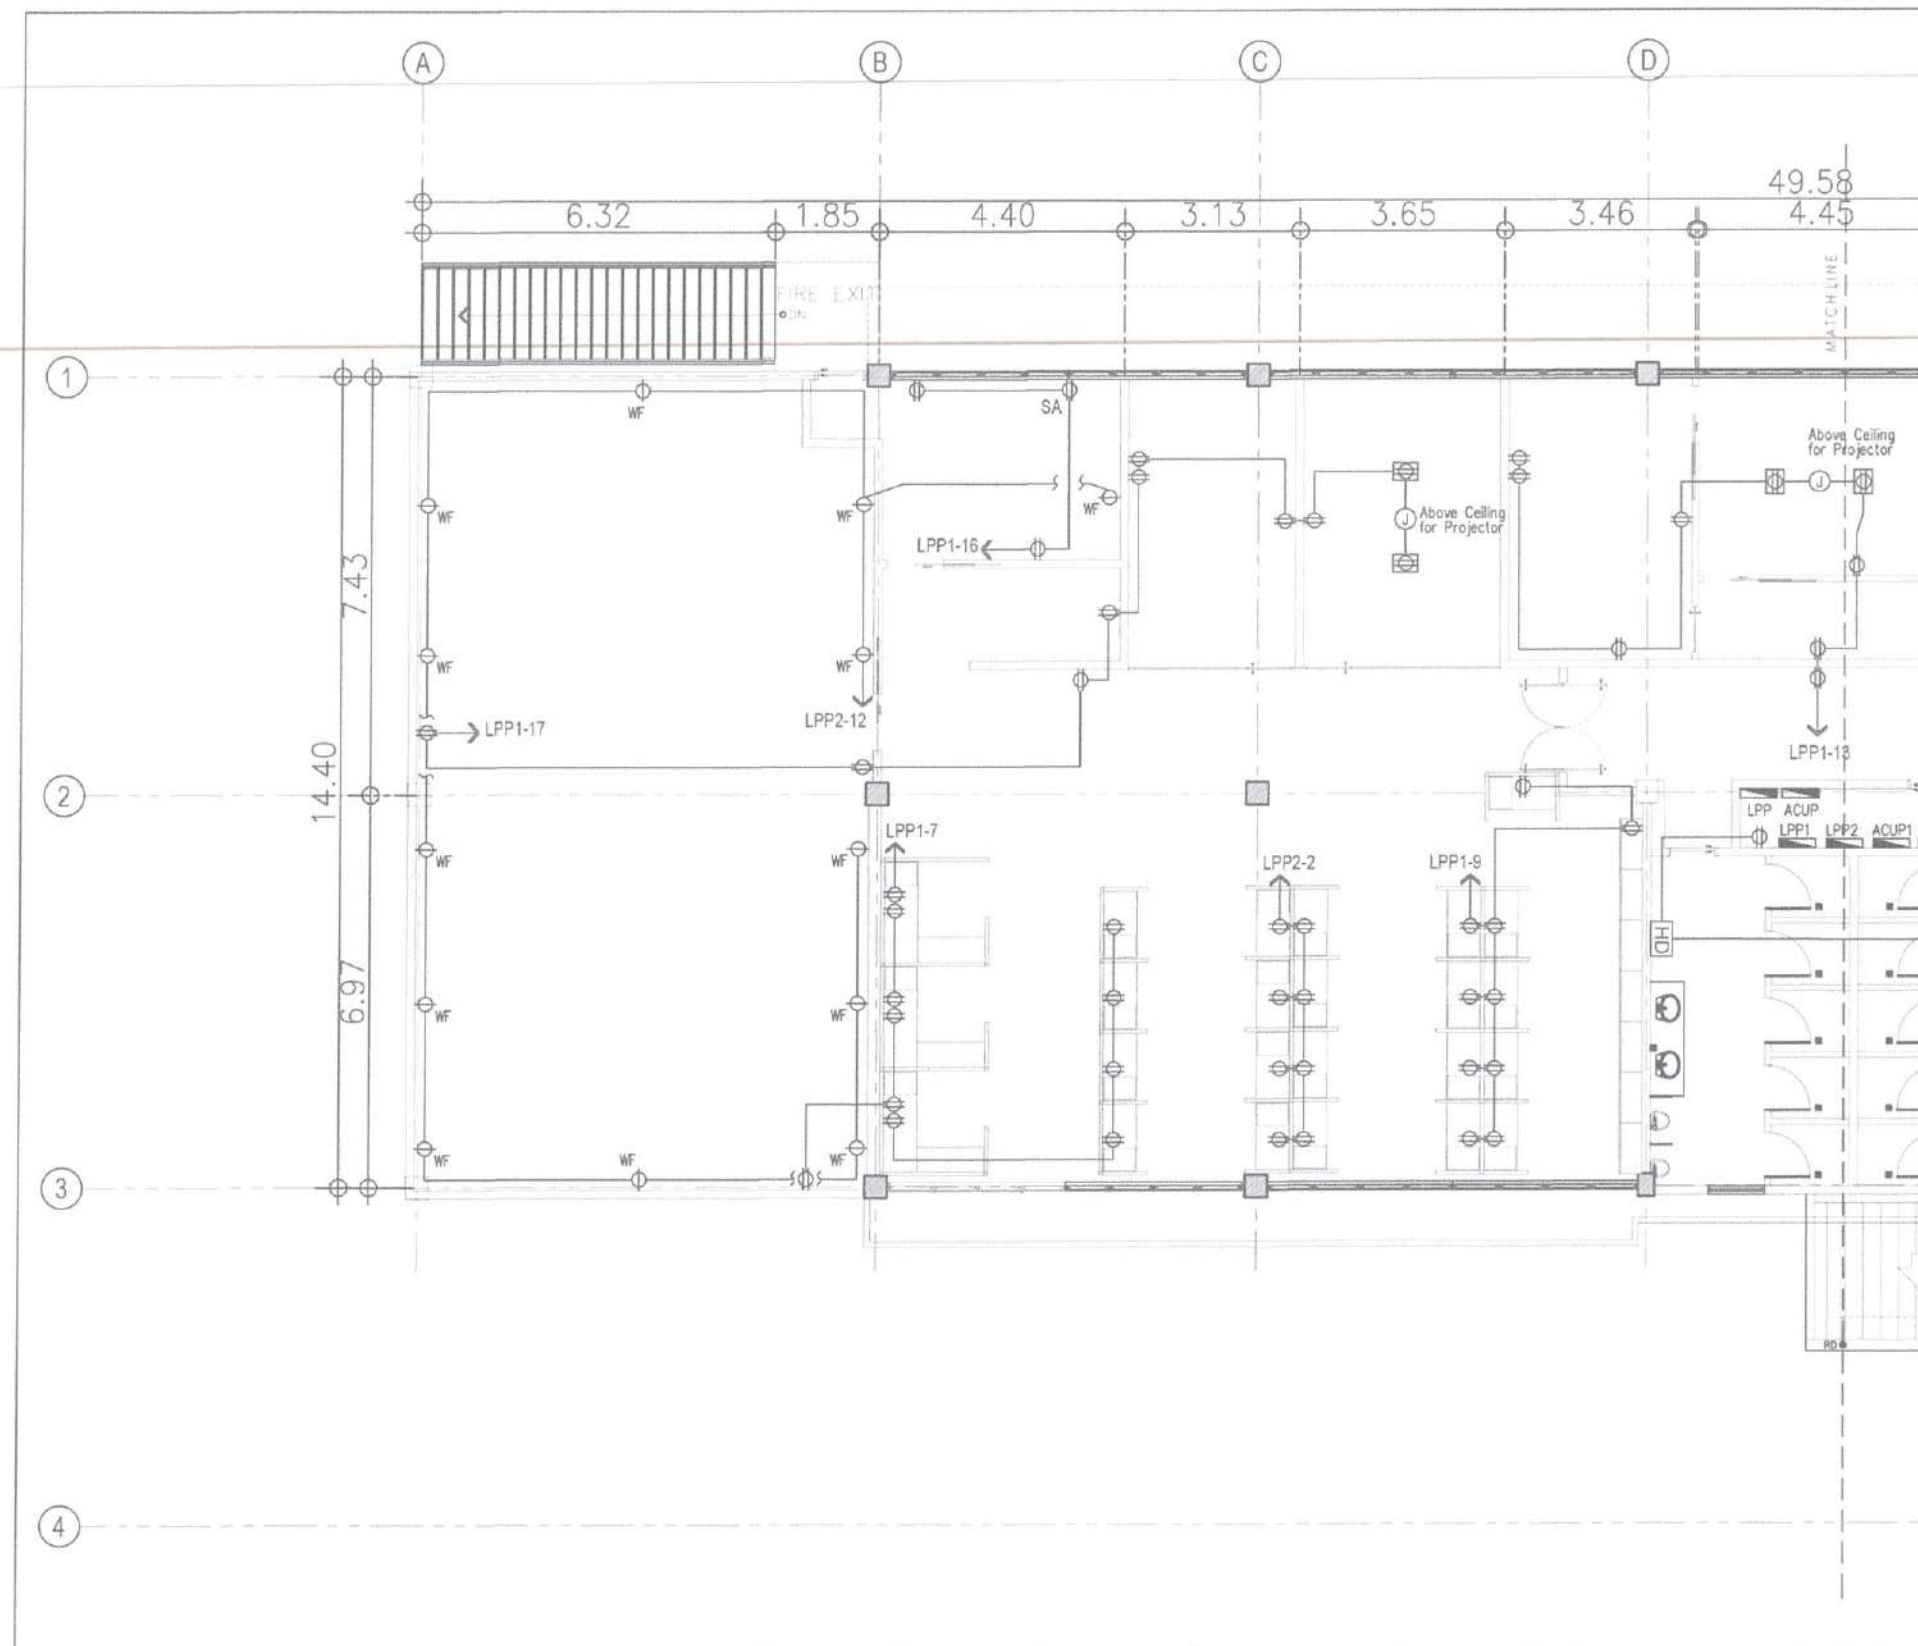

PARTIAL SECOND FLOOR
POWER LAYOUT PLAN
 SCALE: 1:75M



CIVIL AVIATION AUTHORITY OF THE PHILIPPINES

THIS DRAWINGS AND DESIGN IS EXCLUSIVE PROPERTIES OF CIVIL AVIATION AUTHORITY OF THE PHILIPPINES AND MUST NOT BE REPRODUCED, EXHIBITED, LOANED NOR COPIED IN PART OR IN WHOLE WITHOUT PROPER PERMISSION AND/OR WRITTEN CONSENT FROM THE DIRECTOR GENERAL CAAP.

AERODROME DEVELOPMENT AND MANAGEMENT SERVICE

INFRASTRUCTURE DEVELOPMENT AND DESIGN DIVISION

DESIGN STAFF	INITIAL / DATE
DESIGNED BY: RMD	
DRAWN BY: JPCJR	
CHECKED BY: RUAJR	

REVIEWED BY:

[Signature]
 RAUL R. CRUCENA
 Division Chief III, EDD - ADMS

SUBMITTED BY:

[Signature]
 ARNEL F. BORLADO
 Department Manager III, AED-ADMS

RECOMMENDED APPROVAL:

[Signature]
 LT COL. VALENTINO A. DIONELA PAF RET
 Assistant Director General II, ADMS

APPROVED:

[Signature]
 CAPTAIN MANUEL ANTONIO L. TAMAYO
 Director General

NOTES/REVISIONS:

PROJECT:

IMPROVEMENT/REHABILITATION OF AIRWAYS FACILITY COMPLEX BUILDING


LOCATION:

CAAP CENTRAL OFFICE
 NAIA ROAD COR. N. AQUINO AVE,
 PASAY CITY

SHEET CONTENTS

PARTIAL SECOND FLOOR
 POWER LAYOUT PLAN

DRAWING SCALE	SHEET NO.
AS SHOWN	E-12

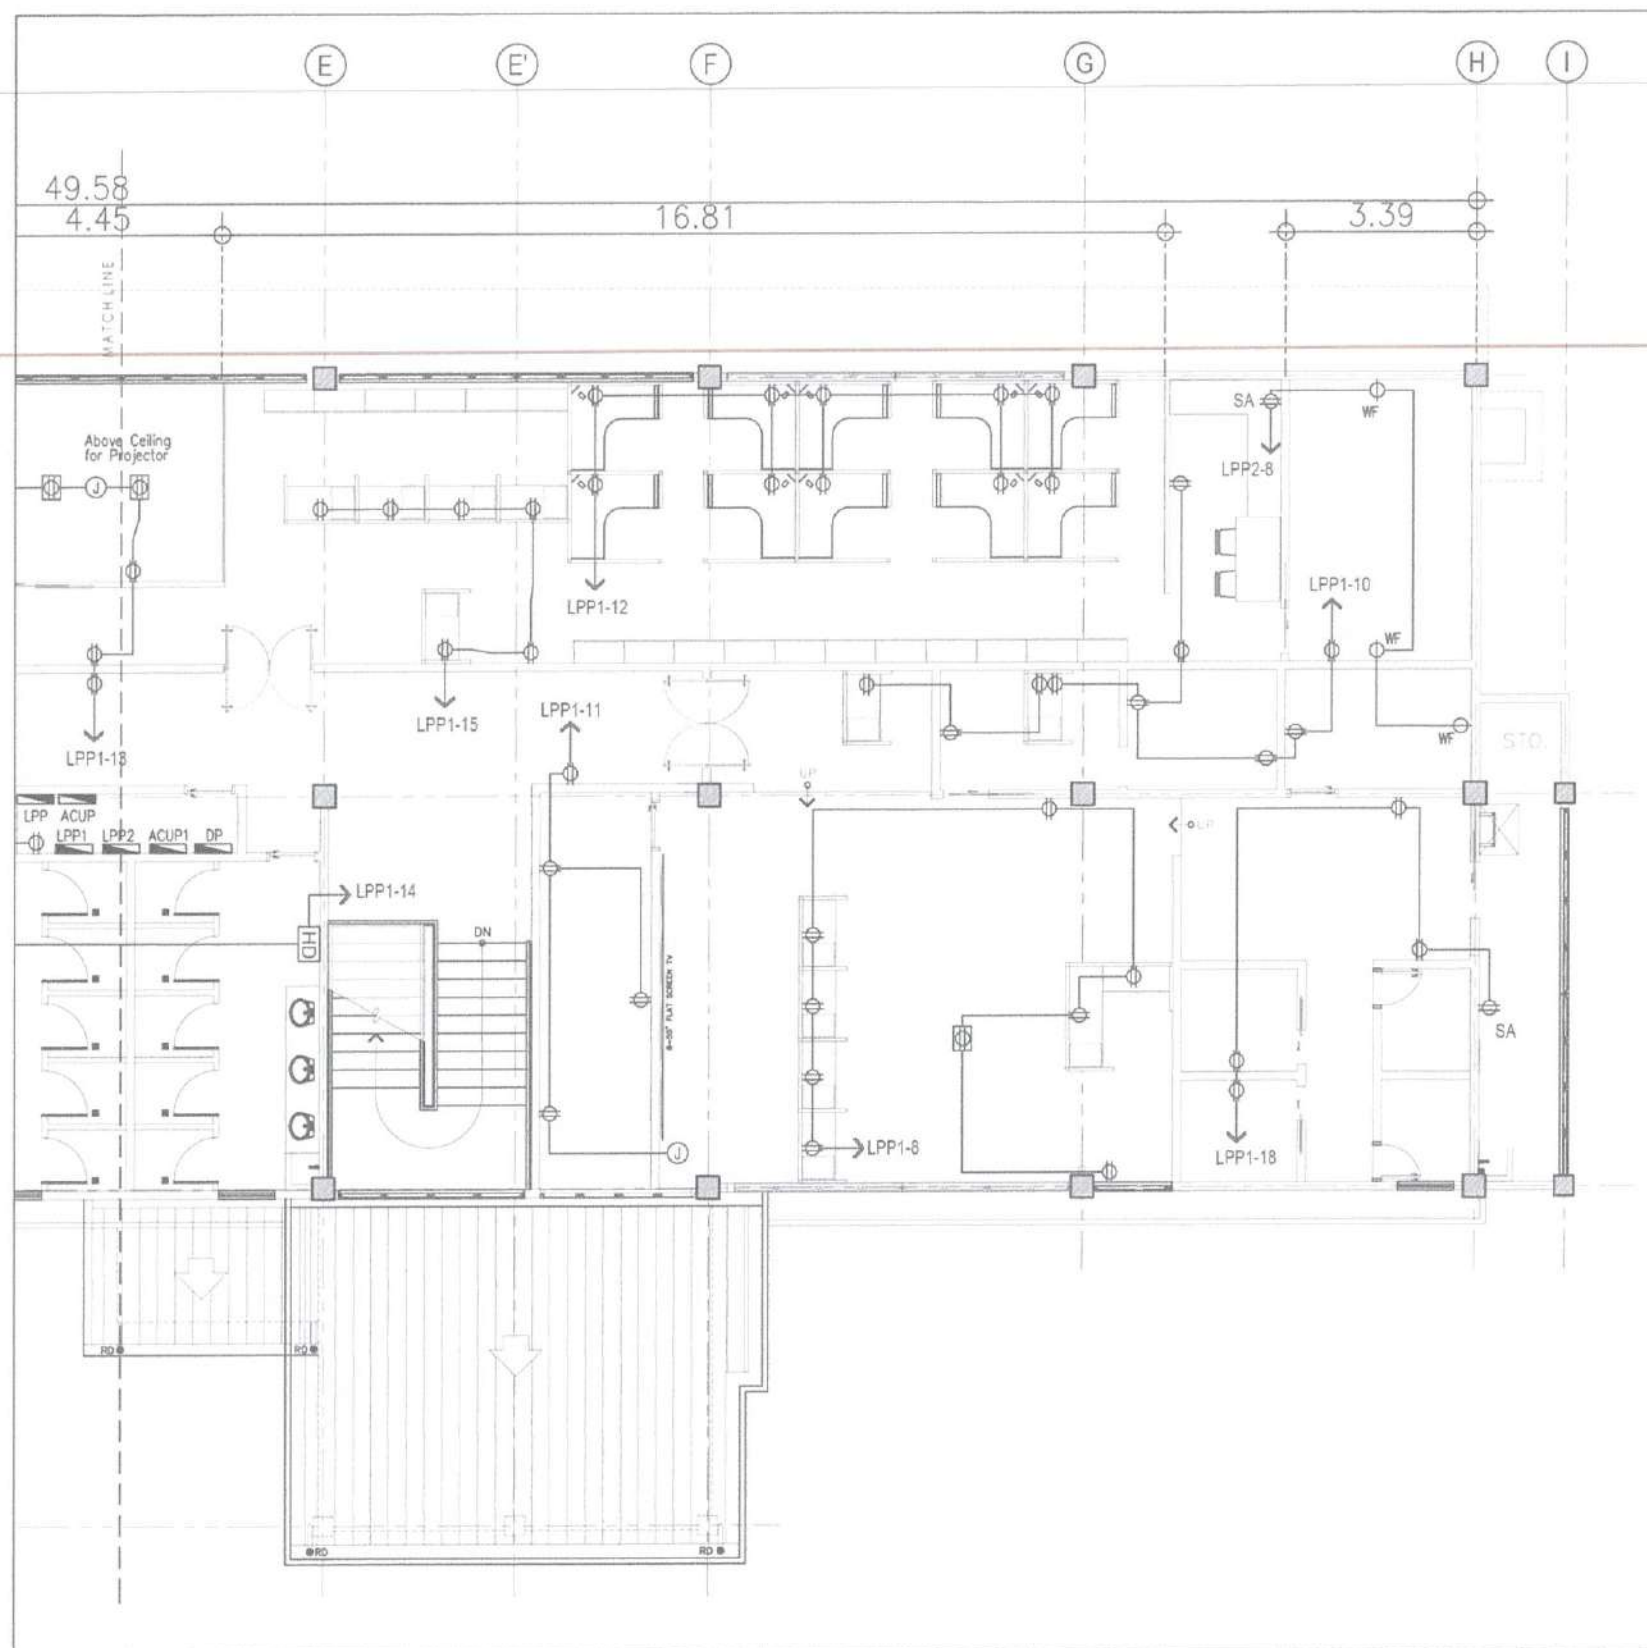

1
E 13
PARTIAL SECOND FLOOR
POWER LAYOUT PLAN
SCALE: 1:75M



CIVIL AVIATION AUTHORITY OF THE PHILIPPINES
NO. 100, 101, 102, 999, 1000

THIS DRAWINGS AND DESIGN IS EXCLUSIVE PROPERTIES OF CIVIL AVIATION AUTHORITY OF THE PHILIPPINES AND MUST NOT BE REPRODUCED, EXHIBITED, LOANED NOR COPIED IN PART OR IN WHOLE WITHOUT PROPER PERMISSION AND/OR WRITTEN CONSENT FROM THE DIRECTOR GENERAL CAAP

AERODROME DEVELOPMENT AND MANAGEMENT SERVICE

INFRASTRUCTURE DEVELOPMENT AND DESIGN DIVISION

DESIGN STAFF	INITIAL / DATE
DESIGNED BY:	RMD
DRAWN BY:	JPCJR
CHECKED BY:	RUAR

REVIEWED BY:

RAUL R. CRUCENA
Division Chief III, AED-ADMS

SUBMITTED BY:

ARNEL F. BORLADO
Department Manager III, AED-ADMS

RECOMMENDED APPROVAL:

LT COL VALENTINO A. DIONELA PAF RET
Assistant Director General II, ADMS

APPROVED:

CAPTAIN MANUEL ANTONIO L. TAMAYO
Director General

NOTES/REVISIONS:

PROJECT

IMPROVEMENT/REHABILITATION OF AIRWAYS FACILITY COMPLEX BUILDING


LOCATION:

CAAP CENTRAL OFFICE
NAIA ROAD COR. N. AQUINO AVE,
PASAY CITY

SHEET CONTENTS:

PARTIAL SECOND FLOOR
POWER LAYOUT PLAN

DRAWING SCALE	SHEET NO.
AS SHOWN	E-13

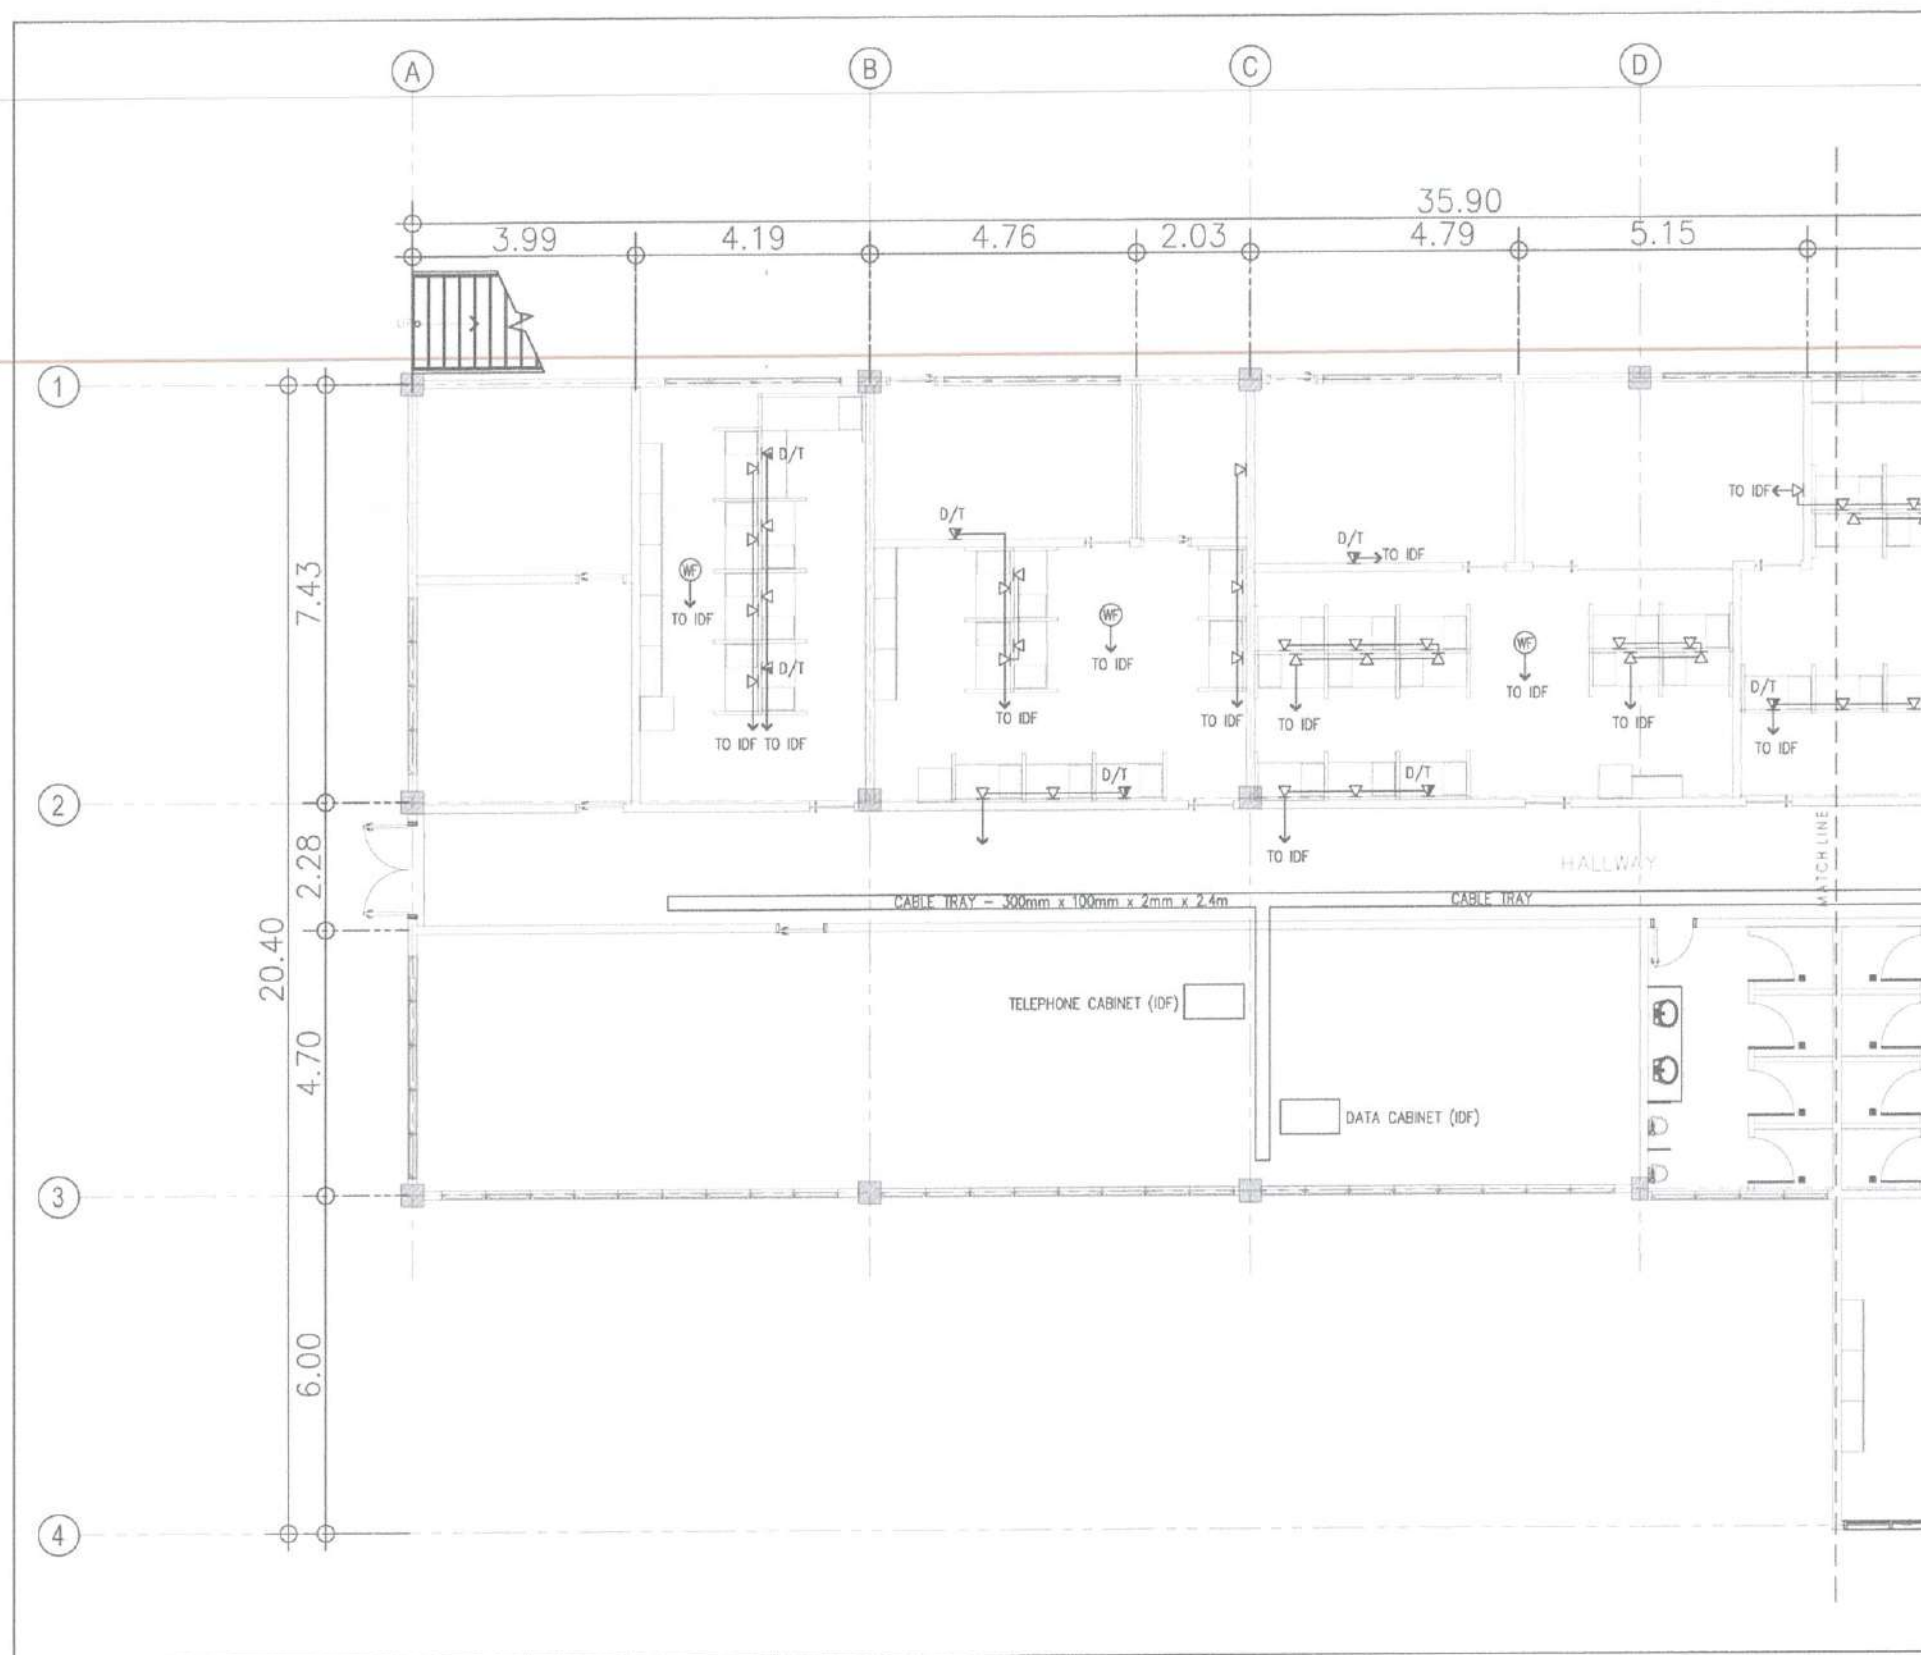

1
E 14
SCALE: 1:75M

PARTIAL GROUND FLOOR
DATA AND VOICE SYSTEM LAYOUT PLAN



CIVIL AVIATION AUTHORITY OF THE PHILIPPINES

THIS DRAWINGS AND DESIGN IS EXCLUSIVE PROPERTIES OF CIVIL AVIATION AUTHORITY OF THE PHILIPPINES AND MUST NOT BE REPRODUCED, EXHIBITED, LOANED, NOR COPIED IN PART OR IN WHOLE WITHOUT PROPER PERMISSION AND/OR WRITTEN CONSENT FROM THE DIRECTOR GENERAL CAAP.

AERODROME DEVELOPMENT AND MANAGEMENT SERVICE

INFRASTRUCTURE DEVELOPMENT AND DESIGN DIVISION

DESIGN STAFF: INITIAL / DATE

DESIGNED BY: RMD

DRAWN BY: JPCJR

CHECKED BY: RUJAJR

REVIEWED BY:

RAUL R. CRUCENA
Division Chief III, ADD - ADMS

SUBMITTED BY:

ARNEL F. BORLADO
Department Manager III, AED-ADMS

RECOMMENDED APPROVAL:

LYCOL VALENTINO A DIONELA PAF RET
Assistant Director General II, ADMS

APPROVED:

CAPTAIN MANUEL ANTONIO L. TAMAYO
Director General

NOTES/REVISIONS:

PROJECT:

IMPROVEMENT/REHABILITATION OF AIRWAYS FACILITY COMPLEX BUILDING

LOCATION:

CAAP CENTRAL OFFICE
NAIA ROAD COR. N. AQUINO AVE,
PASAY CITY

SHEET CONTENTS:

PARTIAL GROUND FLOOR
DATA AND VOICE SYSTEM
LAYOUT PLAN

DRAWING SCALE:

AS SHOWN

SHEET NO.:

E-14



CIVIL AVIATION AUTHORITY OF THE PHILIPPINES
1000 N. AVENUE, PASAY CITY

THIS DRAWINGS AND DESIGN IS
EXCLUSIVE PROPERTIES OF CIVIL AVIATION
AUTHORITY OF THE PHILIPPINES AND MUST
NOT BE REPRODUCED, EXHIBITED, LOANED
NOR COPIED IN PART OR IN WHOLE WITHOUT
PROPER PERMISSION AND/OR WRITTEN
CONSENT FROM THE DIRECTOR GENERAL
CAAP

AERODROME DEVELOPMENT AND
MANAGEMENT SERVICE

INFRASTRUCTURE DEVELOPMENT
AND DESIGN DIVISION

DESIGN STAFF	INITIAL / DATE
DESIGNER	RMD
DRAWN BY	JPCJR
CHECKED BY	RUAJR

REVIEWED BY:

RAUL R. RUCENA
Division Chief III, IDDD - ADMS

SUBMITTED BY:

ARNEL F. BORLADO
Department Manager III, AED-ADMS

RECOMMENDED APPROVAL:

LT COL. VALENTINO A. DIONELA PAF RET
Assistant Director General II, ADMS

APPROVED:

CAPTAIN MANUEL ANTONIO L. TAMAYO
Director General

NOTES/REVISIONS:

PROJECT:

IMPROVEMENT/REHABILITATION
OF AIRWAYS FACILITY COMPLEX
BUILDING


LOCATION:

CAAP CENTRAL OFFICE
NAIA ROAD COR. N. AQUINO AVE,
PASAY CITY


SHEET CONTENTS:

PARTIAL GROUND FLOOR
DATA AND VOICE SYSTEM LAYOUT PLAN

DRAWING SCALE:	SHEET NO.
AS SHOWN	E-15

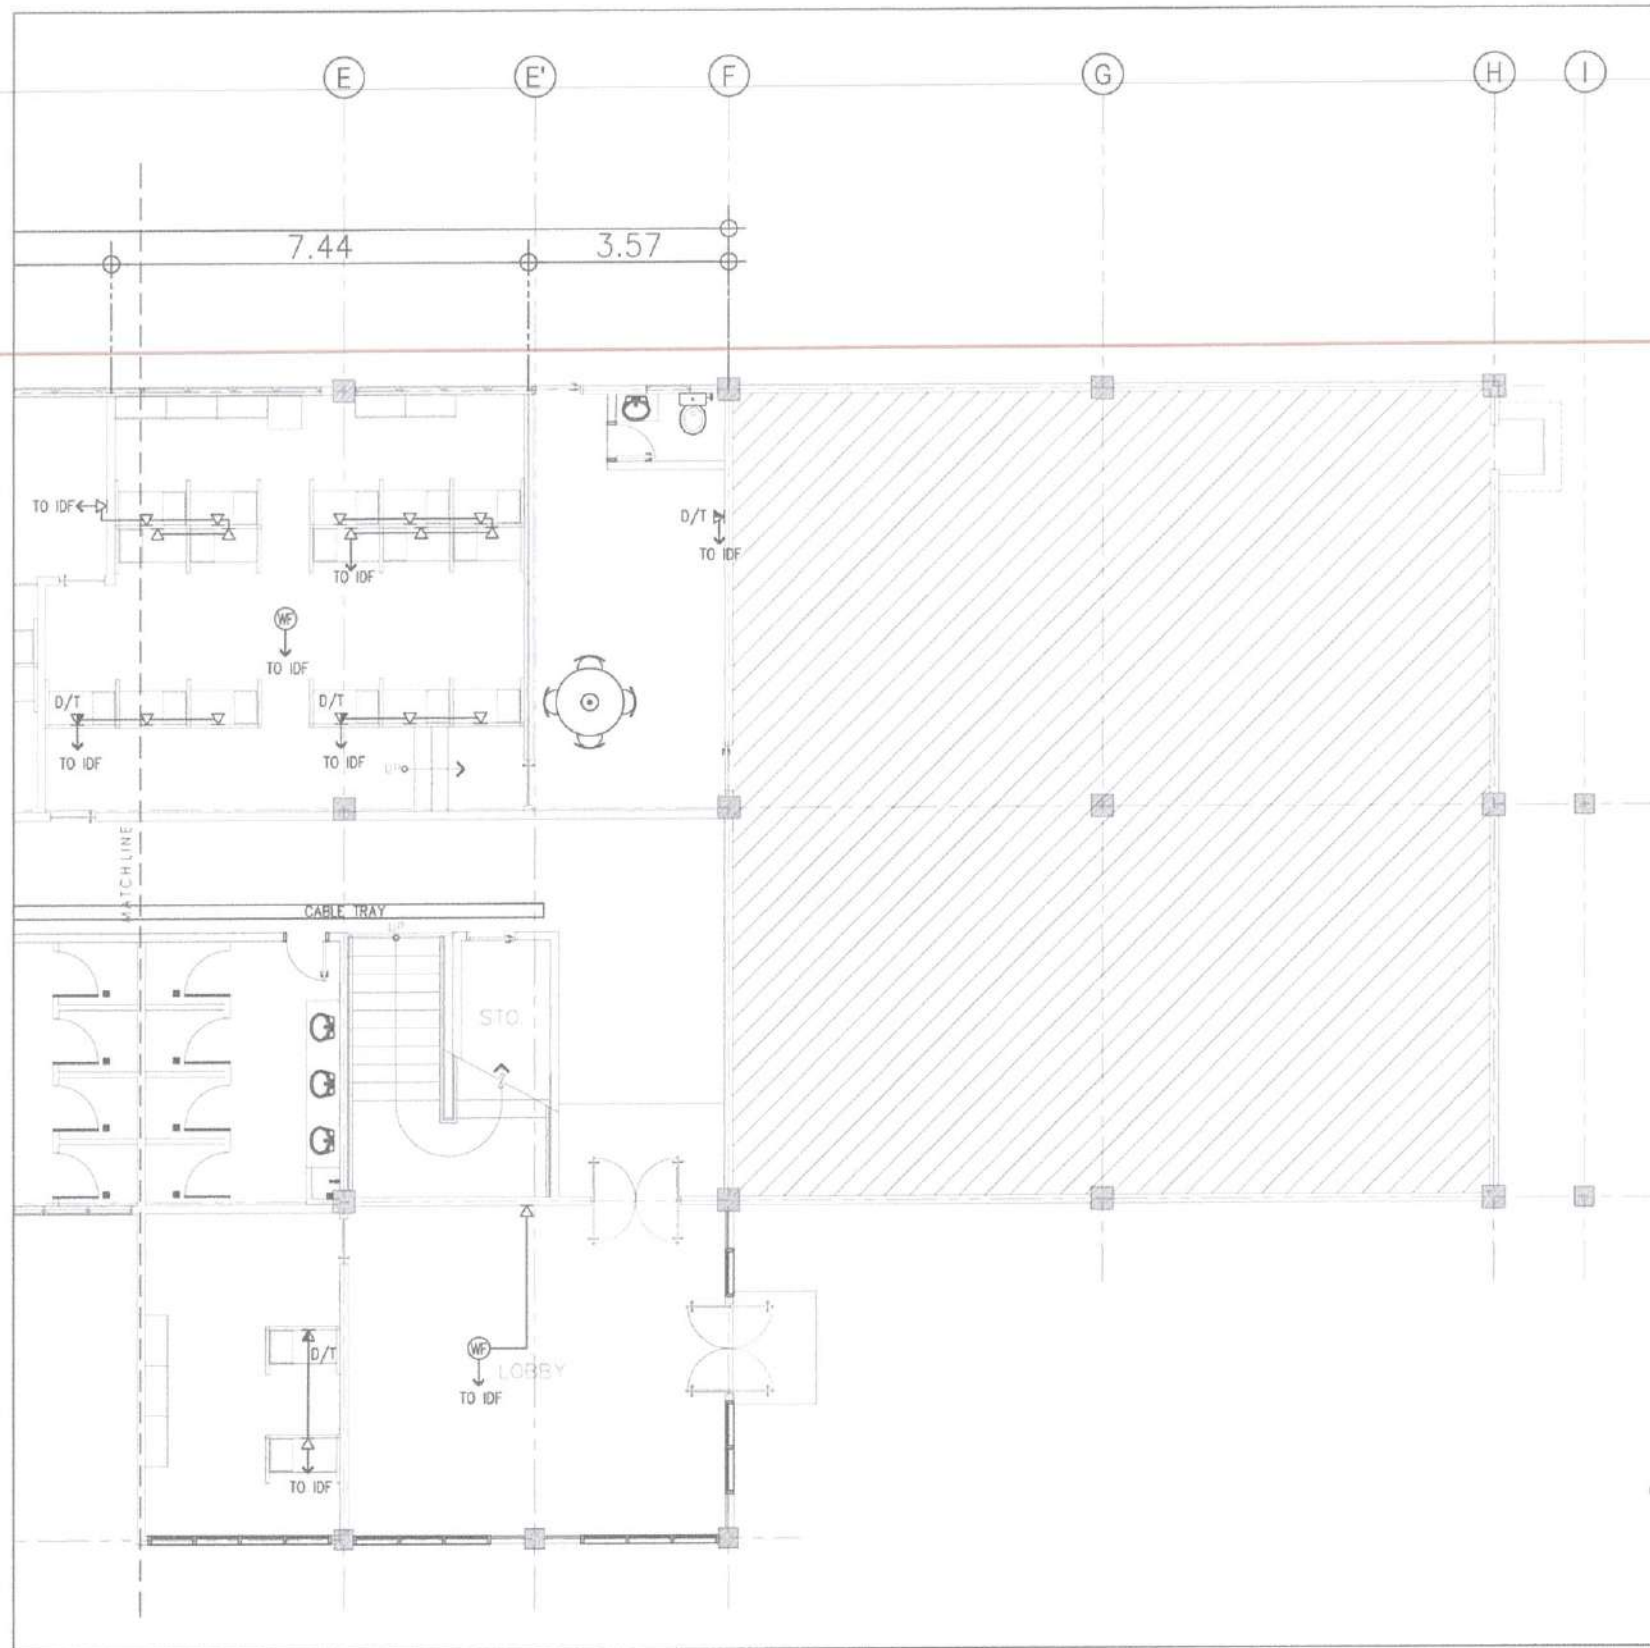

1
E 15
PARTIAL GROUND FLOOR
DATA AND VOICE SYSTEM LAYOUT PLAN
SCALE: 1:75M

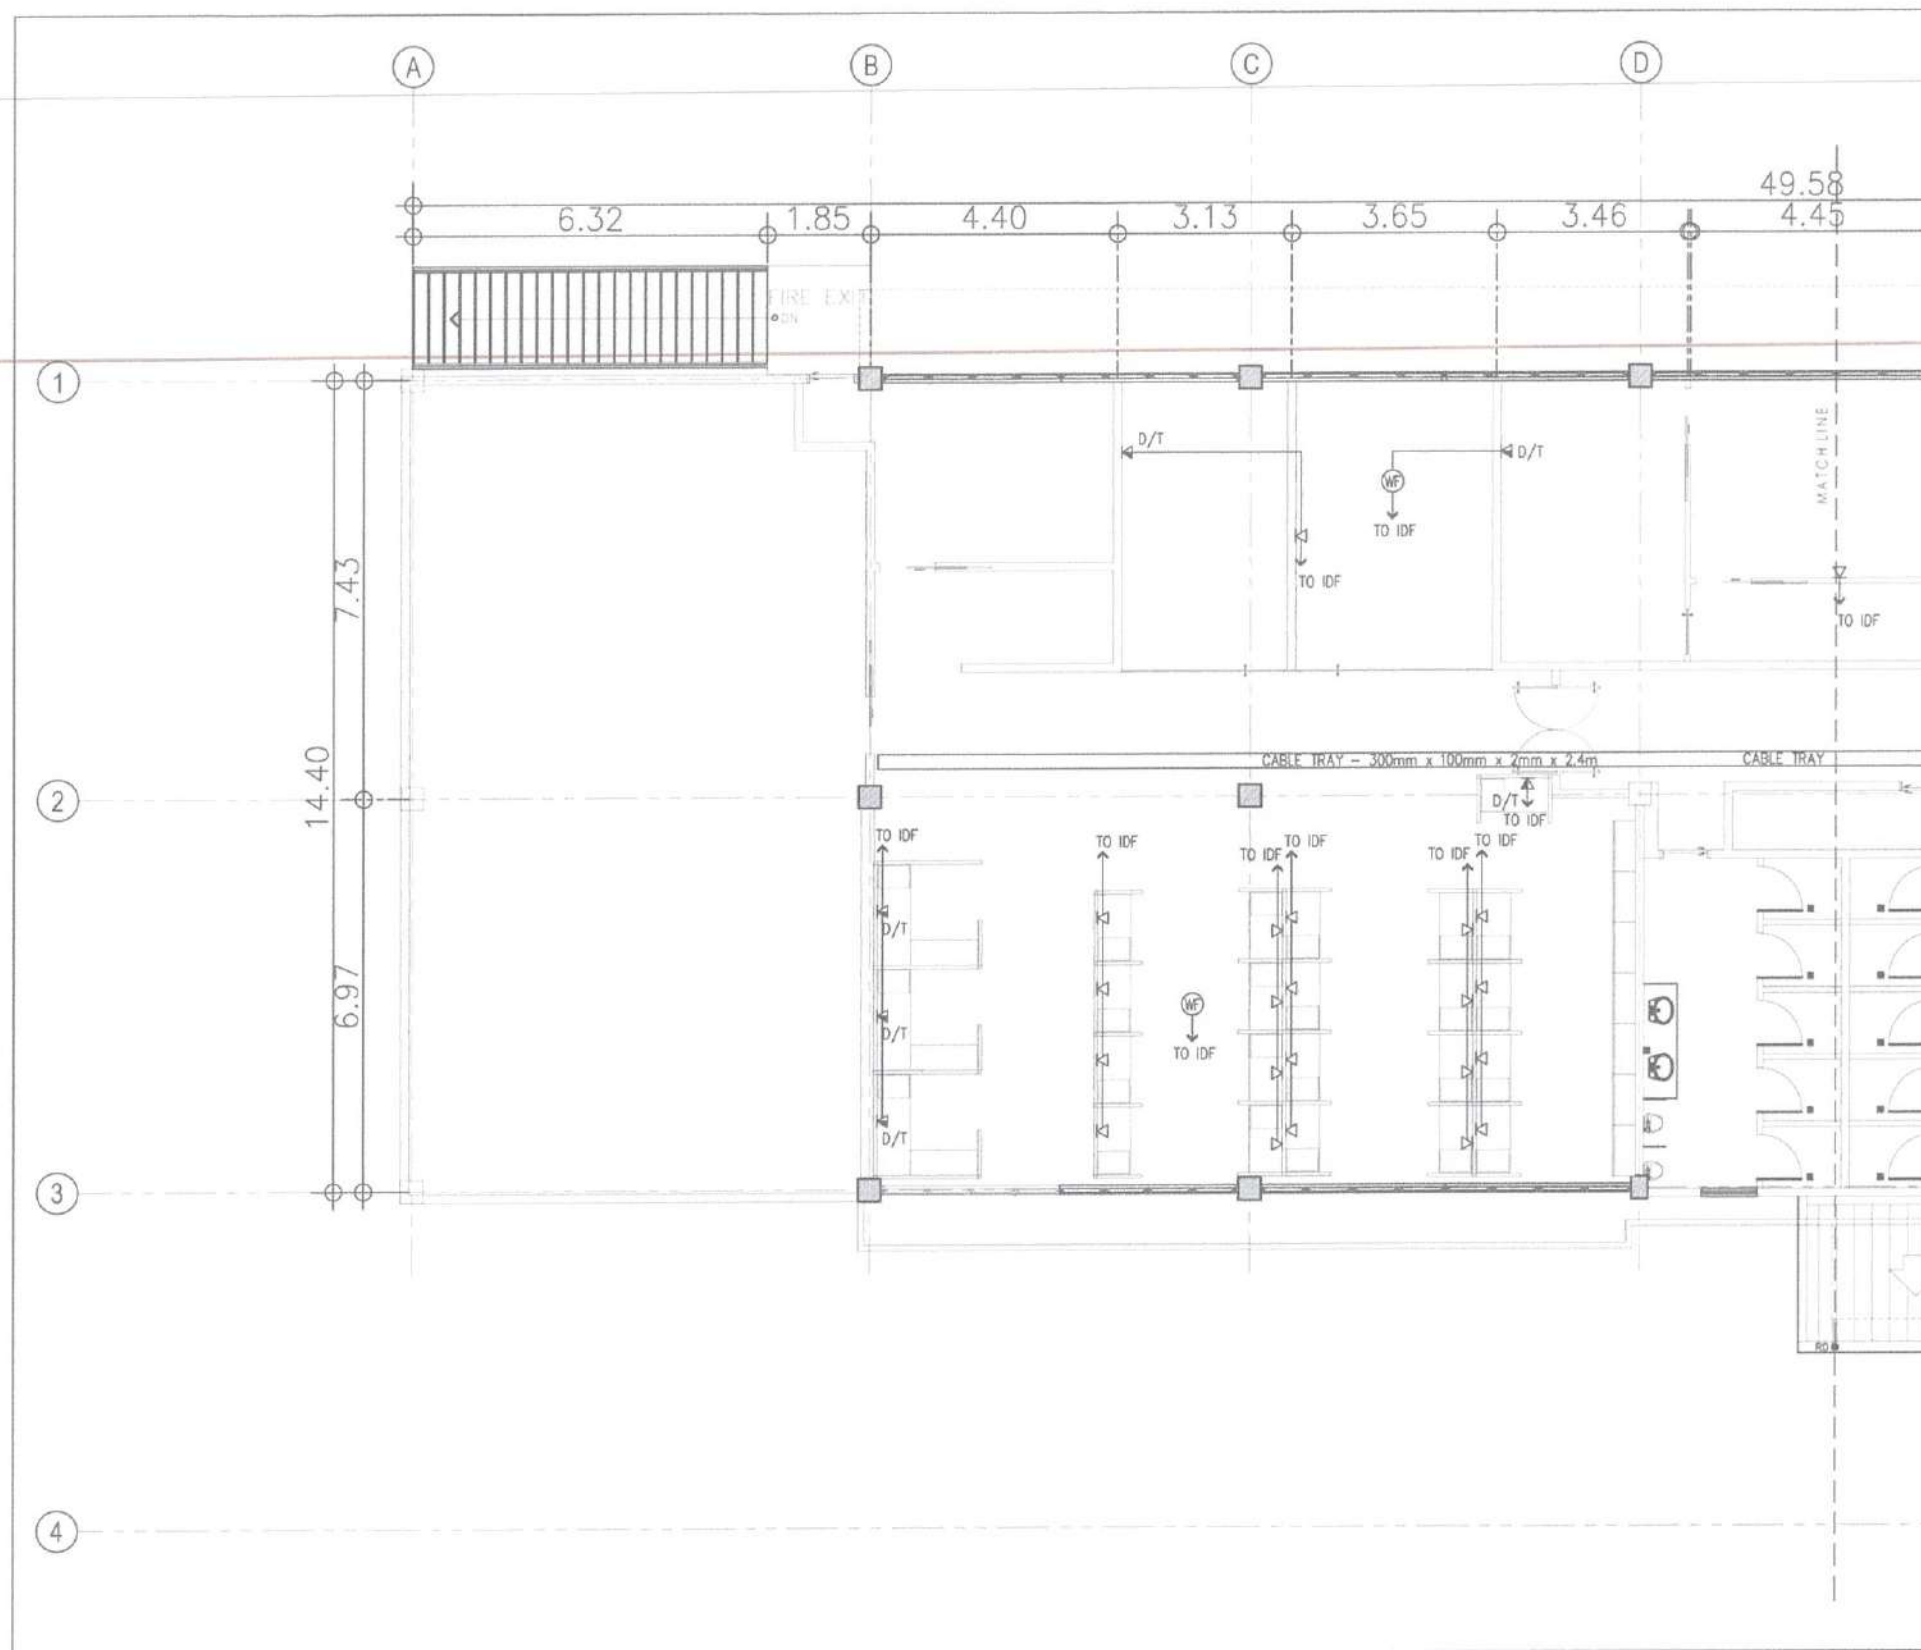

1
E 16
PARTIAL SECOND FLOOR
DATA AND VOICE SYSTEM LAYOUT PLAN
SCALE: 1:75M



THIS DRAWINGS AND DESIGN IS EXCLUSIVE PROPERTIES OF CIVIL AVIATION AUTHORITY OF THE PHILIPPINES AND MUST NOT BE REPRODUCED, EXHIBITED, LOANED NOR COPIED IN PART OR IN WHOLE WITHOUT PROPER PERMISSION AND/OR WRITTEN CONSENT FROM THE DIRECTOR GENERAL CAAP

AERODROME DEVELOPMENT AND MANAGEMENT SERVICE

INFRASTRUCTURE DEVELOPMENT AND DESIGN DIVISION

DESIGN STAFF	INITIAL / DATE
DESIGNED BY: RMD	
DRAWN BY: JPCJR	
CHECKED BY: RUAJR	

REVIEWED BY:
RAUL R. TRUCENA
Division Chief III, ADD - ADMS

SUBMITTED BY:
ARNEL F. BORLADO
Department Manager III, AED-ADMS

RECOMMENDED APPROVAL:
LT COL VALENTINO A. DIONELA PAF RET
Assistant Director General II, ADMS

APPROVED:
CAPTAIN MANUEL ANTONIO L. TAMAYO
Director General


NOTES/REVISIONS:

PROJECT:
IMPROVEMENT/REHABILITATION OF AIRWAYS FACILITY COMPLEX BUILDING

LOCATION:
CAAP CENTRAL OFFICE
NAIA ROAD COR. N. AQUINO AVE,
PASAY CITY

SHEET CONTENTS:
PARTIAL SECOND FLOOR
DATA AND VOICE SYSTEM
LAYOUT PLAN

DRAWING SCALE	SHEET NO.
AS SHOWN	E-16

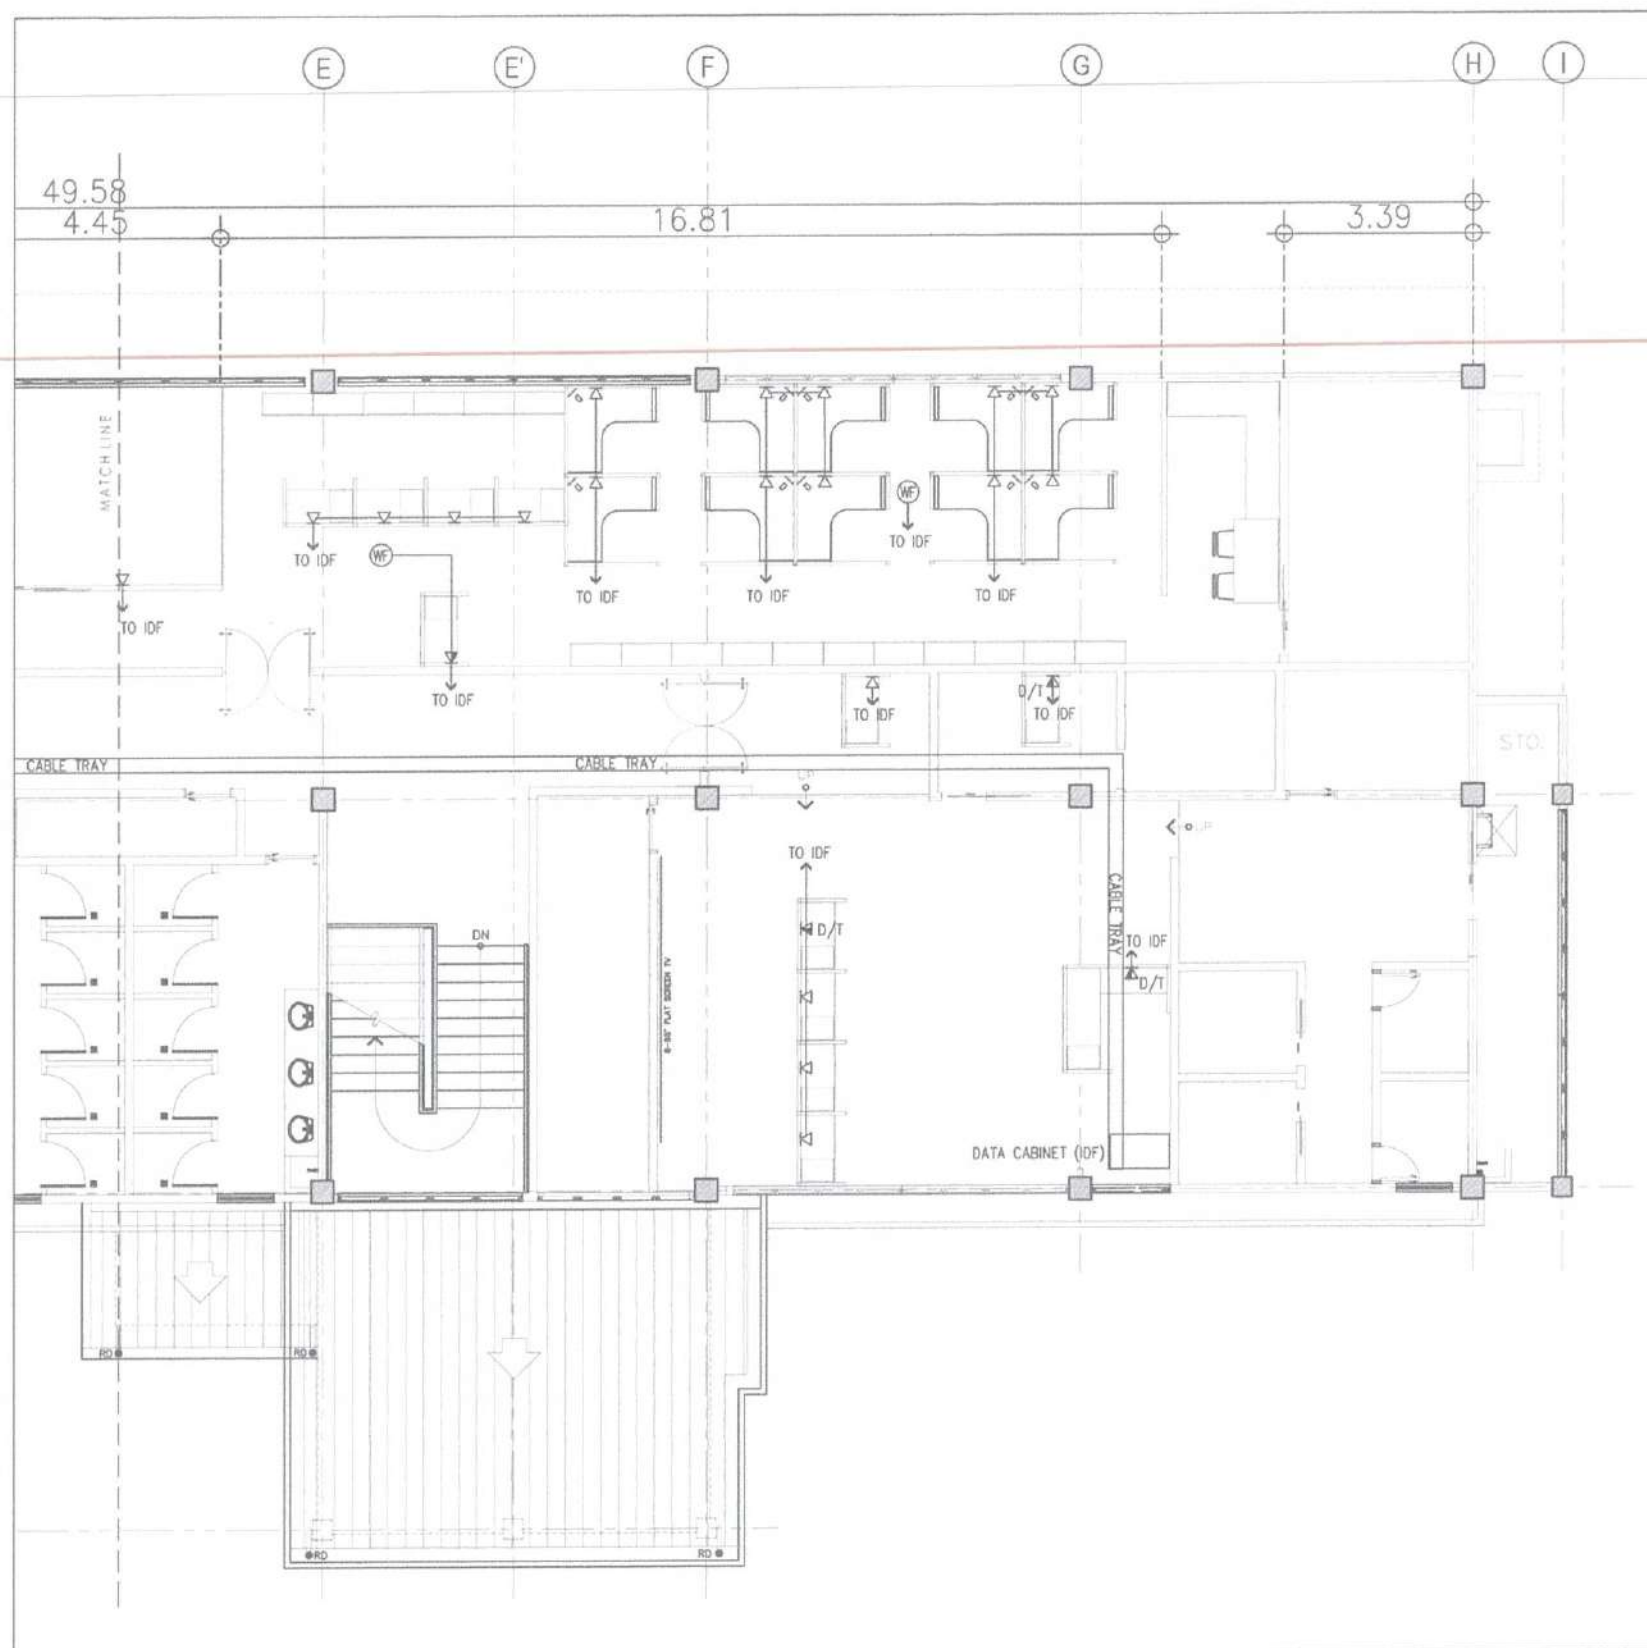

1
E 17
PARTIAL SECOND FLOOR
DATA AND VOICE SYSTEM LAYOUT PLAN
SCALE: 1:75M



CIVIL AVIATION AUTHORITY OF THE PHILIPPINES

THIS DRAWINGS AND DESIGN IS EXCLUSIVE PROPERTIES OF CIVIL AVIATION AUTHORITY OF THE PHILIPPINES AND MUST NOT BE REPRODUCED, EXHIBITED, LOANED, NOR COPIED IN PART OR IN WHOLE WITHOUT PROPER PERMISSION AND/OR WRITTEN CONSENT FROM THE DIRECTOR GENERAL CAAP.

AERODROME DEVELOPMENT AND MANAGEMENT SERVICE

INFRASTRUCTURE DEVELOPMENT AND DESIGN DIVISION

DESIGN STAFF	INITIAL / DATE
DESIGNED BY: RMD	
DRAWN BY: JPCJR	
CHECKED BY: RUAJR	

REVIEWED BY:

[Signature]
RAUL R. CRUCENA
Division Chief III, AED-ADMS

SUBMITTED BY:

ARNEL F. BORLADO
Department Manager III, AED-ADMS

RECOMMENDED APPROVAL:

[Signature]
LT COL VALENTINO A. DIONELA PAF RET
Assistant Director General II, ADMS

APPROVED:

[Signature]
CAPTAIN MANUEL ANTONIO L. TAMAYO
Director General

NOTES/REVISIONS:

PROJECT:

IMPROVEMENT/REHABILITATION OF AIRWAYS FACILITY COMPLEX BUILDING

LOCATION:

CAAP CENTRAL OFFICE
NAIA ROAD COR. N. AQUINO AVE,
PASAY CITY

SHEET CONTENTS:


PARTIAL SECOND FLOOR
DATA AND VOICE SYSTEM
LAYOUT PLAN

DRAWING SCALE:

AS SHOWN

SHEET NO.

E-17

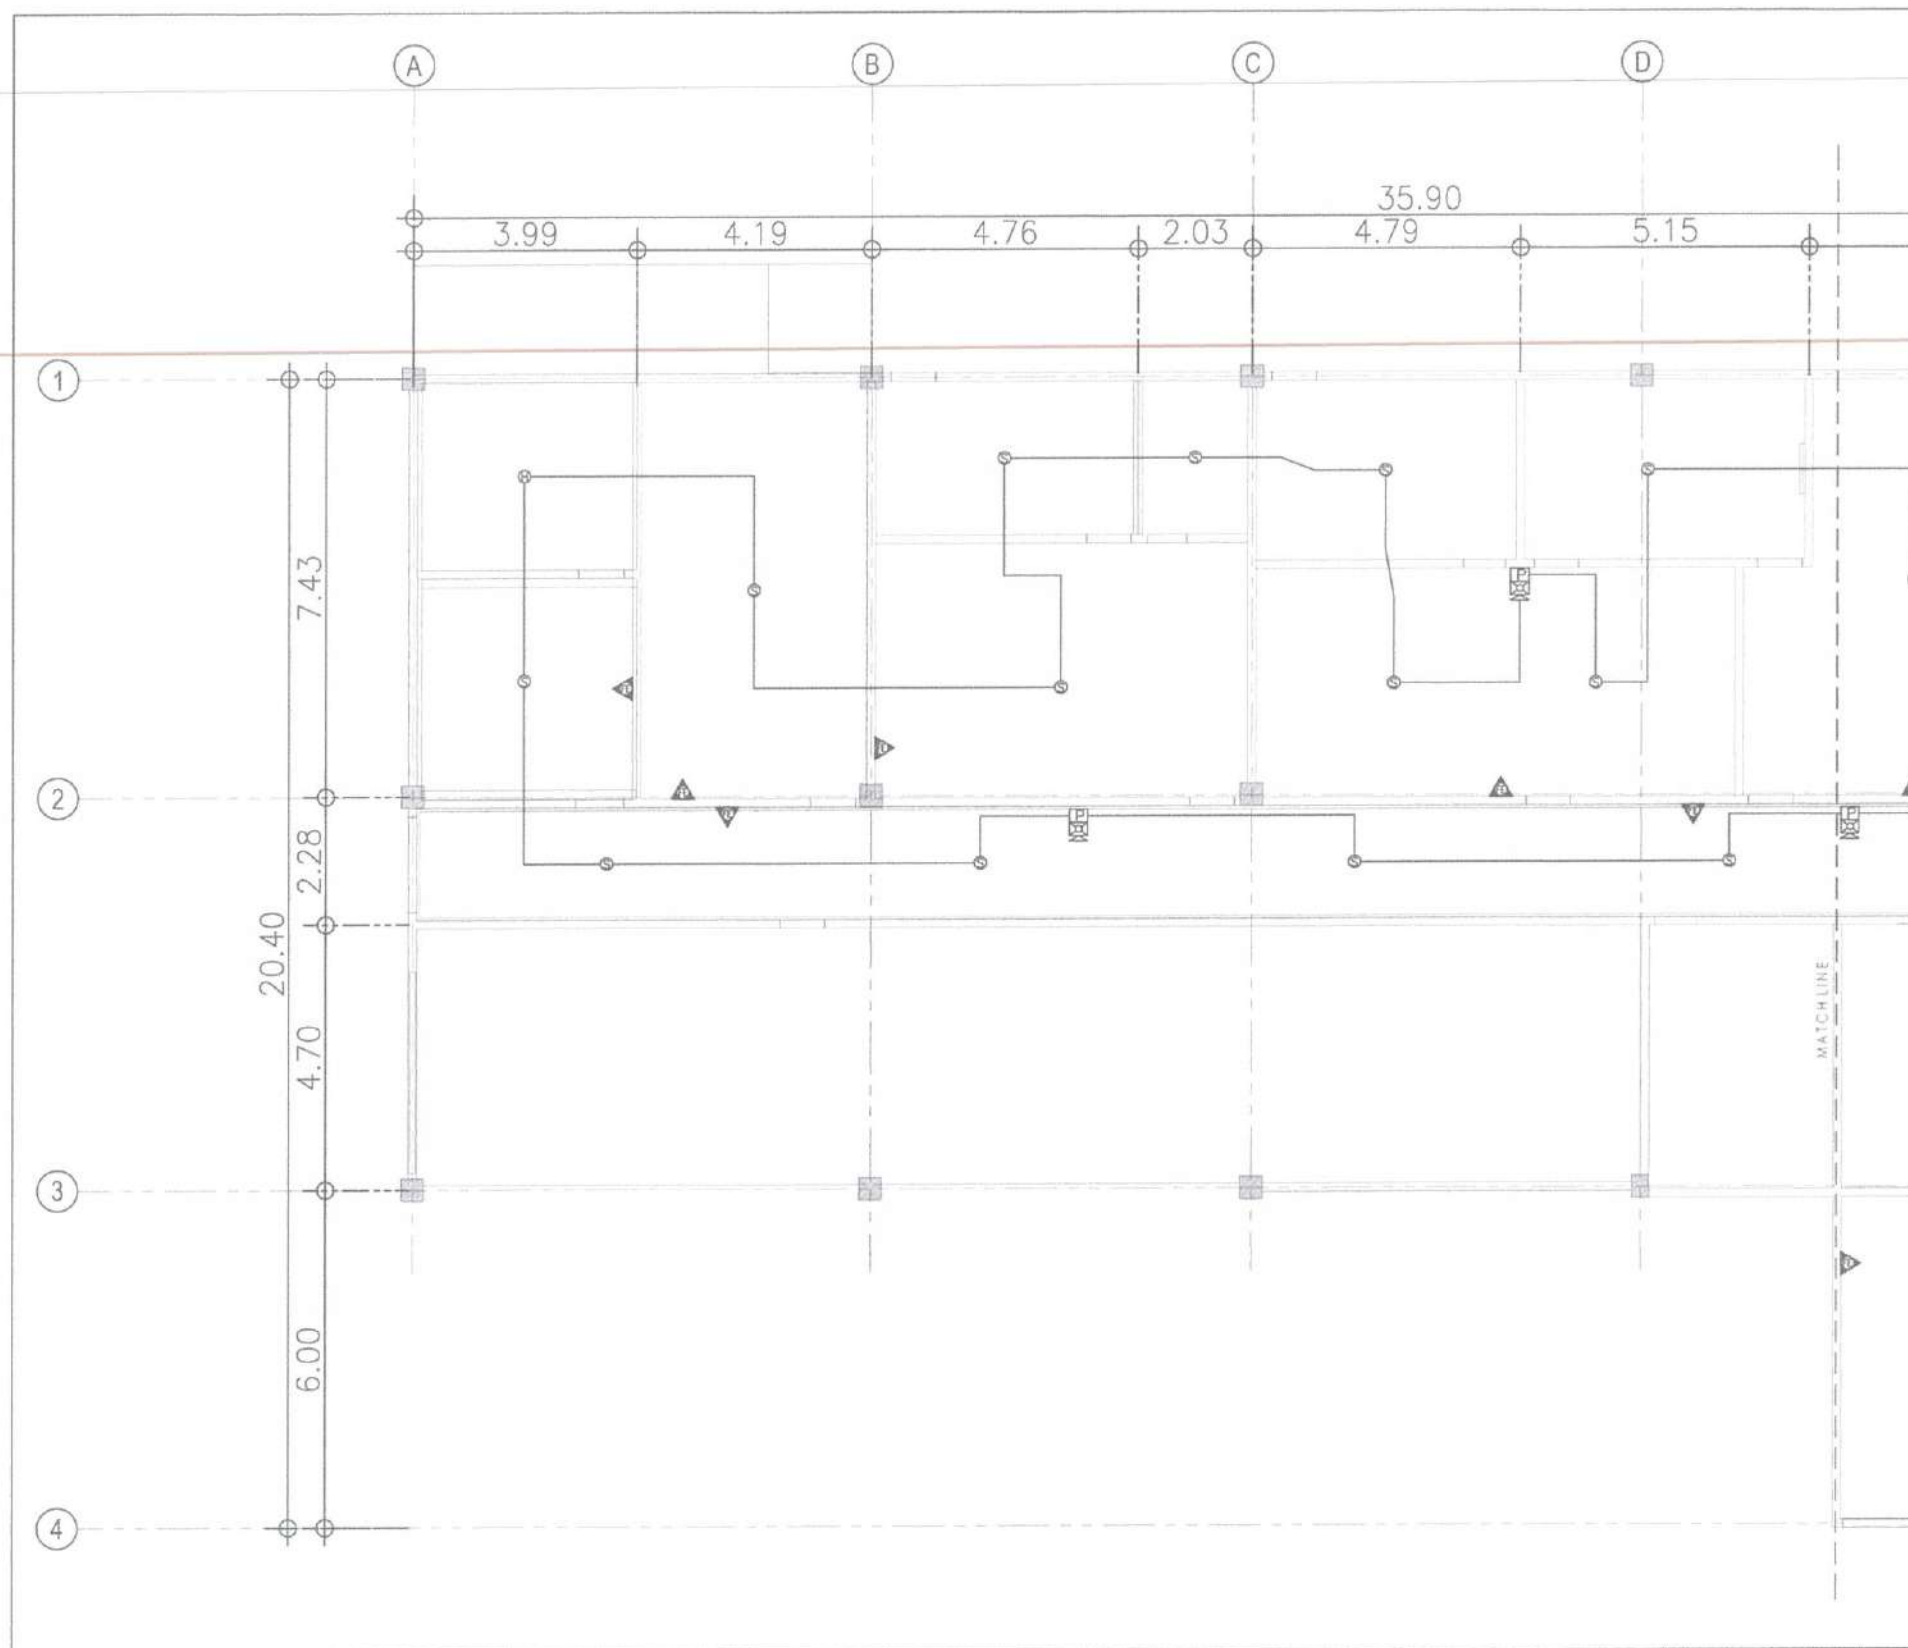

1
 E 18
 PARTIAL GROUND FLOOR
FDAS LAYOUT PLAN
 SCALE: 1:75M



CIVIL AVIATION AUTHORITY OF THE PHILIPPINES

THIS DRAWINGS AND DESIGN IS EXCLUSIVE PROPERTIES OF CIVIL AVIATION AUTHORITY OF THE PHILIPPINES AND MUST NOT BE REPRODUCED, EXHIBITED, LOANED, NOR COPIED IN PART OR IN WHOLE WITHOUT PROPER PERMISSION AND/OR WRITTEN CONSENT FROM THE DIRECTOR GENERAL CAAP.

AERODROME DEVELOPMENT AND MANAGEMENT SERVICE

INFRASTRUCTURE DEVELOPMENT AND DESIGN DIVISION

DESIGN STAFF	INITIAL / DATE
DESIGNED BY: RMD	
DRAWN BY: JPCJR	
CHECKED BY: RUAJR	

REVIEWED BY:

RAUL R. ARUCENA
 Division Chief III, AED-ADMS

SUBMITTED BY:

 ARNEL F. BORLADO
 Department Manager III, AED-ADMS

RECOMMENDED APPROVAL

 LT COL. VALENTINO A. DIONELA PAF RET
 Assistant Director General II, ADMS

APPROVED:

 CAPTAIN MANUEL ANTONIO L. TAMAYO
 Director General


NOTES/REVISIONS:

PROJECT:
 IMPROVEMENT/REHABILITATION
 OF AIRWAYS FACILITY COMPLEX
 BUILDING

LOCATION:
 CAAP CENTRAL OFFICE
 NAIA ROAD COR. N. AQUINO AVE,
 PASAY CITY

SHEET CONTENTS:
 PARTIAL GROUND FLOOR
 FIRE DETECTION AND
 ALARM SYSTEM LAYOUT
 PLAN

DRAWING SCALE	SHEET NO.
AS SHOWN	E-18

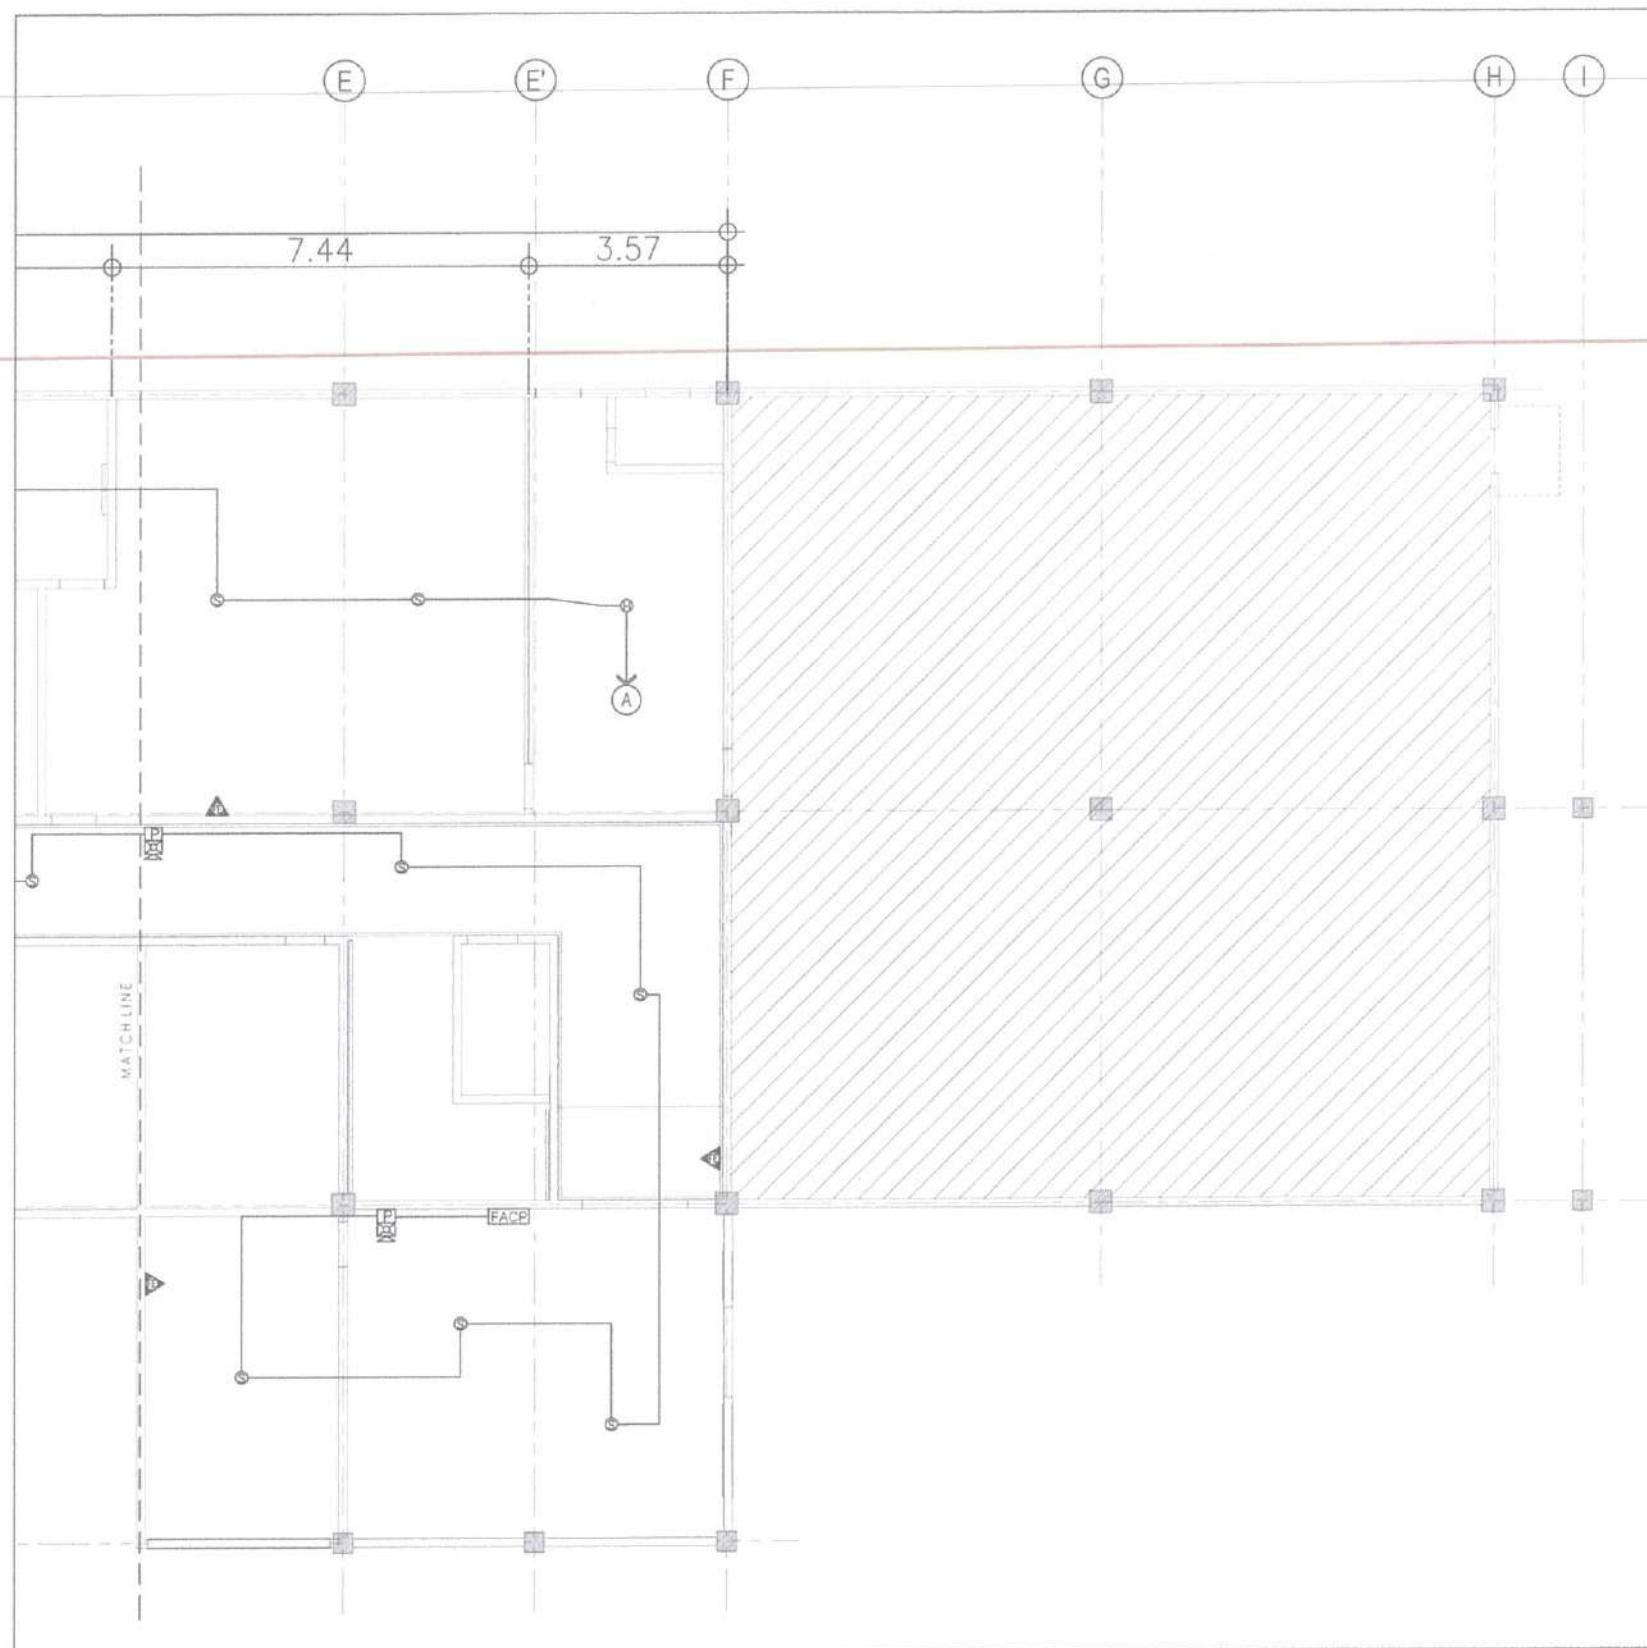

1
E 19
PARTIAL GROUND FLOOR
FDAS LAYOUT PLAN
SCALE: 1:75M



CIVIL AVIATION AUTHORITY OF THE PHILIPPINES
REPUBLIC OF THE PHILIPPINES

THIS DRAWINGS AND DESIGN IS
EXCLUSIVE PROPERTIES OF CIVIL AVIATION
AUTHORITY OF THE PHILIPPINES AND MUST
NOT BE REPRODUCED, EXHIBITED, LOANED
NOR COPIED IN PART OR IN WHOLE WITHOUT
PROPER PERMISSION AND/OR WRITTEN
CONSENT FROM THE DIRECTOR GENERAL
CAAP

AERODROME DEVELOPMENT AND
MANAGEMENT SERVICE

INFRASTRUCTURE DEVELOPMENT
AND DESIGN DIVISION

DESIGN STAFF	INITIAL / DATE
DESIGNED BY	RMD
DRAWN BY	JPCJR
CHECKED BY	RUAJR

REVIEWED BY:

[Signature]
RAUL R. CRUCENA
Division Chief III, IDDD - ADMS

SUBMITTED BY:

[Signature]
ARNEL F. BORLADO
Department Manager III, AED-ADMS

RECOMMENDED APPROVAL:

[Signature]
LT COL VALENTINO M. MONELA PAF RET
Assistant Chief, General II, ADMS

APPROVED:

CAPTAIN MANUEL ANTONIO L. TAMAYO
Director General

NOTES/REVISIONS:

PROJECT:

IMPROVEMENT/REHABILITATION
OF AIRWAYS FACILITY COMPLEX
BUILDING


LOCATION:

CAAP CENTRAL OFFICE
NAIA ROAD COR. N. AQUINO AVE.,
PASAY CITY

SHEET CONTENTS:

PARTIAL GROUND FLOOR
FIRE DETECTION AND
ALARM SYSTEM LAYOUT
PLAN

DRAWING SCALE	SHEET NO.
AS SHOWN	E-19

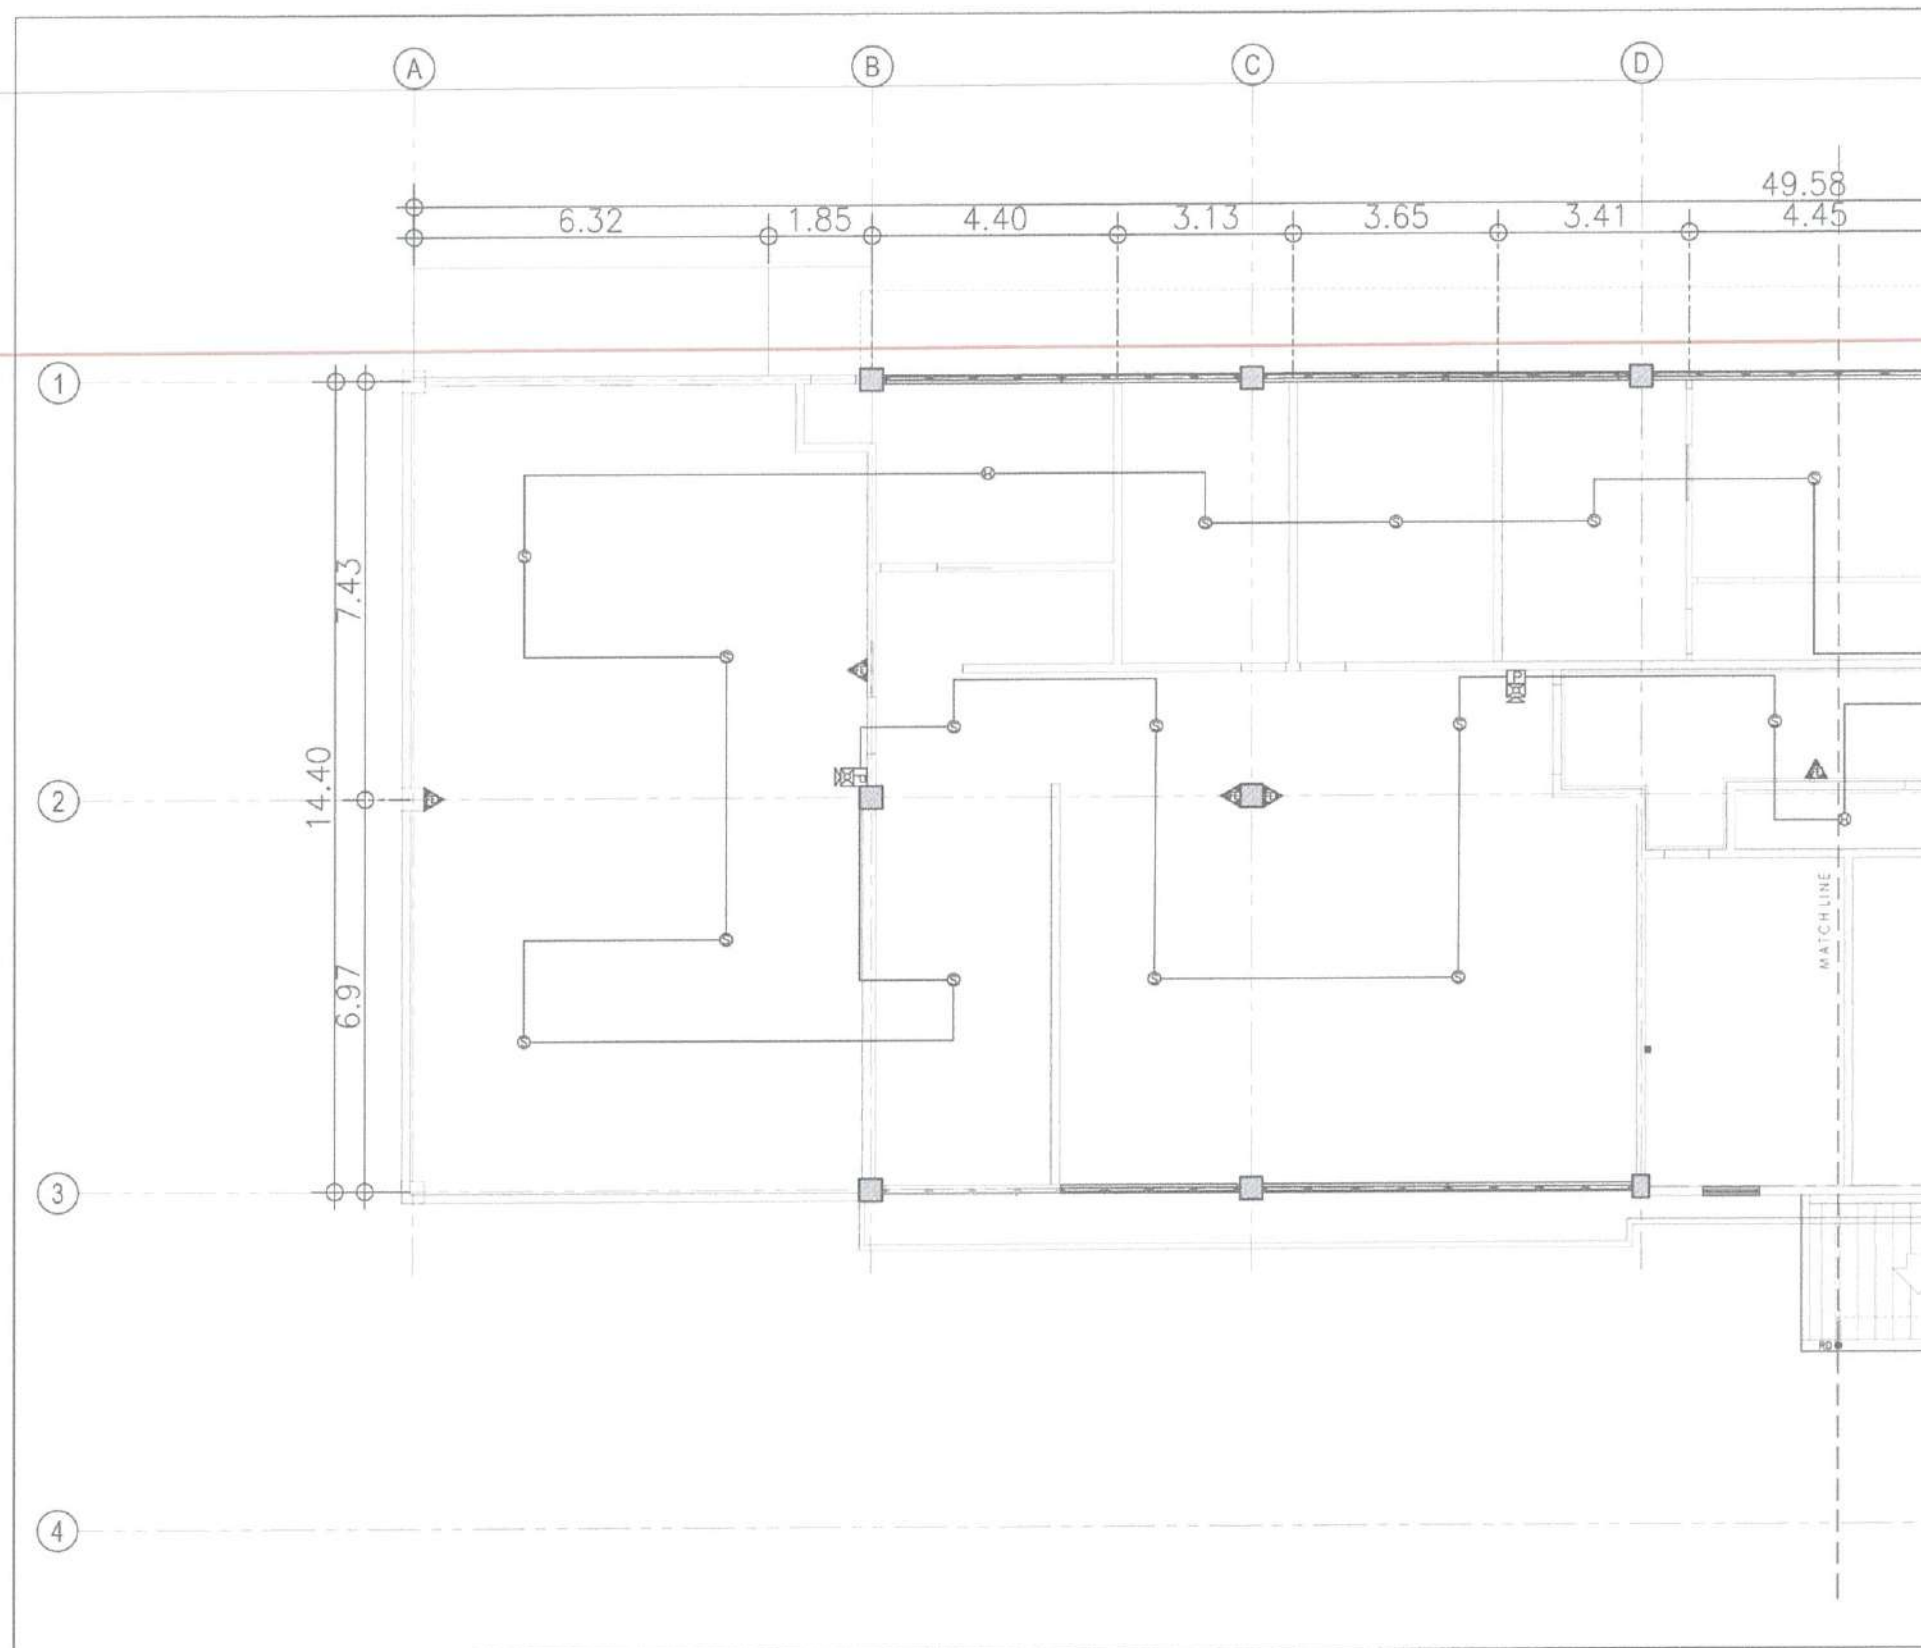

1
E 20
PARTIAL SECOND FLOOR
FDAS LAYOUT PLAN
SCALE: 1:75M



CIVIL AVIATION AUTHORITY OF THE PHILIPPINES
BAGONG PILIPINAS

THIS DRAWINGS AND DESIGN IS EXCLUSIVE PROPERTIES OF CIVIL AVIATION AUTHORITY OF THE PHILIPPINES AND MUST NOT BE REPRODUCED, EXHIBITED, LOANED, NOR COPIED IN PART OR IN WHOLE WITHOUT PROPER PERMISSION AND/OR WRITTEN CONSENT FROM THE DIRECTOR GENERAL CAAP.

AERODROME DEVELOPMENT AND MANAGEMENT SERVICE

INFRASTRUCTURE DEVELOPMENT AND DESIGN DIVISION

DESIGN STAFF	INITIAL / DATE
DESIGNED BY: RMD	
DRAWN BY: JPCJR	
CHECKED BY: RUJUR	

REVIEWED BY:

RAUL F. CRUCENA
Division Chief III, DDD - ADMS

SUBMITTED BY:

ARNEL F. BORLADO
Department Manager III, AED-ADMS

RECOMMENDED APPROVAL:

LT COL. VALENTINO A. DIONELA PAF RET.
Assistant Director General II, ADMS

APPROVED:

CAPTAIN MANUEL M. L. TAMAYO
Director General


NOTES/REVISIONS:

PROJECT:
IMPROVEMENT/REHABILITATION OF AIRWAYS FACILITY COMPLEX BUILDING

LOCATION:
CAAP CENTRAL OFFICE
NAIA ROAD COR. N. AQUINO AVE,
PASAY CITY

SHEET CONTENTS:
PARTIAL SECOND FLOOR
FIRE DETECTION AND
ALARM SYSTEM LAYOUT
PLAN

DRAWING SCALE	SHEET NO.
AS SHOWN	E-20

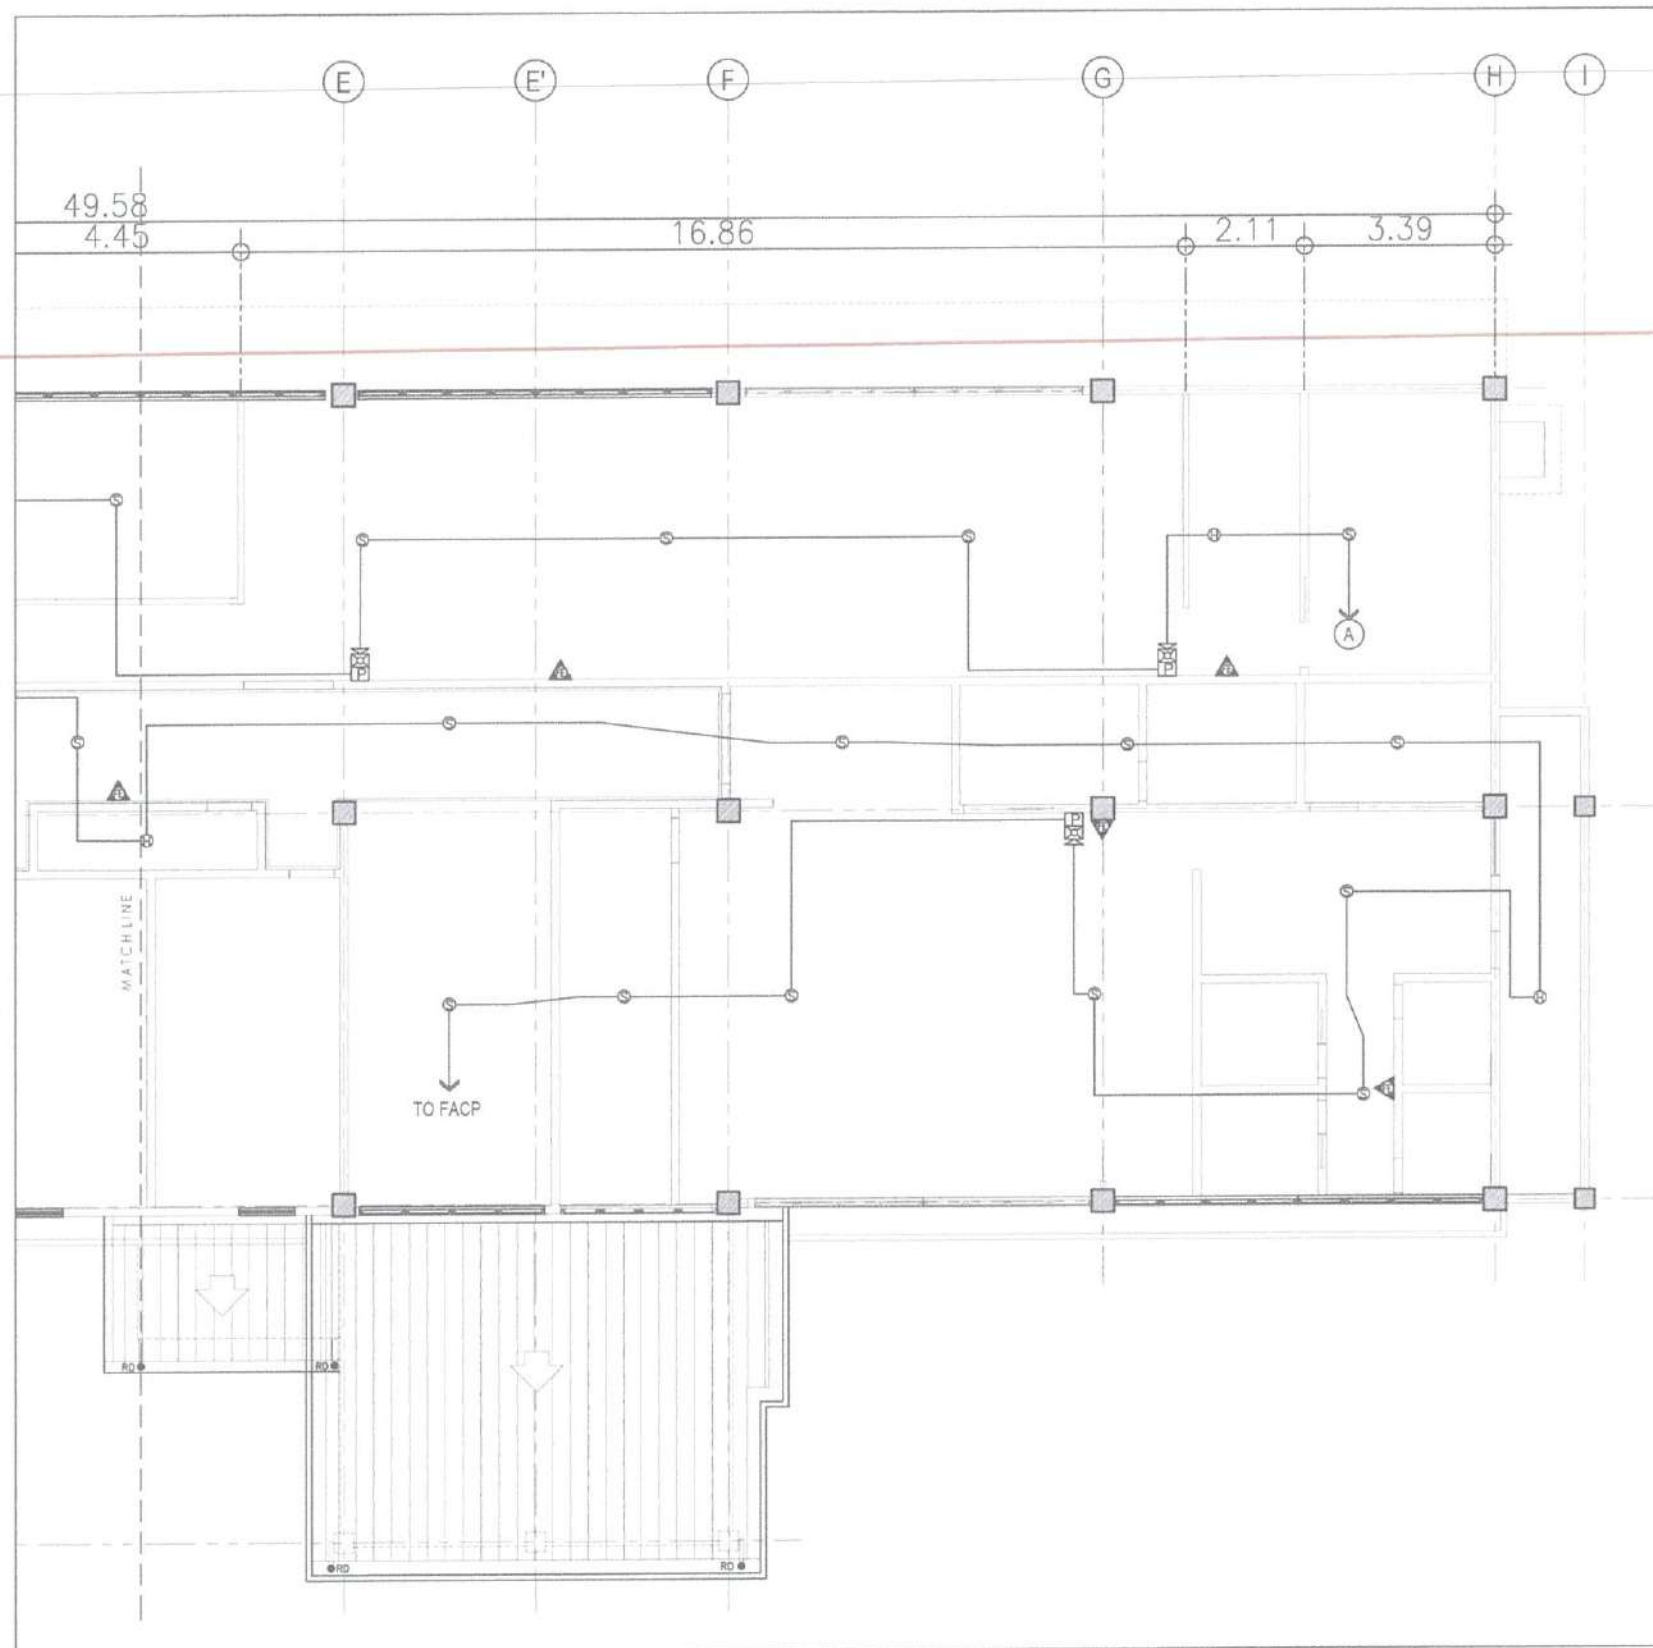

1
E 21
PARTIAL SECOND FLOOR
FDAS LAYOUT PLAN
SCALE: 1:75M



CIVIL AVIATION AUTHORITY OF THE PHILIPPINES
1000 N. A. ROAD, PASAY CITY

THIS DRAWING AND DESIGN IS
EXCLUSIVE PROPERTY OF CIVIL AVIATION
AUTHORITY OF THE PHILIPPINES AND MUST
NOT BE REPRODUCED, EXHIBITED, LOANED
NOR COPIED IN PART OR IN WHOLE WITHOUT
PROPER PERMISSION AND/OR WRITTEN
CONSENT FROM THE DIRECTOR GENERAL
CAAP.

AERODROME DEVELOPMENT AND
MANAGEMENT SERVICE

INFRASTRUCTURE DEVELOPMENT
AND DESIGN DIVISION

DESIGN STAFF	INITIAL / DATE
DESIGNED BY: RMD	
DRAWN BY: JPCJR	
CHECKED BY: RUAJR	

REVIEWED BY:

[Signature]
RABL R. CRUCENA
Division Chief III, ADD - ADMS

SUBMITTED BY:
[Signature]
ARNEL F. BORLADO
Department Manager III, AED-ADMS

RECOMMENDED APPROVAL
[Signature]
LT COL VALERINO A. QIONELA PAF RET
Assistant Director General II, ADMS

APPROVED:
[Signature]
CAPTAIN MARCEL ANTONIO L. TAMAYO
Director General

NOTES/REVISIONS:

PROJECT:
IMPROVEMENT/REHABILITATION
OF AIRWAYS FACILITY COMPLEX
BUILDING

LOCATION:
CAAP CENTRAL OFFICE
NAIA ROAD COR. N. AQUINO AVE,
PASAY CITY

SHEET CONTENTS:
PARTIAL SECOND FLOOR
FIRE DETECTION AND
ALARM SYSTEM LAYOUT
PLAN

DRAWING SCALE	SHEET NO.
AS SHOWN	E-21

LEGEND:



AIR COOLED CONDENSING UNIT (INVERTER OUTDOOR UNIT, VER. SPECS) CAPITAL LETTER ON RECTANGLE DENOTES FCU CONTROLLED AND EQUIPMENT TAG NUMBER INDICATES TYPE OF ACCU.



FAN COIL UNIT (INDOOR UNIT, VER. SPECS) CAPITAL LETTER ON SQUARE CORRESPONDS TO THE ACCU AND EQUIPMENT TAG NUMBER INDICATES TYPE OF FCU.

PIPE GOING DOWN

PIPE GOING UP



REPUBLIC OF THE PHILIPPINES

CIVIL AVIATION AUTHORITY OF THE PHILIPPINES
AERODROME DEVELOPMENT AND MANAGEMENT SERVICE
NAIA RD. 1385 PASAY CITY

THIS DRAWINGS AND DESIGN IS EXCLUSIVE PROPERTY OF CIVIL AVIATION AUTHORITY OF THE PHILIPPINES AND SUCH MUST NOT BE REPRODUCED, EXHIBITED, LOANED NOR COPIED IN PART OR IN WHOLE WITHOUT PROPER PERMISSION AND/OR WRITTEN CONSENT FROM THE DIRECTOR GENERAL CAAP.

AERODROME DEVELOPMENT AND MANAGEMENT SERVICE

INFRASTRUCTURE DEVELOPMENT AND DESIGN DIVISION

DESIGN STAFF: INITIAL / DATE
DESIGNED BY: IDDD
DRAWN BY: JCMC
CHECKED BY: RUAR

REVIEWED BY:
RAUL R. CRUCENA
Division Chief III, IDDD-AED

SUBMITTED BY:
ARNEL F. BORLADO
Department Manager III, AED-ADMS

RECOMMEND APPROVAL:
LT COL VALENTINO A. DIONELA PAF (RET)
Assistant Director General II, ADMS

APPROVED BY:
CAPTAIN MANUEL ANDONIO L. TAMAYO
Director General


NOTES/REVISIONS:

PROJECT:
IMPROVEMENT/REHABILITATION OF AIRWAYS FACILITY COMPLEX BUILDING

LOCATION:
CAAP CENTRAL OFFICE
NAIA RD. COR. N. AQUINO AVENUE,
PASAY CITY

SHEET CONTENTS:
GROUND FLOOR
AIR-CONDITIONING LAYOUT

DRAWING SCALE: AS SHOWN
SHEET NO.: M - 01
01

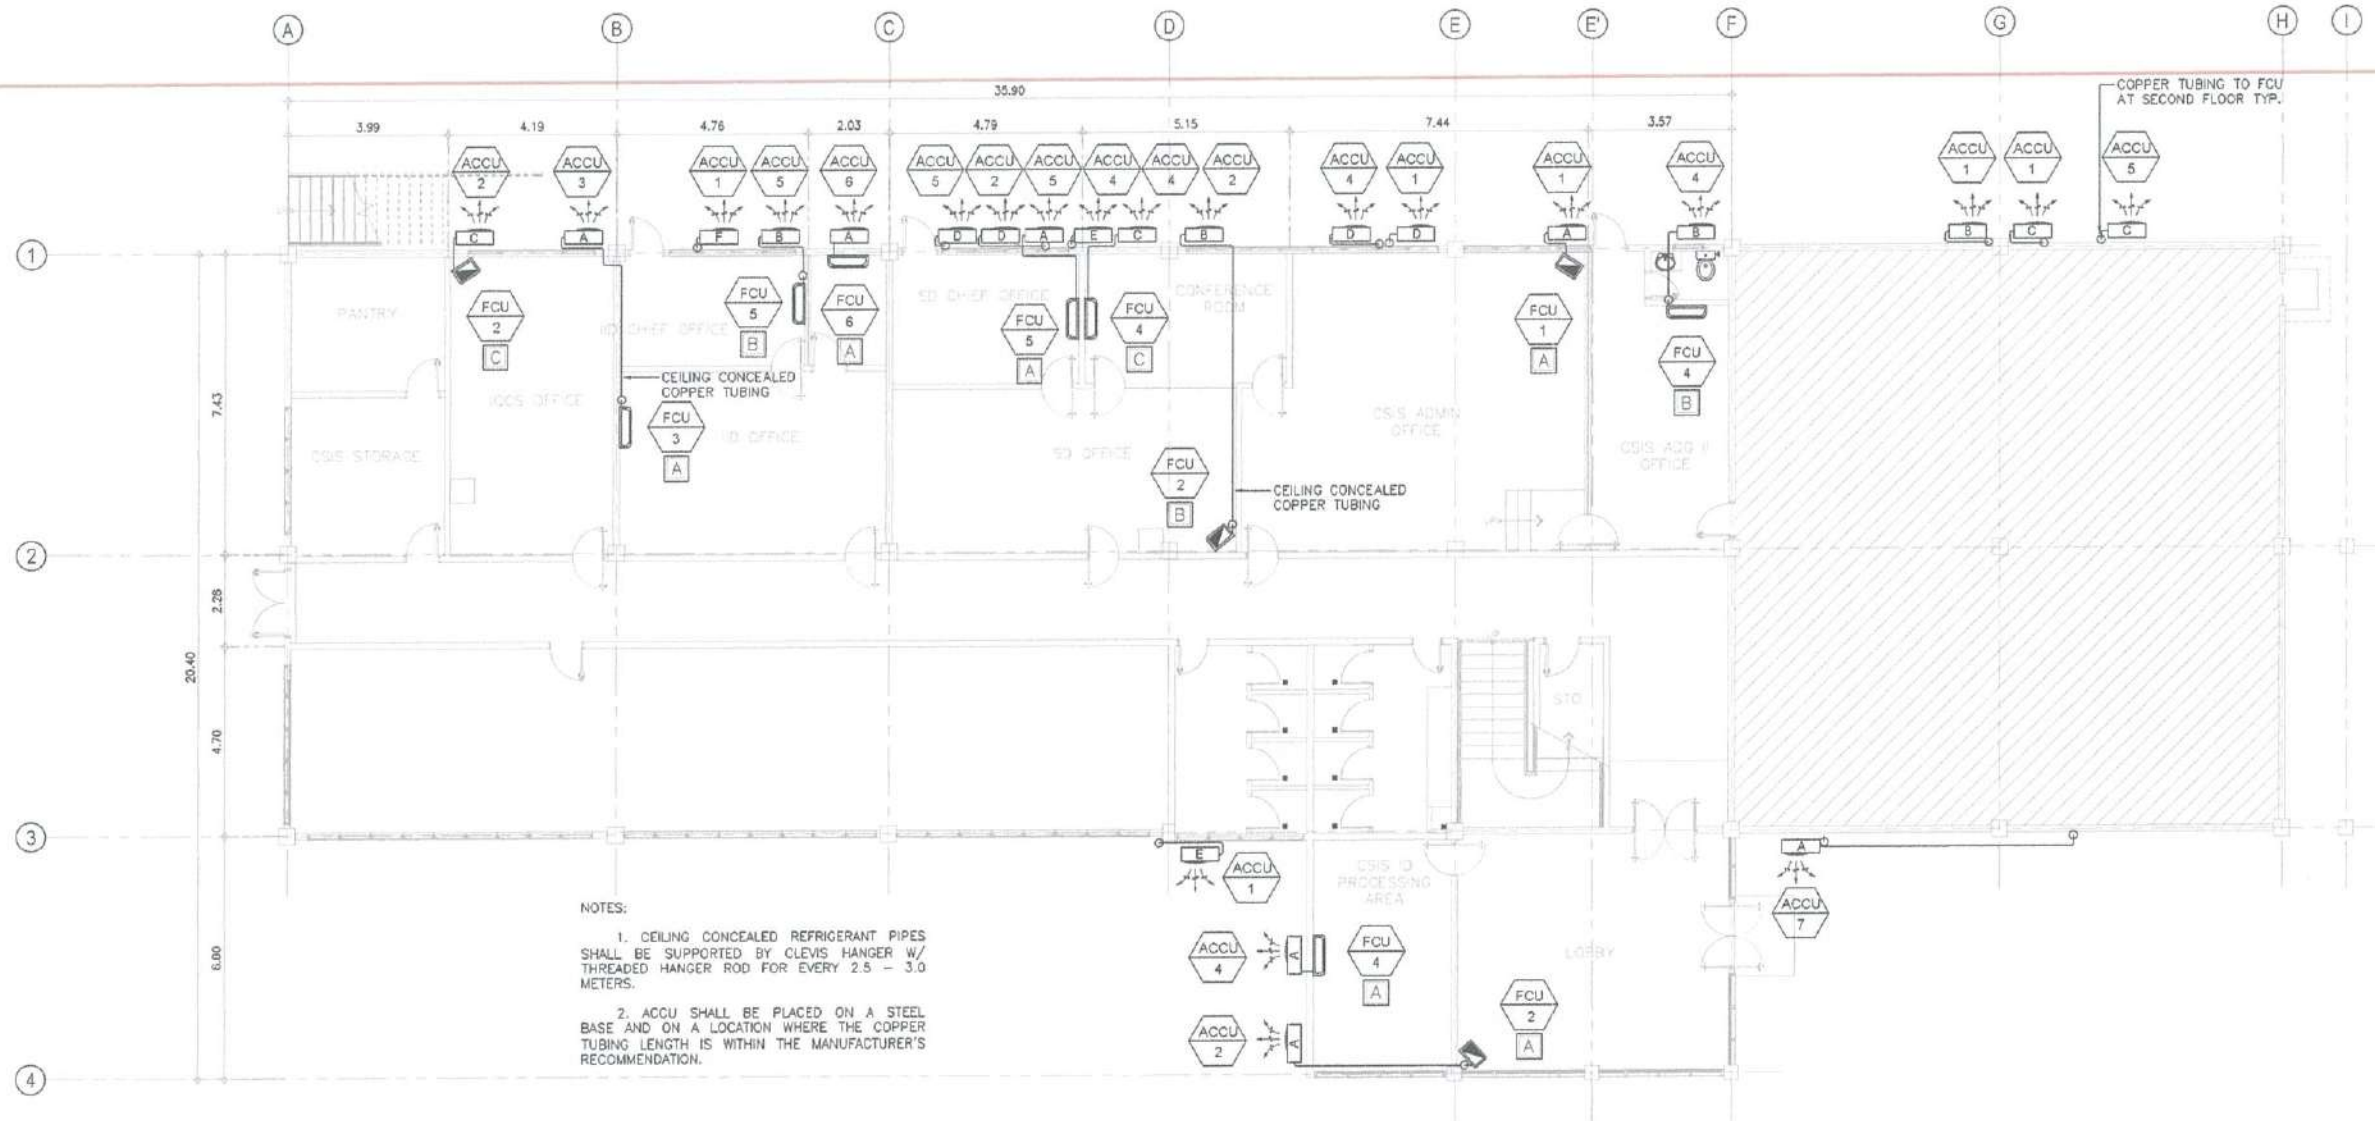

- NOTES:
1. CEILING CONCEALED REFRIGERANT PIPES SHALL BE SUPPORTED BY CLEVIS HANGER W/ THREADED HANGER ROD FOR EVERY 2.5 - 3.0 METERS.
 2. ACCU SHALL BE PLACED ON A STEEL BASE AND ON A LOCATION WHERE THE COPPER TUBING LENGTH IS WITHIN THE MANUFACTURER'S RECOMMENDATION.

1

GROUND FLOOR AIR-CONDITIONING LAYOUT

M-01/M-01 SCALE:

1:100 M

LEGEND:



AIR COOLED CONDENSING UNIT (INVERTER OUTDOOR UNIT, VER. SPECS) CAPITAL LETTER ON RECTANGLE DENOTES FCU CONTROLLED AND EQUIPMENT TAG NUMBER INDICATES TYPE OF ACCU.



FAN COIL UNIT (INDOOR UNIT, VER. SPECS) CAPITAL LETTER ON SQUARE CORRESPONDS TO THE ACCU AND EQUIPMENT TAG NUMBER INDICATES TYPE OF FCU.

— PIPE GOING DOWN

— PIPE GOING UP



REPUBLIC OF THE PHILIPPINES

CIVIL AVIATION AUTHORITY OF THE PHILIPPINES
AERODROME DEVELOPMENT AND MANAGEMENT SERVICE
NAIA RD. COR. N. PASAY CITY

THIS DRAWINGS AND DESIGN IS EXCLUSIVE PROPERTY OF CIVIL AVIATION AUTHORITY OF THE PHILIPPINES AND SUCH MUST NOT BE REPRODUCED, EXHIBITED, LOANED NOR COPIED IN PART OR IN WHOLE WITHOUT PROPER PERMISSION AND/OR WRITTEN CONSENT FROM THE DIRECTOR GENERAL CAAP.

AERODROME DEVELOPMENT AND MANAGEMENT SERVICE

INFRASTRUCTURE DEVELOPMENT AND DESIGN DIVISION

DESIGN STAFF: INITIAL / DATE

DESIGNED BY: IDDD

DRAWN BY: JCMG

CHECKED BY: RUAJR

REVIEWED BY:

RAFAEL CRUCENA
Division Chief, IDDD-AED

SUBMITTED BY:

ARNEL F. BORLADO
Department Manager II, AED-ADMS

RECOMMEND APPROVAL:

LT COL VALENTINO A. DIONELA PAF (RET)
Assistant Director General II, ADMS

APPROVED BY:

CAPTAIN MANUEL A. DIONELA L. TAMAYO
Director General

NOTES/REVISIONS:

PROJECT:

IMPROVEMENT/REHABILITATION OF AIRWAYS FACILITY COMPLEX BUILDING

LOCATION:

CAAP CENTRAL OFFICE
NAIA RD. COR. N. AQUINO AVENUE,
PASAY CITY

SHEET CONTENTS:

SECOND FLOOR
AIR-CONDITIONING LAYOUT


DRAWING SCALE:

AS SHOWN

SHEET NO.:

M - 02

02

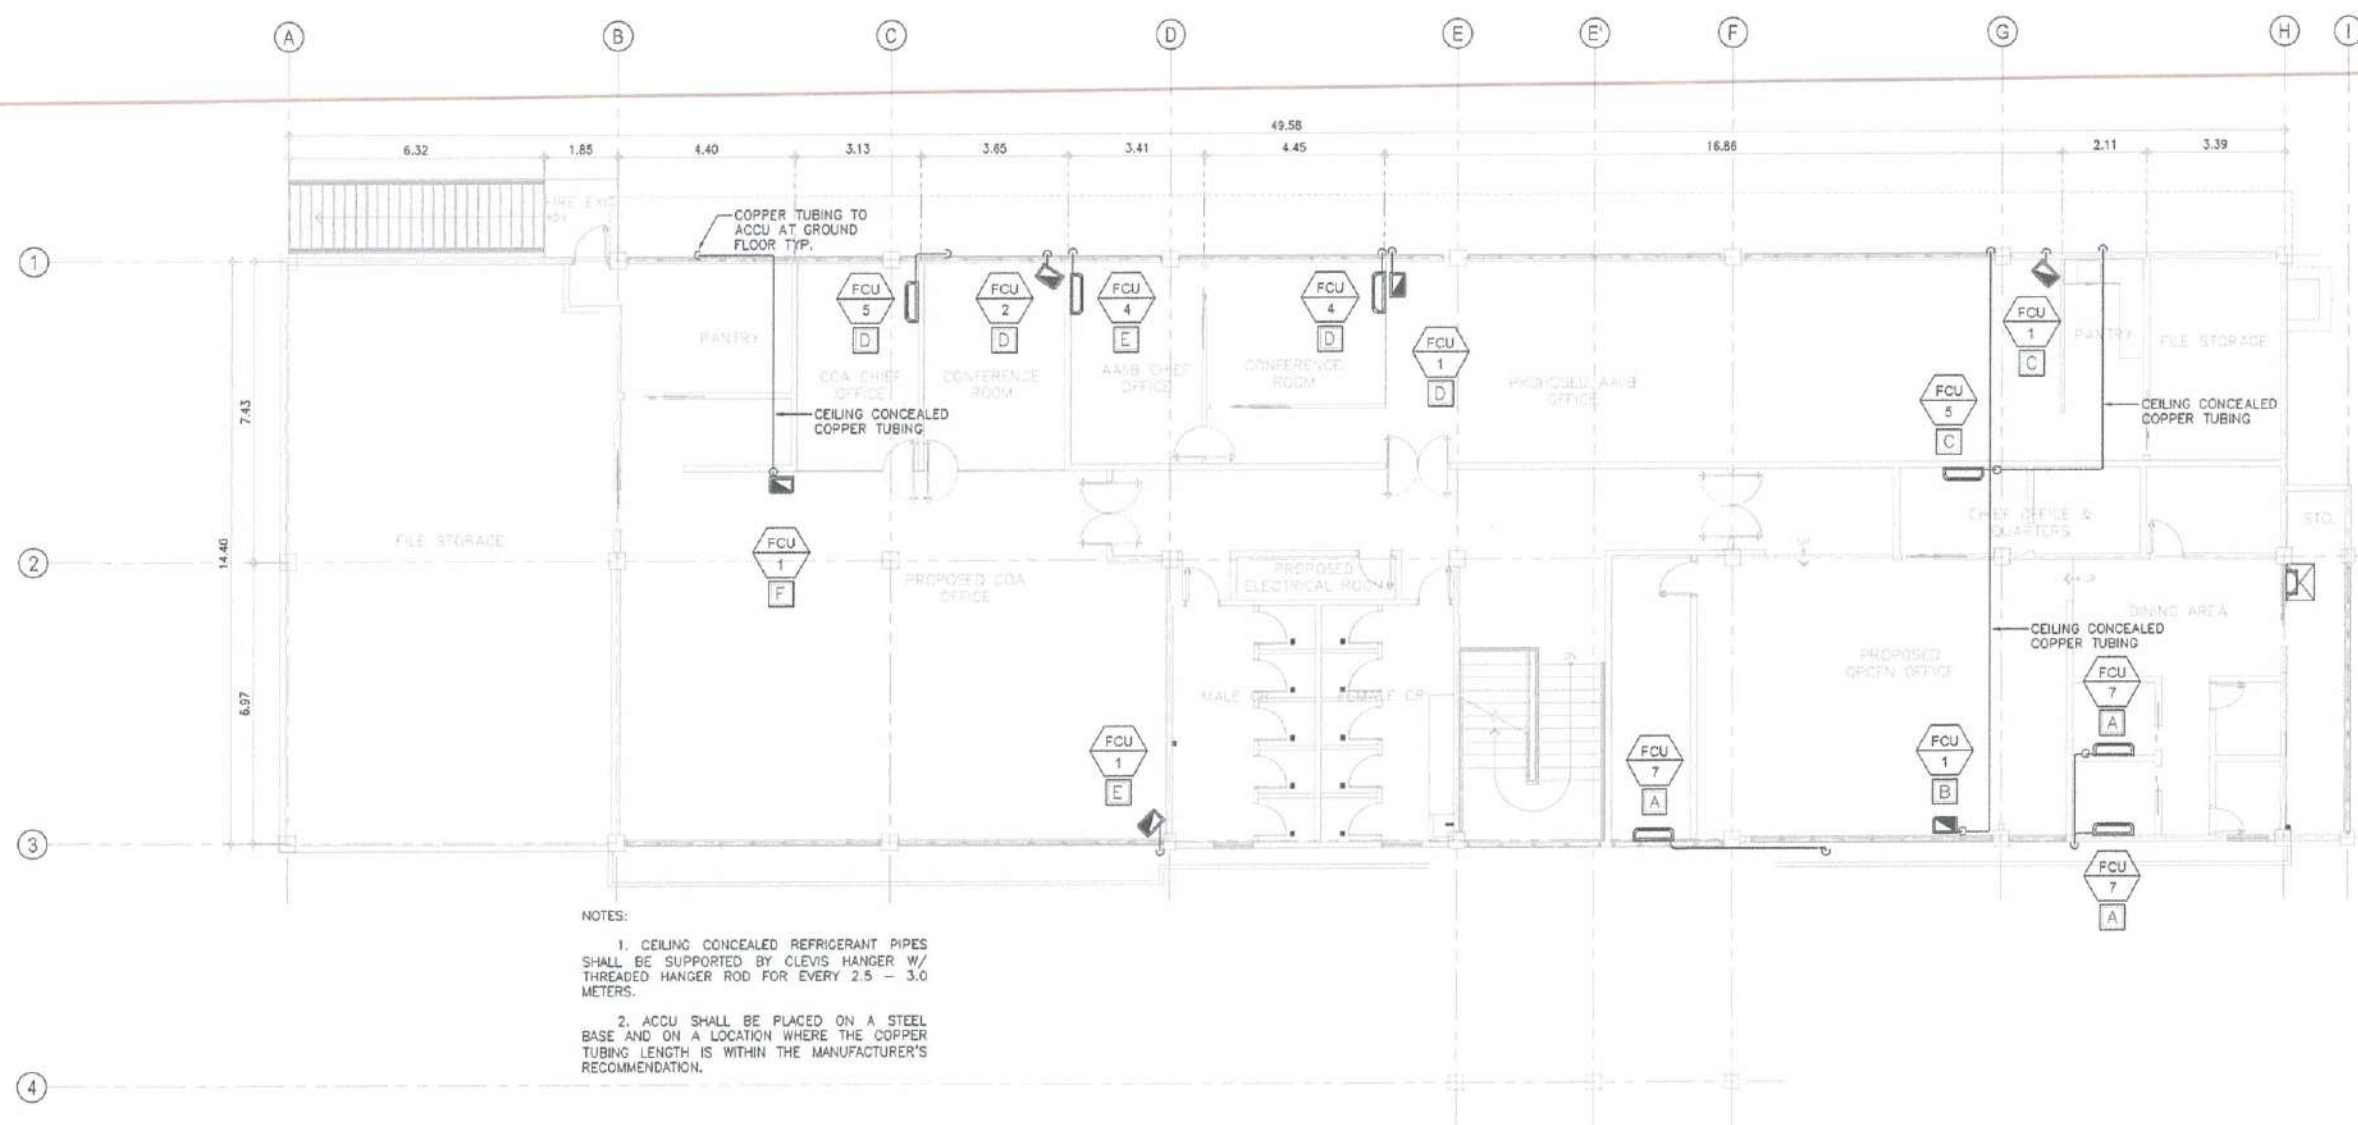

NOTES:

1. CEILING CONCEALED REFRIGERANT PIPES SHALL BE SUPPORTED BY CLEVIS HANGER W/ THREADED HANGER ROD FOR EVERY 2.5 - 3.0 METERS.

2. ACCU SHALL BE PLACED ON A STEEL BASE AND ON A LOCATION WHERE THE COPPER TUBING LENGTH IS WITHIN THE MANUFACTURER'S RECOMMENDATION.



SECOND FLOOR AIR-CONDITIONING LAYOUT

SCALE:

1:100 M

LEGEND:

- PIPE GOING DOWN
 - - - - EMBEDDED CONDENSATE DRAIN PIPE



REPUBLIC OF THE PHILIPPINES
 CIVIL AVIATION AUTHORITY OF THE PHILIPPINES
 AERODROME DEVELOPMENT AND MANAGEMENT SERVICE
 NAIA ROAD, 1305 PASAY CITY

THIS DRAWINGS AND DESIGN IS EXCLUSIVE PROPERTIES OF CIVIL AVIATION AUTHORITY OF THE PHILIPPINES AND SUCH MUST NOT BE REPRODUCED, EXHIBITED, LOANED NOR COPIED IN PART OR IN WHOLE WITHOUT PROPER PERMISSION AND/OR WRITTEN CONSENT FROM THE DIRECTOR GENERAL, CAAP.

AERODROME DEVELOPMENT AND MANAGEMENT SERVICE

INFRASTRUCTURE DEVELOPMENT AND DESIGN DIVISION

DESIGN STAFF: INITIAL / DATE
 DESIGNED BY: IDDD
 DRAWN BY: JCMC
 CHECKED BY: RUAJR

REVIEWED BY:
 RAUL R. ORCENA
 Division Chief III, IDDD-AED

SUBMITTED BY:
 ARNEL F. BORLADO
 Department Manager III, AED-ADMS

RECOMMEND APPROVAL:
 LT COL VALENTINO A. DIONELA PAF (RET)
 Assistant Director General II, ADMS

APPROVED BY:
 CAPTAIN MARIE ANTONIO L. TAMAYO
 Director General


NOTES/REVISIONS:

PROJECT:
 IMPROVEMENT/REHABILITATION OF AIRWAYS FACILITY COMPLEX BUILDING

LOCATION:
 CAAP CENTRAL OFFICE
 NAIA RD. COR. N. AQUINO AVENUE,
 PASAY CITY

SHEET CONTENTS:
 GROUND FLOOR ACU
 CONDENSATE DRAIN PIPE
 LAYOUT

DRAWING SCALE: AS SHOWN
 SHEET NO.: M - 03

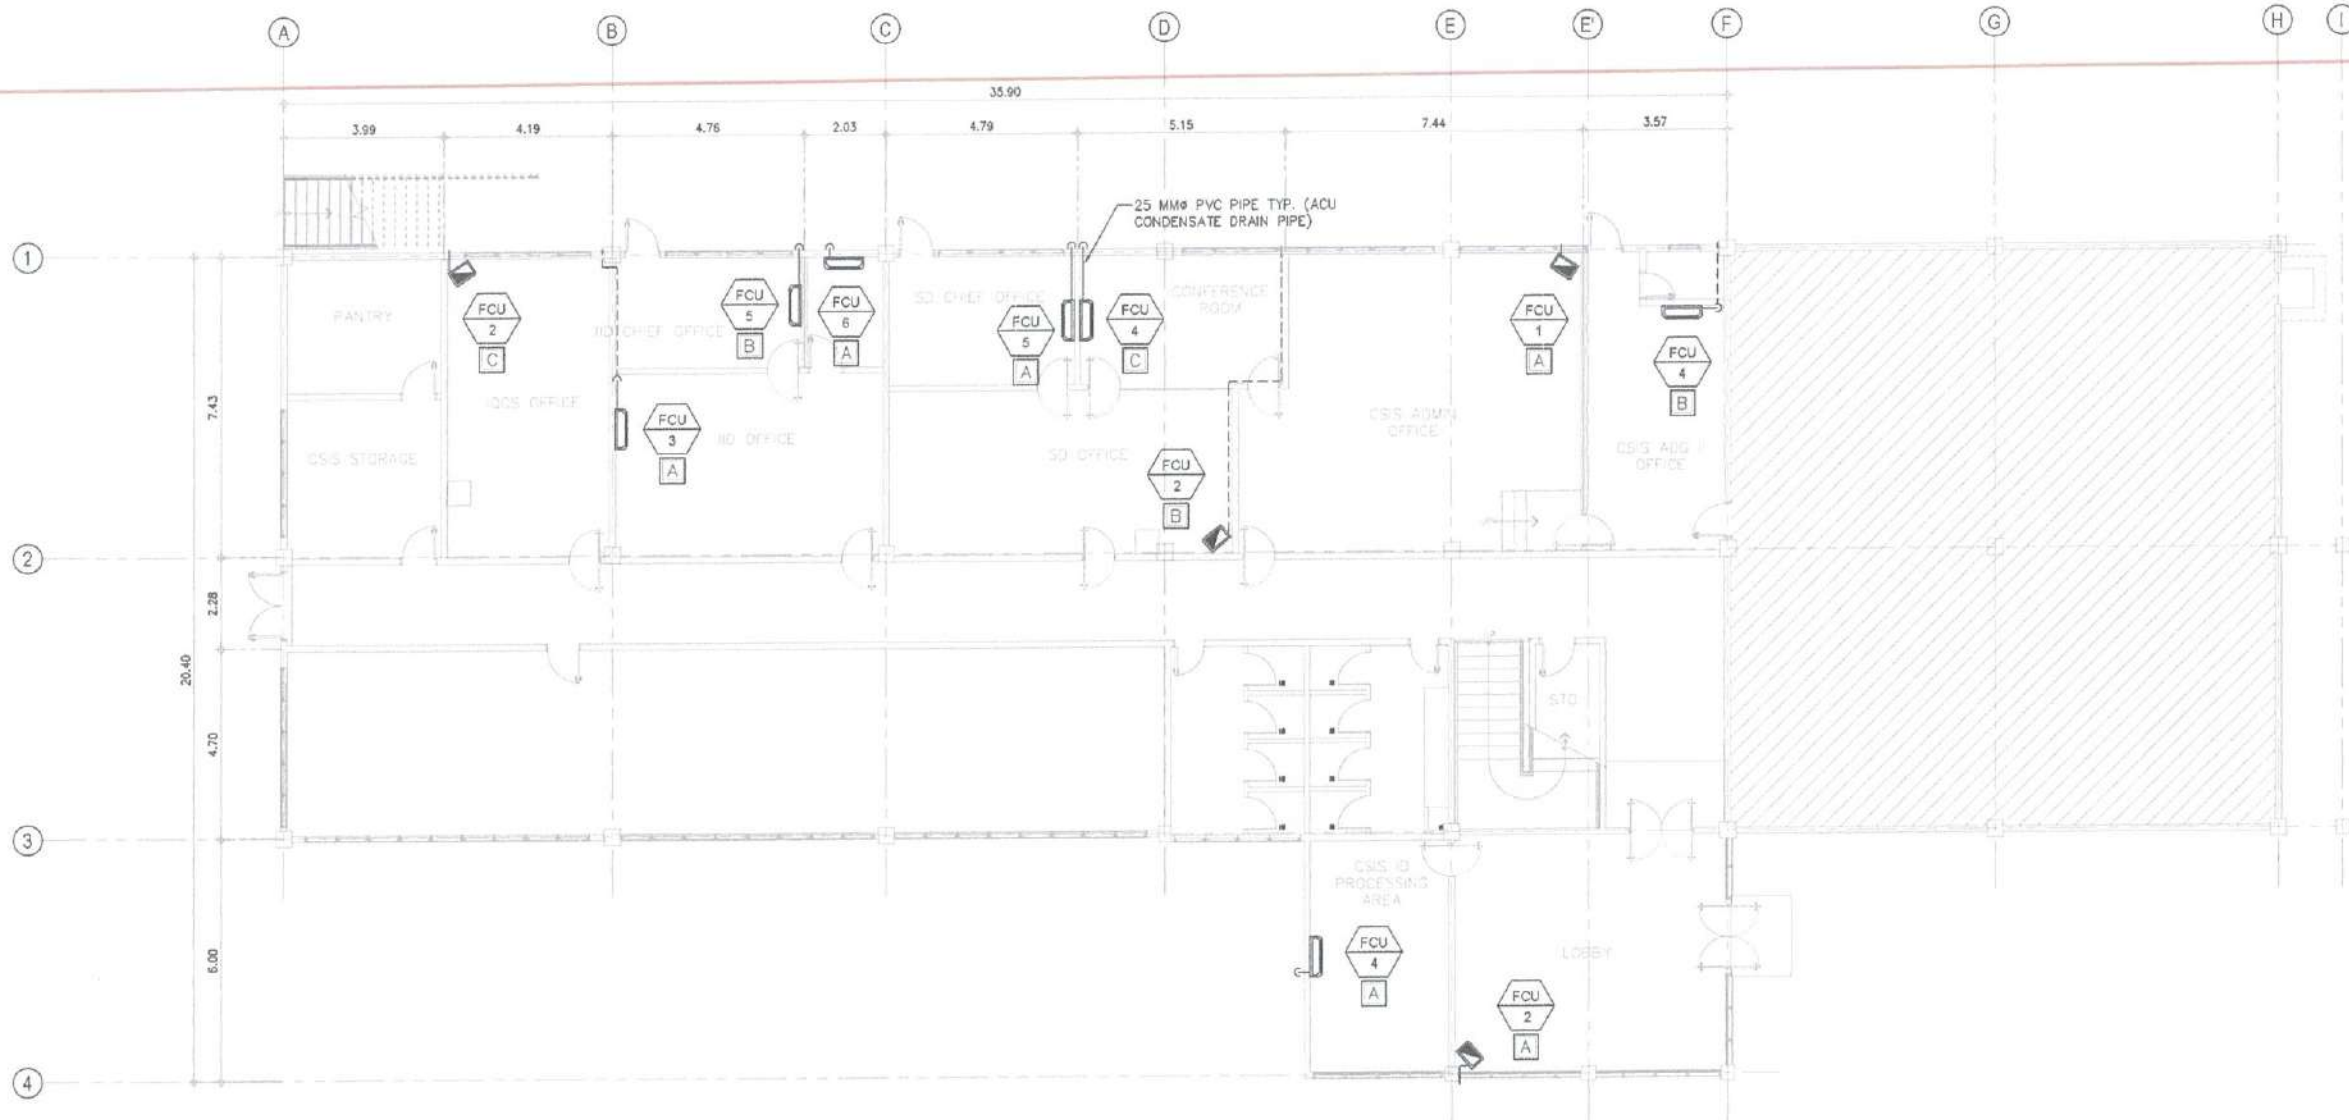

1 GROUND FLOOR ACU CONDENSATE DRAIN PIPE LAYOUT
 M-03M-03 SCALE: 1:100 M

LEGEND:

— PIPE GOING DOWN
 - - - - EMBEDDED CONDENSATE DRAIN PIPE



REPUBLIC OF THE PHILIPPINES
 CIVIL AVIATION AUTHORITY OF THE PHILIPPINES
 AERODROME DEVELOPMENT AND MANAGEMENT SERVICE
 NAIA ROAD, 1300 PASAY CITY

THIS DRAWINGS AND DESIGN IS EXCLUSIVE PROPERTIES OF CIVIL AVIATION AUTHORITY OF THE PHILIPPINES AND SUCH MUST NOT BE REPRODUCED, EXHIBITED, LOANED NOR COPIED IN PART OR IN WHOLE WITHOUT PROPER PERMISSION AND/OR WRITTEN CONSENT FROM THE DIRECTOR GENERAL CAAP.

AERODROME DEVELOPMENT AND MANAGEMENT SERVICE

INFRASTRUCTURE DEVELOPMENT AND DESIGN DIVISION

DESIGN STAFF: INITIAL / DATE
 DESIGNED BY: IDDO
 DRAWN BY: JCMC
 CHECKED BY: RJAJR

REVIEWED BY:

RAUL R. CRUCENA
 Division Chief II, IDDO-AED

SUBMITTED BY:

ARNEL F. BORLADO
 Department Manager III, AED-ADMS

RECOMMEND APPROVAL:

LT COL VALENTINO A. DIONELA PAF (RET)
 Assistant Director General II, ADMS

APPROVED BY:

CAPTAIN MANUEL ANTONIO L. TAMAYO
 Director General

NOTES/REVISIONS:


PROJECT:
 IMPROVEMENT/REHABILITATION OF AIRWAYS FACILITY COMPLEX BUILDING

LOCATION:
 CAAP CENTRAL OFFICE
 NAIA RD. COR. N. AQUINO AVENUE,
 PASAY CITY


SHEET CONTENTS:

SECOND FLOOR ACU CONDENSATE DRAIN PIPE LAYOUT

DRAWING SCALE: AS SHOWN
 SHEET NO: M - 04
 04

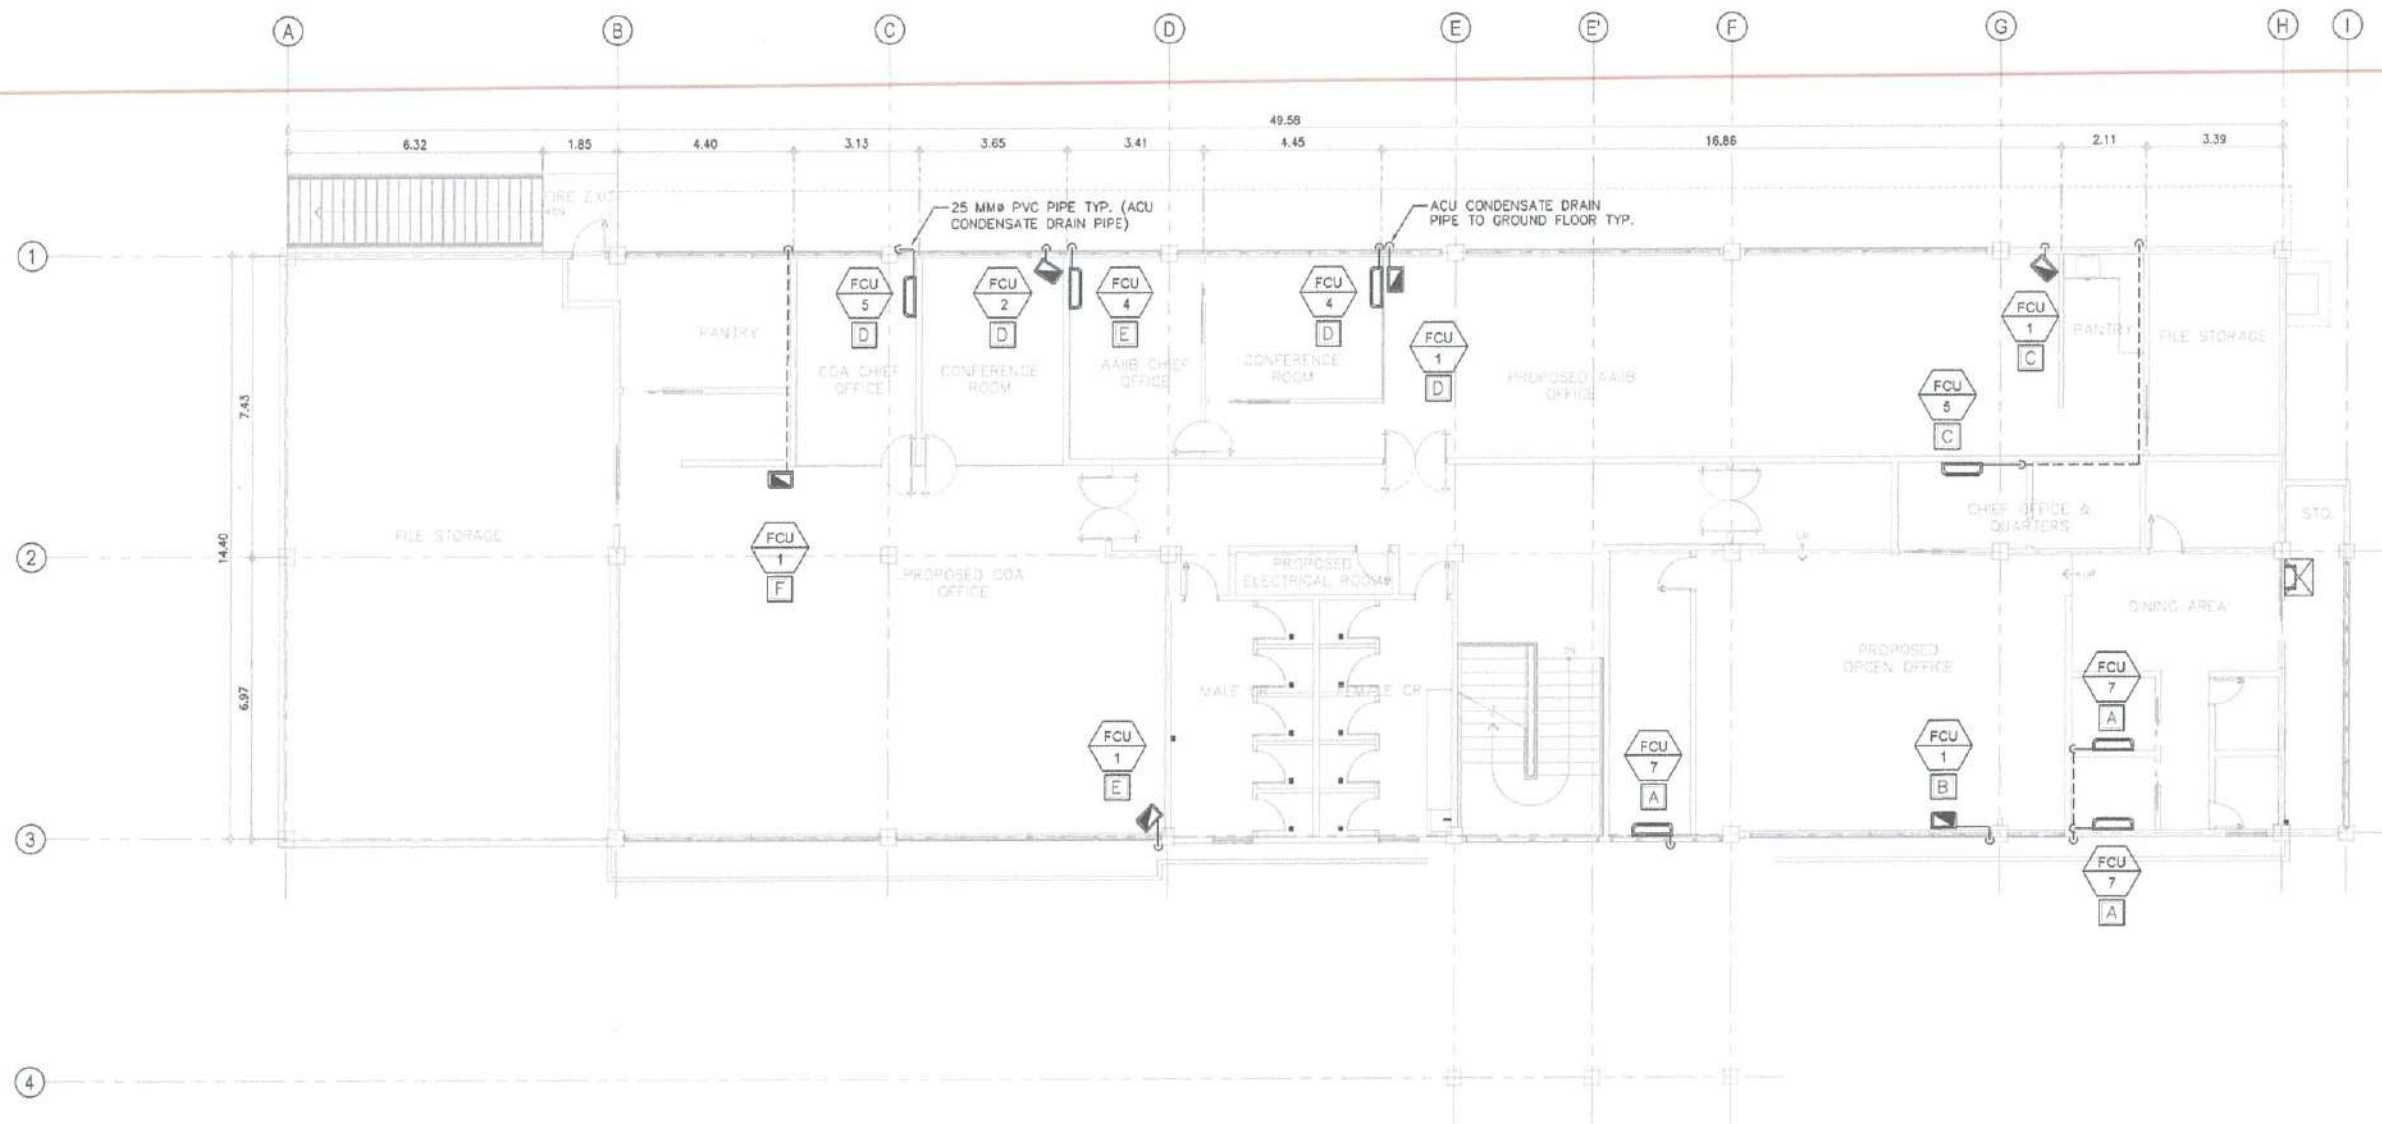

 SECOND FLOOR ACU CONDENSATE DRAIN PIPE LAYOUT
 SCALE: 1:100 M



1
M 05 M 05

GROUND FLOOR VENTILATION LAYOUT

SCALE: 1:100 M



REPUBLIC OF THE PHILIPPINES
CIVIL AVIATION AUTHORITY OF THE PHILIPPINES
AERODROME DEVELOPMENT AND MANAGEMENT SERVICE
NAIA ROAD, PASAY CITY

THIS DRAWINGS AND DESIGN IS EXCLUSIVE
PROPERTY OF CIVIL AVIATION AUTHORITY
OF THE PHILIPPINES AND SUCH MUST NOT BE
REPRODUCED, EXHIBITED, LOANED NOR
COPIED IN PART OR IN WHOLE WITHOUT
PROPER PERMISSION AND/OR WRITTEN
CONSENT FROM THE DIRECTOR GENERAL
CAAP.

AERODROME DEVELOPMENT
AND MANAGEMENT SERVICE

INFRASTRUCTURE DEVELOPMENT AND DESIGN
DIVISION

DESIGN STAFF: INITIAL / DATE
DESIGNED BY: IDDO
DRAWN BY: JCMC
CHECKED BY: RLJR

REVIEWED BY:

RAUL R. CRUCENA
Division Chief II, IDDO-AED

SUBMITTED BY:
ARNEL F. BORLADO
Department Manager II, AED-ADMS

RECOMMEND APPROVAL:
LT COL VALERINO A. DIONELA PAF (RET)
Assistant Director General II, ADMS

APPROVED BY:
CAPTAIN MANUEL ANTONIO L. TAMAYO
Director General


NOTES/REVISIONS:

PROJECT:
IMPROVEMENT/REHABILITATION
OF AIRWAYS FACILITY COMPLEX
BUILDING

LOCATION:
CAAP CENTRAL OFFICE
NAIA RD. COR. N. AQUINO AVENUE,
PASAY CITY


SHEET CONTENTS:
MISCELLANEOUS DETAILS

DRAWING SCALE: AS SHOWN
SHEET NO: M - 08
08

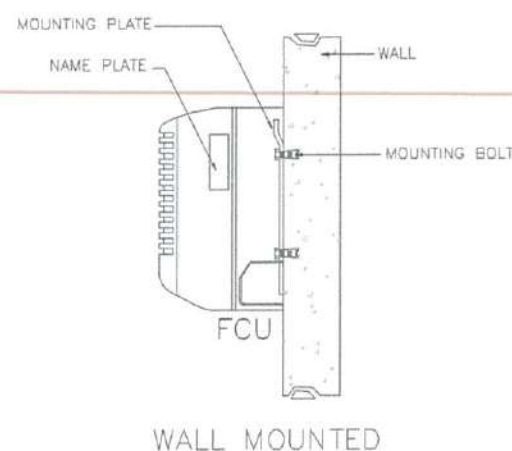


WALL MOUNTED

FCU DETAIL

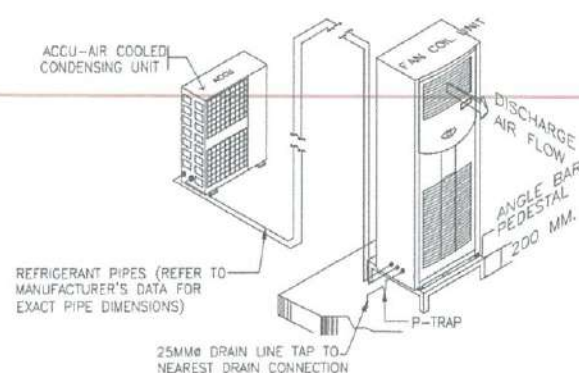


FLOOR STANDING


FCU DETAIL

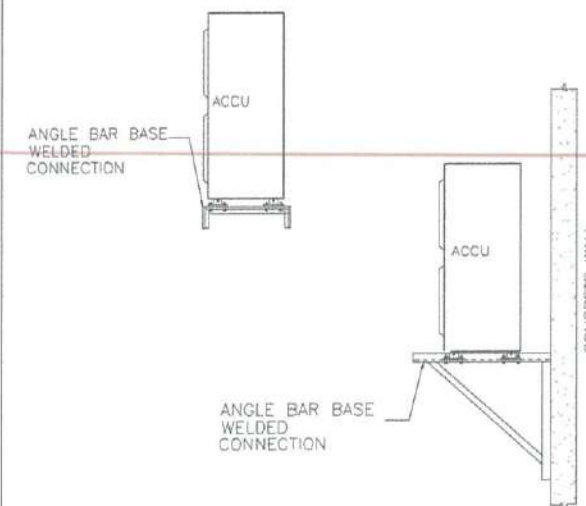


ACCU SUPPORT DETAIL

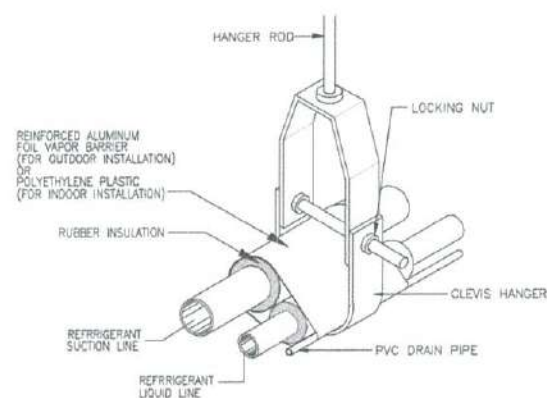

COPPER TUBING W/ HANGER DETAIL

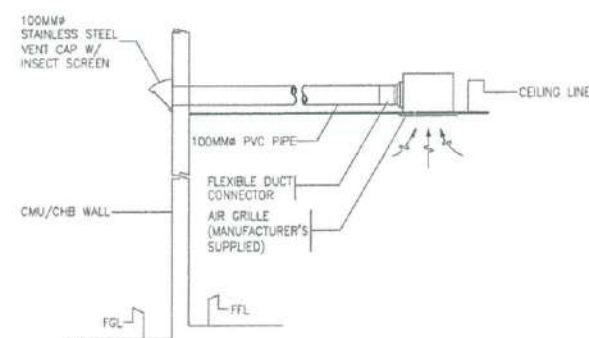

EXHAUST FAN DETAIL

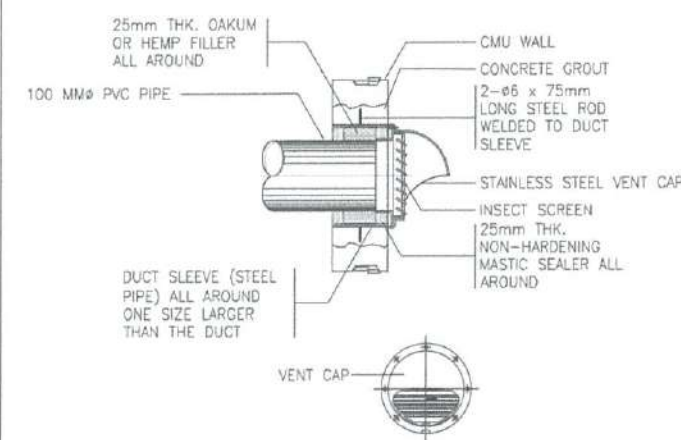

EXHAUST DUCT/VENT CAP DETAIL

GENERAL NOTES:

- IT IS NOT INTENDED THAT THE DRAWINGS SHALL SHOW EVERY PIPE FITTINGS, DUCT FITTINGS, VALVES, DAMPERS, HANGERS/SUPPORTS, ETC.. ALL SUCH ITEM WHETHER SPECIFICALLY MENTIONED OR NOT, OR INDICATED ON THE DRAWINGS SHALL BE FURNISHED AND INSTALLED IF NECESSARY TO COMPLETE THE SYSTEM TO THE SATISFACTION OF THE ENGINEER AND THE OWNER.
- CONTRACTOR SHALL BE RESPONSIBLE IN VERIFYING AND COORDINATING, THE FOLLOWING IN ACCORDANCE WITH MANUFACTURER'S DATA AND RECOMMENDATIONS.
 - FLOOR, ROOF AND WALL OPENINGS
 - EQUIPMENT PADS/PEDESTALS
 - CONDENSATE DRAIN LINES
- ALL PIPE SIZES ARE IN MILLIMETER (mm) UNLESS OTHERWISE INDICATED.
- ALL STRUCTURAL AND ARCHITECTURAL FINISHES DAMAGED DURING THE COURSE OF WORK SHALL BE RESTORED TO ITS ORIGINAL CONDITION OR AS APPROVED BY OWNER.
- PROVIDE SERVICE ACCESS & CLEARANCE TO CHANGE AIR FILTER ELEMENT FOR AC EQUIPMENT AS RECOMMENDED BY MANUFACTURER.
- ALL INSULATED MECHANICAL PIPES THAT ARE EXPOSED SHALL BE CLADDED WITH ALUMINUM SHEET. CLADDING SHALL BE MACHINE/SHOP FABRICATED.
- CONTRACTOR/VENDOR SHOULD BE FAMILIAR WITH THE ACTUAL SITE CONDITION AND INSTALLATION TO VERIFY IF THE WORK IS IN CONFORMANCE TO MANUFACTURER RECOMMENDATION AND SHOULD RECTIFY IF SUCH CONDITION EXIST.
- THE CONTRACTOR SHALL COORDINATE W/ THE STRUCTURAL, SANITARY, ARCHITECTURAL AND ELECTRICAL REGARDING THE ROUGHING-INS OF FUTURE AIR CONDITIONING UNITS. ALL EMBEDDED ITEMS SHALL BE INSTALLED IN PLACE UNDER THIS CONTRACT.
- FINAL EQPT. TAG NUMBERING SHALL BE MADE BY THE OWNER'S ENGINEERING DEPARTMENT FOR CASE OF IDENTIFICATION OF INDIVIDUAL UNIT.
- INSTALLATION OF ALL WORKS SHALL BE DONE IN A NEAT AND WORKMANLIKE MANNER, IMPROPERLY SET WORK OR FINISH AS DETERMINED BY THE ARCHITECT SHALL BE REMOVED AND REPLACED AT NO EXTRA COST.
- ALL MATERIALS TO BE USED SHALL BE BRAND NEW AND CLEAN.
- DEVIATION AND REVISIONS FROM PLAN SHALL BE REFERRED TO THE ARCHITECT/ENGINEER FOR REVIEW AND APPROVAL.
- ALL NECESSARY GOVERNMENT PERMIT SHALL BE SECURED AND PAID FOR THE CONTRACTOR.
- ALL MECHANICAL WORKS SHALL BE IN ACCORDANCE WITH THE LATEST MECHANICAL ENGINEER'S CODE ASVE, ASHRAE AND SMACNA STANDARD.
- ALL A/C AND VENTILATING EQUIPMENT CONTROL PANEL SWITCH AND CIRCUIT BREAKERS ARE PROVIDED BY THE MECHANICAL CONTRACTOR.
- THE MECHANICAL CONTRACTOR SHALL CONDUCT TESTING, BALANCING AND COMMISSIONING OF ALL A/C AND VENTILATING EQUIPMENT.

SYMBOL	ABBREVIATION	DESCRIPTION
	A/C	AIR CONDITIONING
	ACCU	AIR COOLED CONDENSING UNIT
		EQUIPMENT TAG NUMBER
	FCU	FAN COIL UNIT (WALL MOUNTED)
	FCU	FAN COIL UNIT (FLOOR STANDING)
	KW	KILOWATTS
	PH	PHASE
		PIPE GOING UP
		PIPE GOING DOWN
	PFE	PORTABLE FIRE EXTINGUISHER
	QTY	QUANTITY
	RL	REFRIGERANT LIQUID
	RG	REFRIGERANT GAS
	SMACNA	SHEET METAL AND AIR CONDITIONING CONTRACTORS NATIONAL ASSOCIATION
	TR	TON OF REFRIGERATION
	TYP	TYPICAL
	HP	HORSEPOWER
	HZ	HERTZ
	V	VOLTS

FAN COIL UNIT (INDOOR UNIT)

MARK	QTY.	LOCATION / AREA SERVED	COOLING LOAD/UNIT HP (TR)	DRAIN LINE mm (IN)	REFRIGERANT		ELECTRICAL DATA				NET WEIGHT KG	REMARKS	
					TYPE	PIPE CONNECTION		V	PH	HZ			RATED CURRENT (A)
	GAS LINE mm (IN)	LIQUID LINE mm (IN)											
	6	CSIS ADMIN OFFICE, OPCEN OFFICE, AAIB OFFICE & COA OFFICE	7.0 (5.0)	25 (1)	R-410a	19.05 (3/4)	9.52 (3/8)	220-230	3	60	15.4	58	INVERTER FLOOR STANDING TYPE INDOOR FREE BLOW FAN COIL UNIT COMPLETE WITH REMOTE, TEMPERATURE CONTROLLER, FAN SPEED SWITCH EQUIPMENT SUPPORT AND STANDARD ACCESSORIES.
	4	CSIS LOBBY, SD OFFICE, IQCS OFFICE & COA CONFERENCE ROOM	4.0 (3.0)	25 (1)	R-410a	15.88 (5/8)	9.52 (3/8)	220-230	1	60	16.0	50	INVERTER FLOOR STANDING TYPE INDOOR FREE BLOW FAN COIL UNIT COMPLETE WITH REMOTE, TEMPERATURE CONTROLLER, FAN SPEED SWITCH EQUIPMENT SUPPORT AND STANDARD ACCESSORIES.
	1	IID OFFICE	3.0	25 (1)	R-32	15.88 (5/8)	6.35 (1/4)	220-230	1	60	11.5	16.5	INVERTER WALL MOUNTED TYPE INDOOR FREE BLOW FAN COIL UNIT COMPLETE WITH REMOTE, TEMPERATURE CONTROLLER, FAN SPEED SWITCH EQUIPMENT SUPPORT AND STANDARD ACCESSORIES.
	5	CSIS ID PROCESSING AREA, CSIS ADG II OFFICE, CSIS CONF. ROOM, AAIB CONF. ROOM & CHIEF OFFICE	2.0	25 (1)	R-32	12.70 (1/2)	6.35 (1/4)	220-230	1	60	8.5	12	INVERTER WALL MOUNTED TYPE INDOOR FREE BLOW FAN COIL UNIT COMPLETE WITH REMOTE, TEMPERATURE CONTROLLER, FAN SPEED SWITCH EQUIPMENT SUPPORT AND STANDARD ACCESSORIES.
	4	SD CHIEF OFFICE, IID CHIEF OFFICE, OPCEN CHIEF OFFICE & COA CHIEF OFFICE	1.5	25 (1)	R-32	9.52 (3/8)	6.35 (1/4)	220-230	1	60	7.15	7.7	INVERTER WALL MOUNTED TYPE INDOOR FREE BLOW FAN COIL UNIT COMPLETE WITH REMOTE, TEMPERATURE CONTROLLER, FAN SPEED SWITCH EQUIPMENT SUPPORT AND STANDARD ACCESSORIES.
	1	INTERROGATION AREA	1.0	25 (1)	R-32	9.52 (3/8)	6.35 (1/4)	220-230	1	60	5.20	7.2	INVERTER WALL MOUNTED TYPE INDOOR FREE BLOW FAN COIL UNIT COMPLETE WITH REMOTE, TEMPERATURE CONTROLLER, FAN SPEED SWITCH EQUIPMENT SUPPORT AND STANDARD ACCESSORIES.
	3	OPCEN QUARTERS & SERVER ROOM	1.0	25 (1)	R-32	9.52 (3/8)	6.35 (1/4)	220-230	1	60	-	8.6	INVERTER MULTI-SPLIT WALL MOUNTED TYPE INDOOR FREE BLOW FAN COIL UNIT COMPLETE WITH REMOTE, TEMPERATURE CONTROLLER, FAN SPEED SWITCH, EQUIPMENT SUPPORT AND STANDARD ACCESSORIES.

AIR COOLED CONDENSING UNIT (OUTDOOR UNIT)

MARK	QTY.	CAPACITY HP (TR)	EQUIPMENT SERVED	DRAIN LINE mm (IN)	REFRIGERANT		ELECTRICAL DATA					NET WEIGHT KG	REMARKS	
					TYPE	PIPE CONNECTION		V	PH	HZ	RATED CURRENT (A)			CIRCUIT BREAKER (A)
		GAS LINE mm (IN)	LIQUID LINE mm (IN)											
	6	7.0 (5.0)	FCU-1	25 (1)	R-410a	19.05 (3/4)	9.52 (3/8)	220-230	3	60	-	40	92	INVERTER FLOOR MOUNTED AIR COOLED CONDENSER UNIT COMPLETE WITH CONDENSER FAN, HERMETIC COMPRESSOR, ELECTRICAL CONNECTION AND EQUIPMENT SUPPORT. THE UNIT SHALL BE THE SAME MANUFACTURER OF FCU.
	4	4.0 (3.0)	FCU-2	25 (1)	R-410a	15.88 (5/8)	9.52 (3/8)	220-230	1	60	-	40	54	INVERTER FLOOR MOUNTED AIR COOLED CONDENSER UNIT COMPLETE WITH CONDENSER FAN, HERMETIC COMPRESSOR, ELECTRICAL CONNECTION AND EQUIPMENT SUPPORT. THE UNIT SHALL BE THE SAME MANUFACTURER OF FCU.
	1	3.0	FCU-3	25 (1)	R-32	15.88 (5/8)	6.35 (1/4)	220-230	1	60	-	30	43	INVERTER FLOOR MOUNTED AIR COOLED CONDENSER UNIT COMPLETE WITH CONDENSER FAN, HERMETIC COMPRESSOR, ELECTRICAL CONNECTION AND EQUIPMENT SUPPORT. THE UNIT SHALL BE THE SAME MANUFACTURER OF FCU.
	5	2.0	FCU-4	25 (1)	R-32	12.70 (1/2)	6.35 (1/4)	220-230	1	60	-	30	26	INVERTER FLOOR MOUNTED AIR COOLED CONDENSER UNIT COMPLETE WITH CONDENSER FAN, HERMETIC COMPRESSOR, ELECTRICAL CONNECTION AND EQUIPMENT SUPPORT. THE UNIT SHALL BE THE SAME MANUFACTURER OF FCU.
	4	1.5	FCU-5	25 (1)	R-32	9.52 (3/8)	6.35 (1/4)	220-230	1	60	-	20	20	INVERTER FLOOR MOUNTED AIR COOLED CONDENSER UNIT COMPLETE WITH CONDENSER FAN, HERMETIC COMPRESSOR, ELECTRICAL CONNECTION AND EQUIPMENT SUPPORT. THE UNIT SHALL BE THE SAME MANUFACTURER OF FCU.
	1	1.0	FCU-6	25 (1)	R-32	9.52 (3/8)	6.35 (1/4)	220-230	1	60	-	20	19	INVERTER FLOOR MOUNTED AIR COOLED CONDENSER UNIT COMPLETE WITH CONDENSER FAN, HERMETIC COMPRESSOR, ELECTRICAL CONNECTION AND EQUIPMENT SUPPORT. THE UNIT SHALL BE THE SAME MANUFACTURER OF FCU.
	1	3.0	FCU-7	25 (1)	R-32	9.52 (3/8)	6.35 (1/4)	220-230	1	60	11.0	40	63	INVERTER FLOOR MOUNTED AIR COOLED CONDENSER UNIT COMPLETE WITH CONDENSER FAN, HERMETIC COMPRESSOR, ELECTRICAL CONNECTION AND EQUIPMENT SUPPORT. THE UNIT SHALL BE THE SAME MANUFACTURER OF FCU.



CIVIL AVIATION AUTHORITY OF THE PHILIPPINES
AERODROME DEVELOPMENT AND MANAGEMENT SERVICE
NAIA ROAD, PASAY CITY

THIS DRAWINGS AND DESIGN IS EXCLUSIVE PROPERTY OF CIVIL AVIATION AUTHORITY OF THE PHILIPPINES AND SUCH MUST NOT BE REPRODUCED, EXHIBITED, LOANED NOR COPIED IN PART OR IN WHOLE WITHOUT PROPER PERMISSION AND/OR WRITTEN CONSENT FROM THE DIRECTOR GENERAL CAAP.

AERODROME DEVELOPMENT AND MANAGEMENT SERVICE

INFRASTRUCTURE DEVELOPMENT AND DESIGN DIVISION

DESIGN STAFF: INITIAL / DATE

DESIGNED BY: IDDO
DRAWN BY: JCMC
CHECKED BY: RUAR

REVIEWED BY:

REVIEWED BY: RUEL R. CRUCENA
Division Chief II, IDDO-AED

SUBMITTED BY:

ARNEL F. BORLADO
Department Manager II, AED-ADMS

RECOMMEND APPROVAL:

LT COL VALENTINO A. DIGNELA PAF (RET)
Assistant Director General II, ADMS

APPROVED BY:

CAPTAIN RUEL ANTONIO L. TAMAYO
Division General

NOTES/REVISIONS:

PROJECT:

IMPROVEMENT/REHABILITATION OF AIRWAYS FACILITY COMPLEX BUILDING

LOCATION:

CAAP CENTRAL OFFICE
NAIA RD. COR. N. AQUINO AVENUE,
PASAY CITY

SHEET CONTENTS:

GENERAL NOTES
LEGENDS & SYMBOLS
EQUIPMENT SCHEDULE

DRAWING SCALE: SHEET NO:

AS SHOWN M - 07

07

GENERAL NOTES

- IT IS NOT INTENDED THAT THE DRAWINGS SHALL SHOW EVERY PIPE FITTING, VALVE AND APPURTENANCE. ALL SUCH ITEMS WHETHER SPECIFICALLY MENTIONED OR NOT, OR INDICATED ON THE DRAWINGS SHALL BE FURNISHED AND INSTALLED IF NECESSARY TO COMPLETE THE SYSTEM TO THE SATISFACTION OF THE OWNER.
- ALL PLUMBING WORKS SHALL BE INSTALLED IN ACCORDANCE WITH THE PROVISION OF THE NATIONAL PLUMBING CODE OF THE PHILIPPINES, THE REQUIREMENTS OF THE LOCAL PLUMBING INSPECTION OFFICE, PERTINENT PROVISIONS OF THE UNIFORM BUILDING CODE AND THE NATIONAL BUILDING CODE OF THE PHILIPPINES.
- ALL PLUMBING INSTALLATIONS SHALL BE COORDINATED WITH OTHER TRADES. ANY REVISION IN THE PIPING LAYOUT REQUIRED FOR PROPER EXECUTION OF OTHER TRADES SHALL BE WITH PRIOR APPROVAL OF THE PROJECT ENGINEER.
- HORIZONTAL SANITARY SEWER PIPING SHALL BE RUN IN PRACTICAL ALIGNMENT AT A MINIMUM SLOPE OF 1% FOR PIPES 100MMØ AND LARGER AND 2% FOR 75MMØ AND SMALLER.
- ALL VENT PIPE SHALL BE FREE FROM DROPS OR SAGS AND SHALL BE SLOPED OR GRADED AS TO DRIP BACK BY GRAVITY TO THE DRAINAGE PIPE IT SERVES.
- ALL PLUMBING FIXTURES SHALL BE INDIVIDUALLY VENTED.
- ALL DIMENSIONS AND PIPE SIZES ARE IN MILLIMETERS EXCEPT OTHERWISE SHOWN. INDICATED METRIC EQUIVALENT USED ON THESE PLANS FOR PIPE SIZES:

1/2"	= 15mm	2"	= 50mm	6"	= 150mm
3/4"	= 20mm	2 1/2"	= 65mm	8"	= 200mm
1 1/4"	= 32mm	3"	= 75mm	10"	= 250mm
1 1/2"	= 40mm	4"	= 100mm	12"	= 300mm
- THE CONTRACTOR SHALL VERIFY ALL EXISTING UTILITIES AT SITE, SUCH AS, THE ACTUAL PIPE SIZES, LOCATIONS, DEPTHS, TOP AND INVERT ELEVATIONS OF ALL EXISTING PIPES AND RELATED STRUCTURES. THE CONTRACTOR SHALL PROVIDE THE NECESSARY EXCAVATIONS, BACKFILLING AND SURFACE RESTORATION OF THE AFFECTED AREAS IN THE LAYING OF SEWER, STORM DRAINAGE AND SUPPLY LINES.
- CONDENSATE DRAINAGE SYSTEM FOR AIRCONDITIONING EQUIPMENT INCLUDING PIPINGS, FITTINGS, SUPPORTS, ALL REQUIRED ACCESSORIES AND TAPPING PINTS SHALL BE PART OF MECHANICAL WORKS.
- PROVIDE VALVE BOX FOR EACH EMBEDDED GATE VALVE.
- THE SIZES OF WATER SUPPLY FIXTURES SHALL BE IN ACCORDANCE THE MANUFACTURER'S INSTRUCTIONS

MATERIAL SPECIFICATIONS

COLD WATER LINE

- SHALL BE POLYPROPYLENE RANDOM (TYPE 3) PN 20; HIGH RESISTANCE TO PRESSURE AN TEMPERATURE, CONFORMING TO EN ISO 15874, SIMILAR TO GEORGE FISCHER, NELTEX, UNITEC PP-R PIPE OR APPROVED EQUIVALENT

SOIL, WASTE AND VENT LINES

- SHALL BE UNPLASTICIZED POLYVINYL CHLORIDE (uPVC) PIPE CONFORMING TO ASTM D2729, SIMILAR TO NELTEX, MOLDEX OR EMERALD SERIES 1000 uPVC OR APPROVED EQUAL.

DOWNSPOUTS AND DRAINAGE LINE (INSIDE AND OUTSIDE OF BUILDING)

- SHALL BE UNPLASTICIZED POLYVINYL CHLORIDE (uPVC) PIPE AND FITTINGS FOR 10 100mmØ AND SMALLER CONFORMING TO ASTM D2729, SIMILAR TO NELTEX, MOLDEX OR EMERALD SERIES 1000 uPVC OR APPROVED EQUIVALENT.
- SHALL BE HIGH DENSITY POLYETHYLENE (HDPE) PIPE AND FITTINGSS FOR 300mmØ AND LARGER, PE 3408 SDR 17 CONFORMING TO ASTM D3350, ASTM F714, AND ASTM D3261

PLUMBING LEGEND AND SYMBOLS

---	COLD WATERLINE	CWDF	COLD WATER DOWN FEED	LAV	LAVATORY
---	SOIL PIPE/ WASTE PIPE	BS	BIDET SPRAY	PD	PLANTER'S DRAIN
-----	VENT PIPE	CWR	COLD WATER RISER	RD	ROOF DRAIN
--]	END CAP	DD	DECK DRAIN	RED	REDUCER
	FLOOR CLEANOUT	DP	DRAIN PIPE	SHO	SHOWER HEAD
	GROUND CLEANOUT	DS	DOWNSPOUT	SP	SOIL PIPE
	GATE VALVE	EPDR/L	ELEVATOR PIT PIPE DISCHARGE RISER/LINE	SS	SLOP SINK
	CHECK VALVE	FD	FLOOR DRAIN	UR	URINAL
	WATER METER	GD	GUTTER DRAIN	VS	VENT STACK
	INCREASER/ REDUCER	GT	GREASE TRAP	VSTD	VENT STACK THRU DECK
	CATCH BASIN/ AREA DRAIN	HB	HOSE BIBB	VSTR	VENT STACK THRU ROOF
	SEPTIC TANK	KLAV	KID'S LAVATORY	VSTW	VENT STACK THRU WALL
AAV	AIR ADMITTANCE VALVE	KS	KITCHEN SINK	WC	WATER CLOSET
CSWS	COMBINED SOIL AND WASTE STACK	KUR	KID'S URINAL	WP	WASTE PIPE

EQUIVALENT PIPE SIZE FOR WATER PIPES

NOMINAL PIPE SIZE DIAMETER	PIPE SIZES IN MILLIMETERS (mm)							
	15	20	25	32	40	50	63	75
POLYPROPYLENE RANDOM (PPR)	20	25	32	40	50	63	75	100
UNPLASTICIZED POLYVINYL CHLORIDE (uPVC)	15	19	25	32	40	50	65	80

PLUMBING FIXTURE CONNECTION SCHEDULE

DESCRIPTION	SYMBOL	WATER SUPPLY PIPE SIZE (mm)	SOIL/ WASTE PIPE SIZE (mm)	TRAP SIZE (mm)
KITCHEN SINK	KS	15	50	38
LAVATORY	LAV	15	50	38
SERVICE SINK/ SLOP SINK	SSK/SS	15	75	50
SHOWER	SHO	15	50	50
URINAL	UR	20	50	INTEGRAL
WATER CLOSET (FLUSH TANK)	WC	15	100	INTEGRAL
WATER CLOSET (FLUSH VALVE)	WC	32	100	INTEGRAL



REPUBLIC OF THE PHILIPPINES
CIVIL AVIATION AUTHORITY OF THE PHILIPPINES
AERODROME DEVELOPMENT AND MANAGEMENT SERVICE
NAIA ROAD, 1368 PASAY CITY

THIS DRAWINGS AND DESIGN IS EXCLUSIVE PROPERTIES OF CIVIL AVIATION AUTHORITY OF THE PHILIPPINES AND SUCH MUST NOT BE REPRODUCED, EXHIBITED, LOANED NOR COPIED IN PART OR IN WHOLE WITHOUT PROPER PERMISSION AND/OR WRITTEN CONSENT FROM THE DIRECTOR GENERAL CAAP.

AERODROME DEVELOPMENT AND MANAGEMENT SERVICE

INFRASTRUCTURE DEVELOPMENT AND DESIGN DIVISION

DESIGN STAFF:	INITIAL / DATE
DESIGNED BY:	ICDD
DRAWN BY:	JCCS
CHECKED BY:	CDJB
	EJDU

REVIEWED BY:


RAUL R. CRUZENA
Division Chief, ICDD-AED

SUBMITTED BY:


ARNEL F. BORLADO
Department Manager II, AED-ADMS

RECOMMEND APPROVAL:


LT COL VALENTINO A. DIONELA PAF (RET)
Assistant Director General II, ADMS

APPROVED BY:


CAPTAIN MANUEL ANTONIO L. TAMAYO
Director General

NOTES/REVISIONS:

PROJECT:

IMPROVEMENT/REHABILITATION OF AIRWAYS FACILITY COMPLEX BUILDING

LOCATION:

CAAP CENTRAL OFFICE
NAIA RD. COR. N. AQUINO AVENUE,
PASAY CITY

SHEET CONTENTS:

DRAWING SCALE:	SHEET NO:
	P 001

LEGEND:



REPUBLIC OF THE PHILIPPINES
CIVIL AVIATION AUTHORITY OF THE PHILIPPINES
AERODROME DEVELOPMENT AND MANAGEMENT SERVICE
NAIA ROAD, 1305 PASAY CITY

THIS DRAWINGS AND DESIGN IS EXCLUSIVE PROPERTIES OF CIVIL AVIATION AUTHORITY OF THE PHILIPPINES AND SUCH MUST NOT BE REPRODUCED, EXHIBITED, LOANED NOR COPIED IN PART OR IN WHOLE WITHOUT PROPER PERMISSION AND/OR WRITTEN CONSENT FROM THE DIRECTOR GENERAL CAAP.

AERODROME DEVELOPMENT AND MANAGEMENT SERVICE

INFRASTRUCTURE DEVELOPMENT AND DESIGN DIVISION

DESIGN STAFF: INITIAL / DATE
DESIGNED BY: IDDD
DRAWN BY: JCMC
CHECKED BY: RUAJR

REVIEWED BY:
RAUL R. CRUCENA
Division Chief III, IDDD-AED

SUBMITTED BY:
ARNEL F. BORLADO
Department Manager II, AED-ADMS

RECOMMEND APPROVAL:
LT COL VALENTINO A. DIONELA PAF (RET)
Assistant Director General II, ADMS

APPROVED BY:
CAPTAIN MANUEL ANTONIO L. TAMAYO
Director General

NOTES/REVISIONS:

PROJECT:
IMPROVEMENT/REHABILITATION OF AIRWAYS FACILITY COMPLEX BUILDING

LOCATION:
CAAP CENTRAL OFFICE
NAIA RD. COR. N. AQUINO AVENUE,
PASAY CITY

SHEET CONTENTS:
SECOND FLOOR VENTILATION LAYOUT

DRAWING SCALE: AS SHOWN
SHEET NO.: M - 06



NOTE:
1. CEILING MOUNTED EXHAUST FANS SHALL BE CONNECTED TO THE NEAREST LIGHTING CIRCUIT.

1 SECOND FLOOR VENTILATION LAYOUT
SCALE: 1:100 M



REPUBLIC OF THE PHILIPPINES
CIVIL AVIATION AUTHORITY OF THE PHILIPPINES
AERODROME DEVELOPMENT AND MANAGEMENT SERVICE
NAIA ROAD, 1305 PASAY CITY

THIS DRAWING AND DESIGN IS EXCLUSIVE PROPERTY OF CIVIL AVIATION AUTHORITY OF THE PHILIPPINES AND SUCH MUST NOT BE REPRODUCED, EXHIBITED, LOANED NOR COPIED IN PART OR IN WHOLE WITHOUT PROPER PERMISSION AND/OR WRITTEN CONSENT FROM THE DIRECTOR GENERAL, CAAP.

AERODROME DEVELOPMENT AND MANAGEMENT SERVICE

INFRASTRUCTURE DEVELOPMENT AND DESIGN DIVISION

DESIGN STAFF: INITIAL / DATE
DESIGNED BY: IDDD
DRAWN BY: JCCB
CHECKED BY: COJB
EJDJ

REVIEWED BY:

RAUL R. CRUCENA
Division Chief II, IDDD-AED

SUBMITTED BY:

ARNEL F. BORLADO
Department Manager III, AED-ADMS

RECOMMEND APPROVAL:

LT COL. VALENTINO A. DIONELA PAF (RET)
Assistant Director General II, ADMS

APPROVED BY:

CAPTAIN MANUEL ANTONIO L. TAMAYO
Director General


NOTES/REVISIONS:

PROJECT:
IMPROVEMENT/REHABILITATION OF AIRWAYS FACILITY COMPLEX BUILDING

LOCATION:
CAAP CENTRAL OFFICE
NAIA RD. COR. N. AQUINO AVENUE,
PASAY CITY

SHEET CONTENTS:

DRAWING SCALE: SHEET NO:
P 002

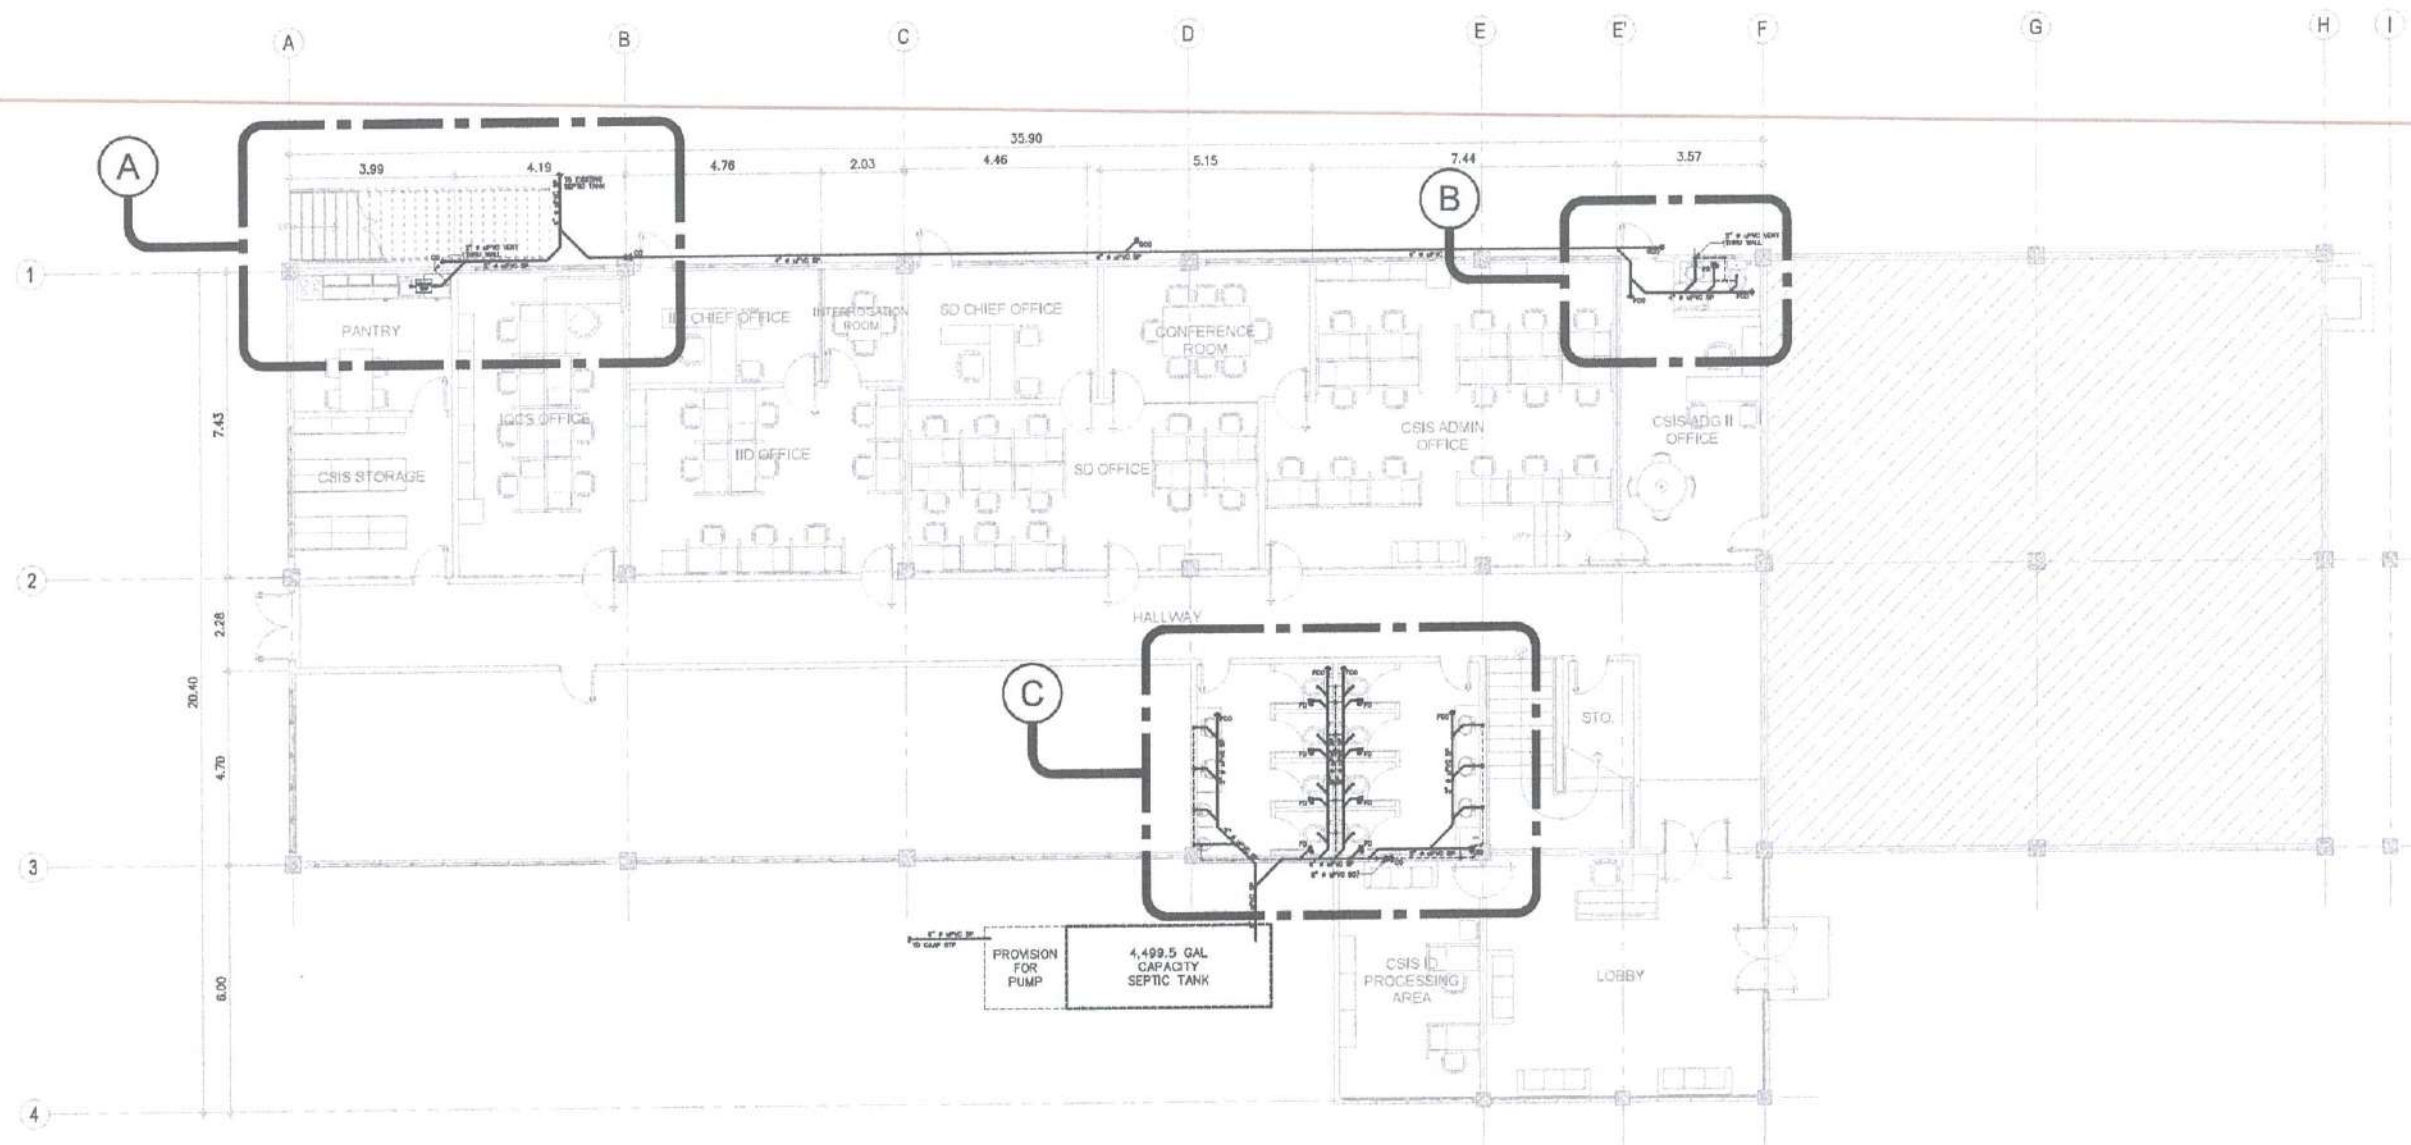

GROUND FLOOR
SEWERLINE SYSTEM PIPING LAYOUT
SCALE: 1:100M



CIVIL AVIATION AUTHORITY OF THE PHILIPPINES
AERODROME DEVELOPMENT AND MANAGEMENT SERVICE
NAIA ROAD, 1300 PASAY CITY

THIS DRAWINGS AND DESIGN IS EXCLUSIVE
PROPERTY OF CIVIL AVIATION AUTHORITY
OF THE PHILIPPINES AND SUCH MUST NOT BE
REPRODUCED, EXHIBITED, LOANED NOR
COPIED IN PART OR IN WHOLE WITHOUT
PROPER PERMISSION AND/OR WRITTEN
CONSENT FROM THE DIRECTOR GENERAL
CAAP.

AERODROME DEVELOPMENT
AND MANAGEMENT SERVICE

INFRASTRUCTURE DEVELOPMENT AND DESIGN
DIVISION

DESIGN STAFF: INITIAL / DATE
DESIGNED BY: JCCD
DRAWN BY: JCCS
CHECKED BY: CDJB
EJDI

REVIEWED BY:
RAUL R. CRUCENA
Division Chief III, IDO-AED

SUBMITTED BY:
ARNEL F. BORLADO
Department Manager III, AED-ADMS

RECOMMEND APPROVAL:
LT COL. VALENTINO A. DIONELA PAF (RET)
Assistant Director General II, ADMS

APPROVED BY:
CAPTAIN MANUEL ANTONIO L. TAMAYO
Director General


NOTES/REVISIONS:

PROJECT:
IMPROVEMENT/REHABILITATION
OF AIRWAYS FACILITY COMPLEX
BUILDING

LOCATION:
CAAP CENTRAL OFFICE
NAIA RD., COR. N. AQUINO AVENUE,
PASAY CITY

SHEET CONTENTS:

DRAWING SCALE: SHEET NO:
P 003

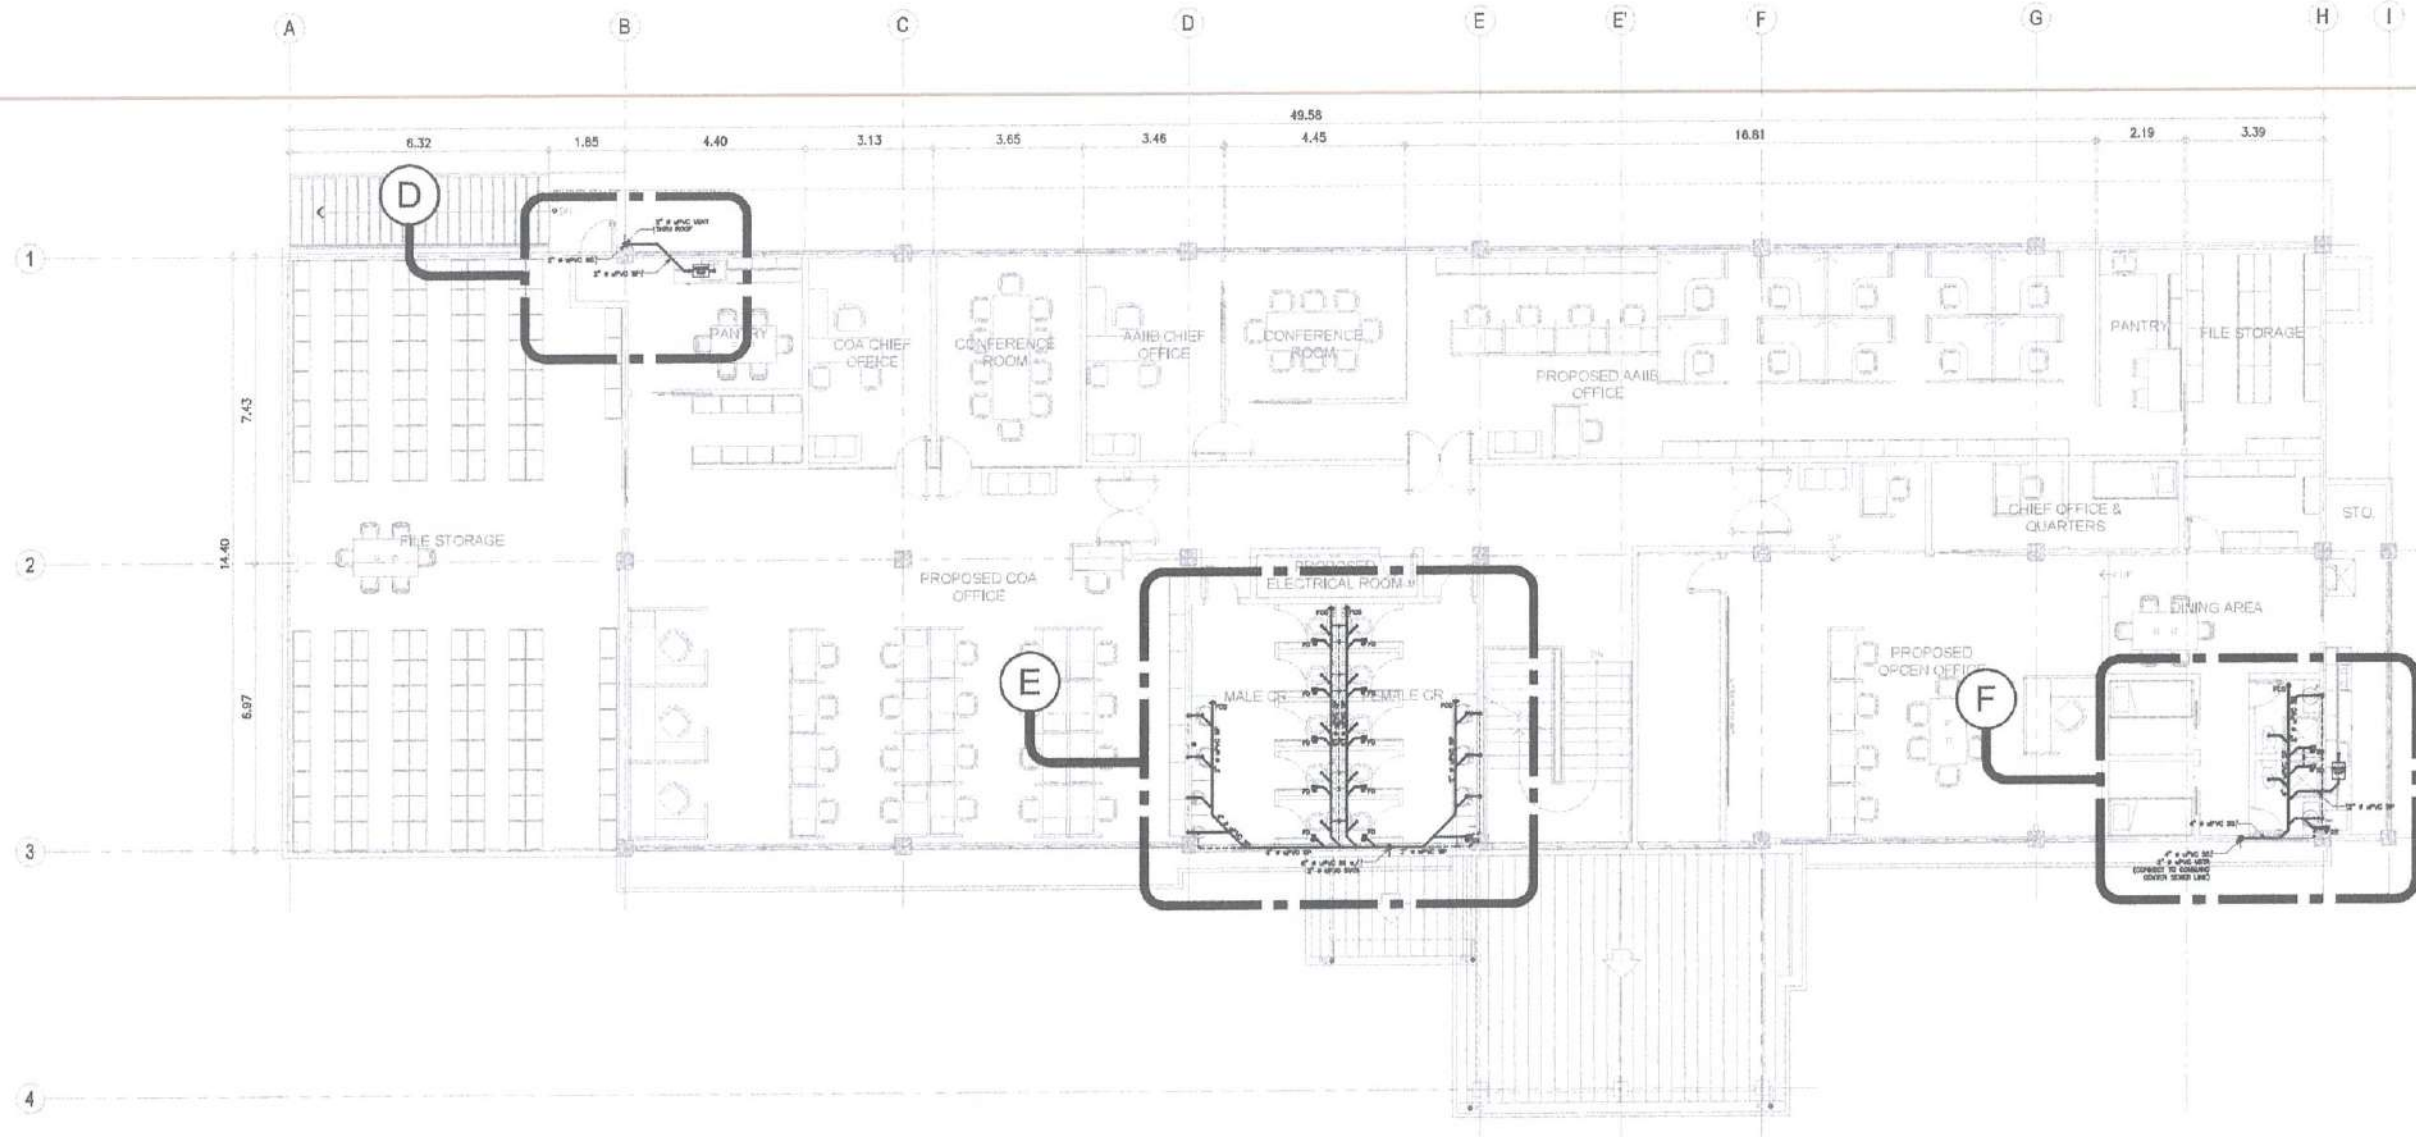

1 SECOND FLOOR
SEWERLINE SYSTEM PIPING LAYOUT
SCALE: 1:100M

THIS DRAWING AND DESIGN IS EXCLUSIVE PROPERTY OF CIVIL AVIATION AUTHORITY OF THE PHILIPPINES AND SUCH MUST NOT BE REPRODUCED, EXHIBITED, LOANED NOR COPIED IN PART OR IN WHOLE WITHOUT PROPER PERMISSION AND/OR WRITTEN CONSENT FROM THE DIRECTOR GENERAL CAAP.

AERODROME DEVELOPMENT AND MANAGEMENT SERVICE

INFRASTRUCTURE DEVELOPMENT AND DESIGN DIVISION

DESIGN STAFF:	INITIAL / DATE
DESIGNED BY:	IDDD
DRAWN BY:	JCCS
CHECKED BY:	CDJB
	EJDI

REVIEWED BY:


RAUL R. CRUZENA
Division Chief, IDDD-AED

SUBMITTED BY:


ARNEL F. BORLADO
Department Manager III, AED-ADMS

RECOMMEND APPROVAL:


LT COL. VALENTINO A. DIONELA PAF (RET)
Assistant Director General II, ADMS

APPROVED BY:


CAPTAIN MANUEL ANTONIO L. TAMAYO
Director General


NOTES/REVISIONS:

PROJECT:
IMPROVEMENT/REHABILITATION OF AIRWAYS FACILITY COMPLEX BUILDING


LOCATION:
CAAP CENTRAL OFFICE
NAIA RD. COR. N. AQUINO AVENUE,
PASAY CITY

SHEET CONTENTS:


DRAWING SCALE:	SHEET NO:
	P 004

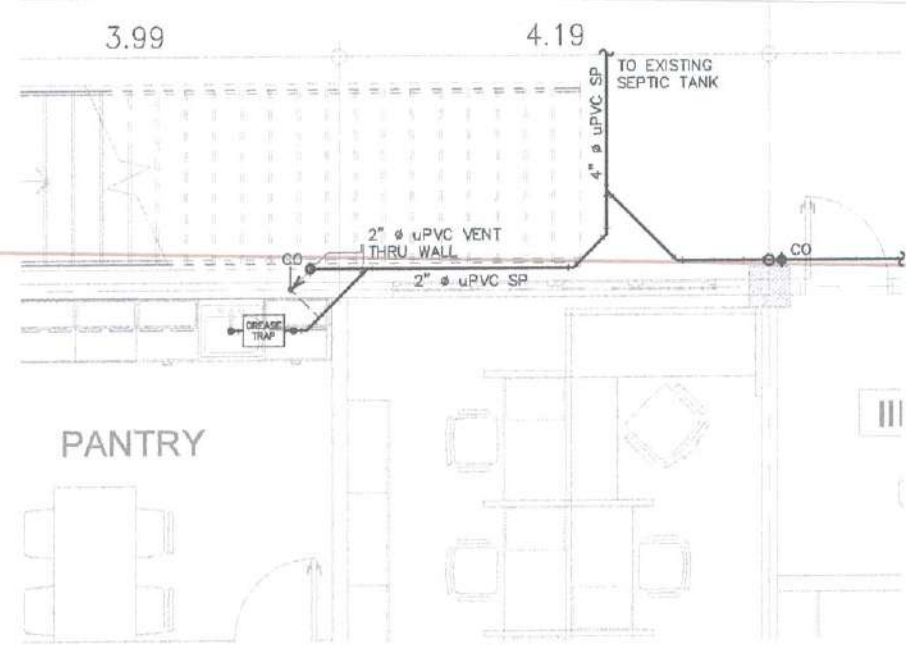

1 BLOW-UP 'A' ENLARGED SEWERLINE SYSTEM
SCALE: 1:40M

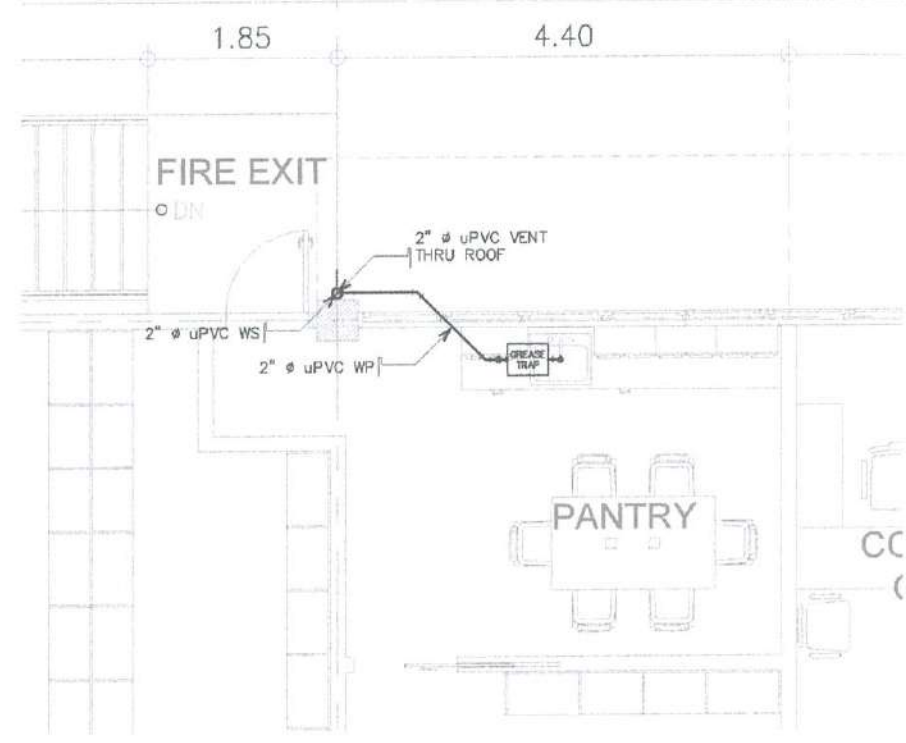

2 BLOW-UP 'D' ENLARGED SEWERLINE SYSTEM
SCALE: 1:40M

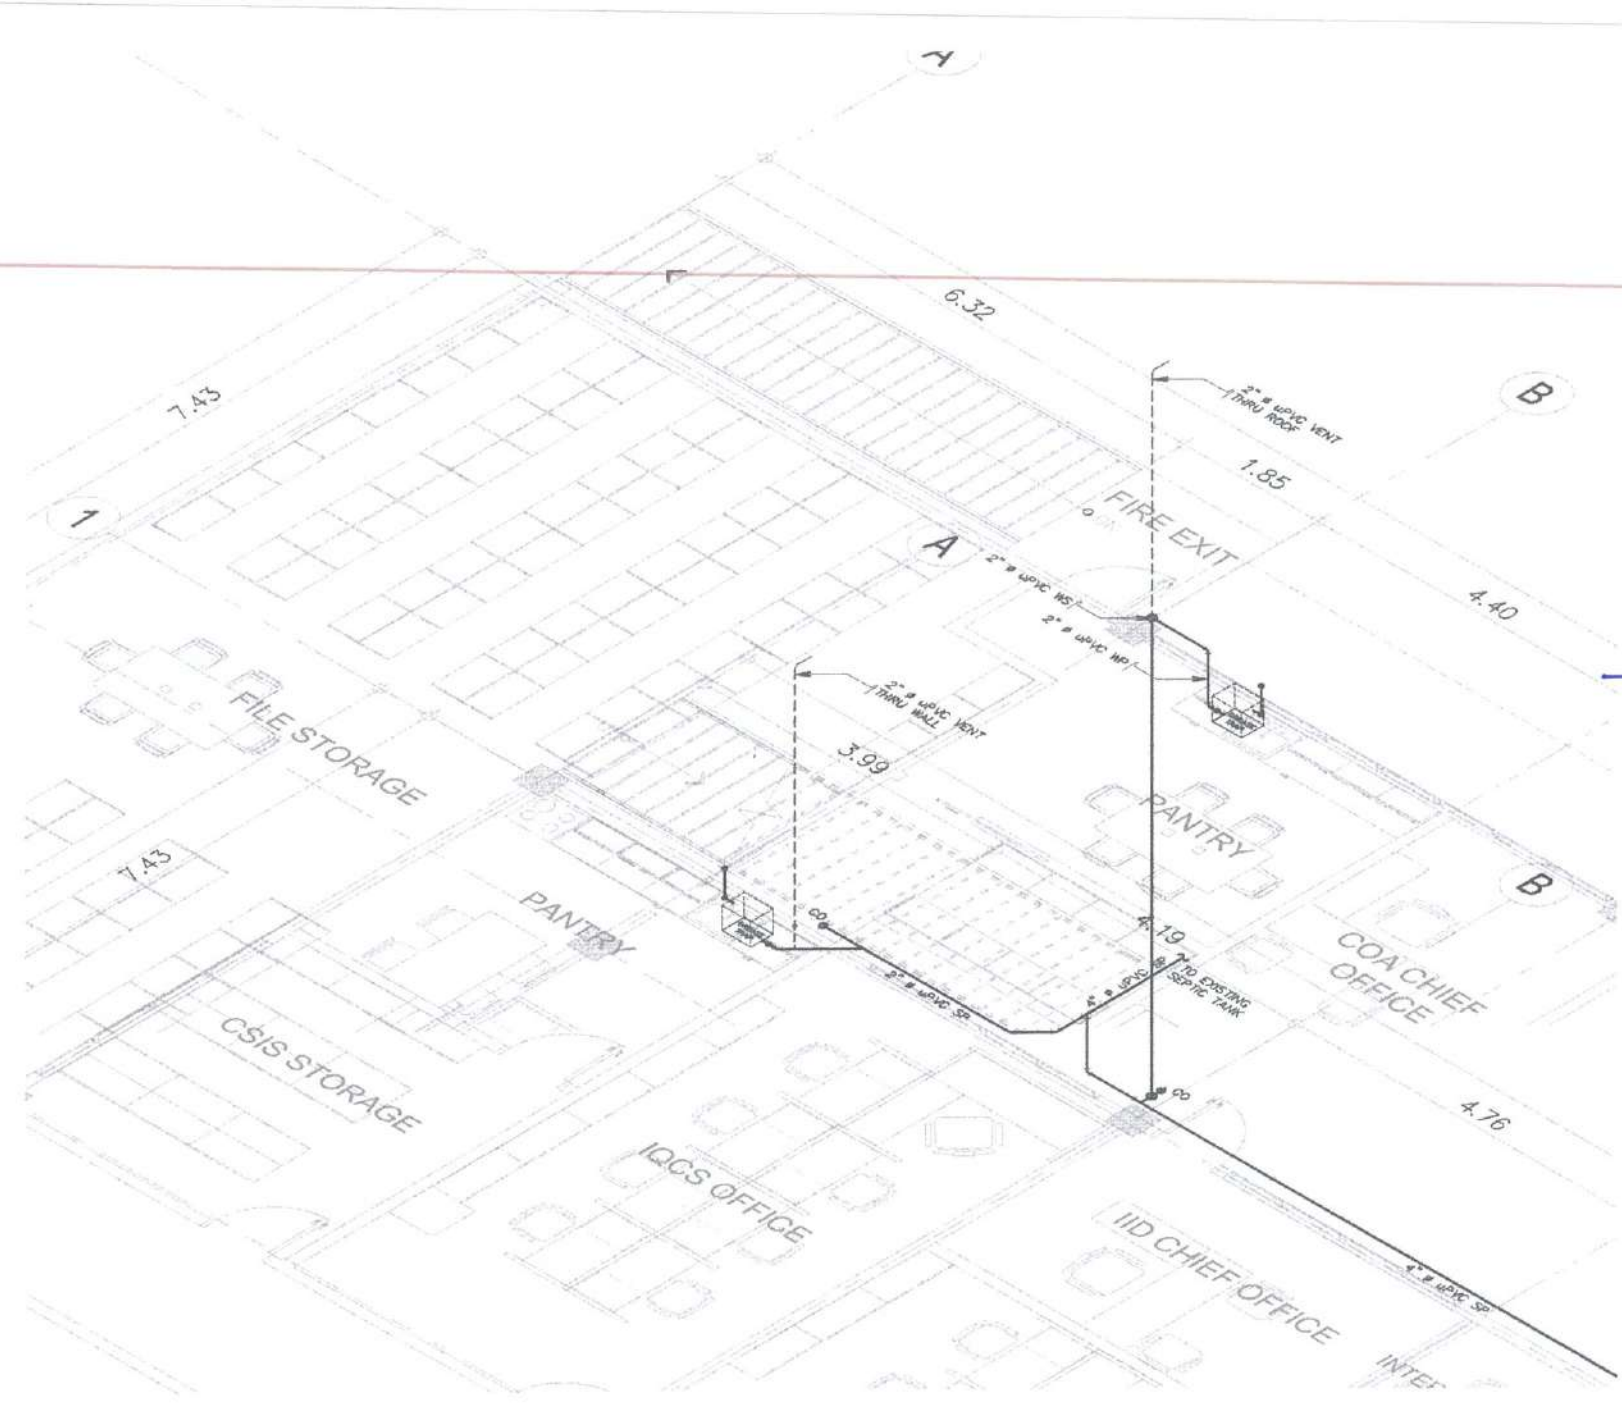

3 BLOW-UP 'C' & 'E' ISOMETRIC VIEW
SCALE: 1:40M



CIVIL AVIATION AUTHORITY OF THE PHILIPPINES
AERODROME DEVELOPMENT AND MANAGEMENT SERVICE
NAIA ROAD 1500 PASAY CITY

THIS DRAWINGS AND DESIGN IS EXCLUSIVE
PROPERTY OF CIVIL AVIATION AUTHORITY
OF THE PHILIPPINES AND SUCH MUST NOT BE
REPRODUCED, EXHIBITED, LOANED NOR
COPIED IN PART OR IN WHOLE WITHOUT
PROPER PERMISSION AND/OR WRITTEN
CONSENT FROM THE DIRECTOR GENERAL
CAAP.

AERODROME DEVELOPMENT
AND MANAGEMENT SERVICE

INFRASTRUCTURE DEVELOPMENT AND DESIGN
DIVISION

DESIGN STAFF:	INITIAL / DATE
DESIGNED BY:	1000
DRAWN BY:	JCCS
CHECKED BY:	CDJB
	EADJ

REVIEWED BY:

RAUL R. CRUCENA
Division Chief III, AED-AED

SUBMITTED BY:

ARNEL F. BORLADO
Department Manager III, AED-ADMS

RECOMMEND APPROVAL:

LT COL VALENTINO A. DIONELA PAF (RET)
Assistant Director General II, ADMS

APPROVED BY:

CAPTAIN MANUEL ANTONIO L. TAMAYO
Director General





NOTES/REVISIONS:

PROJECT:
IMPROVEMENT/REHABILITATION
OF AIRWAYS FACILITY COMPLEX
BUILDING

LOCATION:
CAAP CENTRAL OFFICE
NAIA RD. COR. N. AQUINO AVENUE,
PASAY CITY

SHEET CONTENTS

DRAWING SCALE:	SHEET NO:
	P 005

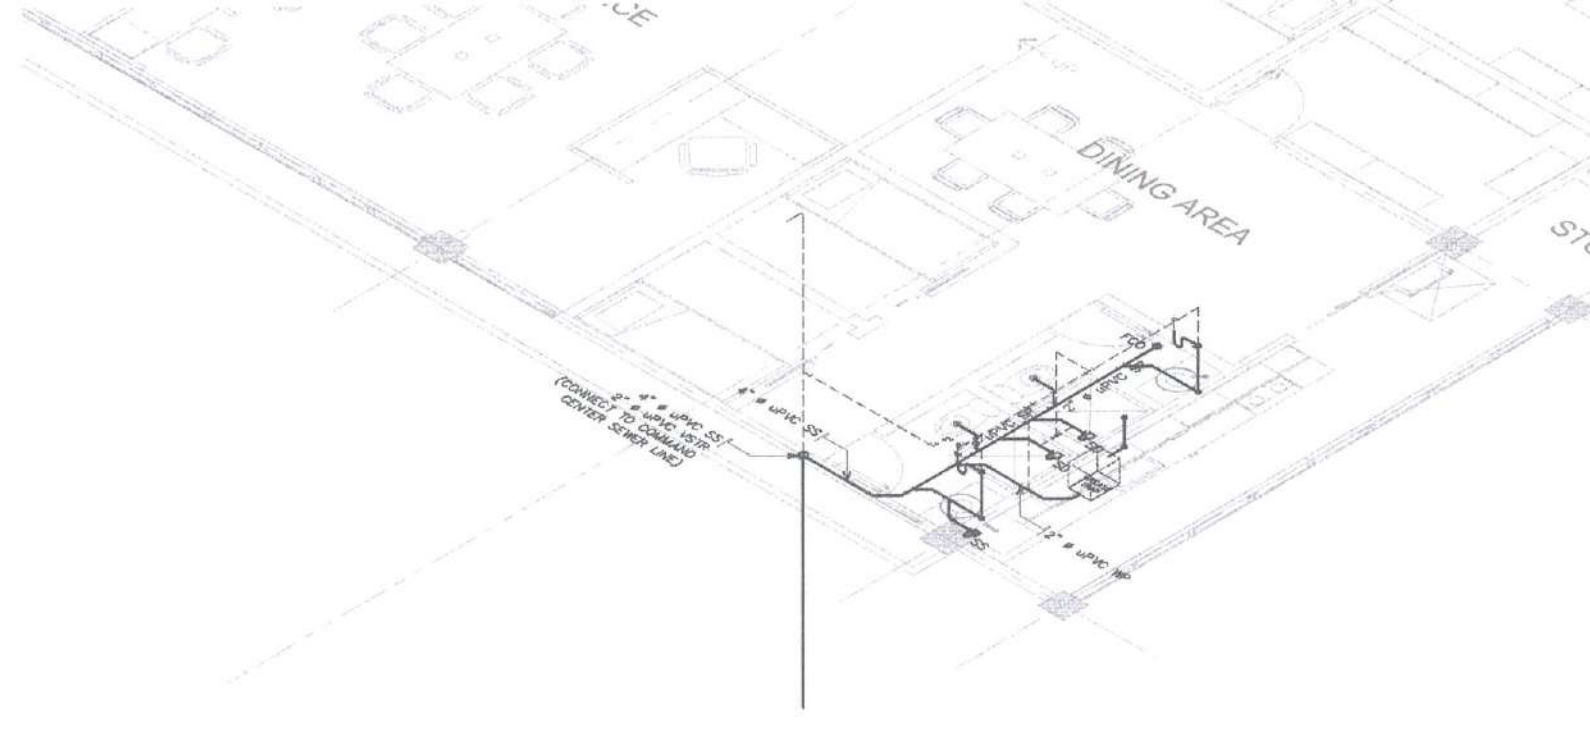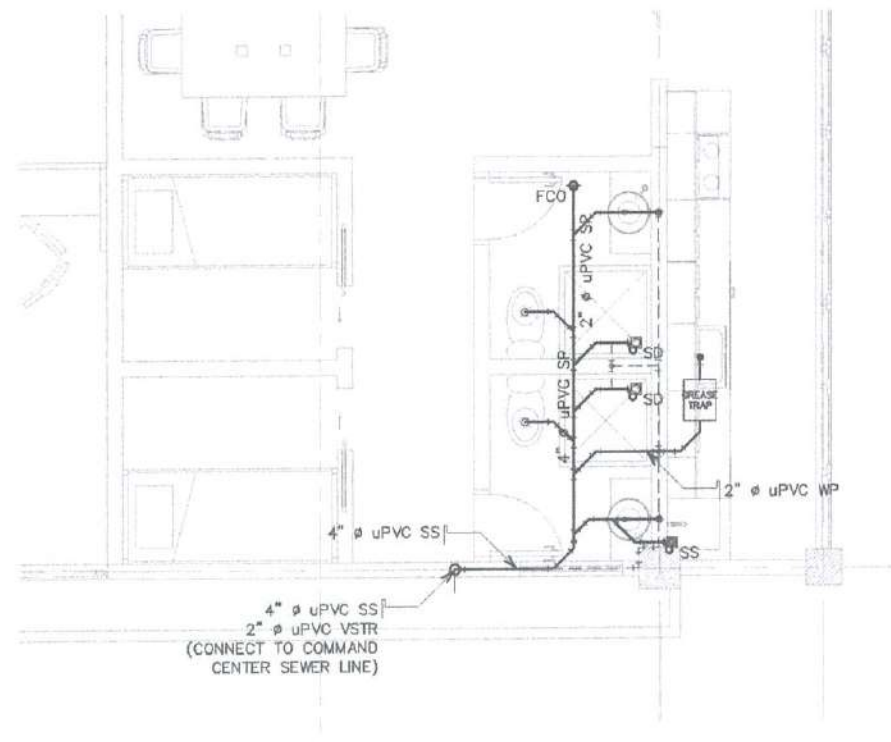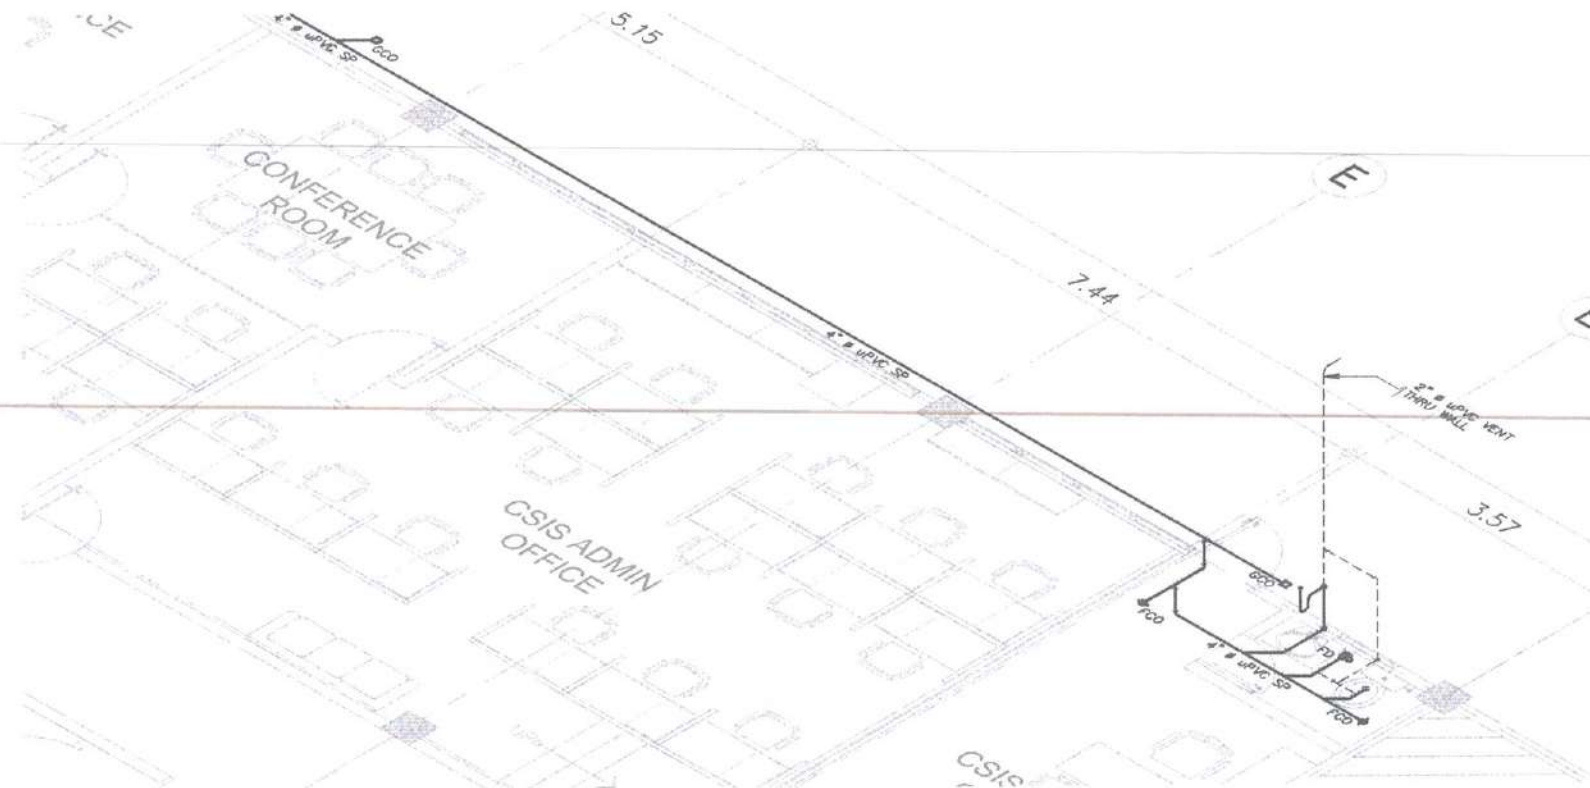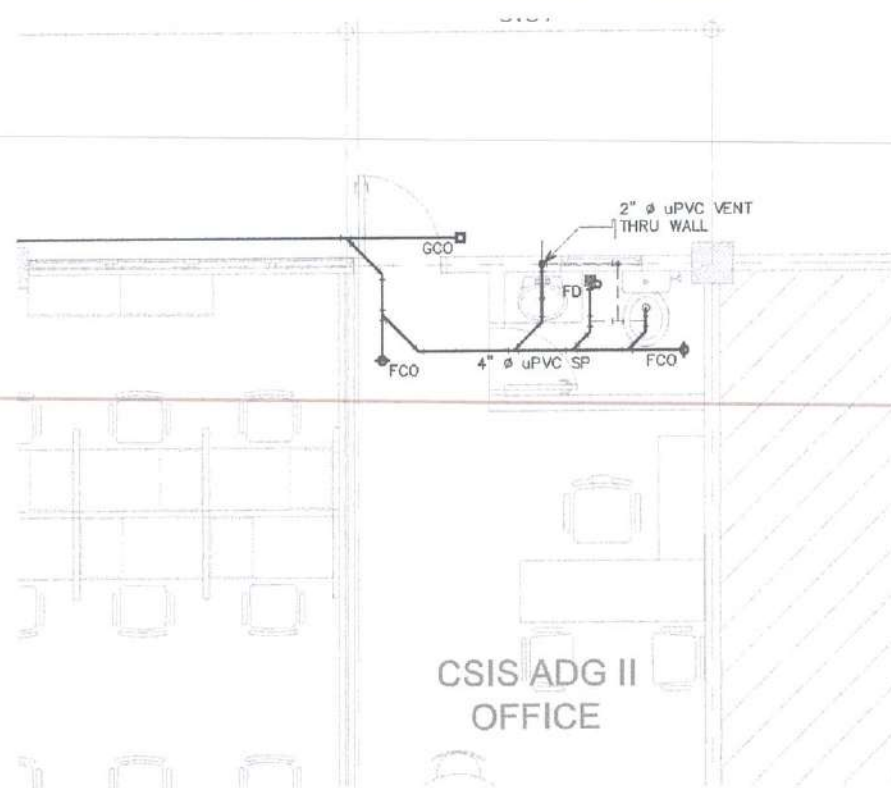



REPUBLIC OF THE PHILIPPINES
CIVIL AVIATION AUTHORITY OF THE PHILIPPINES
AERODROME DEVELOPMENT AND MANAGEMENT SERVICE
NAIA ROAD, 1305 PASAY CITY

THIS DRAWINGS AND DESIGN IS EXCLUSIVE
PROPERTY OF CIVIL AVIATION AUTHORITY
OF THE PHILIPPINES AND SUCH MUST NOT BE
REPRODUCED, EXHIBITED, LOANED NOR
COPIED BY PART OR IN WHOLE WITHOUT
PROPER PERMISSION AND/OR WRITTEN
CONSENT FROM THE DIRECTOR GENERAL
CAAP.

AERODROME DEVELOPMENT
AND MANAGEMENT SERVICE

INFRASTRUCTURE DEVELOPMENT AND DESIGN
DIVISION

DESIGN STAFF: INITIAL DATE
DESIGNED BY: IDDD
DRAWN BY: JCS
CHECKED BY: CDJB
EJD

REVIEWED BY:

RAUL R. CRUCENA
Division Chief II ADD-AED

SUBMITTED BY:
ARNEL F. BORLADO
Department Manager III, AED-ADMS

RECOMMEND APPROVAL:
LT COL VALENTINO A. DIONELA PAF (RET)
Assistant Director General II, ADAS

APPROVED BY:
CAPTAIN MANUEL ANTONIO L. TAMAYO
Director General


NOTES/REVISIONS:

PROJECT:
IMPROVEMENT/REHABILITATION
OF AIRWAYS FACILITY COMPLEX
BUILDING


LOCATION:
CAAP CENTRAL OFFICE
NAIA RD. COR. N. AQUINO AVENUE,
PASAY CITY

SHEET CONTENTS:


DRAWING SCALE: SHEET NO:
P 006

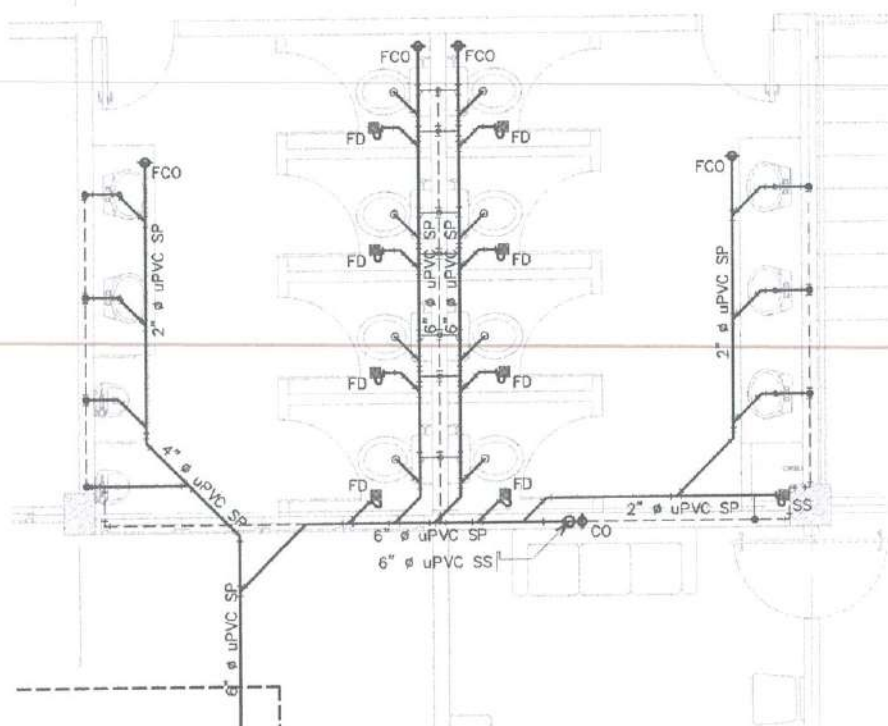

1 BLOW-UP 'C'
ENLARGED SEWERLINE SYSTEM
SCALE: 1:40M

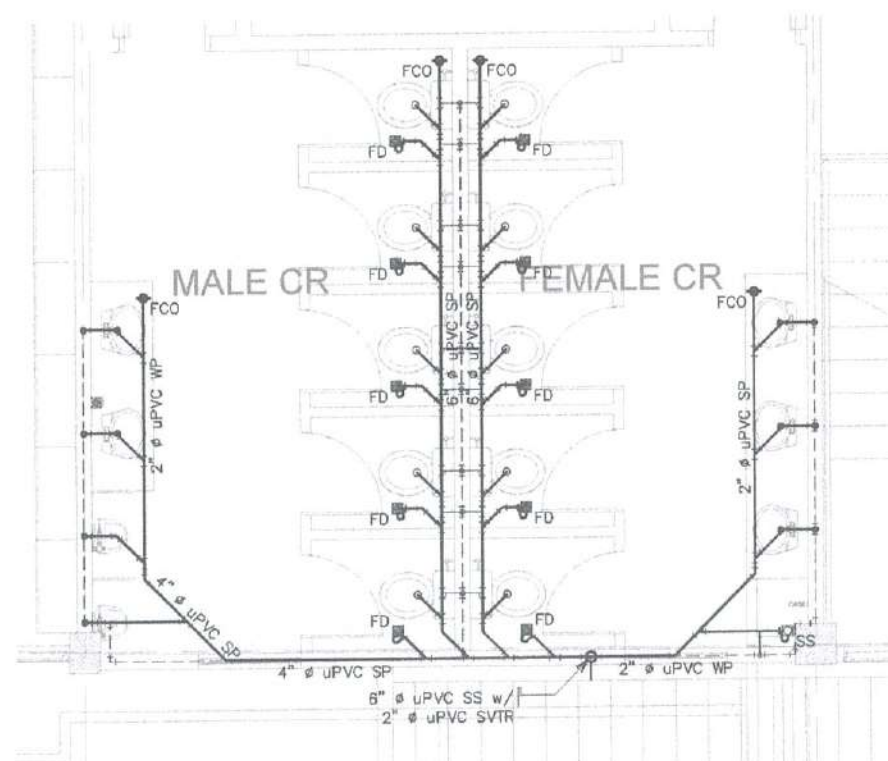

2 BLOW-UP 'E'
ENLARGED SEWERLINE SYSTEM
SCALE: 1:40M

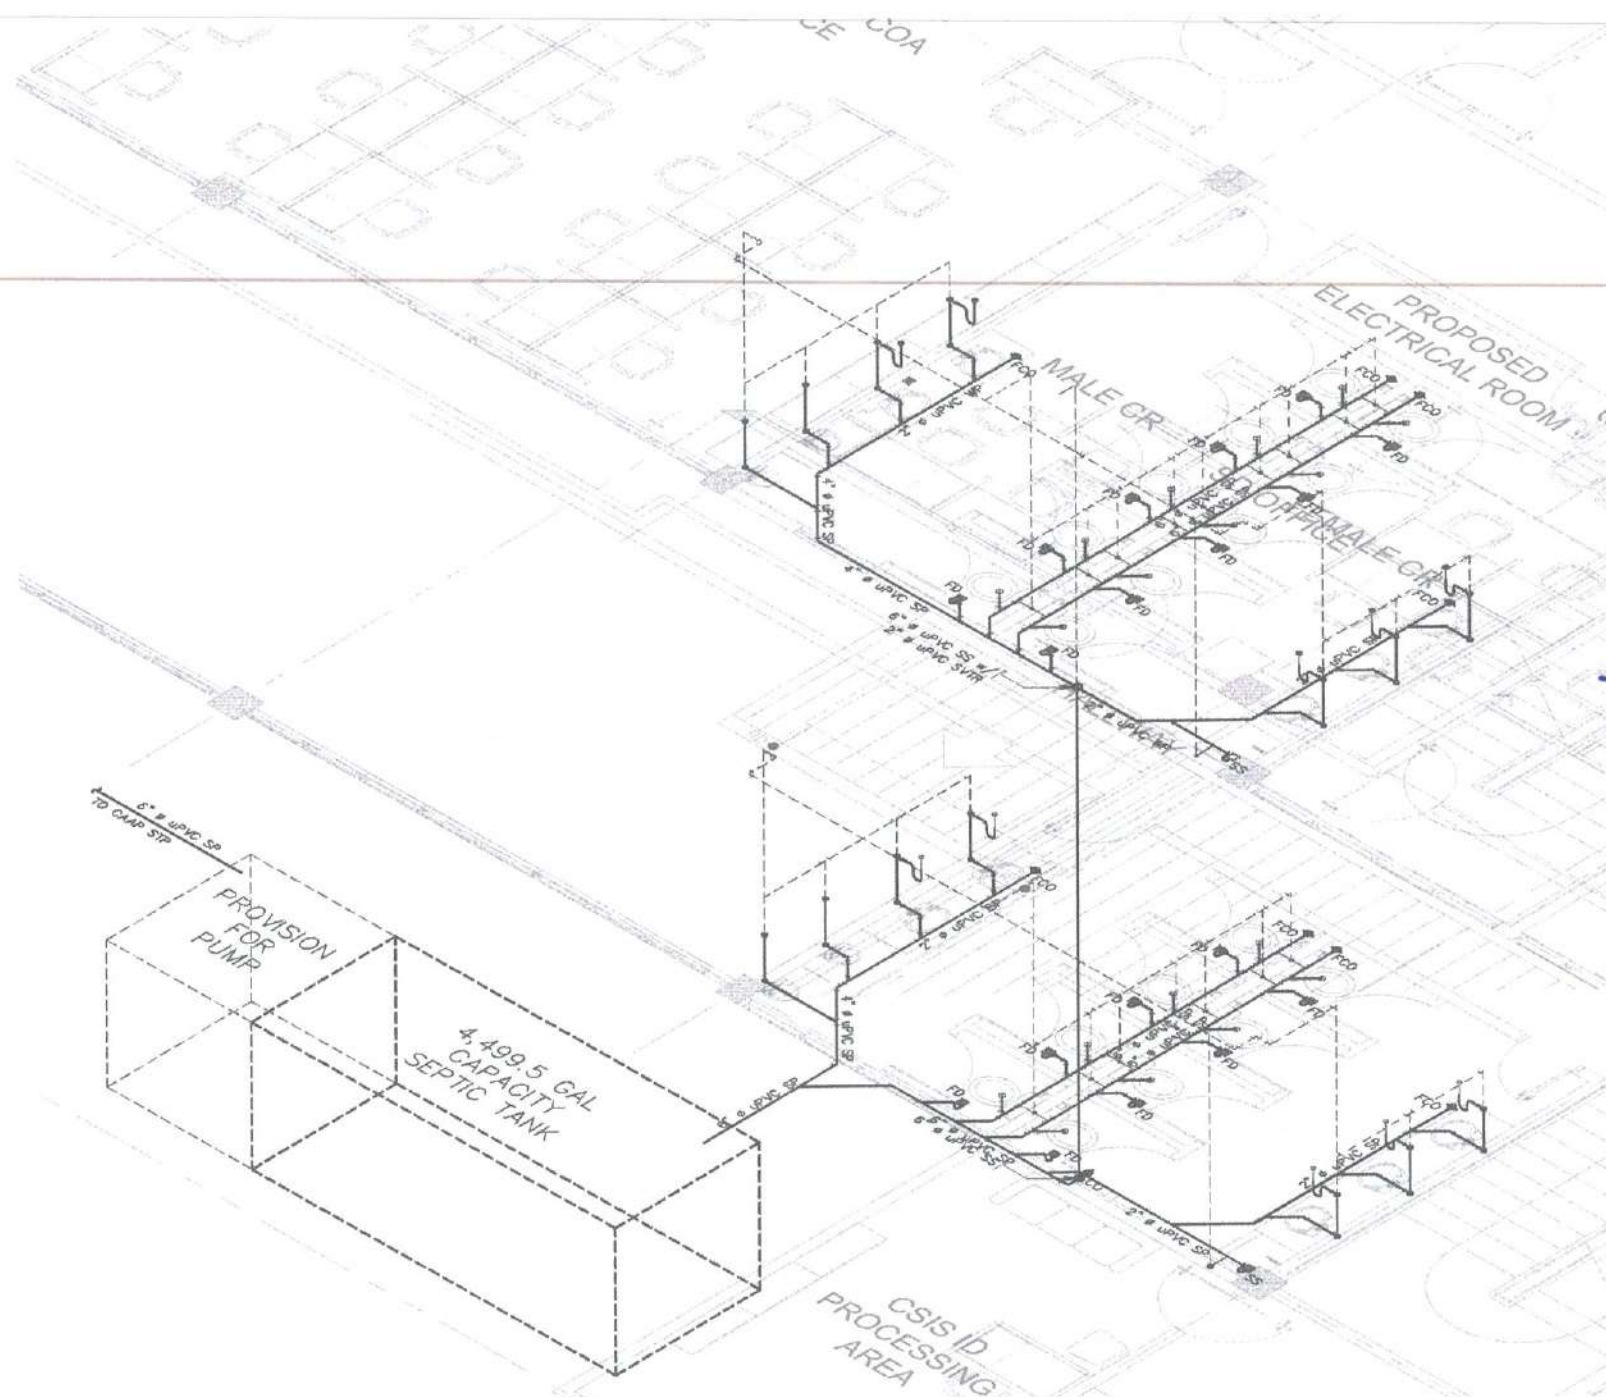

3 BLOW-UP 'C' & 'E'
ISOMETRIC VIEW
SCALE: 1:40M



REPUBLIC OF THE PHILIPPINES
CIVIL AVIATION AUTHORITY OF THE PHILIPPINES
AERODROME DEVELOPMENT AND MANAGEMENT SERVICE
NAIA RD. 1328 PASAY CITY

THIS DRAWINGS AND DESIGN IS EXCLUSIVE
PROPERTY OF CIVIL AVIATION AUTHORITY
OF THE PHILIPPINES AND SUCH MUST NOT BE
REPRODUCED, EXHIBITED, LOANED NOR
COPIED IN PART OR IN WHOLE WITHOUT
PROPER PERMISSION AND/OR WRITTEN
CONSENT FROM THE DIRECTOR GENERAL
CAAP.

AERODROME DEVELOPMENT
AND MANAGEMENT SERVICE

INFRASTRUCTURE DEVELOPMENT AND DESIGN
DIVISION

DESIGN STAFF:	INITIAL / DATE
DESIGNED BY:	ICDD
DRAWN BY:	JCCS
CHECKED BY:	CDJB
	EJDU

REVIEWED BY:

RAUL R. CRUCENA
Division Chief II, ICDD-AED

SUBMITTED BY:

ARNEL F. BORLADO
Department Manager II, AED-ADMS

RECOMMEND APPROVAL:

LT-SEL VALERINO A. DIONELA PAF (RET)
Assistant Director General II, ADMS

APPROVED BY:

CAPTAIN MARCEL ANTONIO L. TAMAYO
Director General


NOTES/REVISIONS:

PROJECT:
IMPROVEMENT/REHABILITATION
OF AIRWAYS FACILITY COMPLEX
BUILDING

LOCATION:
CAAP CENTRAL OFFICE
NAIA RD. COR. N. AQUINO AVENUE,
PASAY CITY

SHEET CONTENTS:

DRAWING SCALE:	SHEET NO:
P	007

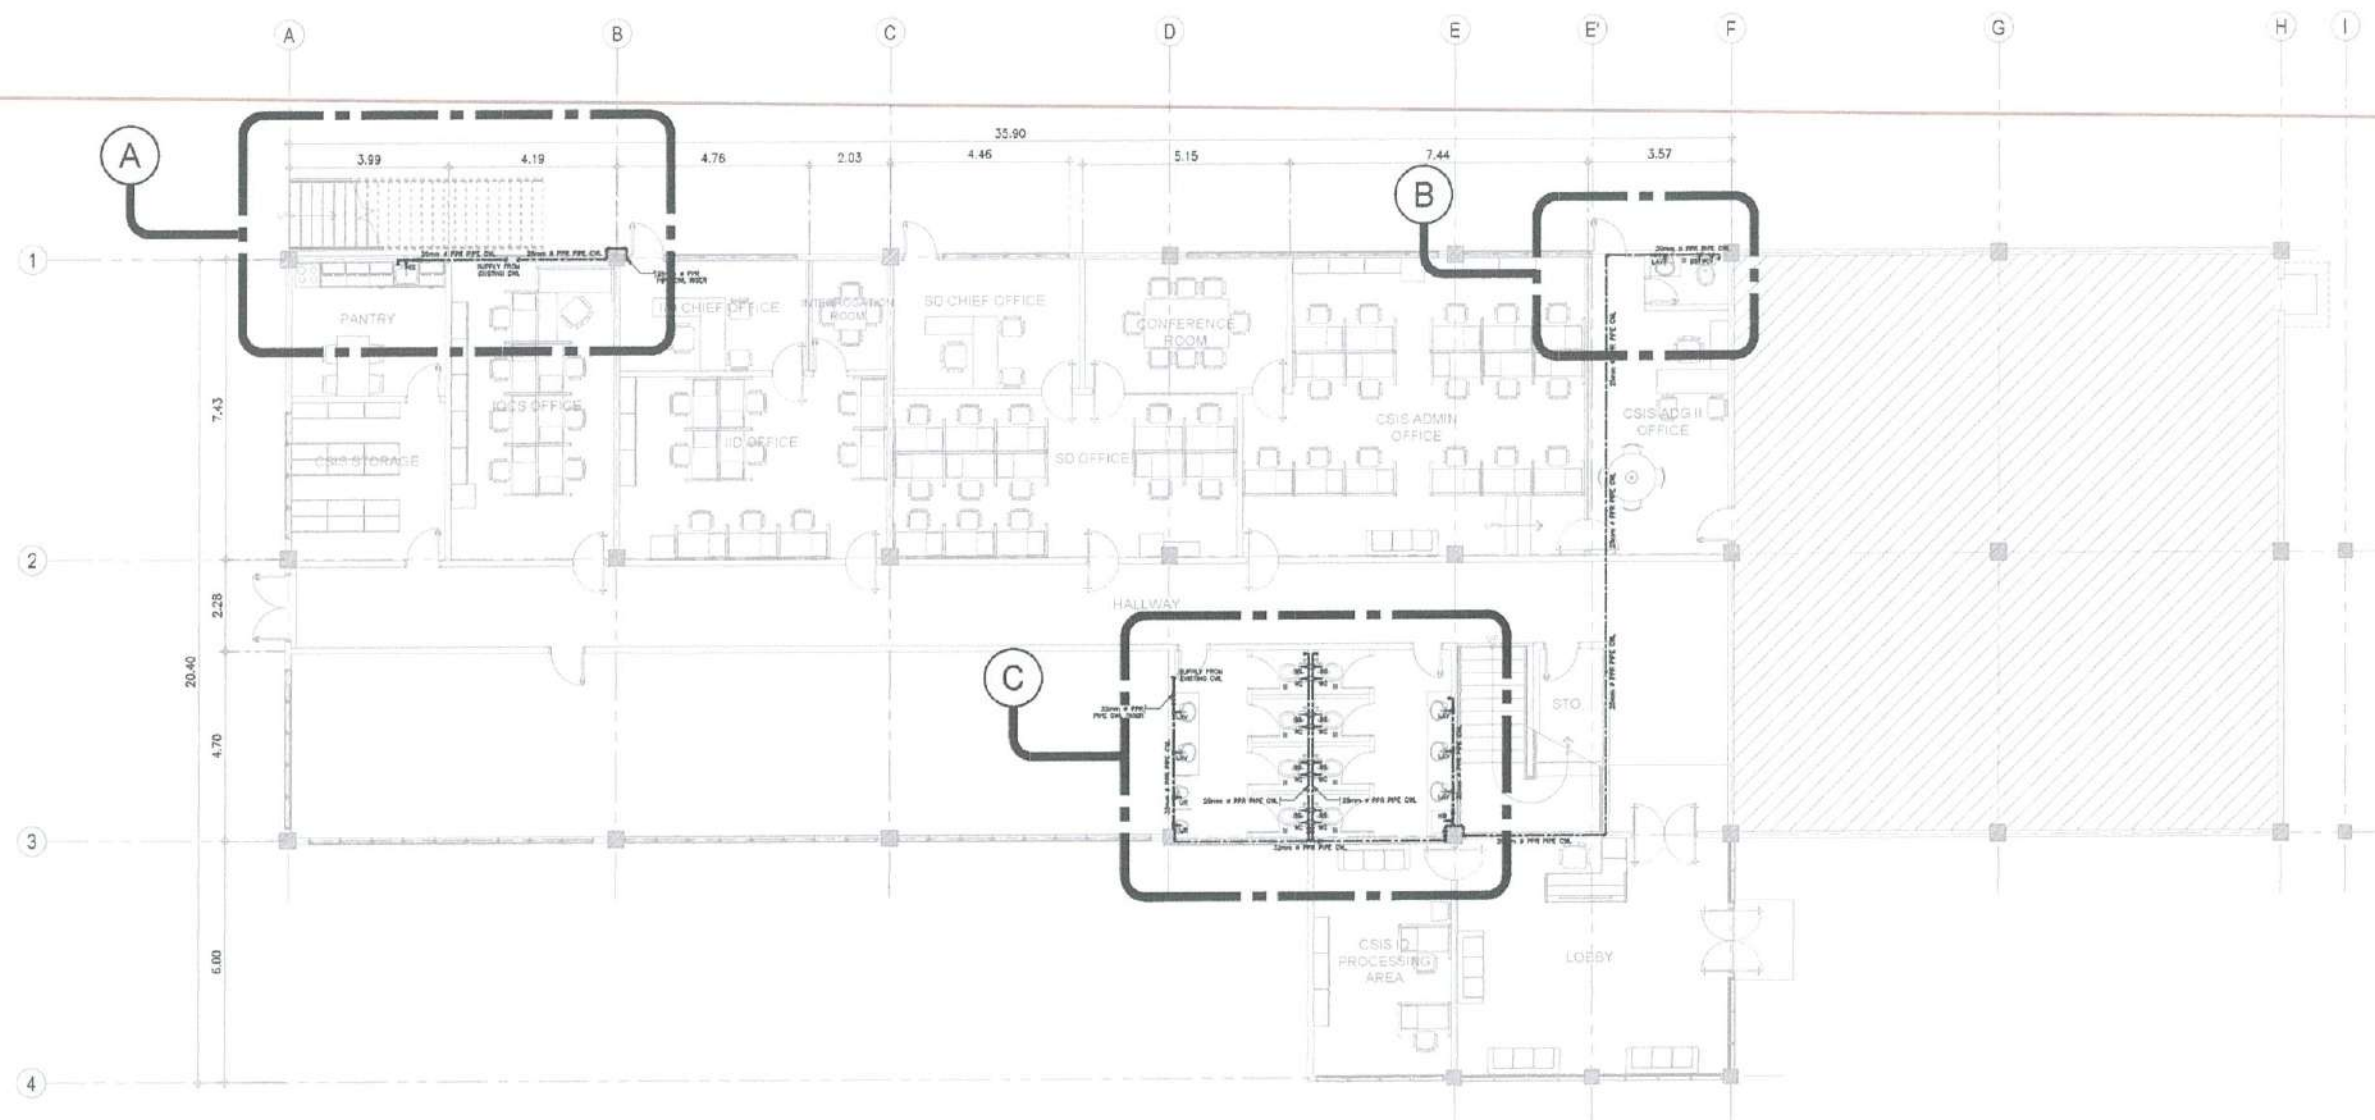

1 GROUND FLOOR
COLD WATER LINE PIPING LAYOUT
SCALE: 1:100M



REPUBLIC OF THE PHILIPPINES
CIVIL AVIATION AUTHORITY OF THE PHILIPPINES
AERODROME DEVELOPMENT AND MANAGEMENT SERVICE
NAIA RD. 138 PASAY CITY

THIS DRAWINGS AND DESIGN IS EXCLUSIVE
PROPERTY OF CIVIL AVIATION AUTHORITY
OF THE PHILIPPINES AND SUCH MUST NOT BE
REPRODUCED, EXHIBITED, LOANED NOR
COPIED IN PART OR IN WHOLE WITHOUT
PROPER PERMISSION AND/OR WRITTEN
CONSENT FROM THE DIRECTOR GENERAL
CAAP.

AERODROME DEVELOPMENT
AND MANAGEMENT SERVICE

INFRASTRUCTURE DEVELOPMENT AND DESIGN
DIVISION

DESIGN STAFF: INITIAL / DATE
DESIGNED BY: IDDD
DRAWN BY: JCCS
CHECKED BY: CDJB
EJDU

REVIEWED BY:

RAUL R. BRUCENA
Division Chief, IDDD-AED

SUBMITTED BY:

ARNEL F. BORLADO
Department Manager III, AED-ADMS

RECOMMEND APPROVAL:

LT COL. VALENTINO A. DIONELA PAF (RET)
Assistant Director General II, ADMS

APPROVED BY:

CAPTAIN MANUEL ANTONIO L. TAMAYO
Director General


NOTES/REVISIONS:

PROJECT:
IMPROVEMENT/REHABILITATION
OF AIRWAYS FACILITY COMPLEX
BUILDING

LOCATION:
CAAP CENTRAL OFFICE
NAIA RD. COR. N. AQUINO AVENUE,
PASAY CITY


SHEET CONTENTS

DRAWING SCALE: SHEET NO:
P 008

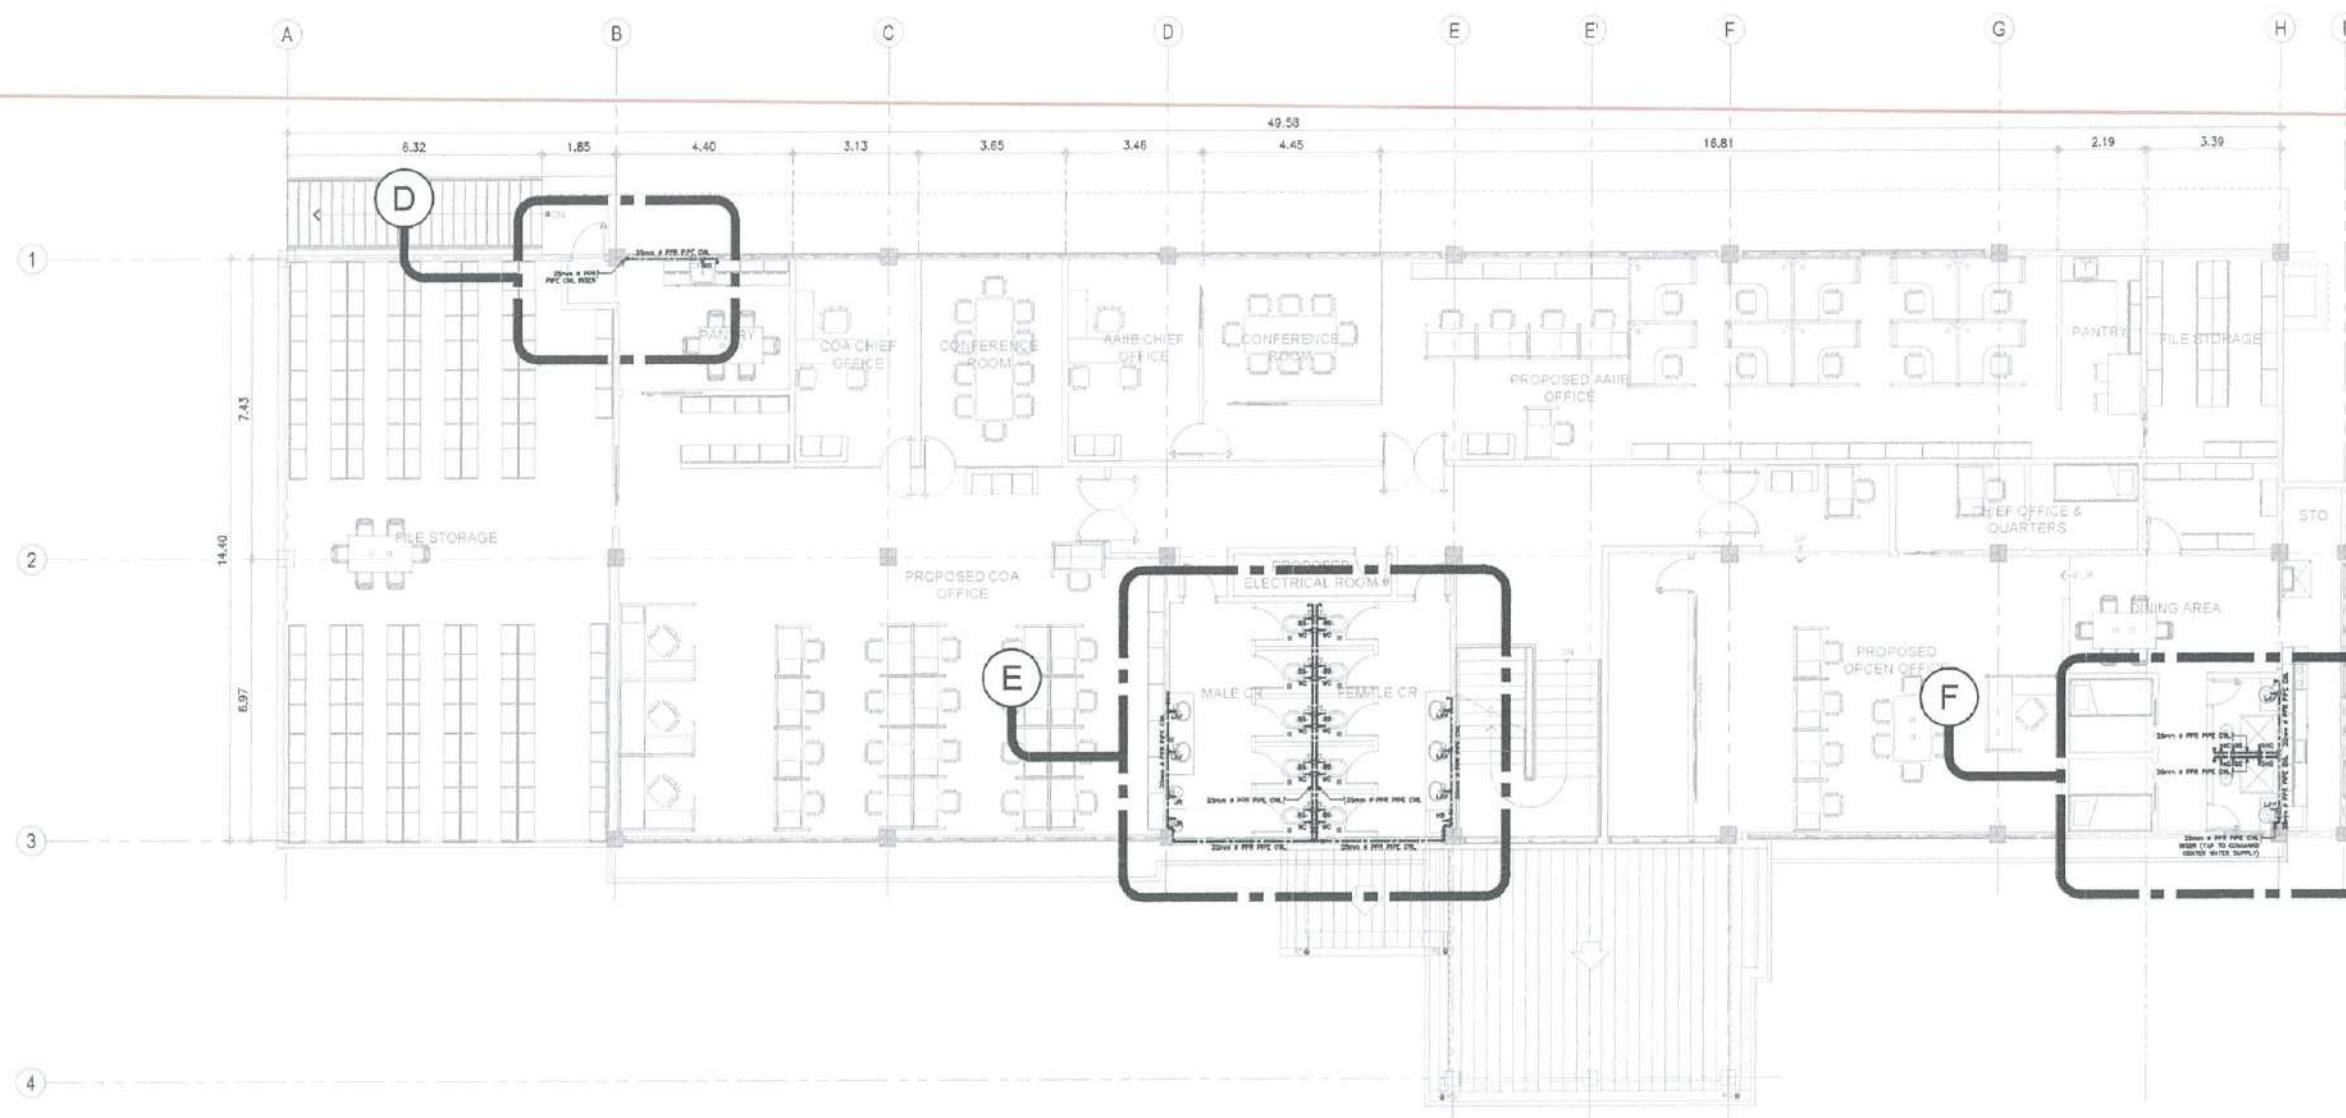


1 SECOND FLOOR
COLD WATER LINE PIPING LAYOUT
SCALE: 1:100M

19 4.19 4.7

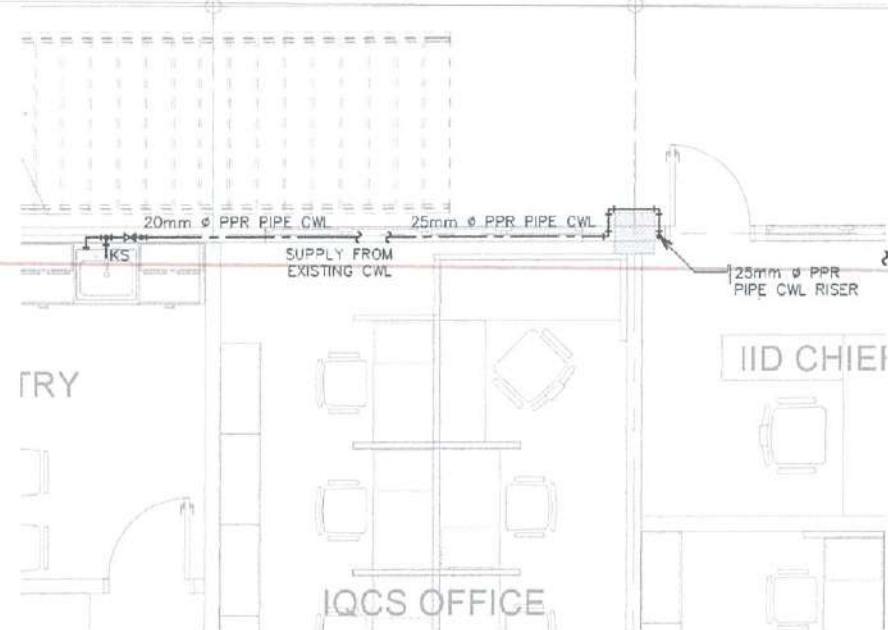

1 BLOW-UP 'A'
ENLARGED COLD WATER LINE LAYOUT
SCALE: 1:40M

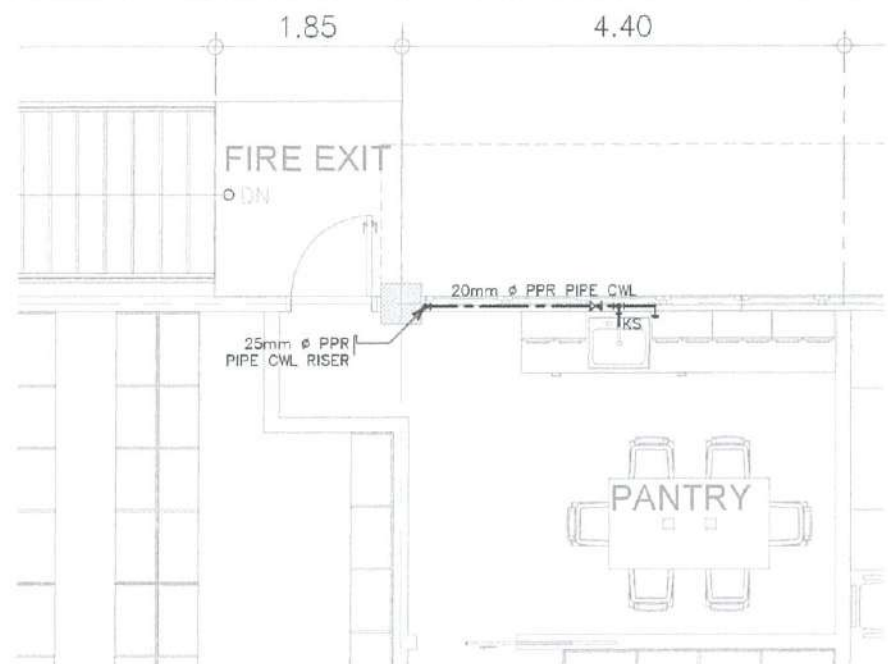

2 BLOW-UP 'D'
ENLARGED COLD WATER LINE LAYOUT
SCALE: 1:40M



3 BLOW-UP 'C' & 'E'
ISOMETRIC VIEW
SCALE: 1:40M



REPUBLIC OF THE PHILIPPINES
CIVIL AVIATION AUTHORITY OF THE PHILIPPINES
AERODROME DEVELOPMENT AND MANAGEMENT SERVICE
NAIA ROAD, 1305 PASAY CITY

THIS DRAWING AND DESIGN IS EXCLUSIVE PROPERTY OF CIVIL AVIATION AUTHORITY OF THE PHILIPPINES AND SUCH MUST NOT BE REPRODUCED, EXHIBITED, LOANED NOR COPIED IN PART OR IN WHOLE WITHOUT PROPER PERMISSION AND/OR WRITTEN CONSENT FROM THE DIRECTOR GENERAL CAAP.

AERODROME DEVELOPMENT AND MANAGEMENT SERVICE

INFRASTRUCTURE DEVELOPMENT AND DESIGN DIVISION

DESIGN STAFF:	INITIAL / DATE
DESIGNED BY:	1000
DRAWN BY:	JCS
CHECKED BY:	CDJB
	EJOJ

REVIEWED BY:

RAUL R. CRUCENA
Division Chief III, IODD-AED

SUBMITTED BY:

ARNEL F. BORLADO
Department Manager II, AED-ACMS

RECOMMEND APPROVAL:

LT COL VALERINO A. DIONELA PAF (RET)
Assistant Director General II, ADMS

APPROVED BY:

CAPTAIN MANUEL S. TAMAYO
Director of Engineering

NOTES/REVISIONS:

PROJECT:
IMPROVEMENT/REHABILITATION
OF AIRWAYS FACILITY COMPLEX
BUILDING


LOCATION:
CAAP CENTRAL OFFICE
NAIA RD. COR. N. AQUINO AVENUE,
PASAY CITY

SHEET CONTENTS


DRAWING SCALE:	SHEET NO:
P	009




1 BLOW-UP 'B'
ENLARGED COLD WATER LINE LAYOUT
SCALE: 1: 40M

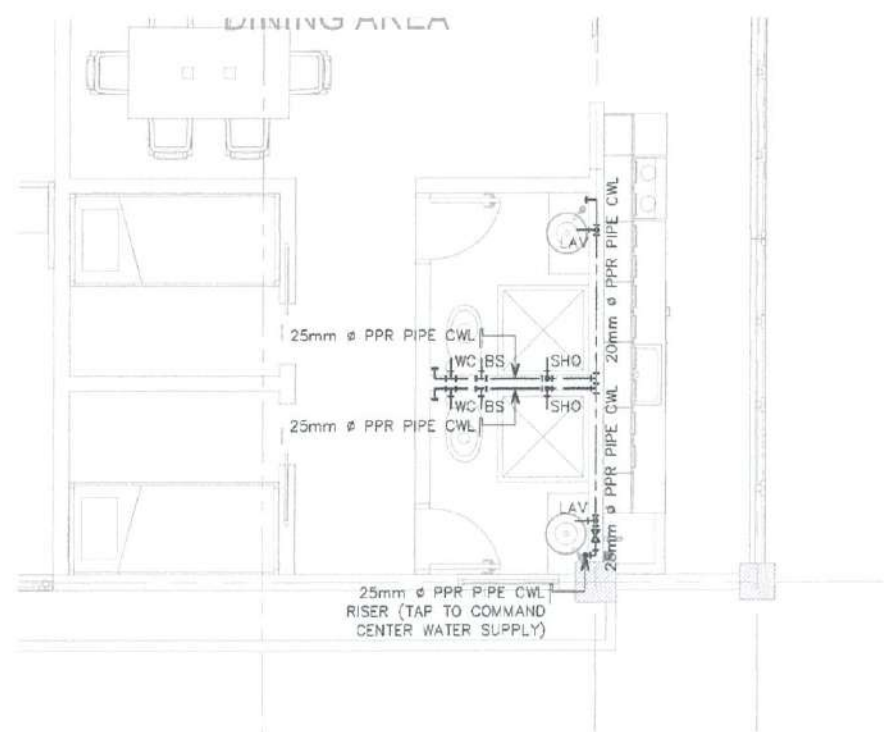

2 BLOW-UP 'F'
ENLARGED COLD WATER LINE LAYOUT
SCALE: 1: 40M

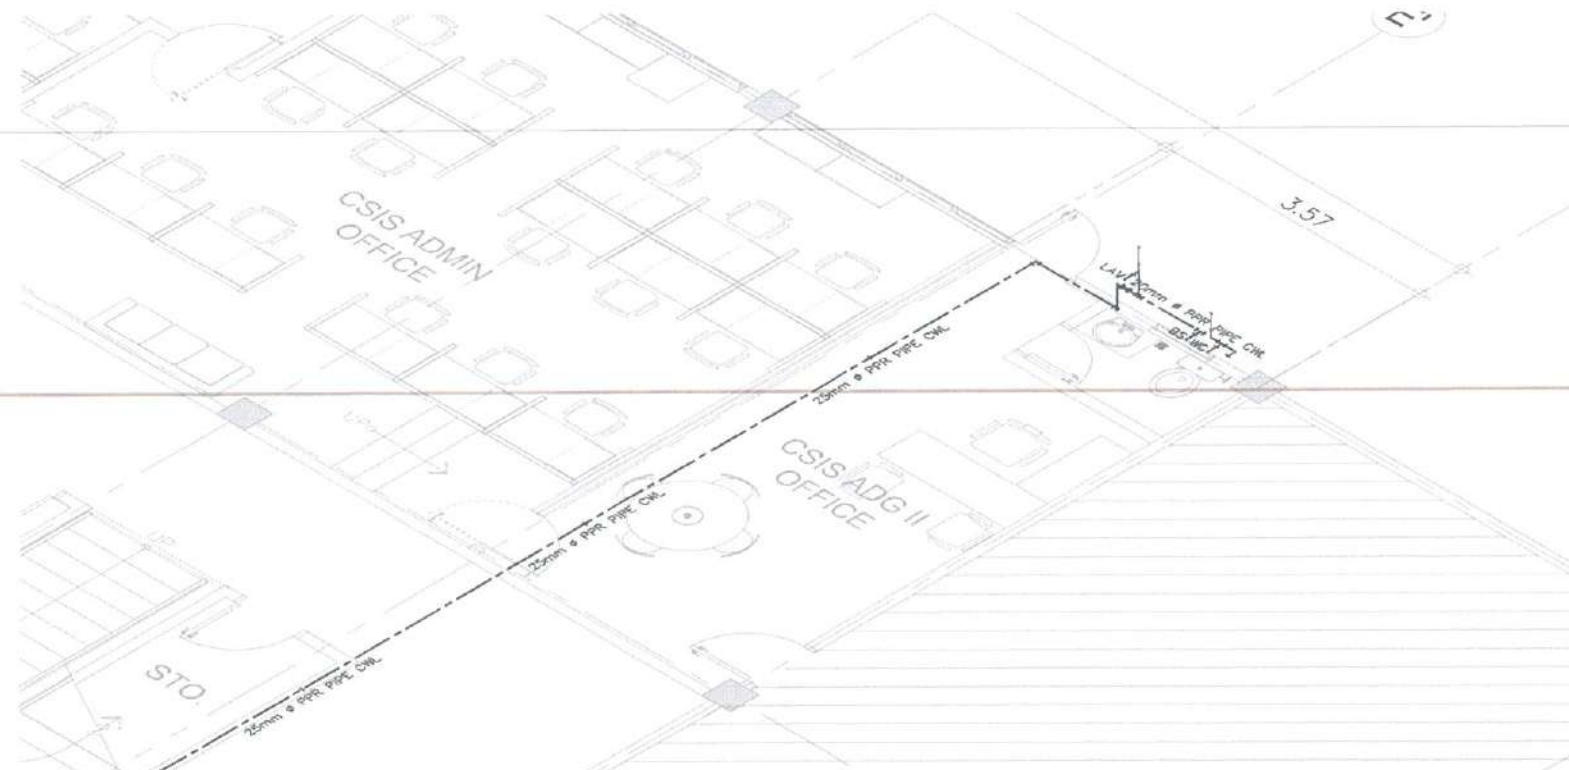

3 BLOW-UP 'B'
ISOMETRIC VIEW
SCALE: 1: 40M

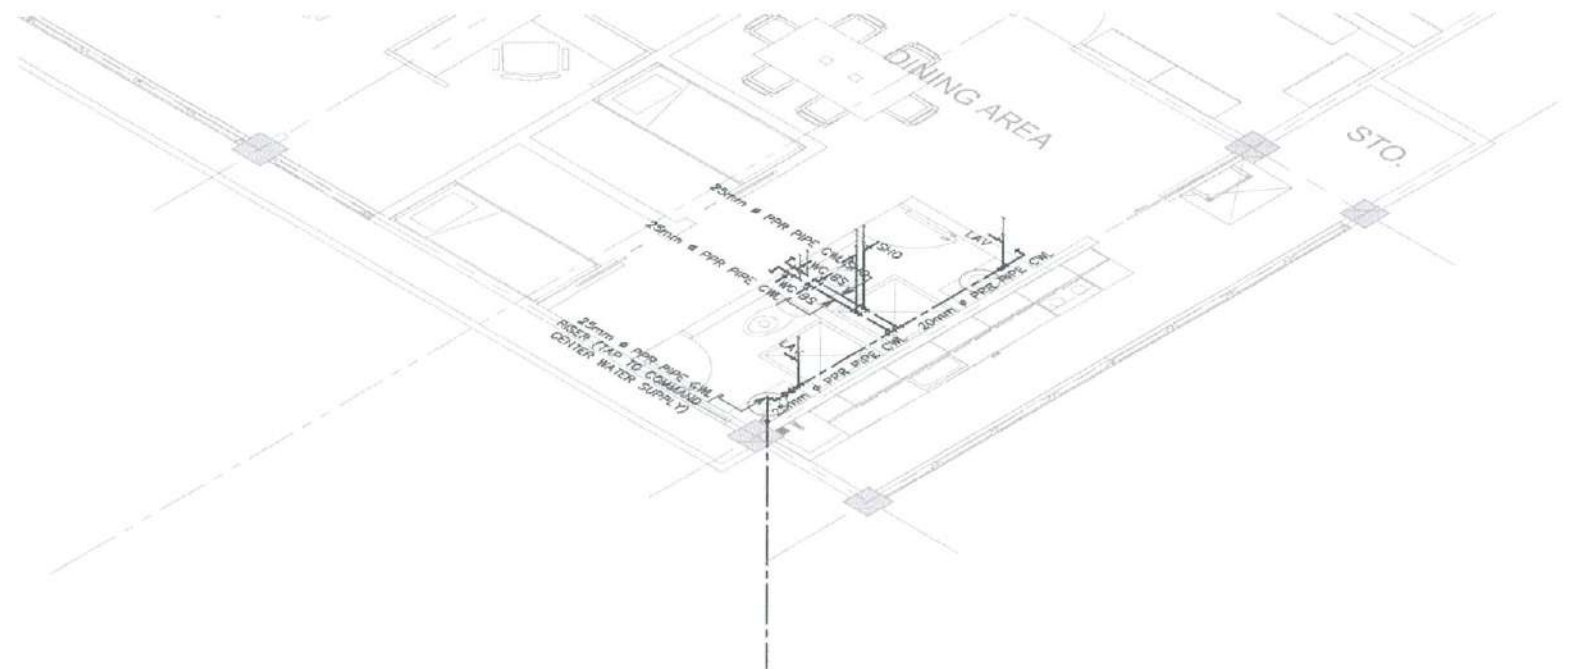

4 BLOW-UP 'F'
ISOMETRIC VIEW
SCALE: 1: 40M



REPUBLIC OF THE PHILIPPINES
CIVIL AVIATION AUTHORITY OF THE PHILIPPINES
AERODROME DEVELOPMENT AND MANAGEMENT SERVICE
NAIA ROAD, 190 PASAY CITY

THIS DRAWINGS AND DESIGN IS EXCLUSIVE
PROPERTIES OF CIVIL AVIATION AUTHORITY
OF THE PHILIPPINES AND SUCH MUST NOT BE
REPRODUCED, EXHIBITED, LOANED NOR
COPIED IN PART OR IN WHOLE WITHOUT
PROPER PERMISSION AND/OR WRITTEN
CONSENT FROM THE DIRECTOR GENERAL
CAAP.

AERODROME DEVELOPMENT
AND MANAGEMENT SERVICE

INFRASTRUCTURE DEVELOPMENT AND DESIGN
DIVISION

DESIGN STAFF:	INITIAL / DATE
DESIGNED BY:	DDO
DRAWN BY:	JCCS
CHECKED BY:	COJB
	EJOJ

REVIEWED BY:

RAUL R. CRUCENA
DIVISION CHIEF III, DDD-AED

SUBMITTED BY:

ARNEL F. BORLADO
Department Manager II, AED-ADMS

RECOMMEND APPROVAL:

LT COL VALENTINO A DIONELA PAF (RET)
Assistant Director General II, ADMS

APPROVED BY:

CAPTAIN ANTONIO L. TAMAYO
Director General

NOTES/REVISIONS:

PROJECT:

IMPROVEMENT/REHABILITATION
OF AIRWAYS FACILITY COMPLEX
BUILDING


LOCATION:

CAAP CENTRAL OFFICE
NAIA RD. COR. N. AQUINO AVENUE,
PASAY CITY


SHEET CONTENTS

DRAWING SCALE:	SHEET NO.
P	010

HALLWAY

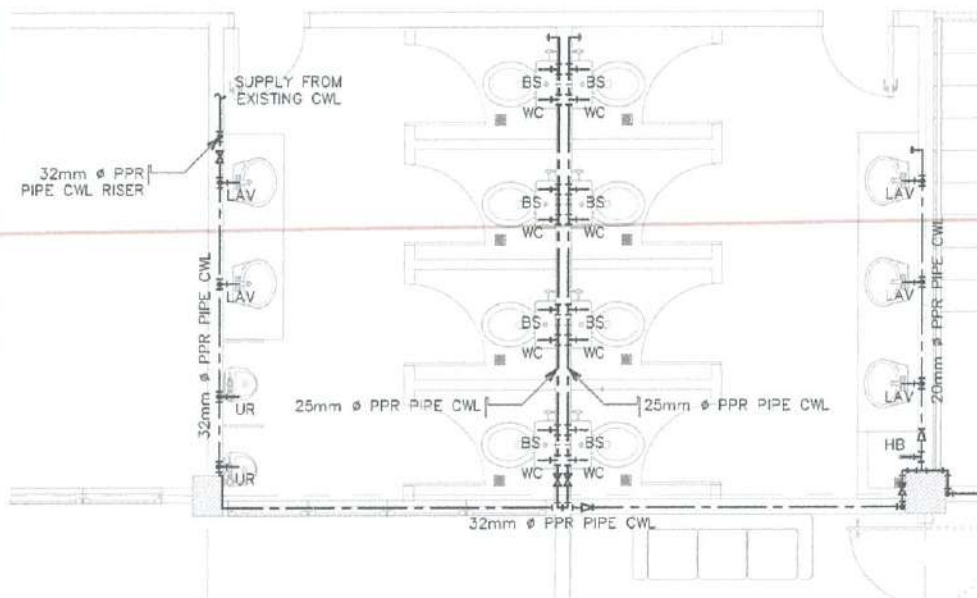

1 BLOW-UP 'C'
ENLARGED COLD WATER LINE LAYOUT
SCALE: 1:40M

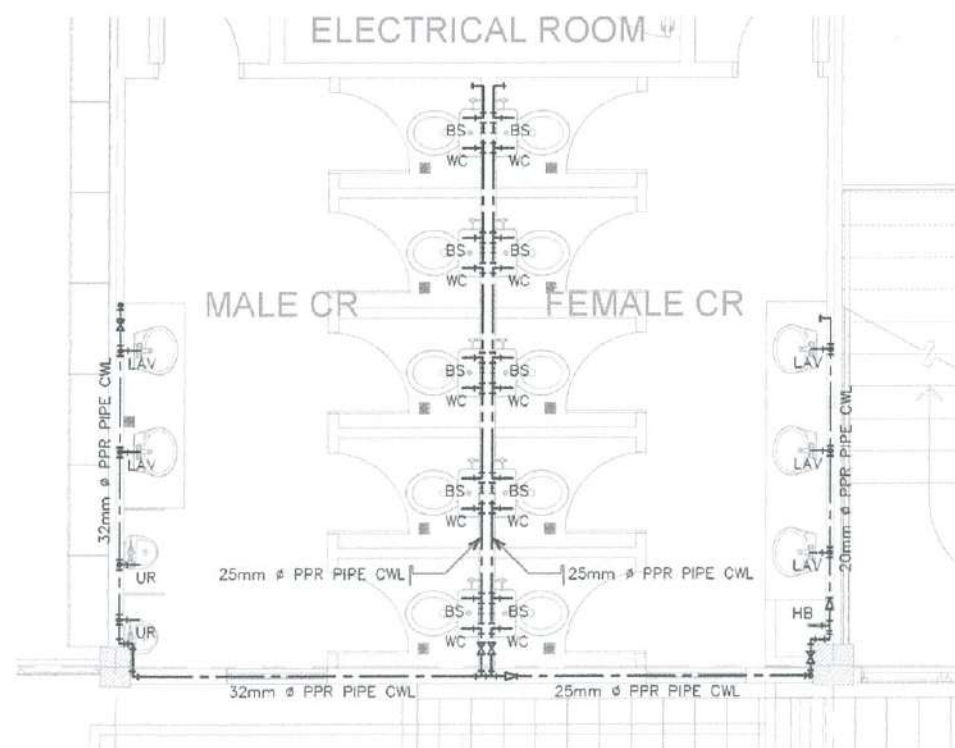

2 BLOW-UP 'E'
ENLARGED COLD WATER LINE LAYOUT
SCALE: 1:40M



3 BLOW-UP 'C' & 'E'
ISOMETRIC VIEW
SCALE: 1:40M



REPUBLIC OF THE PHILIPPINES
CIVIL AVIATION AUTHORITY OF THE PHILIPPINES
AERODROME DEVELOPMENT AND MANAGEMENT SERVICE
NAIA ROAD, 1309 PASAY CITY

THIS DRAWINGS AND DESIGN IS EXCLUSIVE
PROPERTY OF CIVIL AVIATION AUTHORITY
OF THE PHILIPPINES AND SUCH MUST NOT BE
REPRODUCED, EXHIBITED, LOANED NOR
COPIED IN PART OR IN WHOLE WITHOUT
PROPER PERMISSION AND/OR WRITTEN
CONSENT FROM THE DIRECTOR GENERAL
CAAP.

AERODROME DEVELOPMENT
AND MANAGEMENT SERVICE

INFRASTRUCTURE DEVELOPMENT AND DESIGN
DIVISION

DESIGN STAFF:	INITIAL / DATE
DESIGNED BY:	IODD
DRAWN BY:	JCCS
CHECKED BY:	CDJB
	EJOJ

REVIEWED BY:

RAVL R. CRUCENA
Division Chief, IODD-AED

SUBMITTED BY:

ARNEL F. BORLADO
Department Manager II, AED-ADMS

RECOMMEND APPROVAL:

LT COL VALENTINO A. DIONELA, PAF (RET)
Assistant Director General II, ADMS

APPROVED BY:

CAPTAIN M. L. TAMAYO
General

NOTES/REVISIONS:

PROJECT:
IMPROVEMENT/REHABILITATION
OF AIRWAYS FACILITY COMPLEX
BUILDING

LOCATION:
CAAP CENTRAL OFFICE
NAIA RD. COR. N. AQUINO AVENUE,
PASAY CITY

SHEET CONTENTS:

DRAWING SCALE:	SHEET NO:
	P 011



REPUBLIC OF THE PHILIPPINES
CIVIL AVIATION AUTHORITY OF THE PHILIPPINES
AERODROME DEVELOPMENT AND MANAGEMENT SERVICE
NAIA ROAD, PASAY CITY

THIS DRAWINGS AND DESIGN IS EXCLUSIVE
PROPERTIES OF CIVIL AVIATION AUTHORITY
OF THE PHILIPPINES AND SUCH MUST NOT BE
REPRODUCED, EXHIBITED, LOANED NOR
COPIED IN PART OR IN WHOLE WITHOUT
PROPER PERMISSION AND/OR WRITTEN
CONSENT FROM THE DIRECTOR GENERAL
CAAP.

AERODROME DEVELOPMENT
AND MANAGEMENT SERVICE

INFRASTRUCTURE DEVELOPMENT AND DESIGN
DIVISION

DESIGN STAFF:	INITIAL / DATE
DESIGNED BY:	IDDD
DRAWN BY:	JCCS
CHECKED BY:	CDJB
	EUDJ

REVIEWED BY:

RAUL P. CRUCENA
Division Chief III, IDDD-AED

SUBMITTED BY:

ARNEL F. BORLADO
Department Manager II, AED-ADMG

RECOMMEND APPROVAL:

LT COL VALENTINO A. DIONELA PAF (RET)
Assistant Director General II, ADMG

APPROVED BY:

CAPTAIN MARCELINO L. TAMAYO
Director General


NOTES/REVISIONS:

PROJECT:
IMPROVEMENT/REHABILITATION
OF AIRWAYS FACILITY COMPLEX
BUILDING


LOCATION:
CAAP CENTRAL OFFICE
NAIA RD. COR. N. AQUINO AVENUE,
PASAY CITY

SHEET CONTENTS

DRAWING SCALE:	SHEET NO:
	P 012

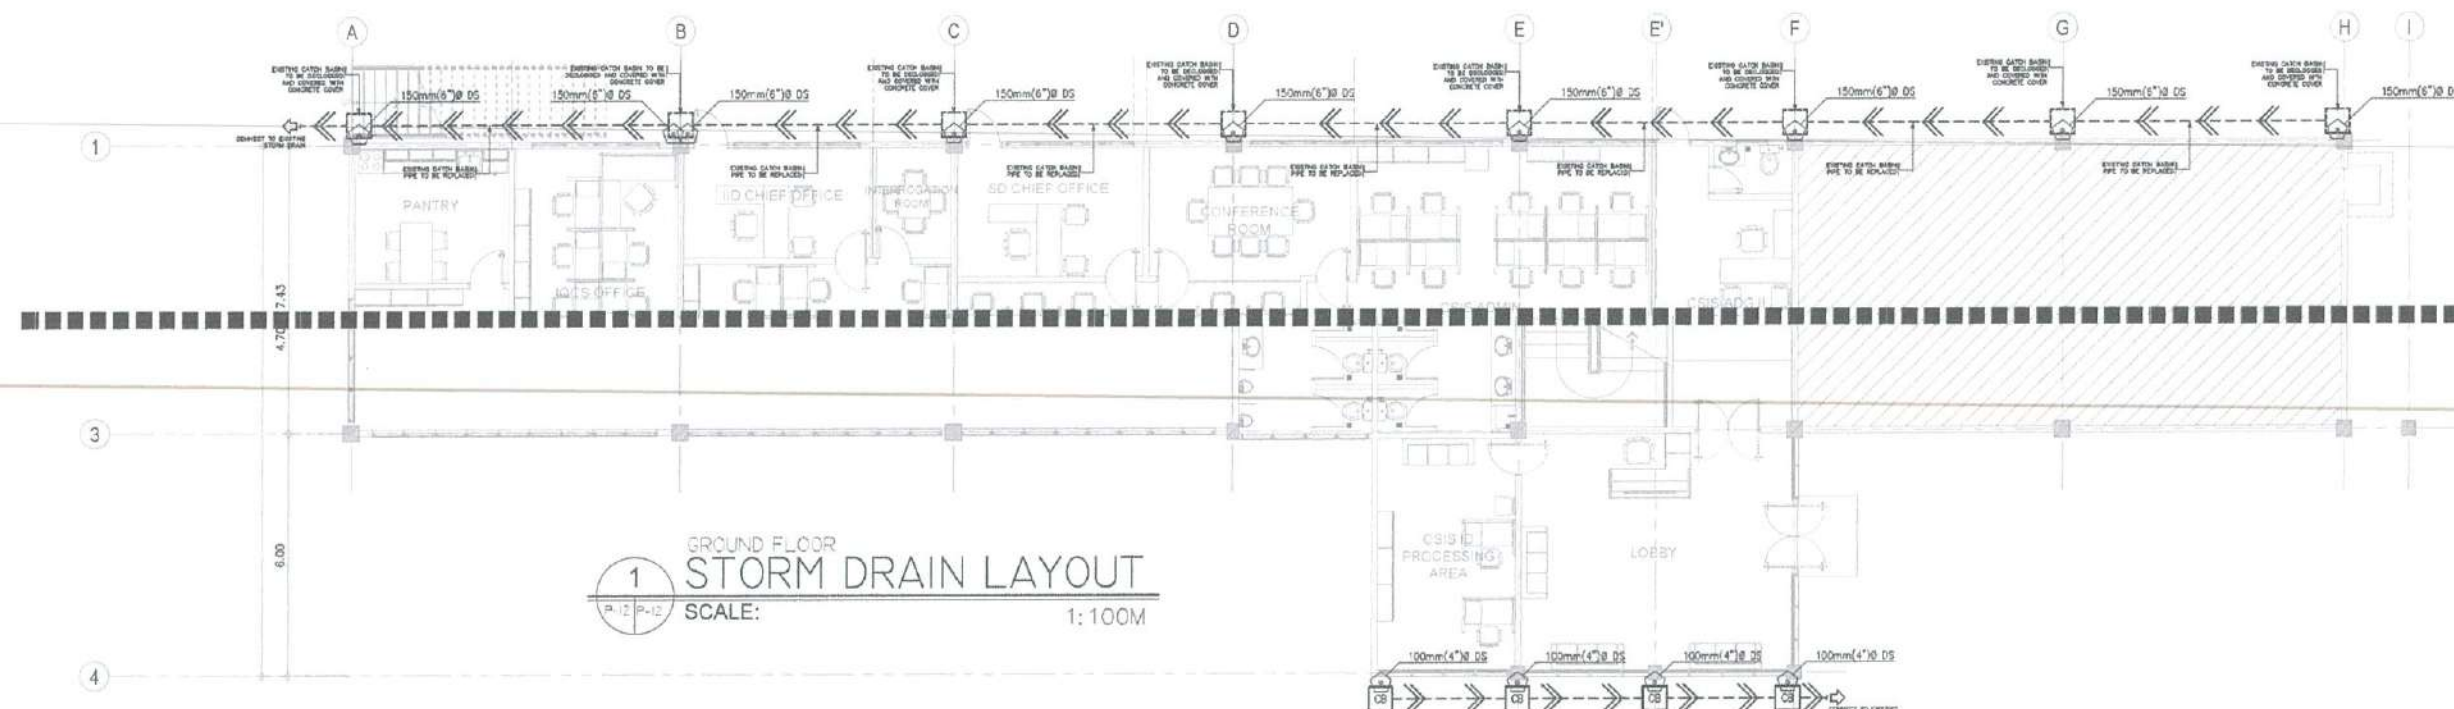

1 GROUND FLOOR
STORM DRAIN LAYOUT
SCALE: 1:100

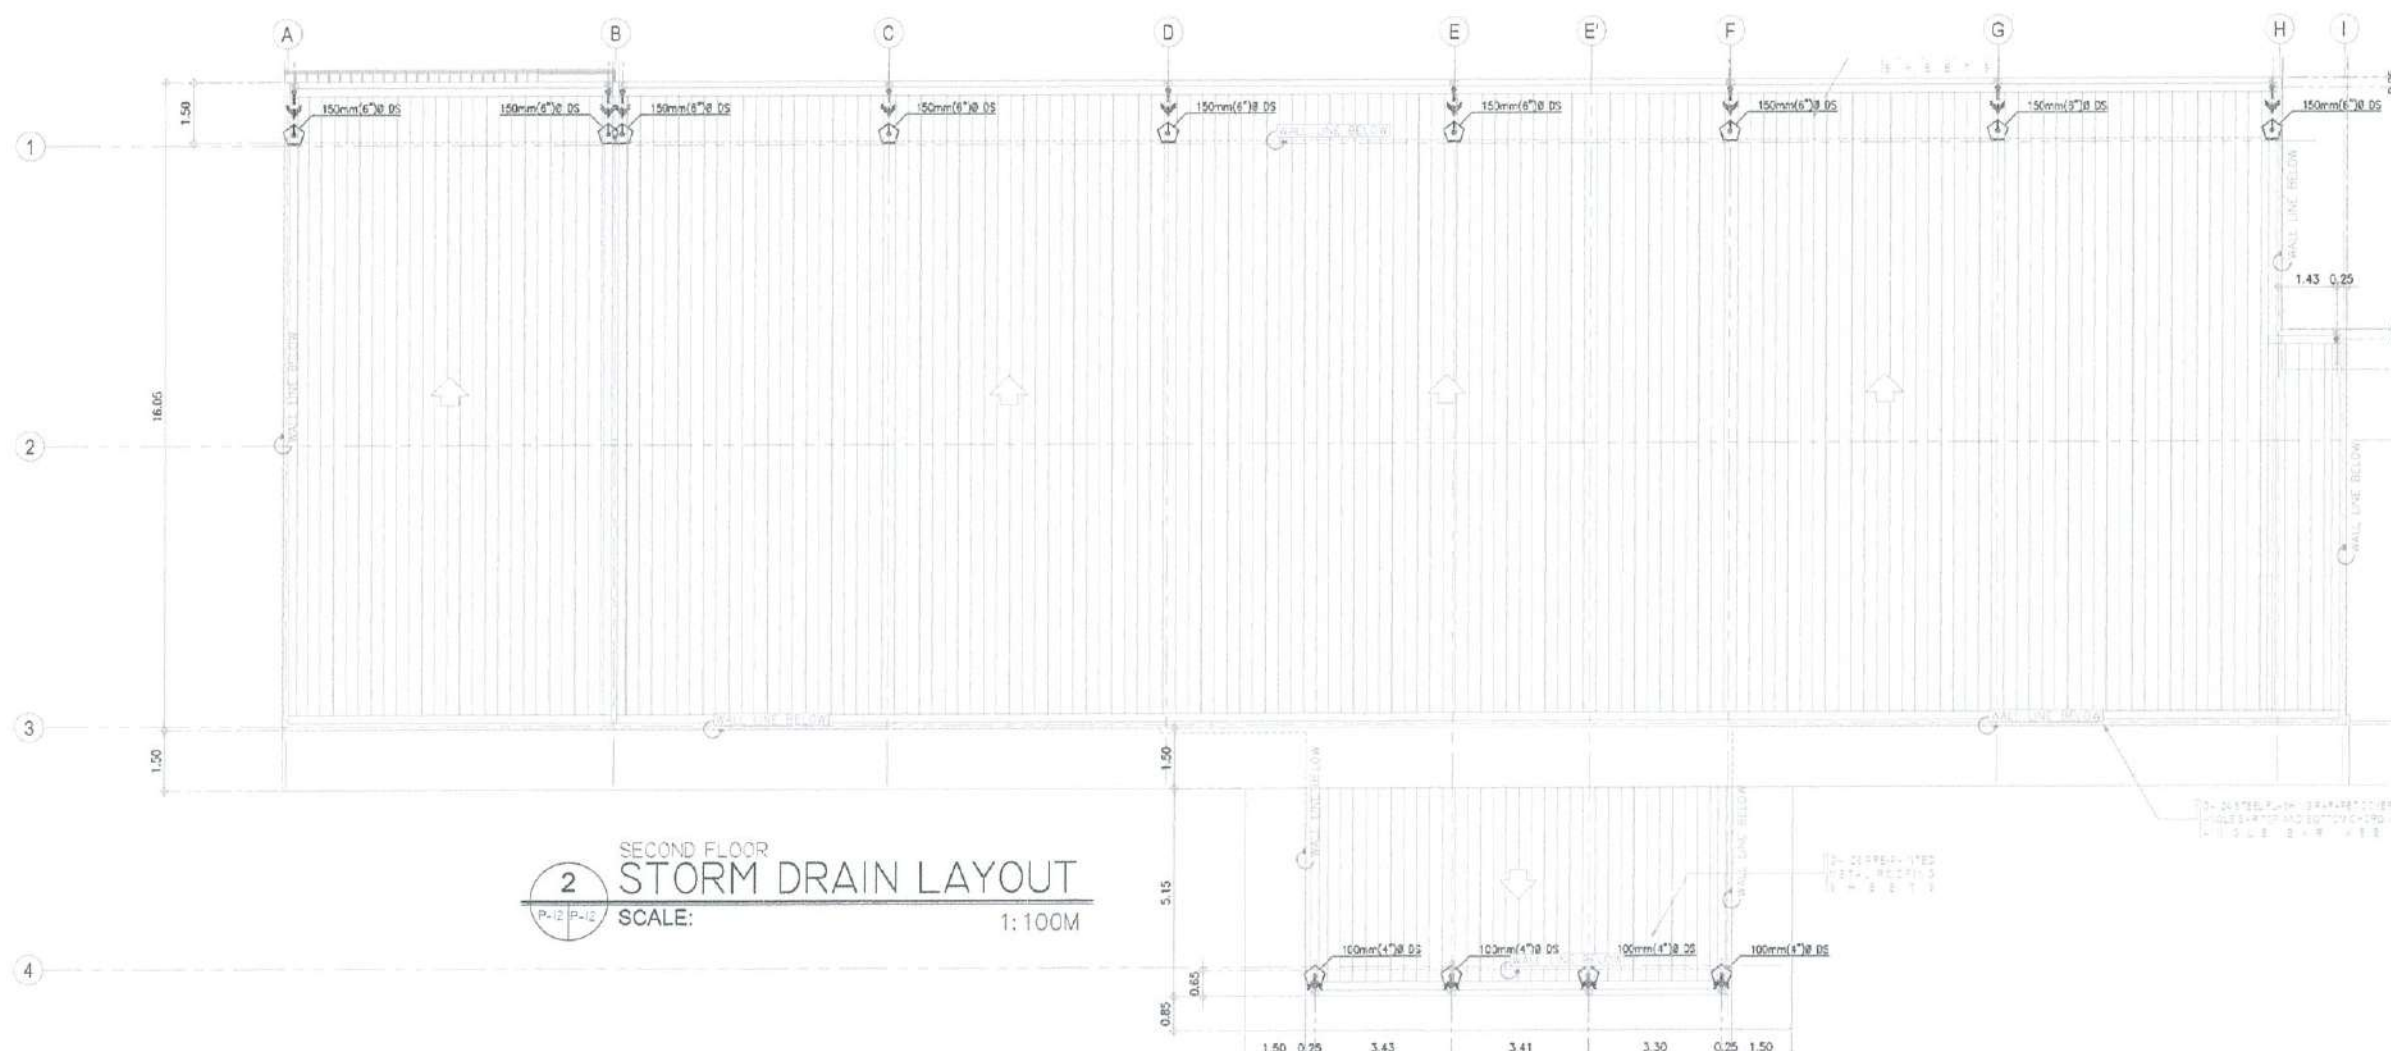

2 SECOND FLOOR
STORM DRAIN LAYOUT
SCALE: 1:100



REPUBLIC OF THE PHILIPPINES
CIVIL AVIATION AUTHORITY OF THE PHILIPPINES
AERODROME DEVELOPMENT AND MANAGEMENT SERVICE
NAIA RD., THE FAIRY CITY

THIS DRAWING AND DESIGN IS EXCLUSIVE
PROPERTY OF CIVIL AVIATION AUTHORITY
OF THE PHILIPPINES AND SUCH MUST NOT BE
REPRODUCED, EXHIBITED, LOANED NOR
COPIED IN PART OR IN WHOLE WITHOUT
PROPER PERMISSION AND/OR WRITTEN
CONSENT FROM THE DIRECTOR GENERAL
CAAP.

AERODROME DEVELOPMENT
AND MANAGEMENT SERVICE

INFRASTRUCTURE DEVELOPMENT AND DESIGN
DIVISION

DESIGN STAFF	INITIAL / DATE
DESIGNED BY:	IDDD
DRAWN BY:	JCCS
CHECK-EC BY:	COJB
	EJDU

REVIEWED BY:

RAUL R. CRUCENA
DIVISION CHIEF, IDDD-AED

SUBMITTED BY:

ARNEL F. BORLADO
Department Manager III, AED-ADMS

RECOMMEND APPROVAL:

LT COL VALENTINO A. DIONELA PAE RIEI
Assistant Director General II, ADMS

APPROVED BY:

CAPTAIN MANUEL ANTONIO L. TAMAYO
Director General

NOTES/REVISIONS:

PROJECT:


IMPROVEMENT/REHABILITATION
OF AIRWAYS FACILITY COMPLEX
BUILDING

LOCATION:

CAAP CENTRAL OFFICE
NAIA RD. COR. N. AQUINO AVENUE,
PASAY CITY

SHEET CONTENTS

DRAWING SCALE	SHEET NO.
P	013

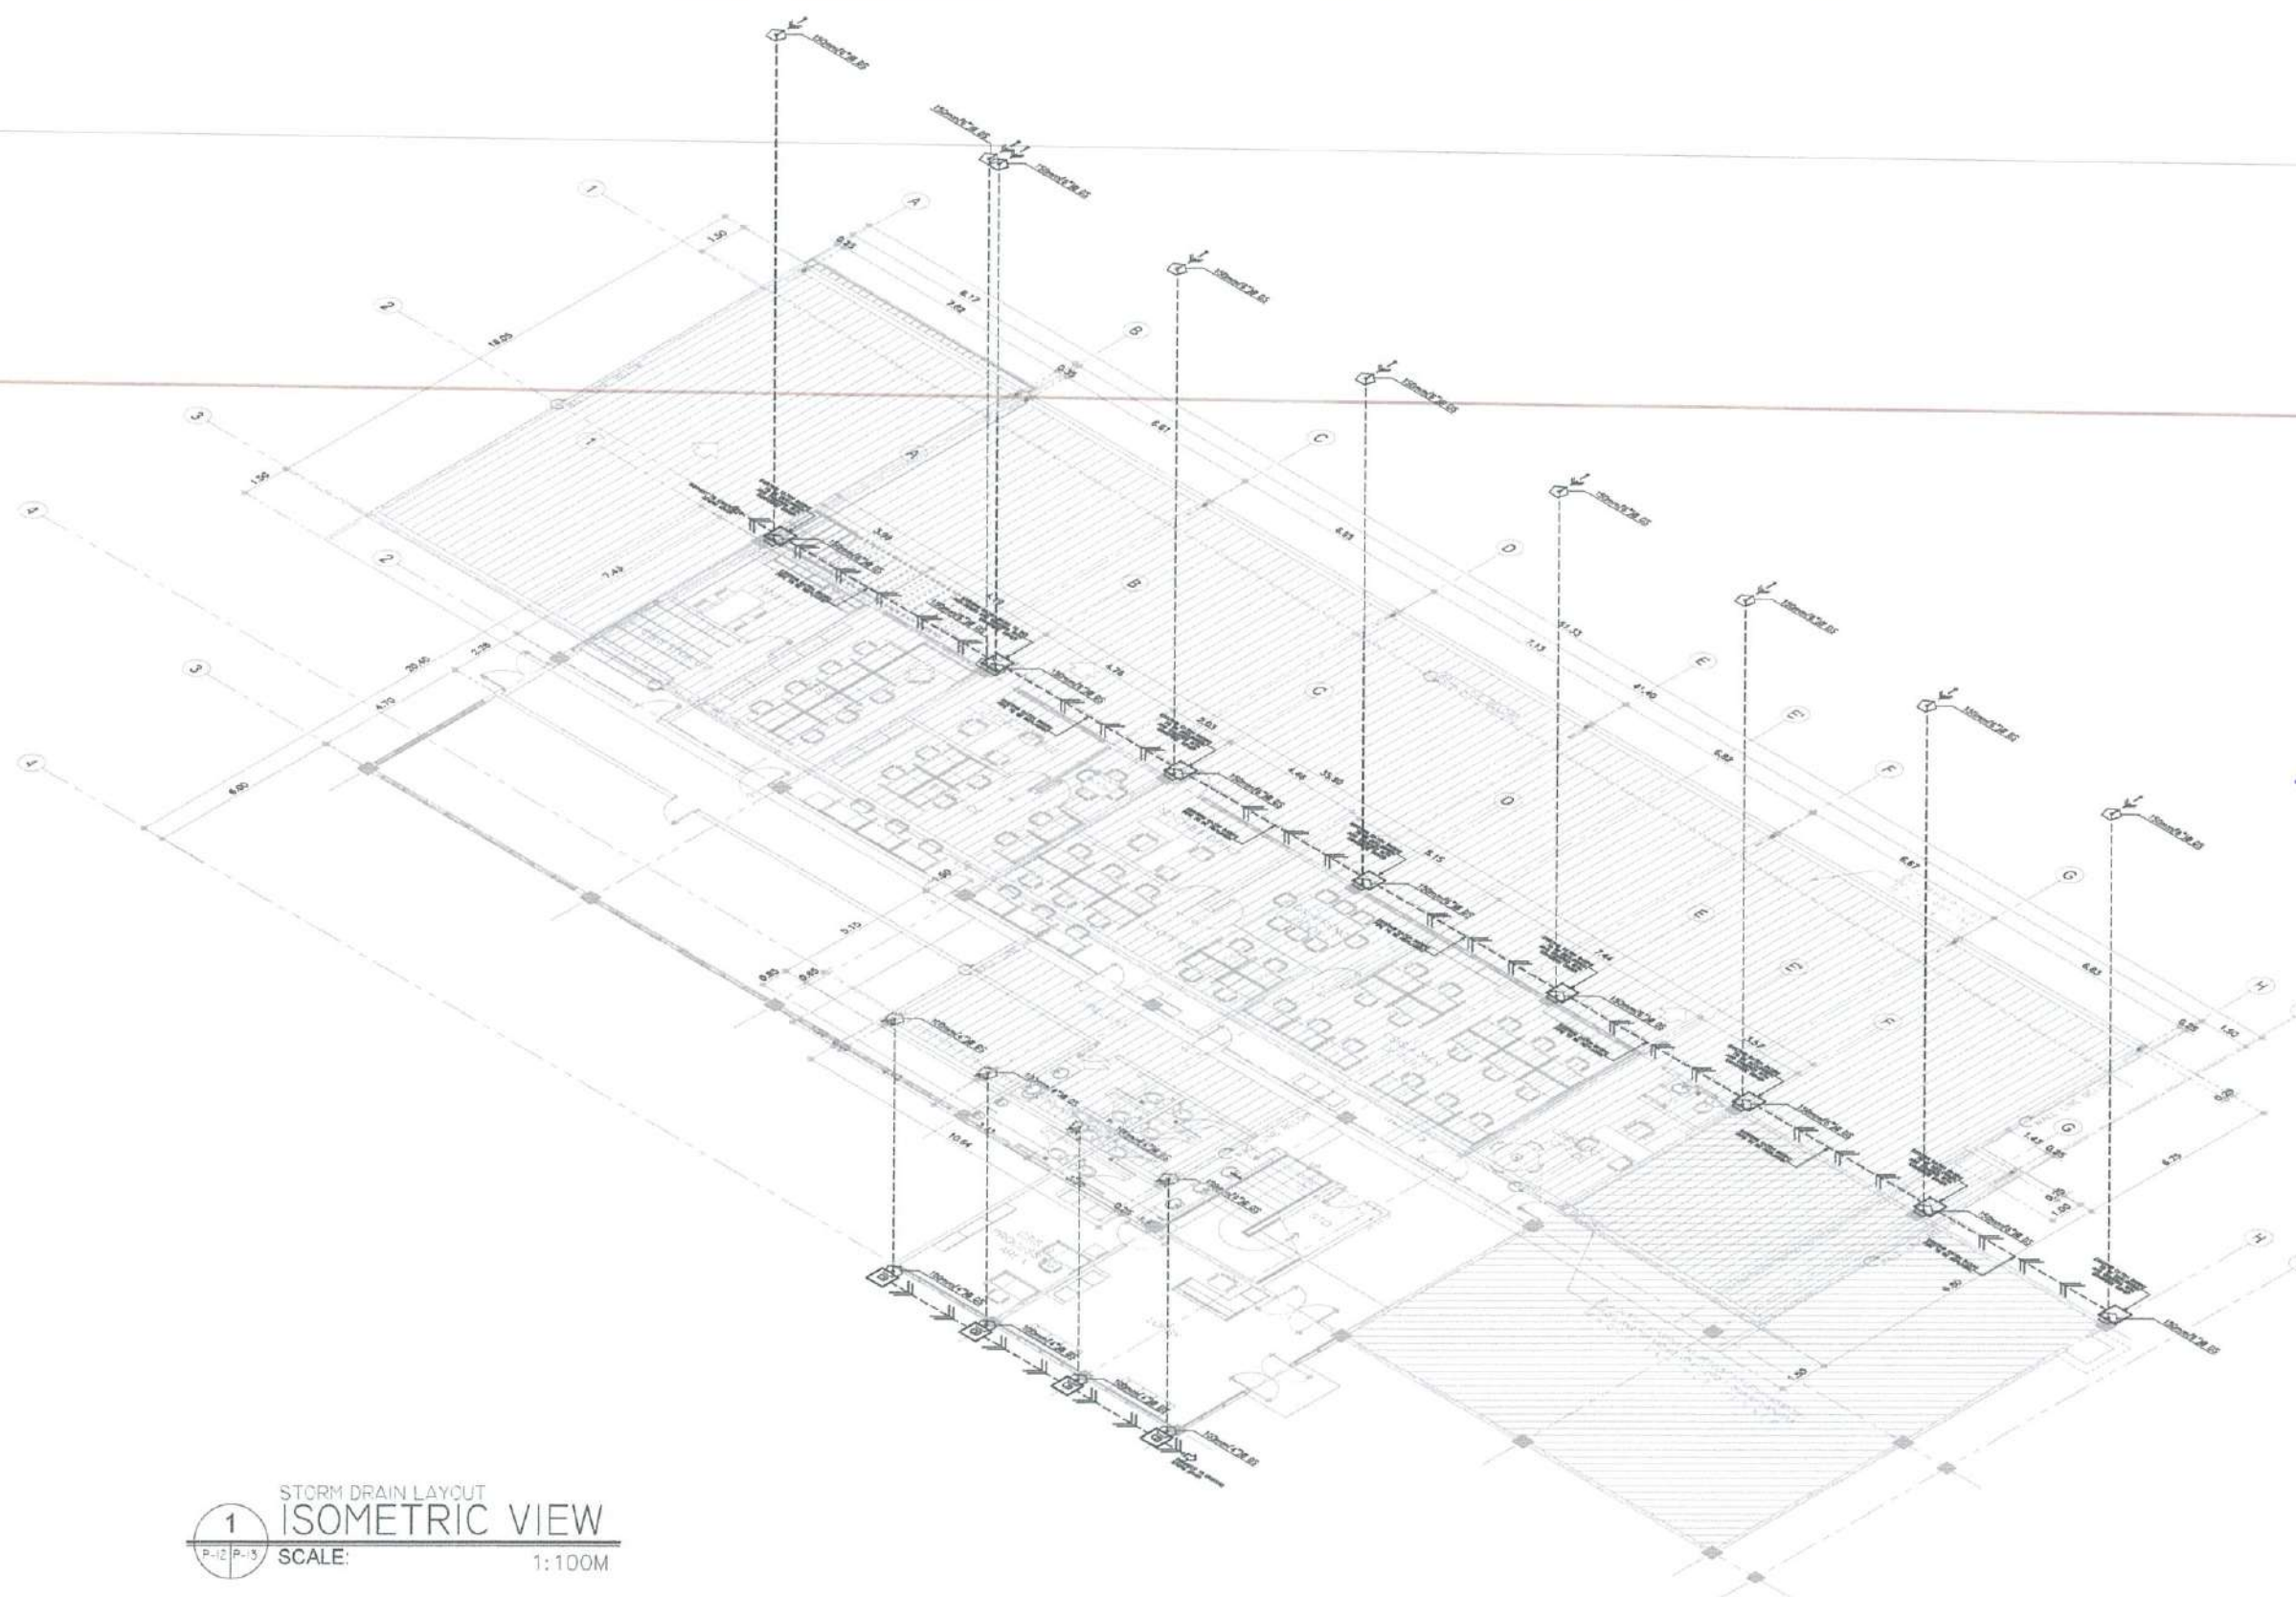

1
P-12 P-13
STORM DRAIN LAYOUT
ISOMETRIC VIEW
SCALE: 1:100M



REPUBLIC OF THE PHILIPPINES
CIVIL AVIATION AUTHORITY OF THE PHILIPPINES
AERODROME DEVELOPMENT AND MANAGEMENT SERVICE
NAIA ROAD, 1500 PASAY CITY

THIS DRAWINGS AND DESIGN IS EXCLUSIVE PROPERTY OF CIVIL AVIATION AUTHORITY OF THE PHILIPPINES AND SUCH MUST NOT BE REPRODUCED, EXHIBITED, LOANED NOR COPIED IN PART OR IN WHOLE WITHOUT PROPER PERMISSION AND/OR WRITTEN CONSENT FROM THE DIRECTOR GENERAL CAA.

AERODROME DEVELOPMENT AND MANAGEMENT SERVICE

INFRASTRUCTURE DEVELOPMENT AND DESIGN DIVISION

DESIGN STAFF: INITIAL / DATE

DESIGNED BY:	1000
DRAWN BY:	JCCS
CHECKED BY:	CDJ
REVIEWED BY:	

REVIEWED BY:

RAULY CRUCENA
Division Chief III, IDDD-AED

SUBMITTED BY:
ARNEL F. BORLADO
Department Manager III, AED-ADMS

RECOMMEND APPROVAL:
LT COL VALENTINO A. DIONELA PAX (RET)
Assistant Director General II, ADMS

APPROVED BY:
CAPTAIN MANUEL ANTONIO L. TAMAYO
Division Chief II


NOTES/REVISIONS:

PROJECT:
IMPROVEMENT/REHABILITATION OF AIRWAYS FACILITY COMPLEX BUILDING


LOCATION:
CAAP CENTRAL OFFICE
NAIA RD. COR. N. AQUINO AVENUE,
PASAY CITY

SHEET CONTENTS


DRAWING SCALE:	SHEET NO:
	P 014

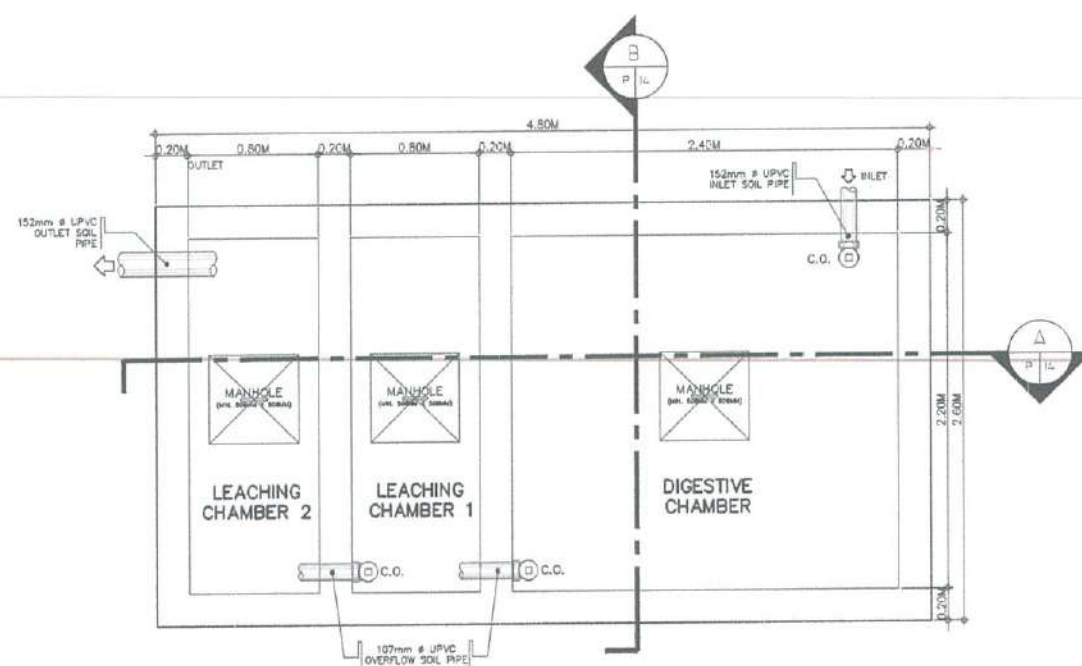


PLAN

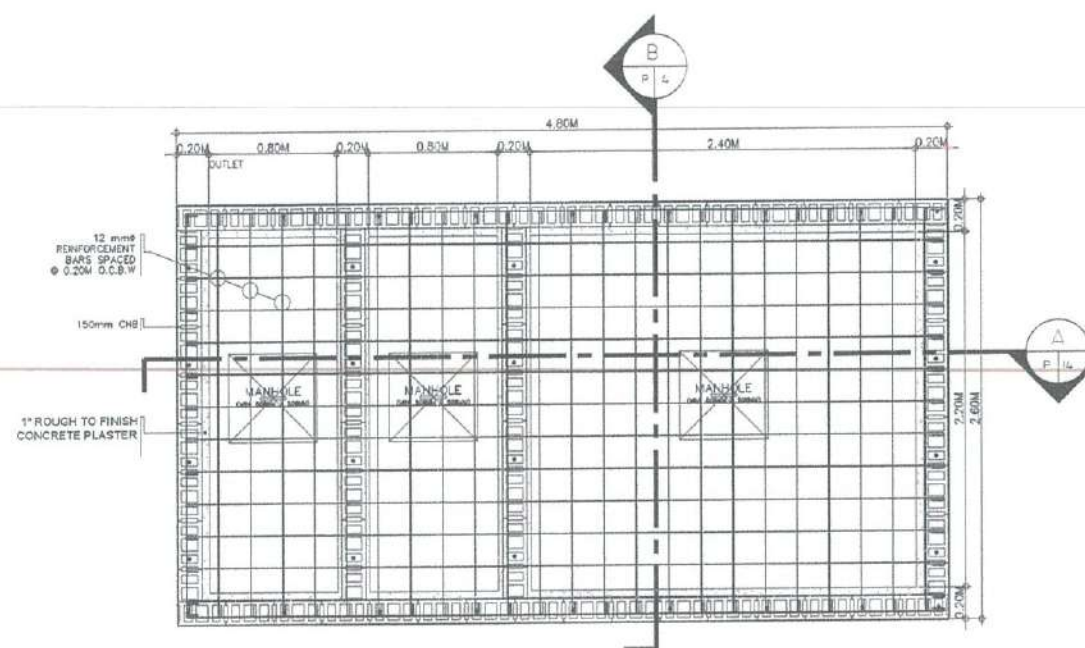

STRUCTURAL PLAN

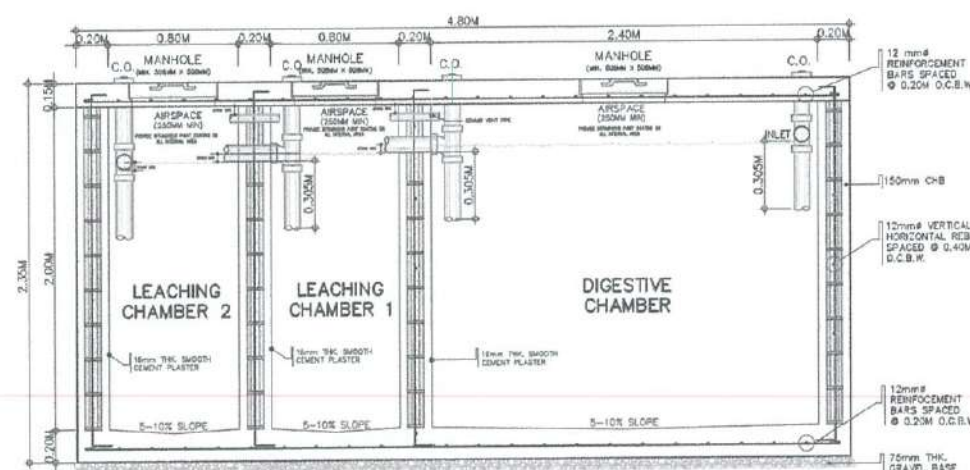

SECTION 'A'

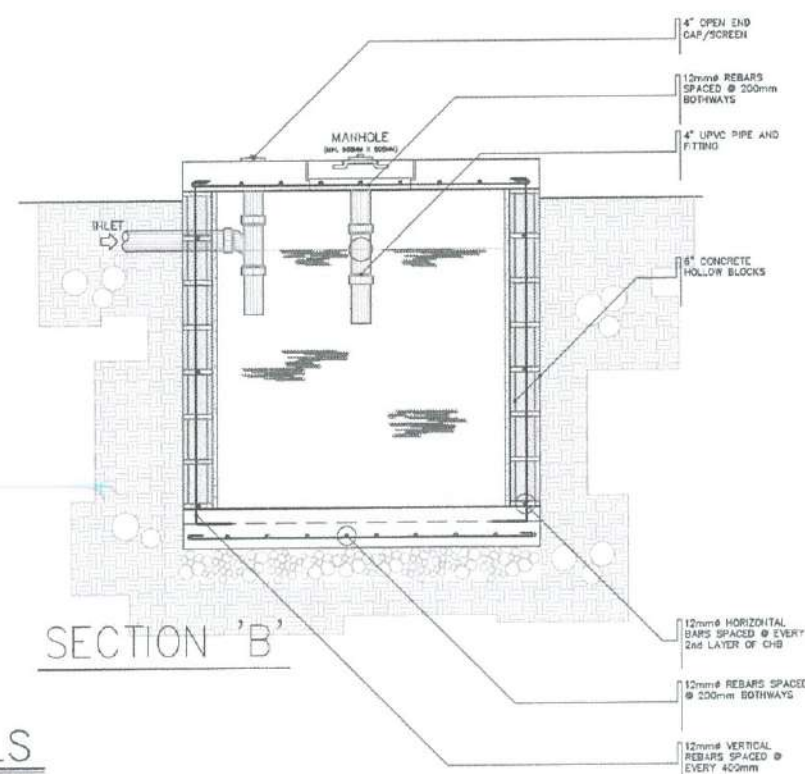

SECTION 'B'

1 SEPTIC TANK DETAILS
SCALE: 1:25M