

THIS DRAWING AND DESIGN IS EXCLUSIVE PROPERTIES OF CIVIL AVIATION AUTHORITY OF THE PHILIPPINES AND SUCH MUST NOT BE REPRODUCED, EXHIBITED, LOANED NOR COPIED IN PART OR IN WHOLE WITHOUT PROPER PERMISSION AND/OR WRITTEN CONSENT FROM THE DIRECTOR GENERAL CAAP.

AERODROME DEVELOPMENT AND MANAGEMENT SERVICE

INFRASTRUCTURE DEVELOPMENT AND DESIGN DIVISION


DESIGN STAFF:	INITIAL / DATE
DESIGNED BY:	IDDD
DRAWN BY:	IDDD
CHECKED BY:	

REVIEWED BY:



RAUL R. CRUCENA
 Division Chief III, IDDD-AED

SUBMITTED BY:



ARNEL F. BORLADO
 Department Manager III, AED-ADMS

RECOMMEND APPROVAL:



LT COL VALENTINO A DIONELA PAF (RET)
 Assistant Director General II, ADMS

APPROVED BY:



CAPTAIN MANUEL ANTONIO L. TAMAYO
 Director General

NOTES/REVISIONS:

PROJECT:

NEW CAAP BUILDING


LOCATION:

CAAP HEAD OFFICE
NAIA ROAD, PASAY CITY

SHEET CONTENTS:

- SCHEMATIC DIAGRAM - SOIL, WASTE, VENT, STORM AND CONDENSATE DRAIN

DRAWING SCALE:	SHEET NO:
AS SHOWN	P-13

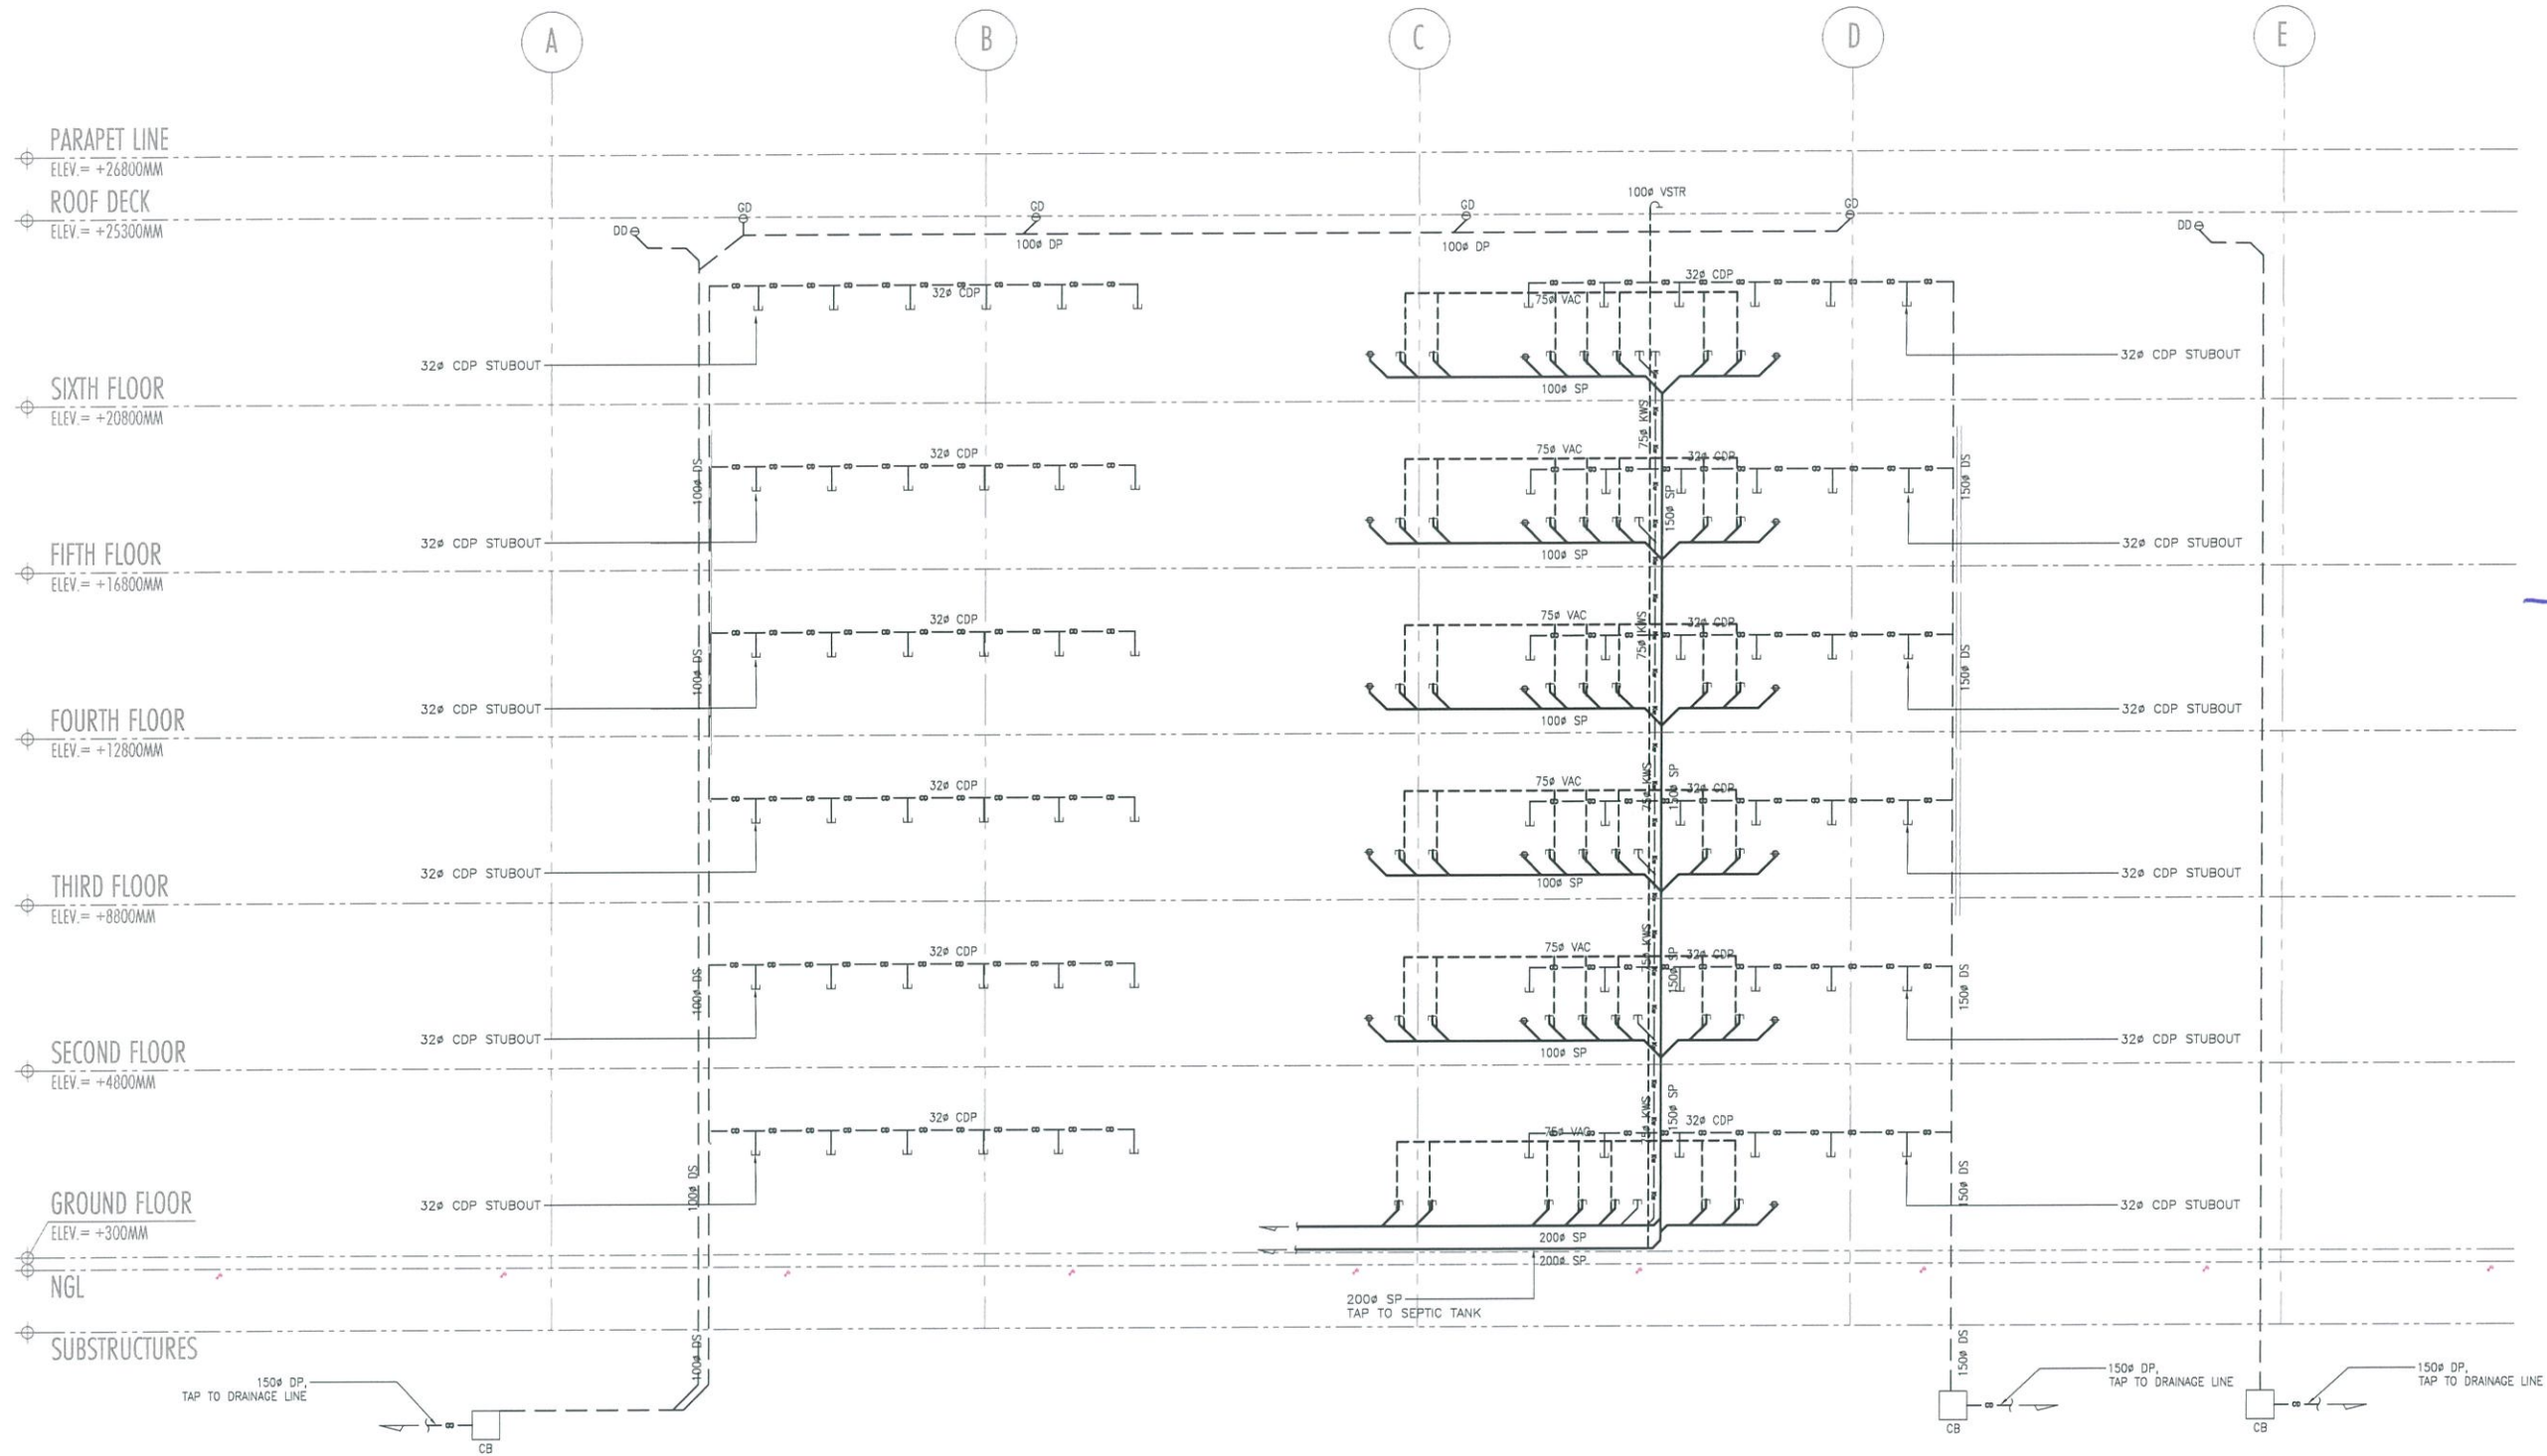

1

P-13

SOIL, WASTE, VENT, STORM AND CONDENSATE DRAIN
SCHEMATIC DIAGRAM
 SCALE: NTS



REPUBLIC OF THE PHILIPPINES
CIVIL AVIATION AUTHORITY OF THE PHILIPPINES
AERODROME DEVELOPMENT AND MANAGEMENT SERVICE
NAIA ROAD, PASAY CITY

THIS DRAWING AND DESIGN IS EXCLUSIVE
PROPERTIES OF CIVIL AVIATION AUTHORITY OF
THE PHILIPPINES AND SUCH MUST NOT BE
REPRODUCED, EXHIBITED, LOANED, NOR
COPIED IN PART OR IN WHOLE WITHOUT
PROPER PERMISSION AND/OR WRITTEN
CONSENT FROM THE DIRECTOR GENERAL CAAP.

AERODROME DEVELOPMENT
AND MANAGEMENT SERVICE

INFRASTRUCTURE DEVELOPMENT
AND DESIGN DIVISION

DESIGN STAFF:	INITIAL / DATE
DESIGNED BY:	IDDD
DRAWN BY:	IDDD
CHECKED BY:	
REVIEWED BY:	

RAUL R. CRUCENA
Division Chief III, IDDD-AED

ARNEL F. BORLADO
Department Manager III, AED-ADMS

LT COL VALENTINO A DIONELA PAF (RET)
Assistant Director General II, ADMS

CAPTAIN MANUEL ANTONIO L. TAMAYO
Director General



NOTES/REVISIONS:

PROJECT:
NEW CAAP BUILDING

LOCATION:
CAAP HEAD OFFICE
NAIA ROAD, PASAY CITY

SHEET CONTENTS:
• GROUND FLOOR PIPING
LAYOUT- WATER SUPPLY

DRAWING SCALE: AS SHOWN
SHEET NO: P-15

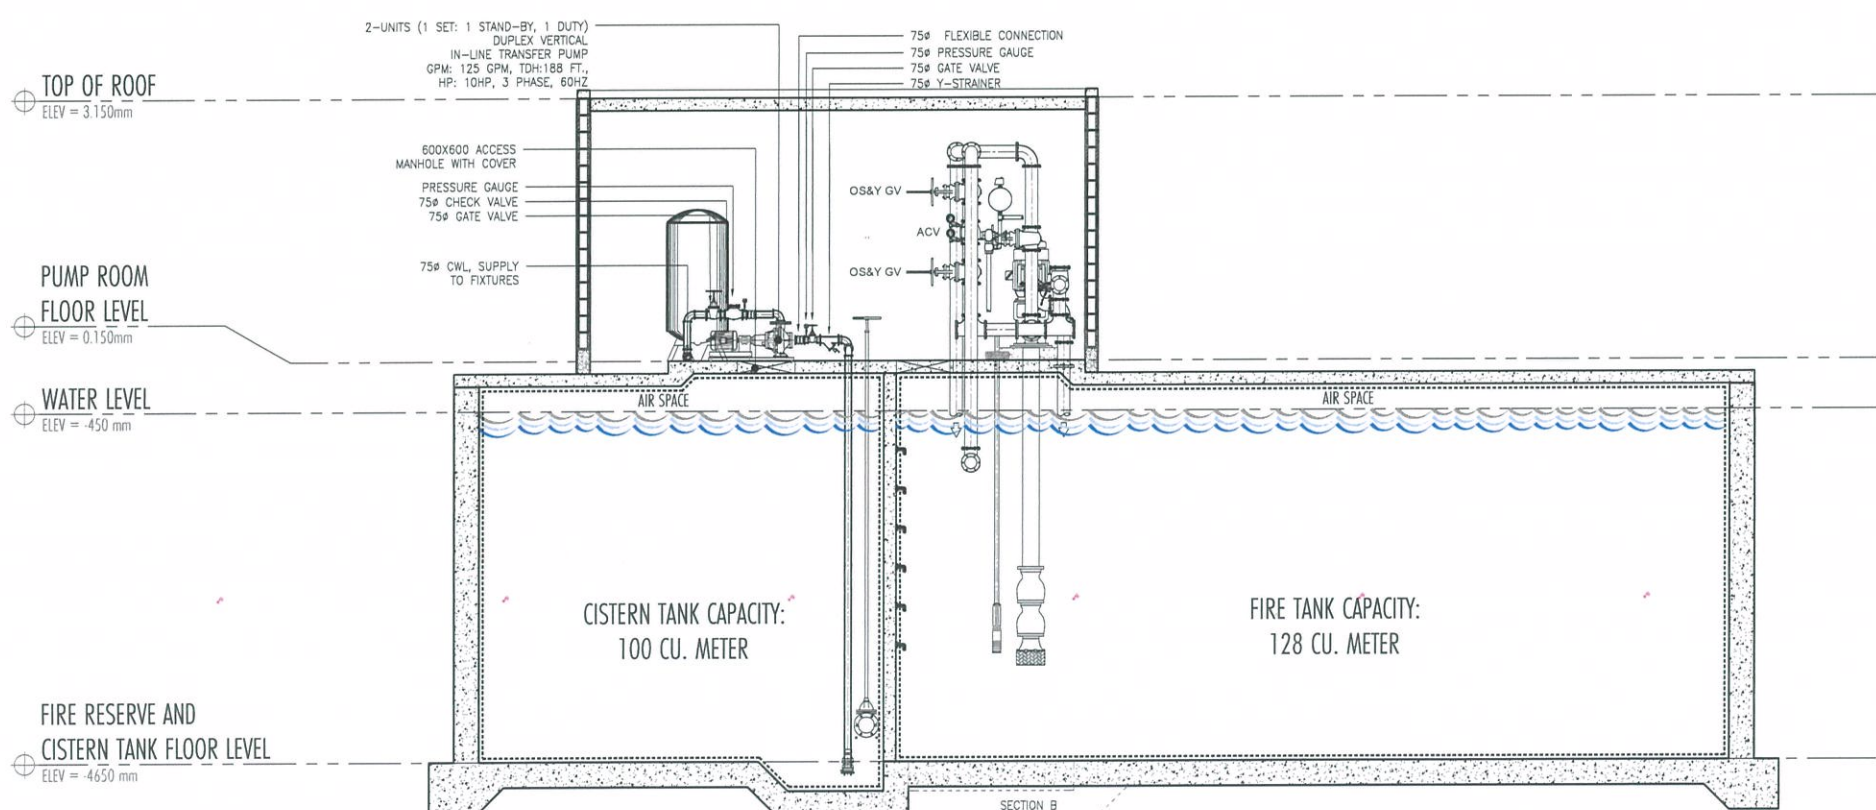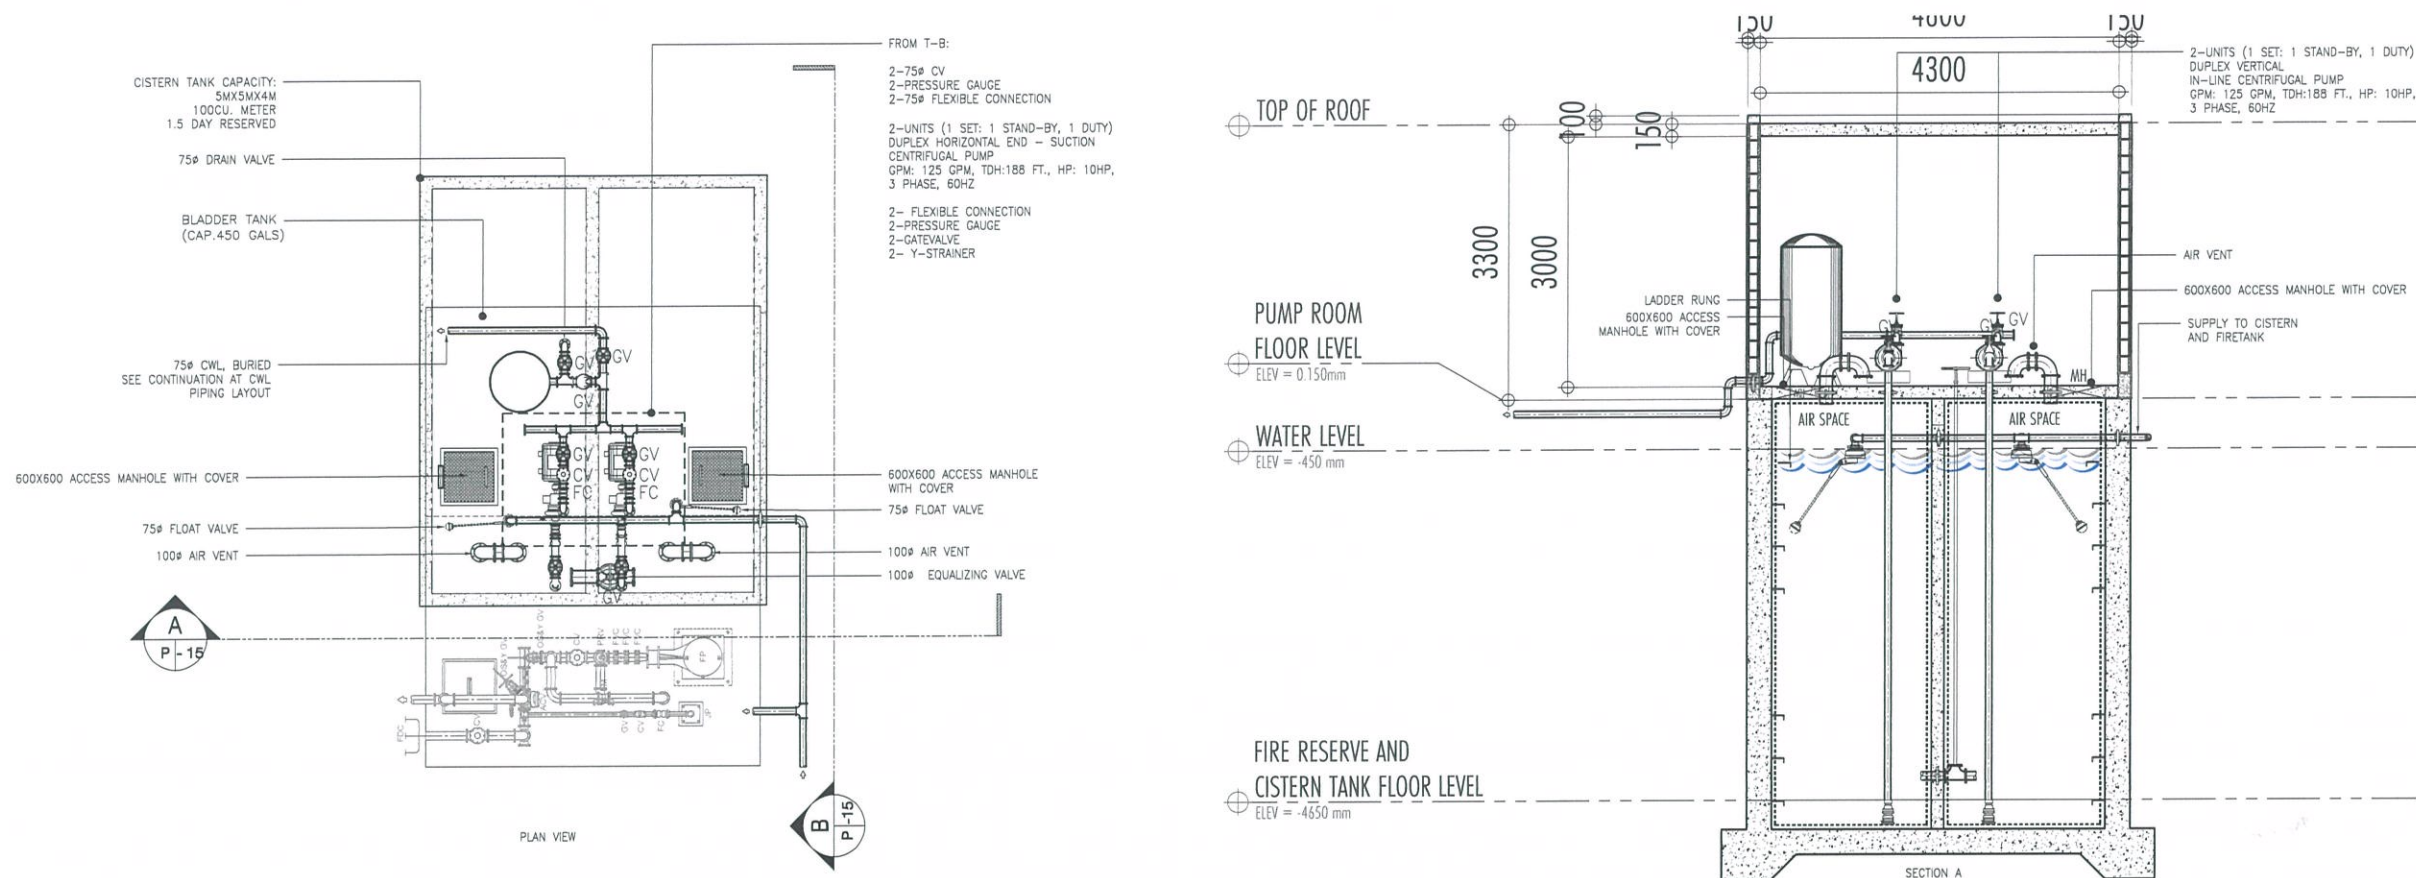

WATER SUPPLY
1
P-15
SCALE: 1:100 MTS
CISTERN TANK DETAILS AND PIPING LAYOUT


THIS DRAWING AND DESIGN IS EXCLUSIVE PROPERTIES OF CIVIL AVIATION AUTHORITY OF THE PHILIPPINES AND SUCH MUST NOT BE REPRODUCED, EXHIBITED, LOANED NOR COPIED IN PART OR IN WHOLE WITHOUT PROPER PERMISSION AND/OR WRITTEN CONSENT FROM THE DIRECTOR GENERAL CAAP.

AERODROME DEVELOPMENT AND MANAGEMENT SERVICE


INFRASTRUCTURE DEVELOPMENT AND DESIGN DIVISION

DESIGN STAFF:	INITIAL / DATE
DESIGNED BY:	IDDD
DRAWN BY:	IDDD
CHECKED BY:	

REVIEWED BY:


 RAUL R. CRUCENA
 Division Chief III, IDDD-AED


SUBMITTED BY:


 ARNEL F. BORLADO
 Department Manager III, AED-ADMS

RECOMMEND APPROVAL:


 LT COL VALENTINO A DIONELA PAF (RET)
 Assistant Director General II, ADMS

APPROVED BY:


 CAPTAIN MANUEL ANTONIO L. TAMAYO
 Director General

NOTES/REVISIONS:

PROJECT:

NEW CAAP BUILDING


LOCATION:

CAAP HEAD OFFICE
NAIA ROAD, PASAY CITY




SHEET CONTENTS:

- POWER CENTER AND PUMP ROOM'S STORMWATER PIPING LAYOUT


DRAWING SCALE:	SHEET NO:
AS SHOWN	P-16

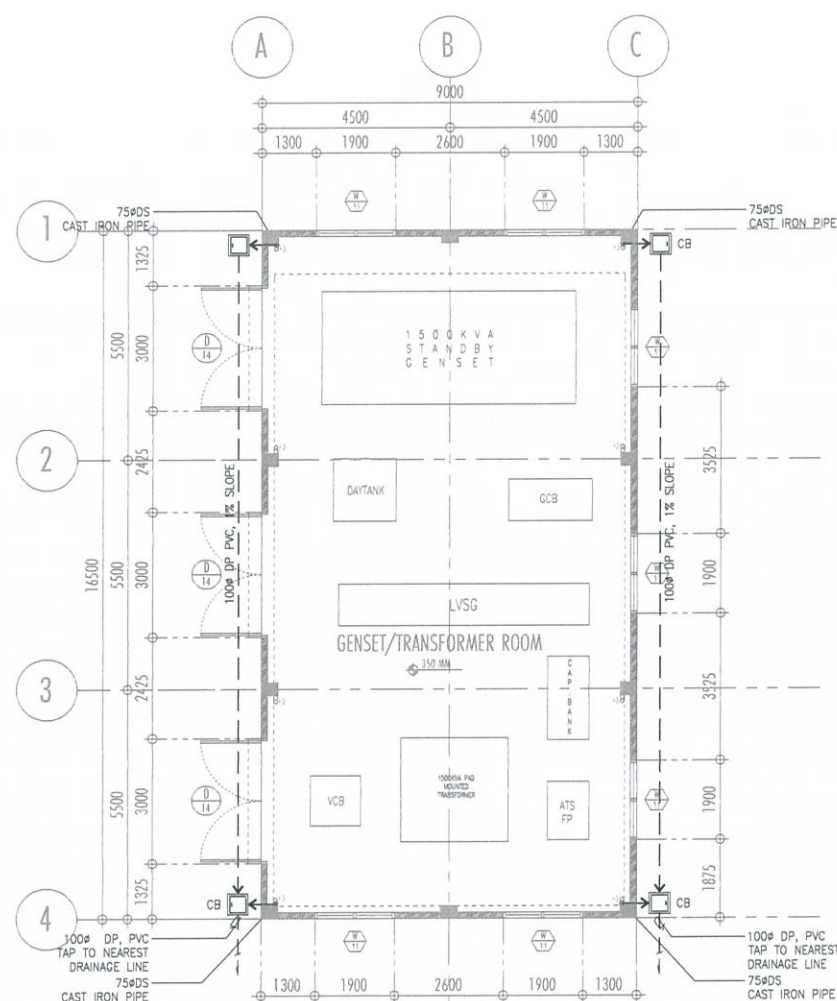


1 POWER CENTER STORMWATER PIPING LAYOUT
P-15 SCALE: 1:100 M/S

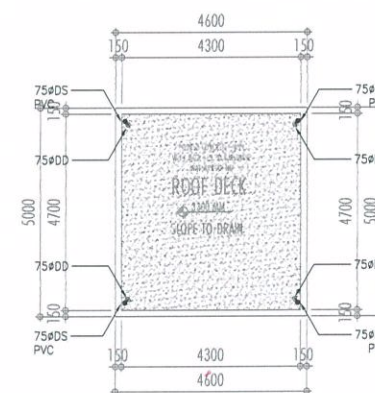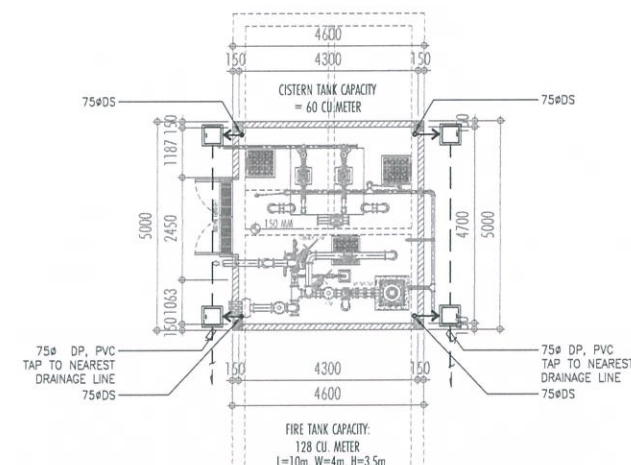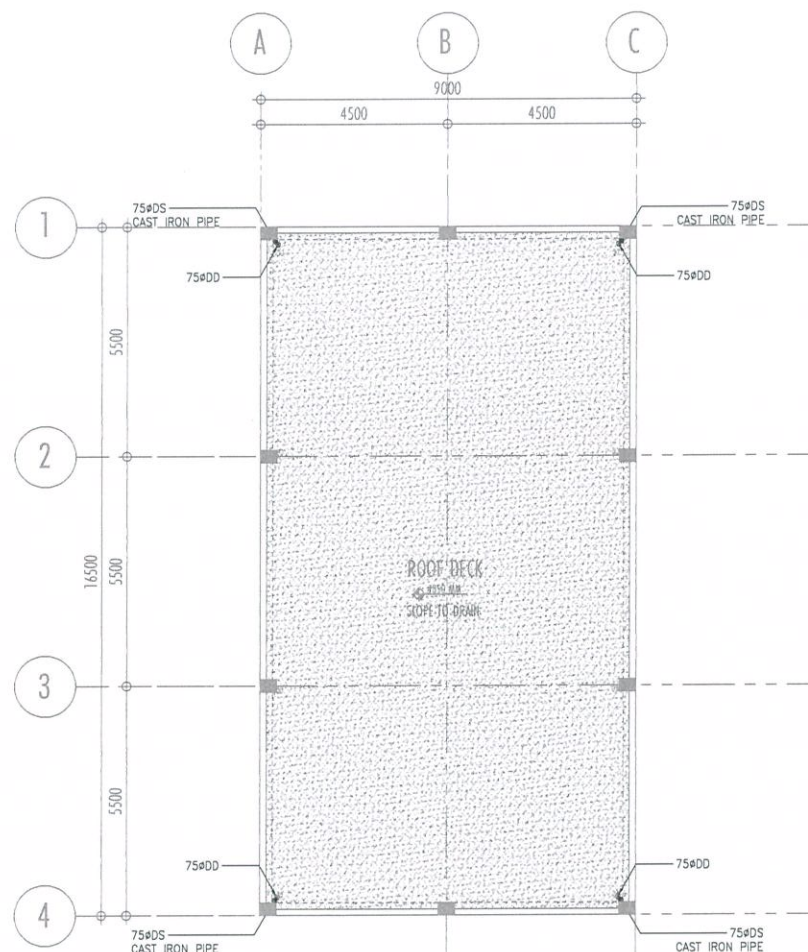

2 PUMP ROOM STORMWATER PIPING LAYOUT
P-16 SCALE: 1:100 M/S

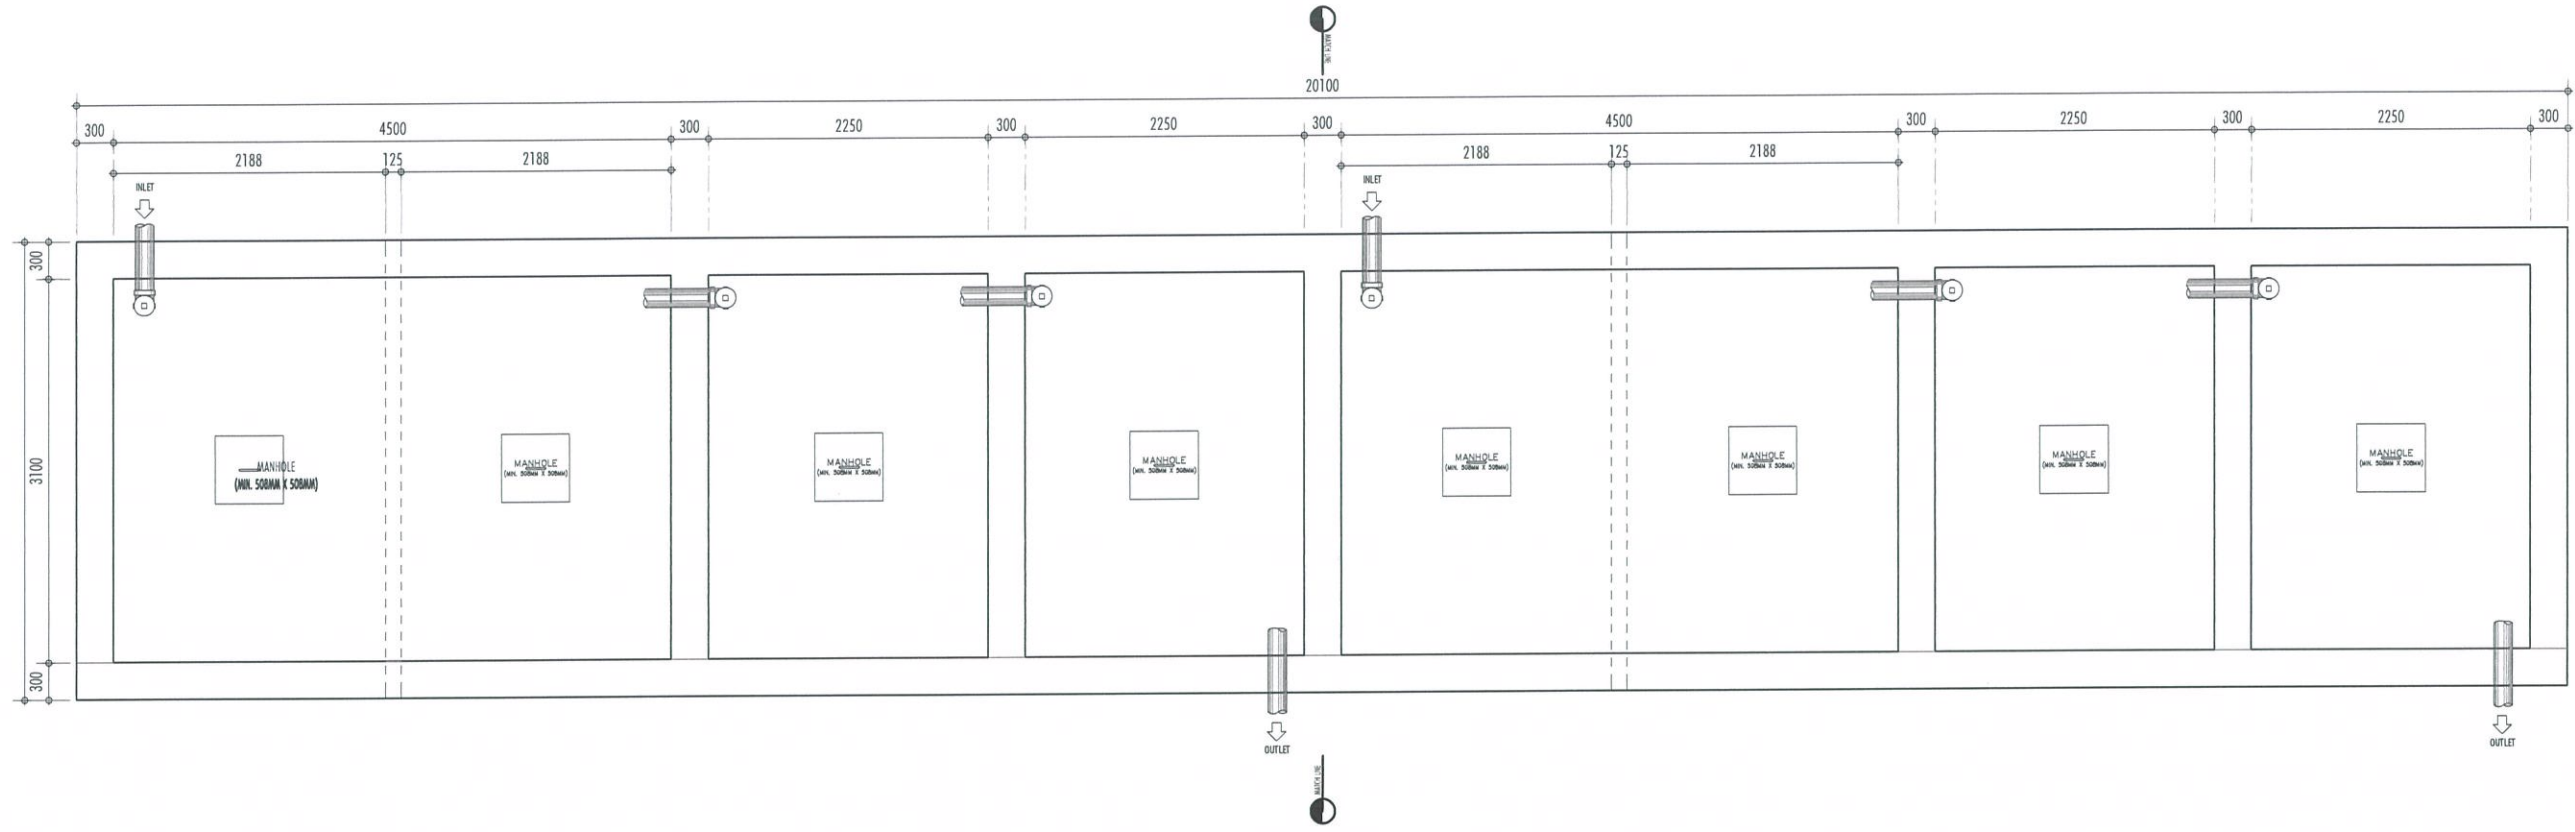

PLAN

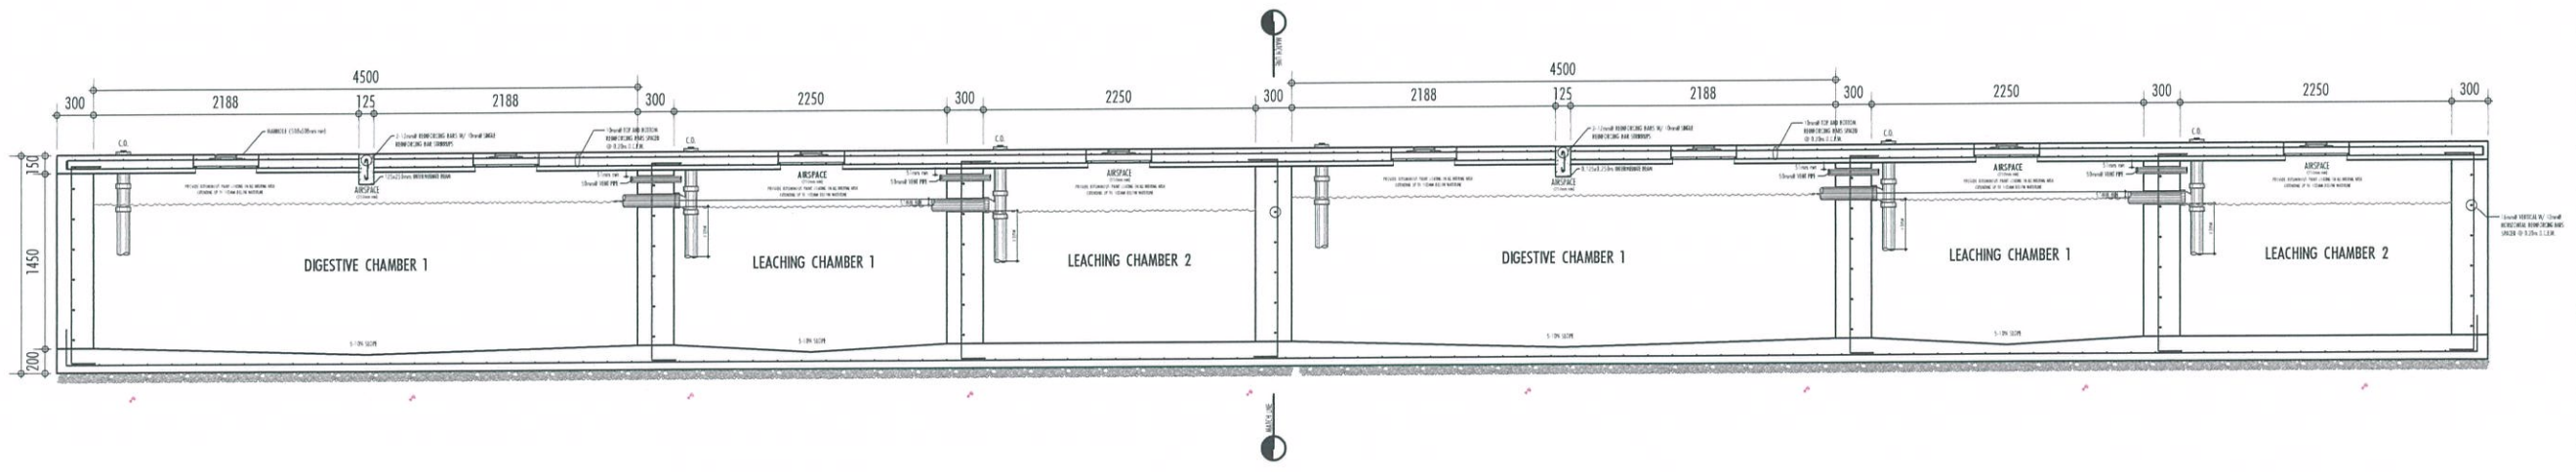

SECTION

1
P-17 SCALE: NTS
SEPTIC TANK DETAILS

THIS DRAWING AND DESIGN IS EXCLUSIVE PROPERTY OF CIVIL AVIATION AUTHORITY OF THE PHILIPPINES AND SUCH MUST NOT BE REPRODUCED, EXHIBITED, LOANED NOR COPIED IN PART OR IN WHOLE WITHOUT PROPER PERMISSION AND/OR WRITTEN CONSENT FROM THE DIRECTOR GENERAL CAAP.

AERODROME DEVELOPMENT AND MANAGEMENT SERVICE


INFRASTRUCTURE DEVELOPMENT AND DESIGN DIVISION

DESIGN STAFF:	INITIAL / DATE
DESIGNED BY:	IDDD
DRAWN BY:	IDDD
CHECKED BY:	

REVIEWED BY:


 RAUL R. CRUCENA
 Division Chief III, IDDD-AED

SUBMITTED BY:


 ARNEL F. BORLADO
 Department Manager III, AED-ADMS

RECOMMEND APPROVAL:


 LT COL VALENTINO A. DIONELA PAF (RET)
 Assistant Director General II, ADMS

APPROVED BY:


 CAPTAIN MANUEL ANTONIO L. TAMAYO
 Director General

NOTES/REVISIONS:

PROJECT:

NEW CAAP BUILDING

LOCATION:

CAAP HEAD OFFICE
NAIA ROAD, PASAY CITY

SHEET CONTENTS:

- SEPTIC TANK DETAILS

DRAWING SCALE:	SHEET NO:
AS SHOWN	P-17



REPUBLIC OF THE PHILIPPINES
CIVIL AVIATION AUTHORITY OF THE PHILIPPINES
AERODROME DEVELOPMENT AND MANAGEMENT SERVICE
NAIA ROAD, 1305 PASAY CITY

THIS DRAWING AND DESIGN IS EXCLUSIVE
PROPERTY OF CIVIL AVIATION AUTHORITY OF
THE PHILIPPINES AND SUCH MUST NOT BE
REPRODUCED, EXHIBITED, LOANED NOR
COPIED IN PART OR IN WHOLE WITHOUT
PROPER PERMISSION AND/OR WRITTEN
CONSENT FROM THE DIRECTOR GENERAL CAAP.

AERODROME DEVELOPMENT
AND MANAGEMENT SERVICE

INFRASTRUCTURE DEVELOPMENT
AND DESIGN DIVISION

DESIGN STAFF:	INITIAL / DATE
DESIGNED BY:	IDDD
DRAWN BY:	IDDD
CHECKED BY:	

REVIEWED BY:

RAUL R. CRUCENA
Division Chief III, IDDD-AED

SUBMITTED BY:

ARNEL F. BORLADO
Department Manager III, AED-ADMS

RECOMMEND APPROVAL:

LT COL VALENTINO A DIONELA PAF (RET)
Assistant Director General II, ADMS

APPROVED BY:

CAPTAIN MANUEL ANTONIO L. TAMAYO
Director General

NOTES/REVISIONS:

PROJECT:


NEW CAAP BUILDING

LOCATION:


CAAP HEAD OFFICE
NAIA ROAD, PASAY CITY

SHEET CONTENTS:
• SEPTIC TANK DETAILS (PLAN) - I

DRAWING SCALE:	SHEET NO:
AS SHOWN	P-18

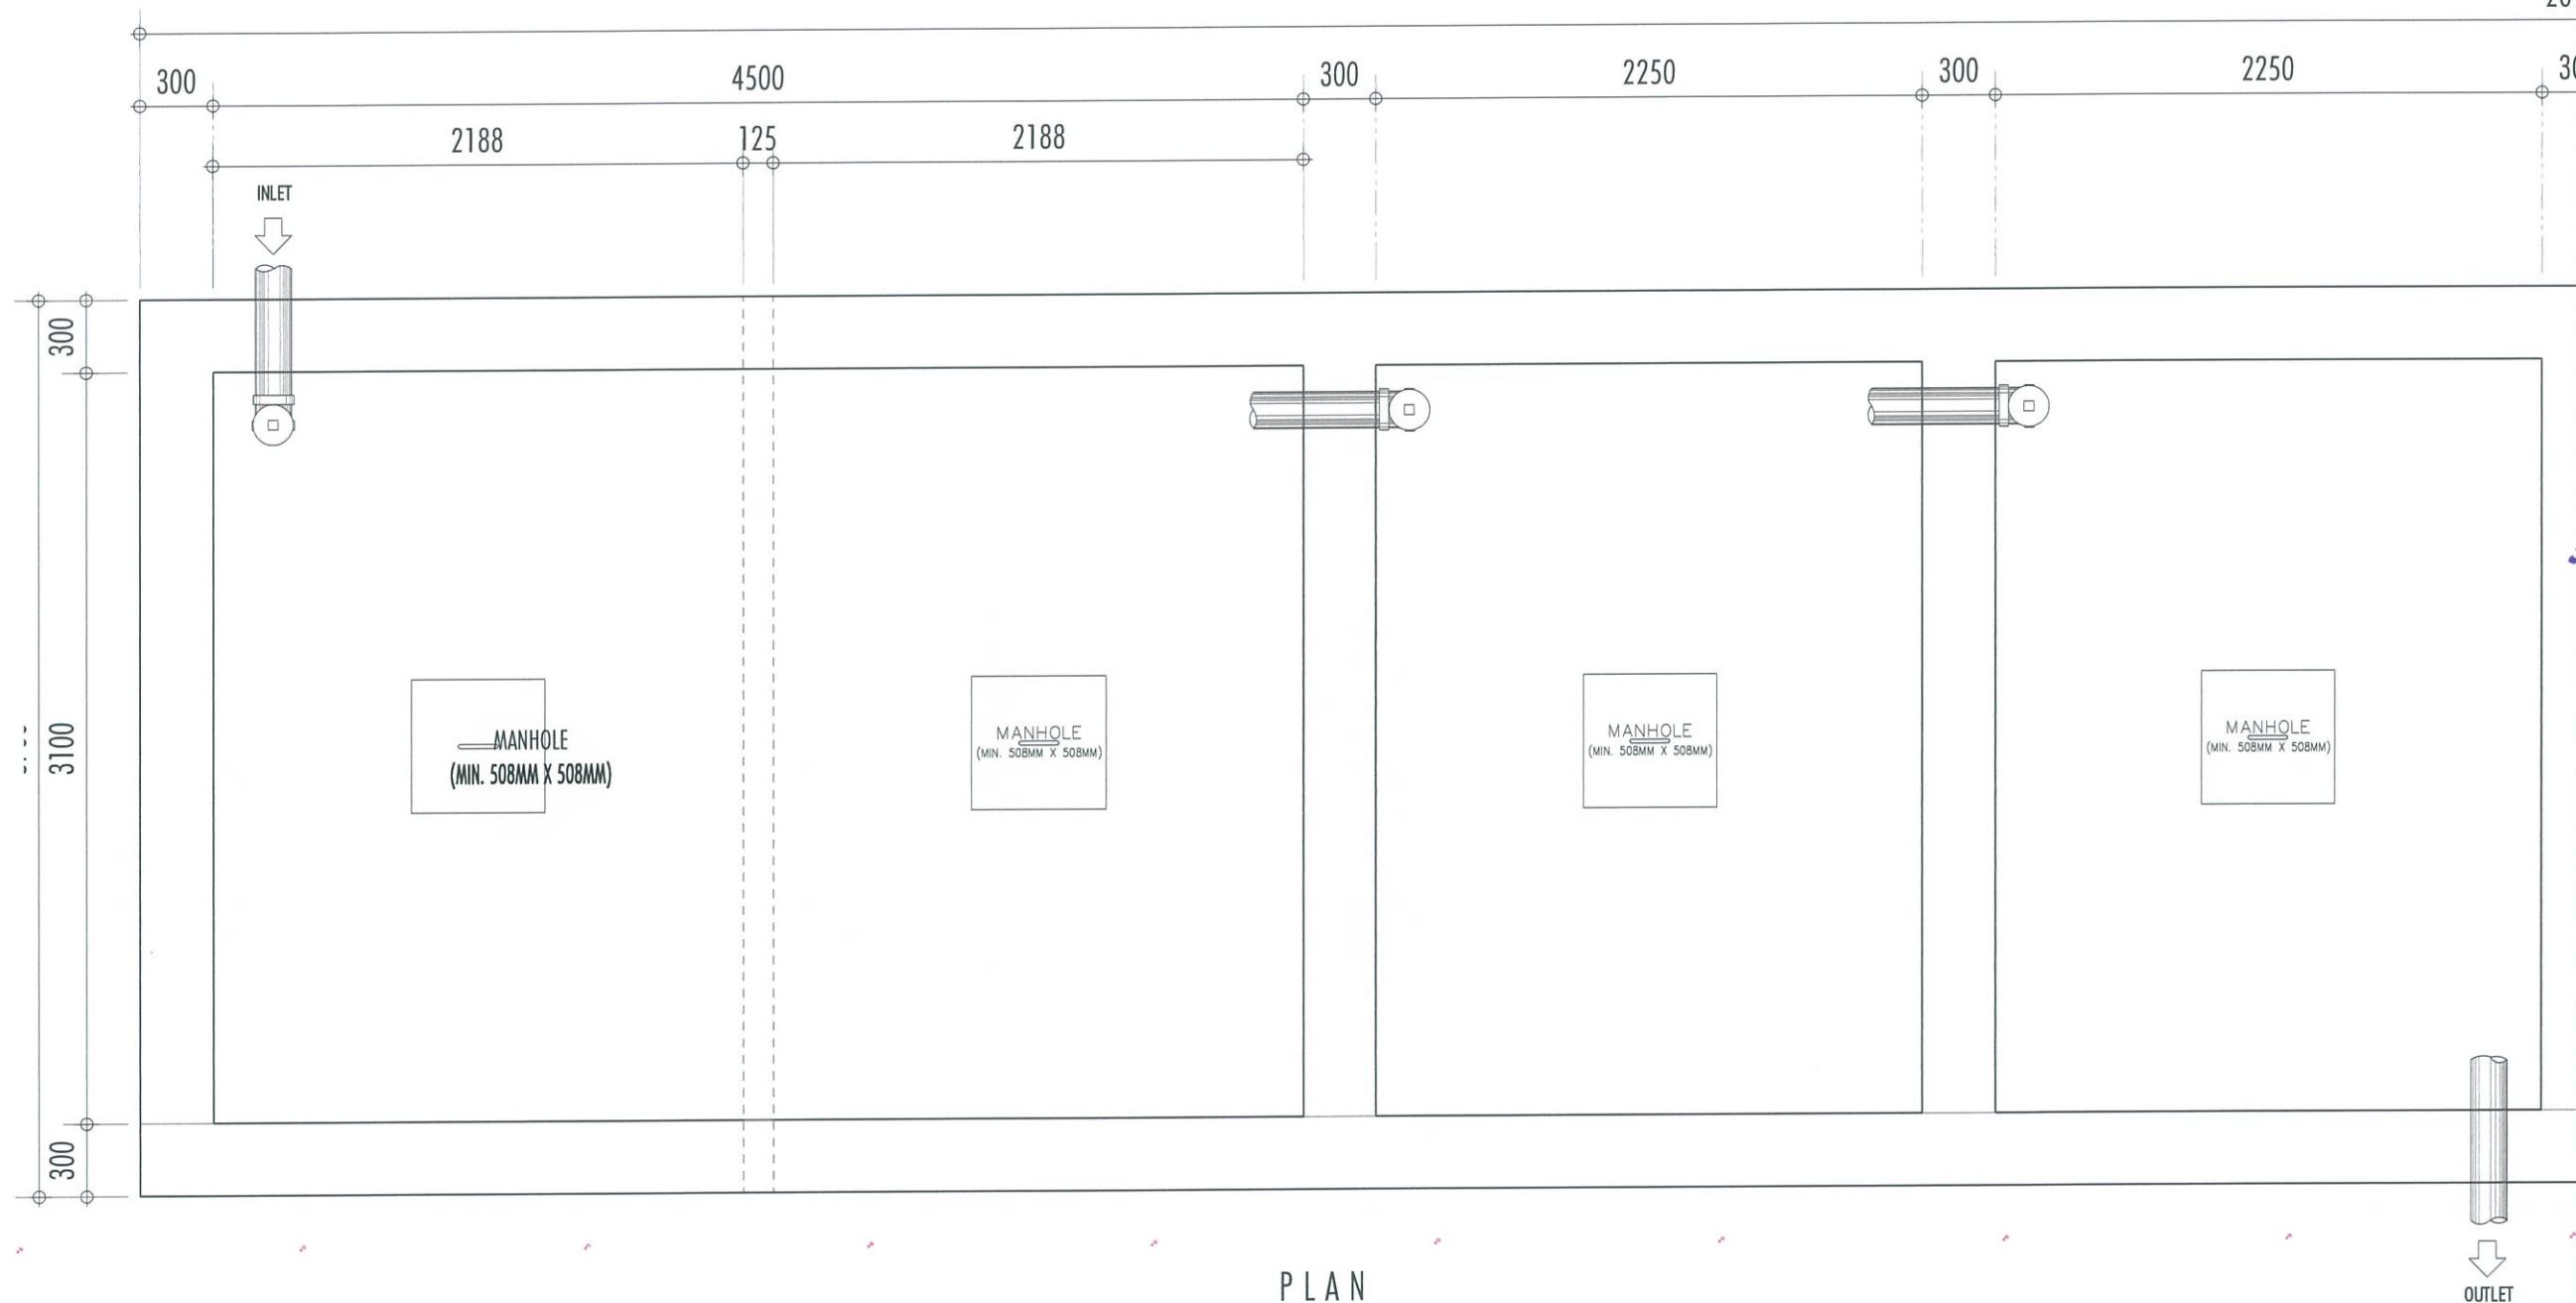

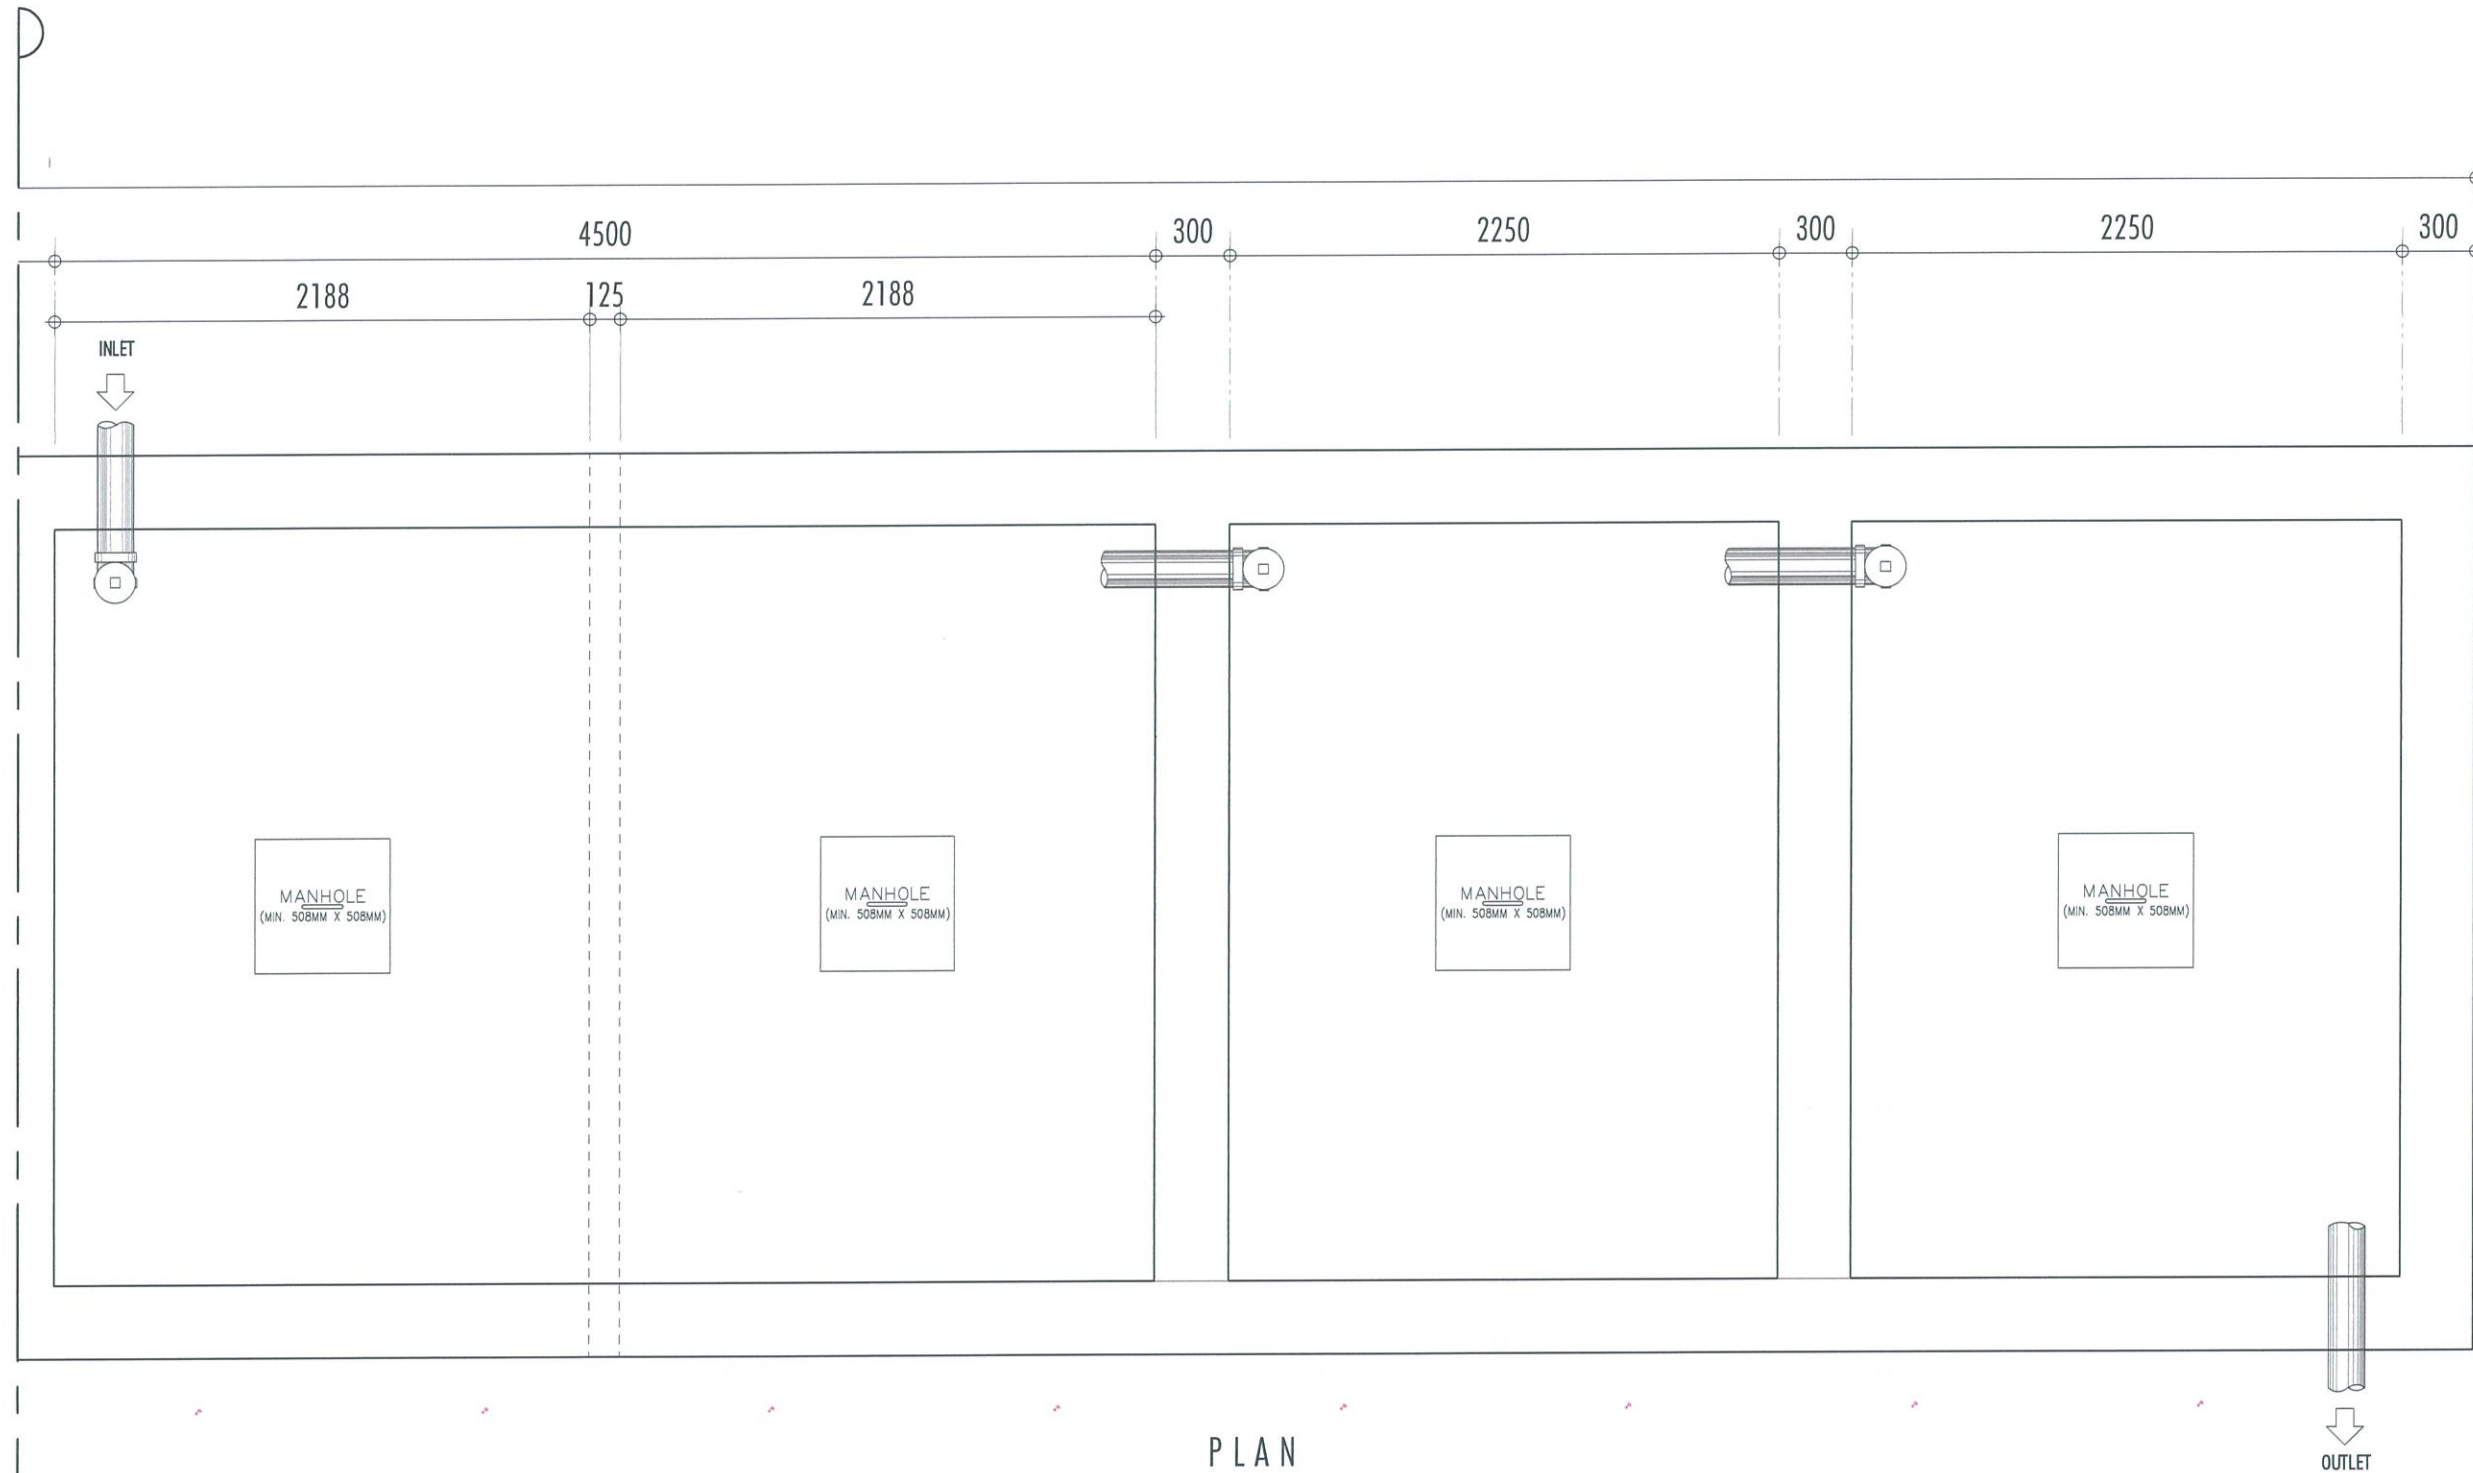

1
P-18 SCALE: NTS
SEPTIC TANK DETAILS (PLAN) - I



1
P-19
SCALE: NTS

SEPTIC TANK DETAILS (PLAN) - II



REPUBLIC OF THE PHILIPPINES
CIVIL AVIATION AUTHORITY OF THE PHILIPPINES
AERODROME DEVELOPMENT AND MANAGEMENT SERVICE
NAIA ROAD, 1300 PASAY CITY


THIS DRAWING AND DESIGN IS EXCLUSIVE PROPERTIES OF CIVIL AVIATION AUTHORITY OF THE PHILIPPINES AND SUCH MUST NOT BE REPRODUCED, EXHIBITED, LOANED, NOR COPIED IN PART OR IN WHOLE WITHOUT PROPER PERMISSION AND/OR WRITTEN CONSENT FROM THE DIRECTOR GENERAL CAAP.

AERODROME DEVELOPMENT AND MANAGEMENT SERVICE


INFRASTRUCTURE DEVELOPMENT AND DESIGN DIVISION

DESIGN STAFF:	INITIAL / DATE
DESIGNED BY:	IDDD
DRAWN BY:	IDDD
CHECKED BY:	


REVIEWED BY:


RAUL R. CRUCENA
Division Chief II, IDDD-AED


SUBMITTED BY:


ARNEL F. BORLADO
Department Manager III, AED-ADMS

RECOMMEND APPROVAL:


LT COL. VALENTINO A. DIONELA PAF (RET)
Assistant Director General II, ADMS

APPROVED BY:


CAPTAIN MANUEL ANTONIO L. TAMAYO
Director General

NOTES/REVISIONS:

PROJECT:

NEW CAAP BUILDING

LOCATION:

CAAP HEAD OFFICE
NAIA ROAD, PASAY CITY

SHEET CONTENTS:

- SEPTIC TANK DETAILS (PLAN) - II

DRAWING SCALE:	SHEET NO:
AS SHOWN	P-19

THIS DRAWING AND DESIGN IS EXCLUSIVE
PROPERTIES OF CIVIL AVIATION AUTHORITY OF
THE PHILIPPINES AND SUCH MUST NOT BE
REPRODUCED, EXHIBITED, LOANED NOR
COPIED IN PART OR IN WHOLE WITHOUT
PROPER PERMISSION AND/OR WRITTEN
CONSENT FROM THE DIRECTOR GENERAL CAAP.

AERODROME DEVELOPMENT
AND MANAGEMENT SERVICE

INFRASTRUCTURE DEVELOPMENT
AND DESIGN DIVISION

DESIGN STAFF:	INITIAL / DATE
DESIGNED BY:	IDDD
DRAWN BY:	IDDD
CHECKED BY:	

REVIEWED BY:

RAUL R. CRUCENA
Division Chief III, IDDD-AED

SUBMITTED BY:

ARNEL F. BORLADO
Department Manager III, AED-ADMS

RECOMMEND APPROVAL:

LT COL VALENTINO A DIONELA PAF (RET)
Assistant Director General II, ADMS

APPROVED BY:

CAPTAIN MANUEL ANTONIO L. TAMAYO
Director General

NOTES/REVISIONS:

PROJECT:


NEW CAAP BUILDING

LOCATION:

CAAP HEAD OFFICE
NAIA ROAD, PASAY CITY

SHEET CONTENTS:
• SEPTIC TANK DETAILS (SECTION)
- I

DRAWING SCALE:	SHEET NO:
AS SHOWN	P-20

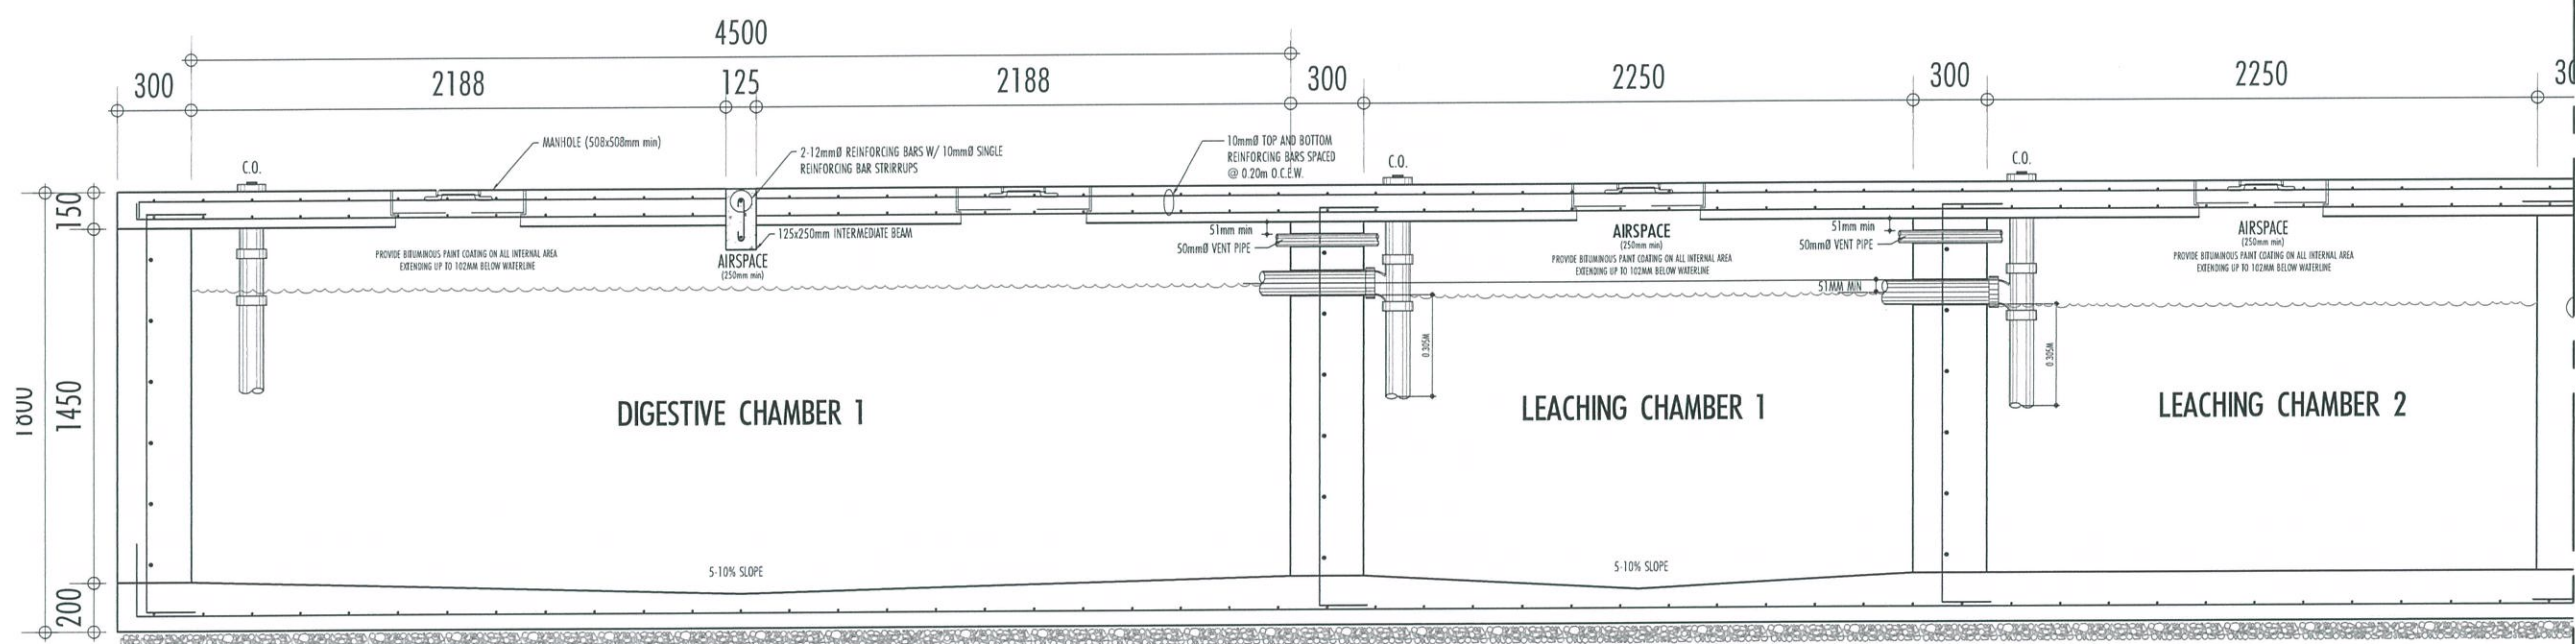

SECTION

1
P-20
SCALE: NTS
SEPTIC TANK DETAILS (SECTION) - I

THIS DRAWING AND DESIGN IS EXCLUSIVE PROPERTIES OF CIVIL AVIATION AUTHORITY OF THE PHILIPPINES AND SUCH MUST NOT BE REPRODUCED, EXHIBITED, LOANED NOR COPIED IN PART OR IN WHOLE WITHOUT PROPER PERMISSION AND/OR WRITTEN CONSENT FROM THE DIRECTOR GENERAL CAAP.

AERODROME DEVELOPMENT
AND MANAGEMENT SERVICE

INFRASTRUCTURE DEVELOPMENT
AND DESIGN DIVISION

DESIGN STAFF:	INITIAL / DATE
DESIGNED BY:	IDDD
DRAWN BY:	IDDD
CHECKED BY:	

REVIEWED BY:

RAUL R. CRUCENA
Division Chief III, IDDD-AED

SUBMITTED BY:

ARNEL F. BORLADO
Department Manager III, AED-ADMS

RECOMMEND APPROVAL:

LT COL VALENTINO A DIONELA PAF (RET)
Assistant Director General II, ADMS

APPROVED BY:

CAPTAIN MANUEL ANTONIO L. TAMAYO
Director General

NOTES/REVISIONS:

PROJECT:

NEW CAAP BUILDING

LOCATION:

CAAP HEAD OFFICE
NAIA ROAD, PASAY CITY

SHEET CONTENTS:


• SEPTIC TANK DETAILS (SECTION)
- II

DRAWING SCALE:

AS SHOWN

SHEET NO:


P-21

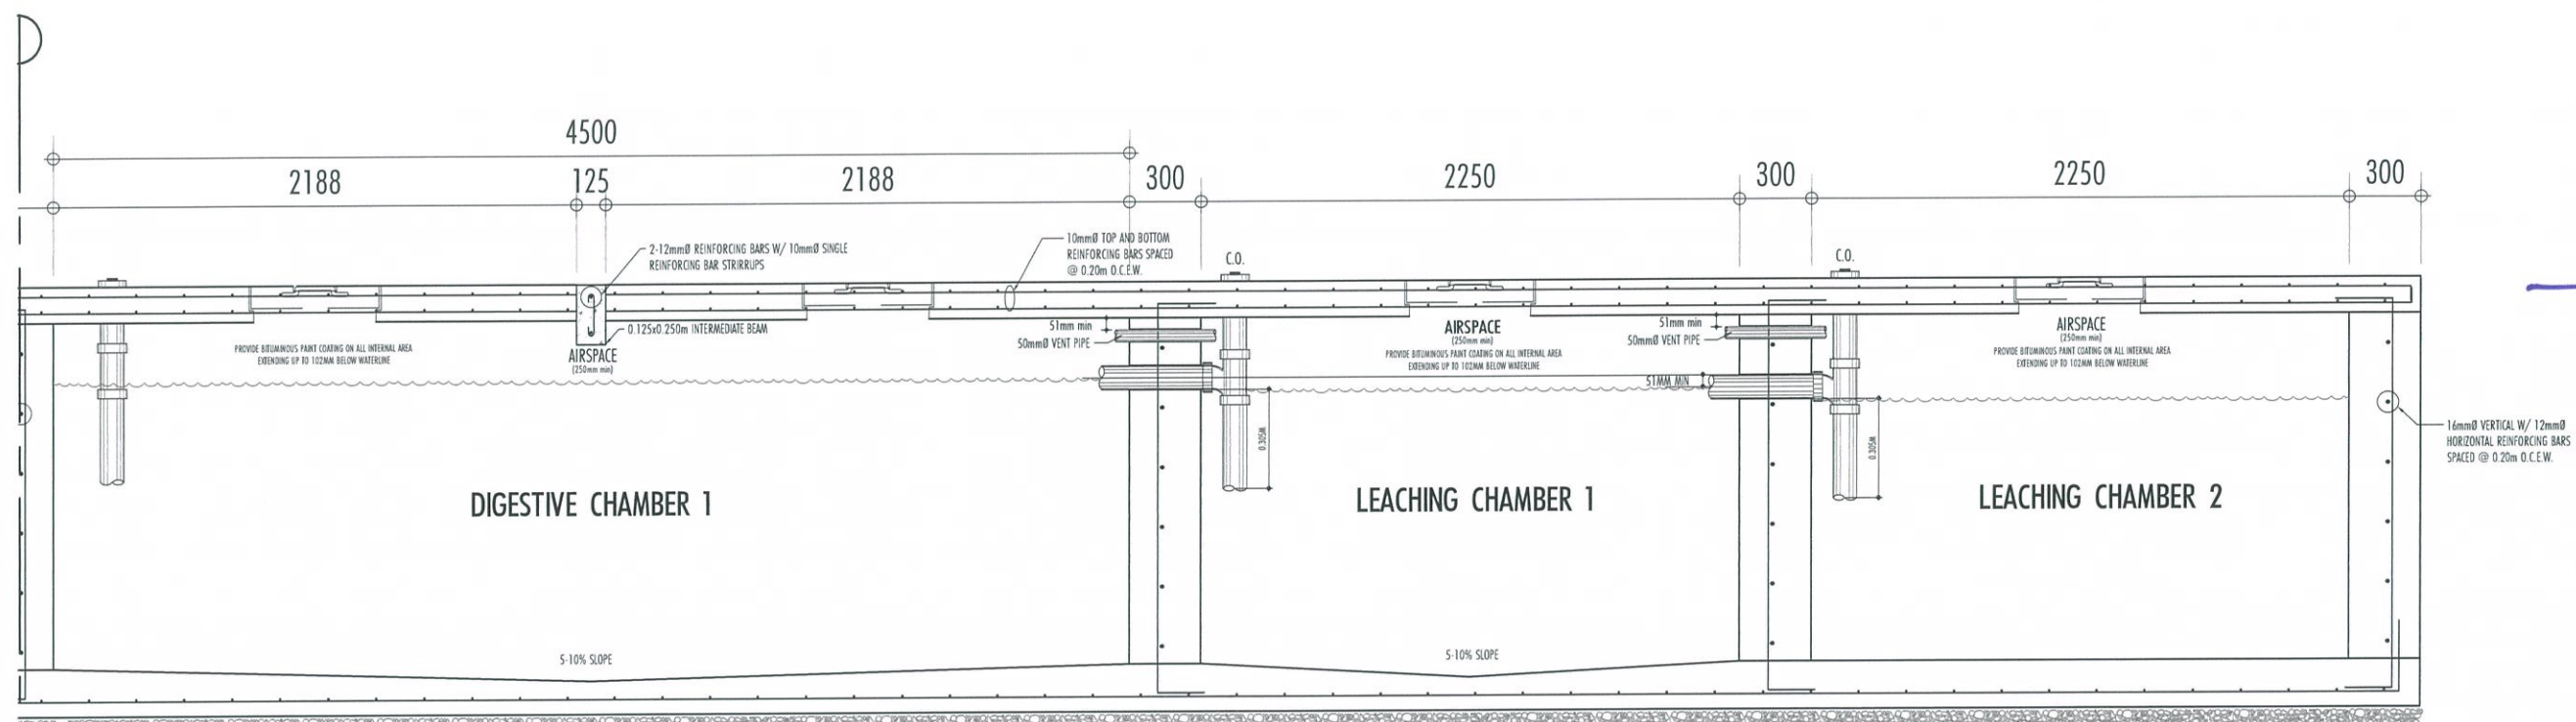


SECTION

1
P-21
SCALE: NTS


SEPTIC TANK DETAILS (SECTION) - II

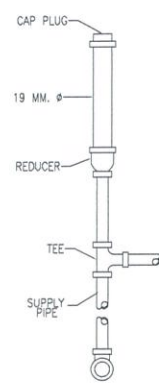


1 AIR CHAMBER DETAIL
P-18 SCALE: NTS

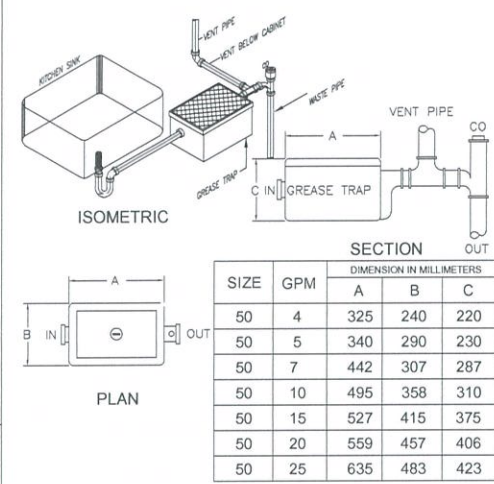


2 GREASE TRAP DETAIL
P-18 SCALE: NTS

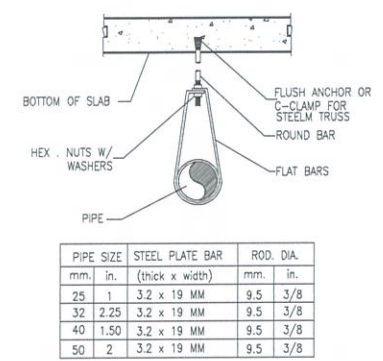


3 ADJUSTABLE TYPE HANGER DETAIL
P-18 SCALE: NTS

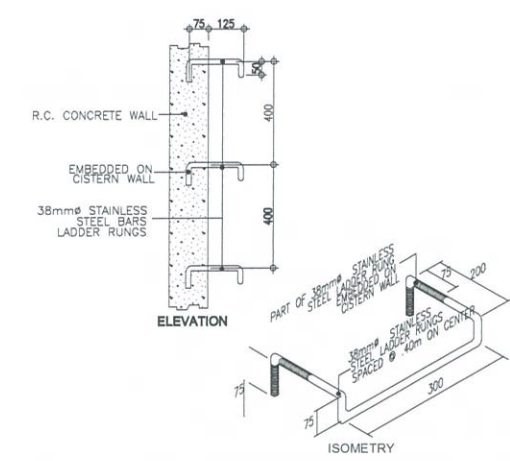


4 TYPICAL LADDER RUNG DETAIL
P-18 SCALE: NTS

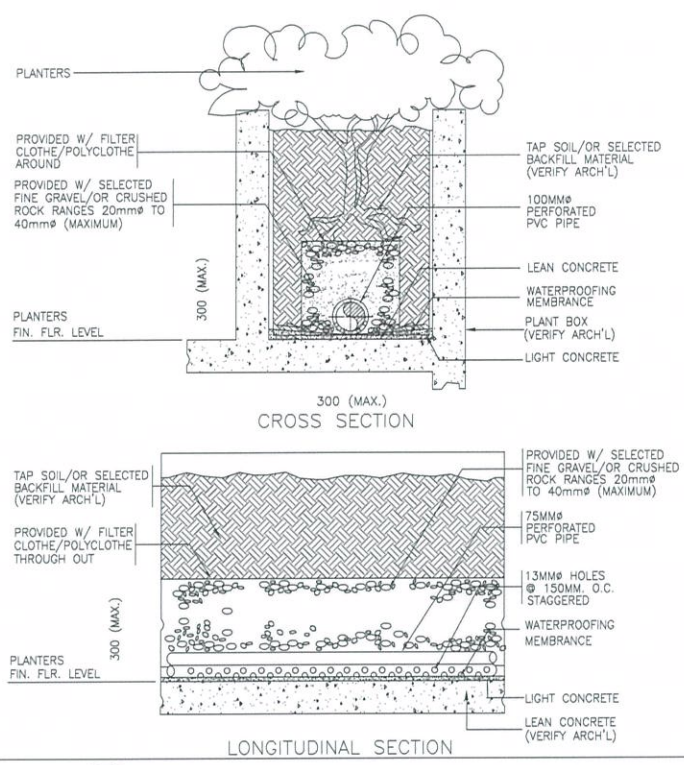


5 PERFORATED PIPE ON PLANTER'S BOX DETAIL
P-18 SCALE: NTS

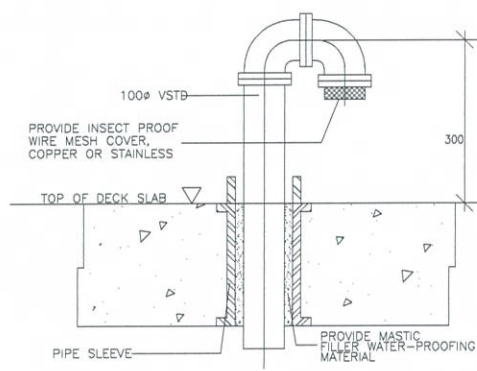


6 VENT STACK THRU ROOF DETAIL
P-18 SCALE: NTS

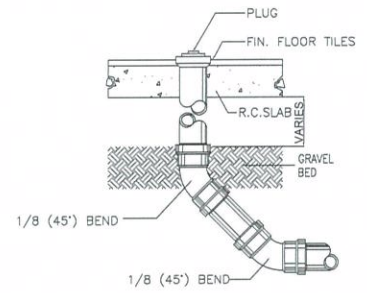


7 FLOOR CLEAN-OUT DETAIL
P-18 SCALE: NTS

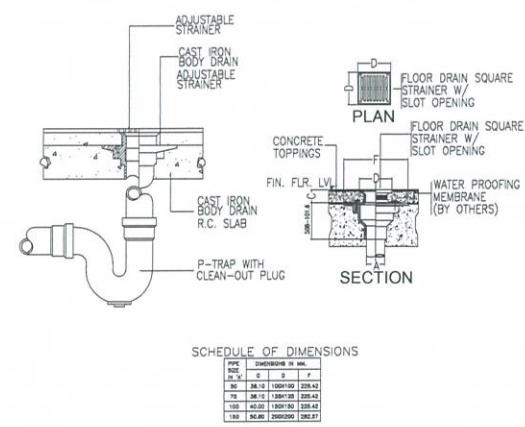


8 FLOOR DRAIN DETAIL
P-18 SCALE: NTS

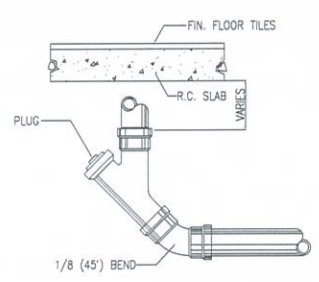


9 CEILING CLEAN-OUT DETAIL
P-18 SCALE: NTS

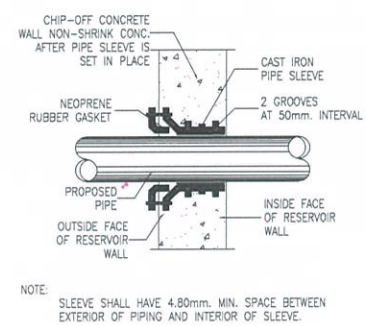

10 PIPE SLEEVE DETAIL
P-18 SCALE: NTS

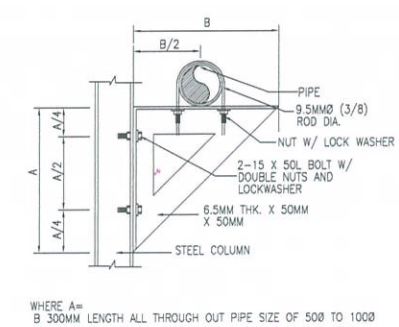

11 WALL PIPE HANGER DETAIL
P-18 SCALE: NTS

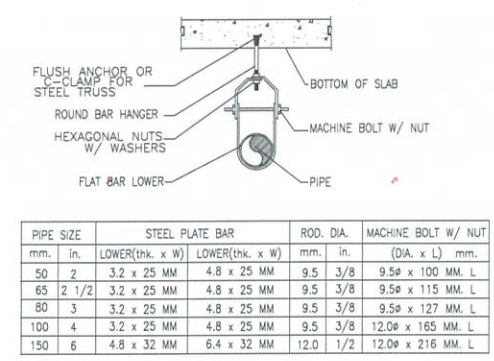

12 ADJUSTABLE TYPE CLEVIS HANGER DETAIL
P-18 SCALE: NTS

CAA
BAGONG PILIPINAS
REPUBLIC OF THE PHILIPPINES
CIVIL AVIATION AUTHORITY OF THE PHILIPPINES
AERODROME DEVELOPMENT AND MANAGEMENT SERVICE
NAIA ROAD, 1300 PASAY CITY

THIS DRAWING AND DESIGN IS EXCLUSIVE PROPERTIES OF CIVIL AVIATION AUTHORITY OF THE PHILIPPINES AND SUCH MUST NOT BE REPRODUCED, EXHIBITED, LOANED NOR COPIED IN PART OR IN WHOLE WITHOUT PROPER PERMISSION AND/OR WRITTEN CONSENT FROM THE DIRECTOR GENERAL CAA.

AERODROME DEVELOPMENT AND MANAGEMENT SERVICE

INFRASTRUCTURE DEVELOPMENT AND DESIGN DIVISION

DESIGN STAFF:	INITIAL / DATE
DESIGNED BY:	IDDD
DRAWN BY:	IDDD
CHECKED BY:	

REVIEWED BY:

RAUL R. CRUCENA
 Division Chief III, IDDD-AED

SUBMITTED BY:

ARNEL F. BORLADO
 Department Manager III, AED-ADMS

RECOMMEND APPROVAL:

LT COL. VALENTINO A. DIONELA PAF (RET)
 Assistant Director General II, ADMS

APPROVED BY:

CAPTAIN MANUEL ANTONIO L. TAMAYO
 Director General

NOTES/REVISIONS:

PROJECT:

NEW CAA BUILDING

LOCATION:

**CAA HEAD OFFICE
NAIA ROAD, PASAY CITY**

SHEET CONTENTS:

• MISCELLANEOUS DETAILS

DRAWING SCALE:	SHEET NO:
AS SHOWN	P-18